




1 UNDER RAMP PLAN
SCALE: 1/4" = 1'-0"

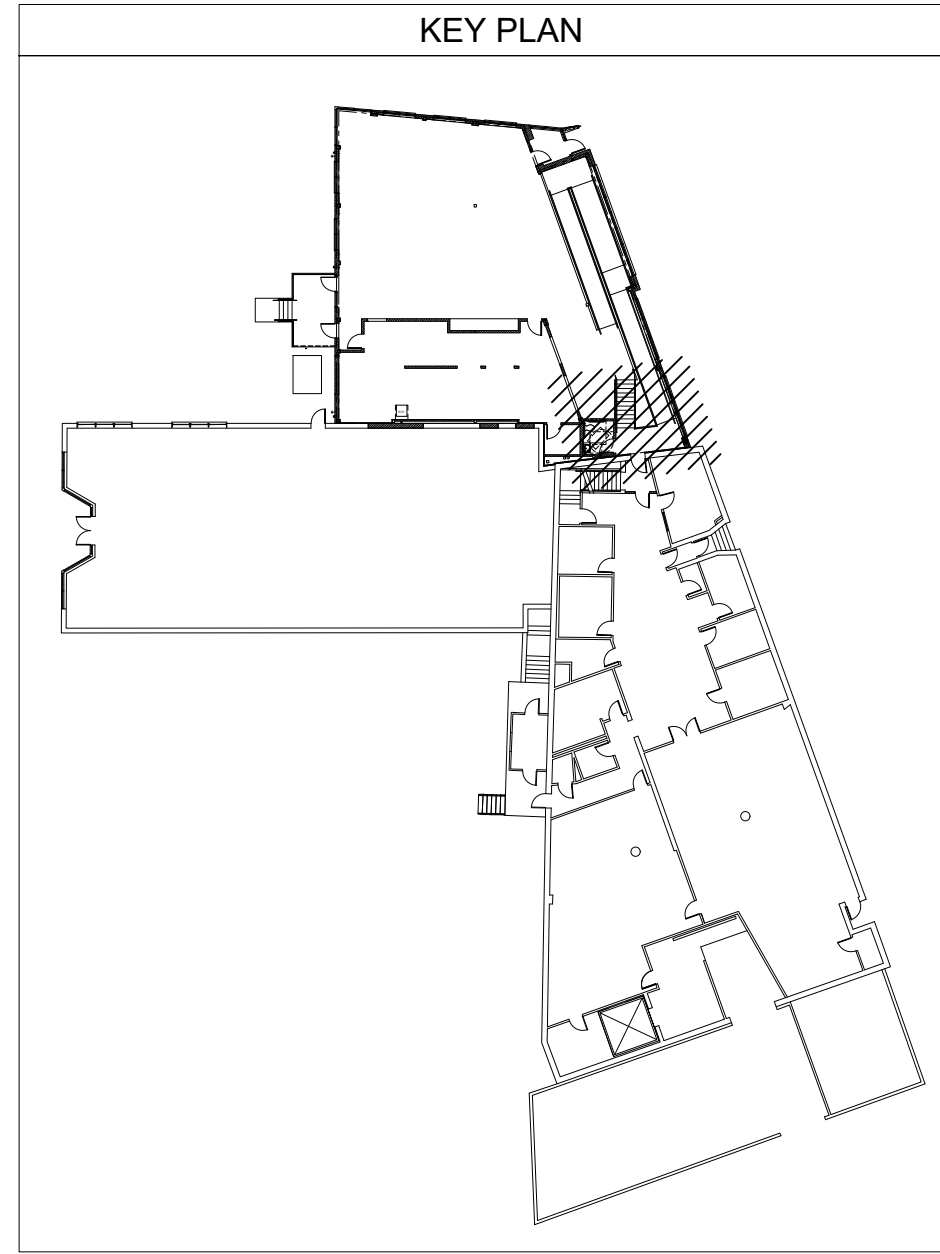


NOTE:
1. PROVIDE NEW EQUIPMENT PAD AT NEW WATER HEATER IN BOILER ROOM. REFER TO MECHANICAL PLANS FOR LOCATION. SEE DETAIL 3/A504 FOR EQUIPMENT PAD CONSTRUCTION.

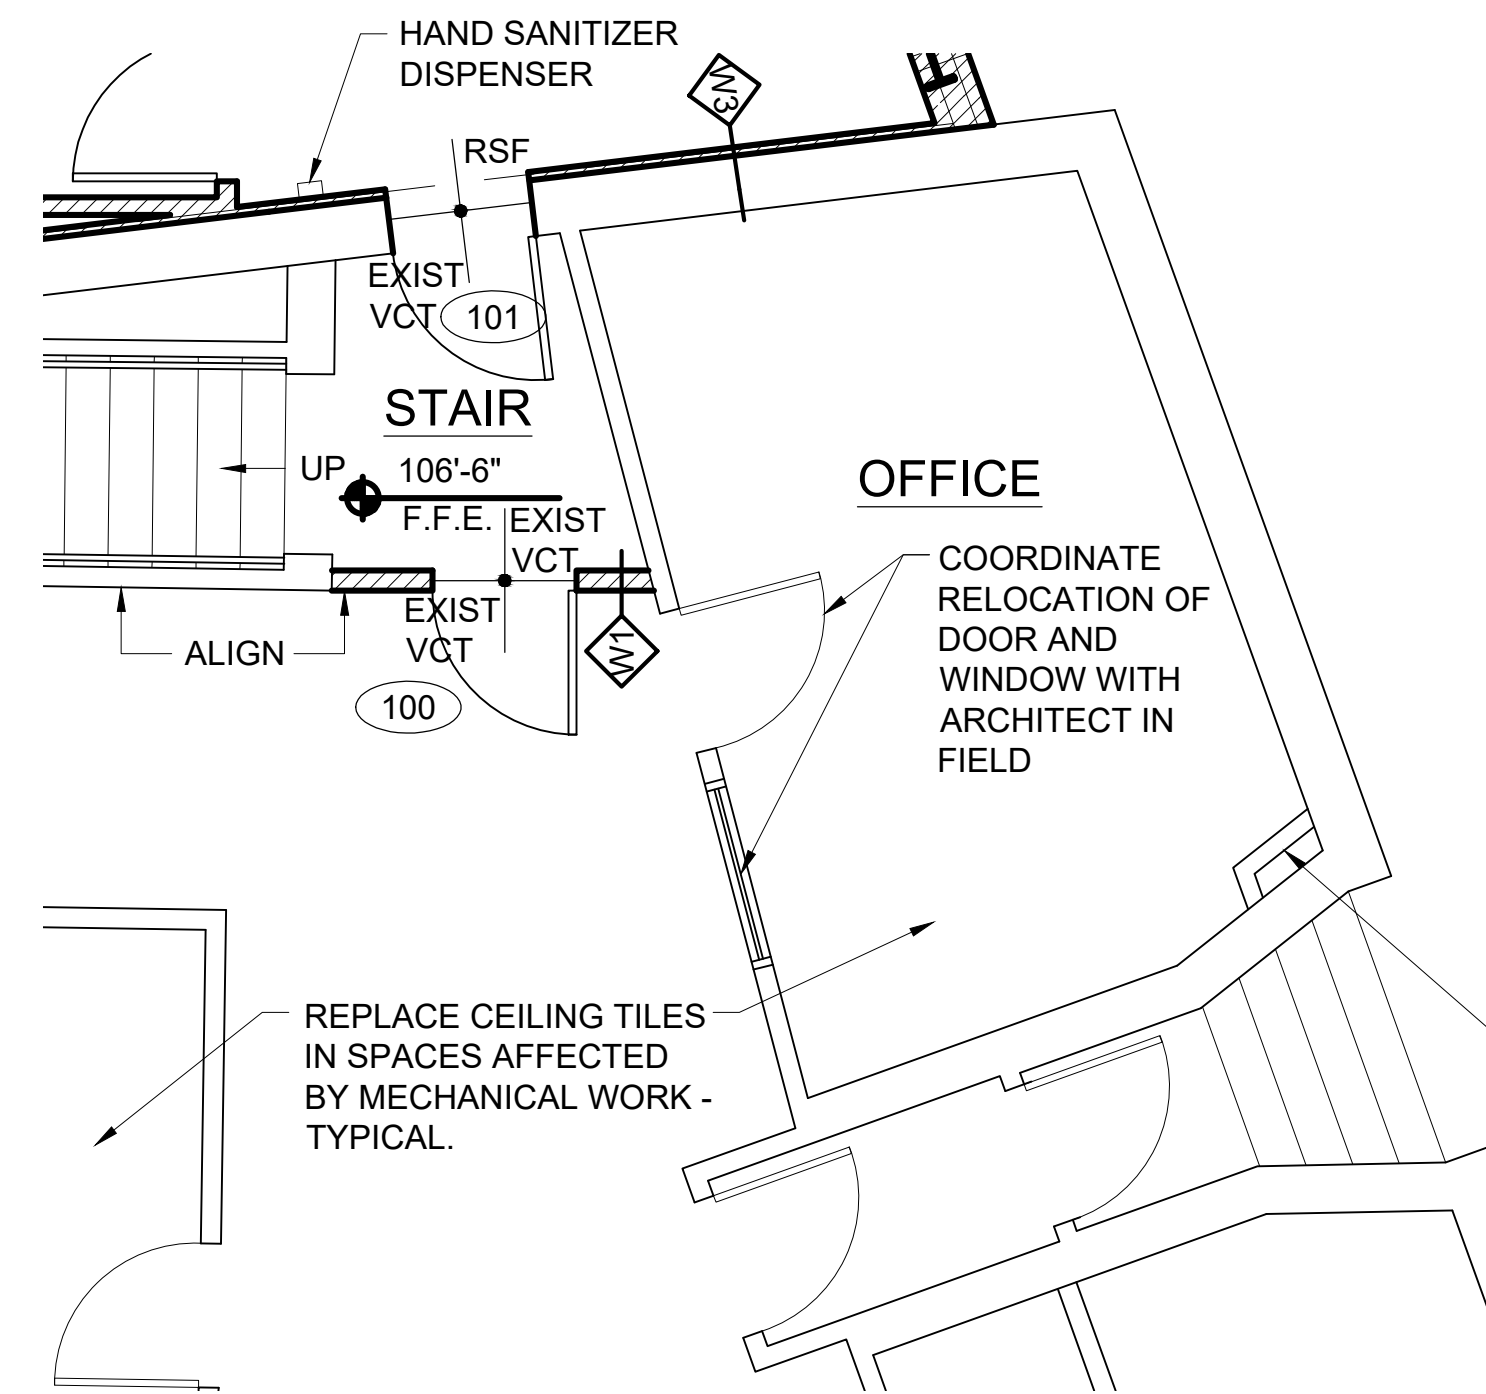



2 DINING HALL PLAN - CONT.
SCALE: 1/4" = 1'-0"

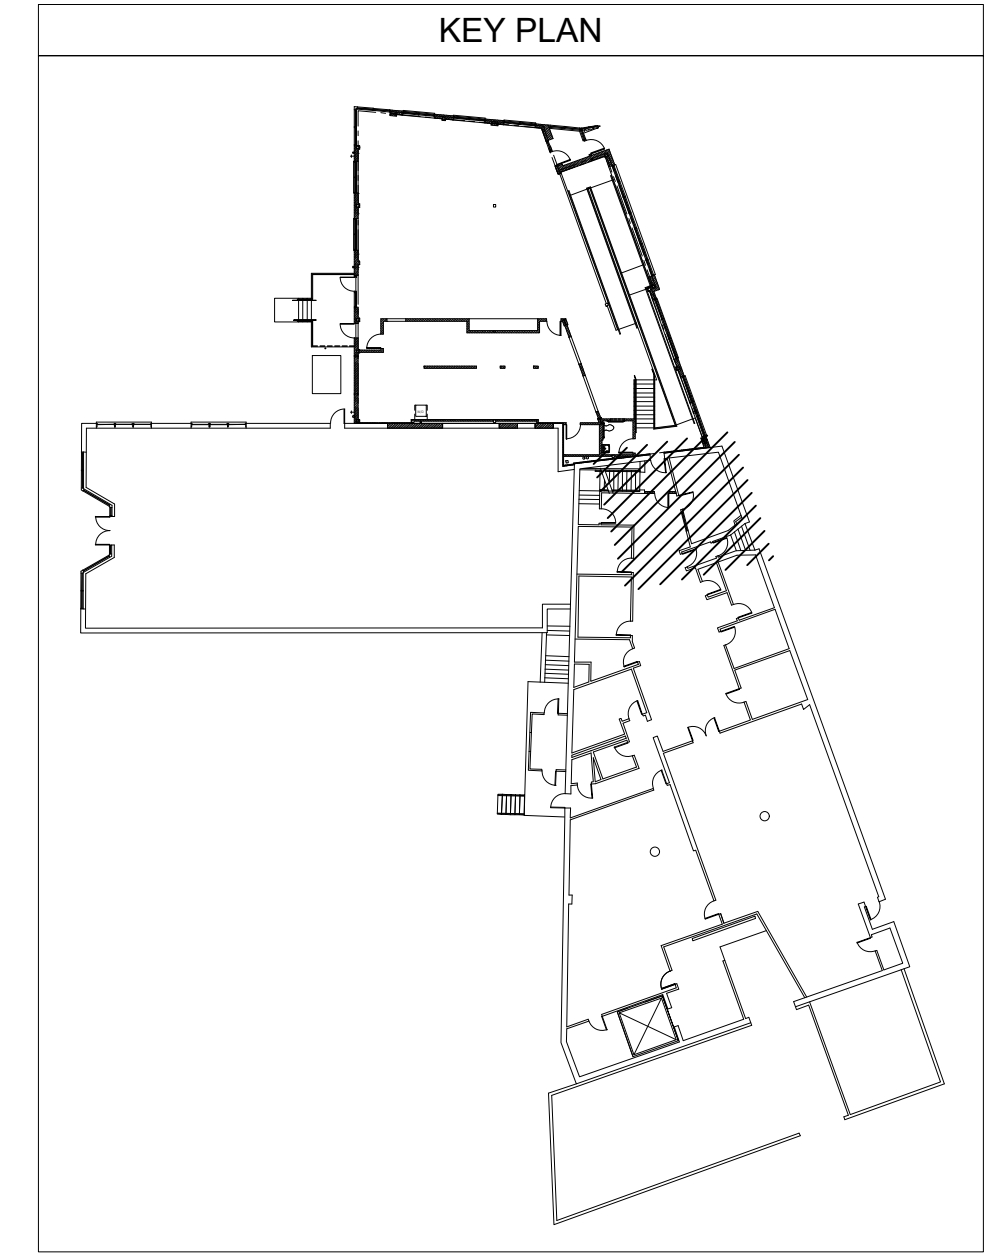

REPLACE CEILING TILES IN SPACES AFFECTED BY MECHANICAL WORK - TYPICAL.
PATCH WALL/CHASE TO MATCH SURROUNDING FINISHES IN AREAS AFFECTED BY MECHANICAL PIPING REWORK.

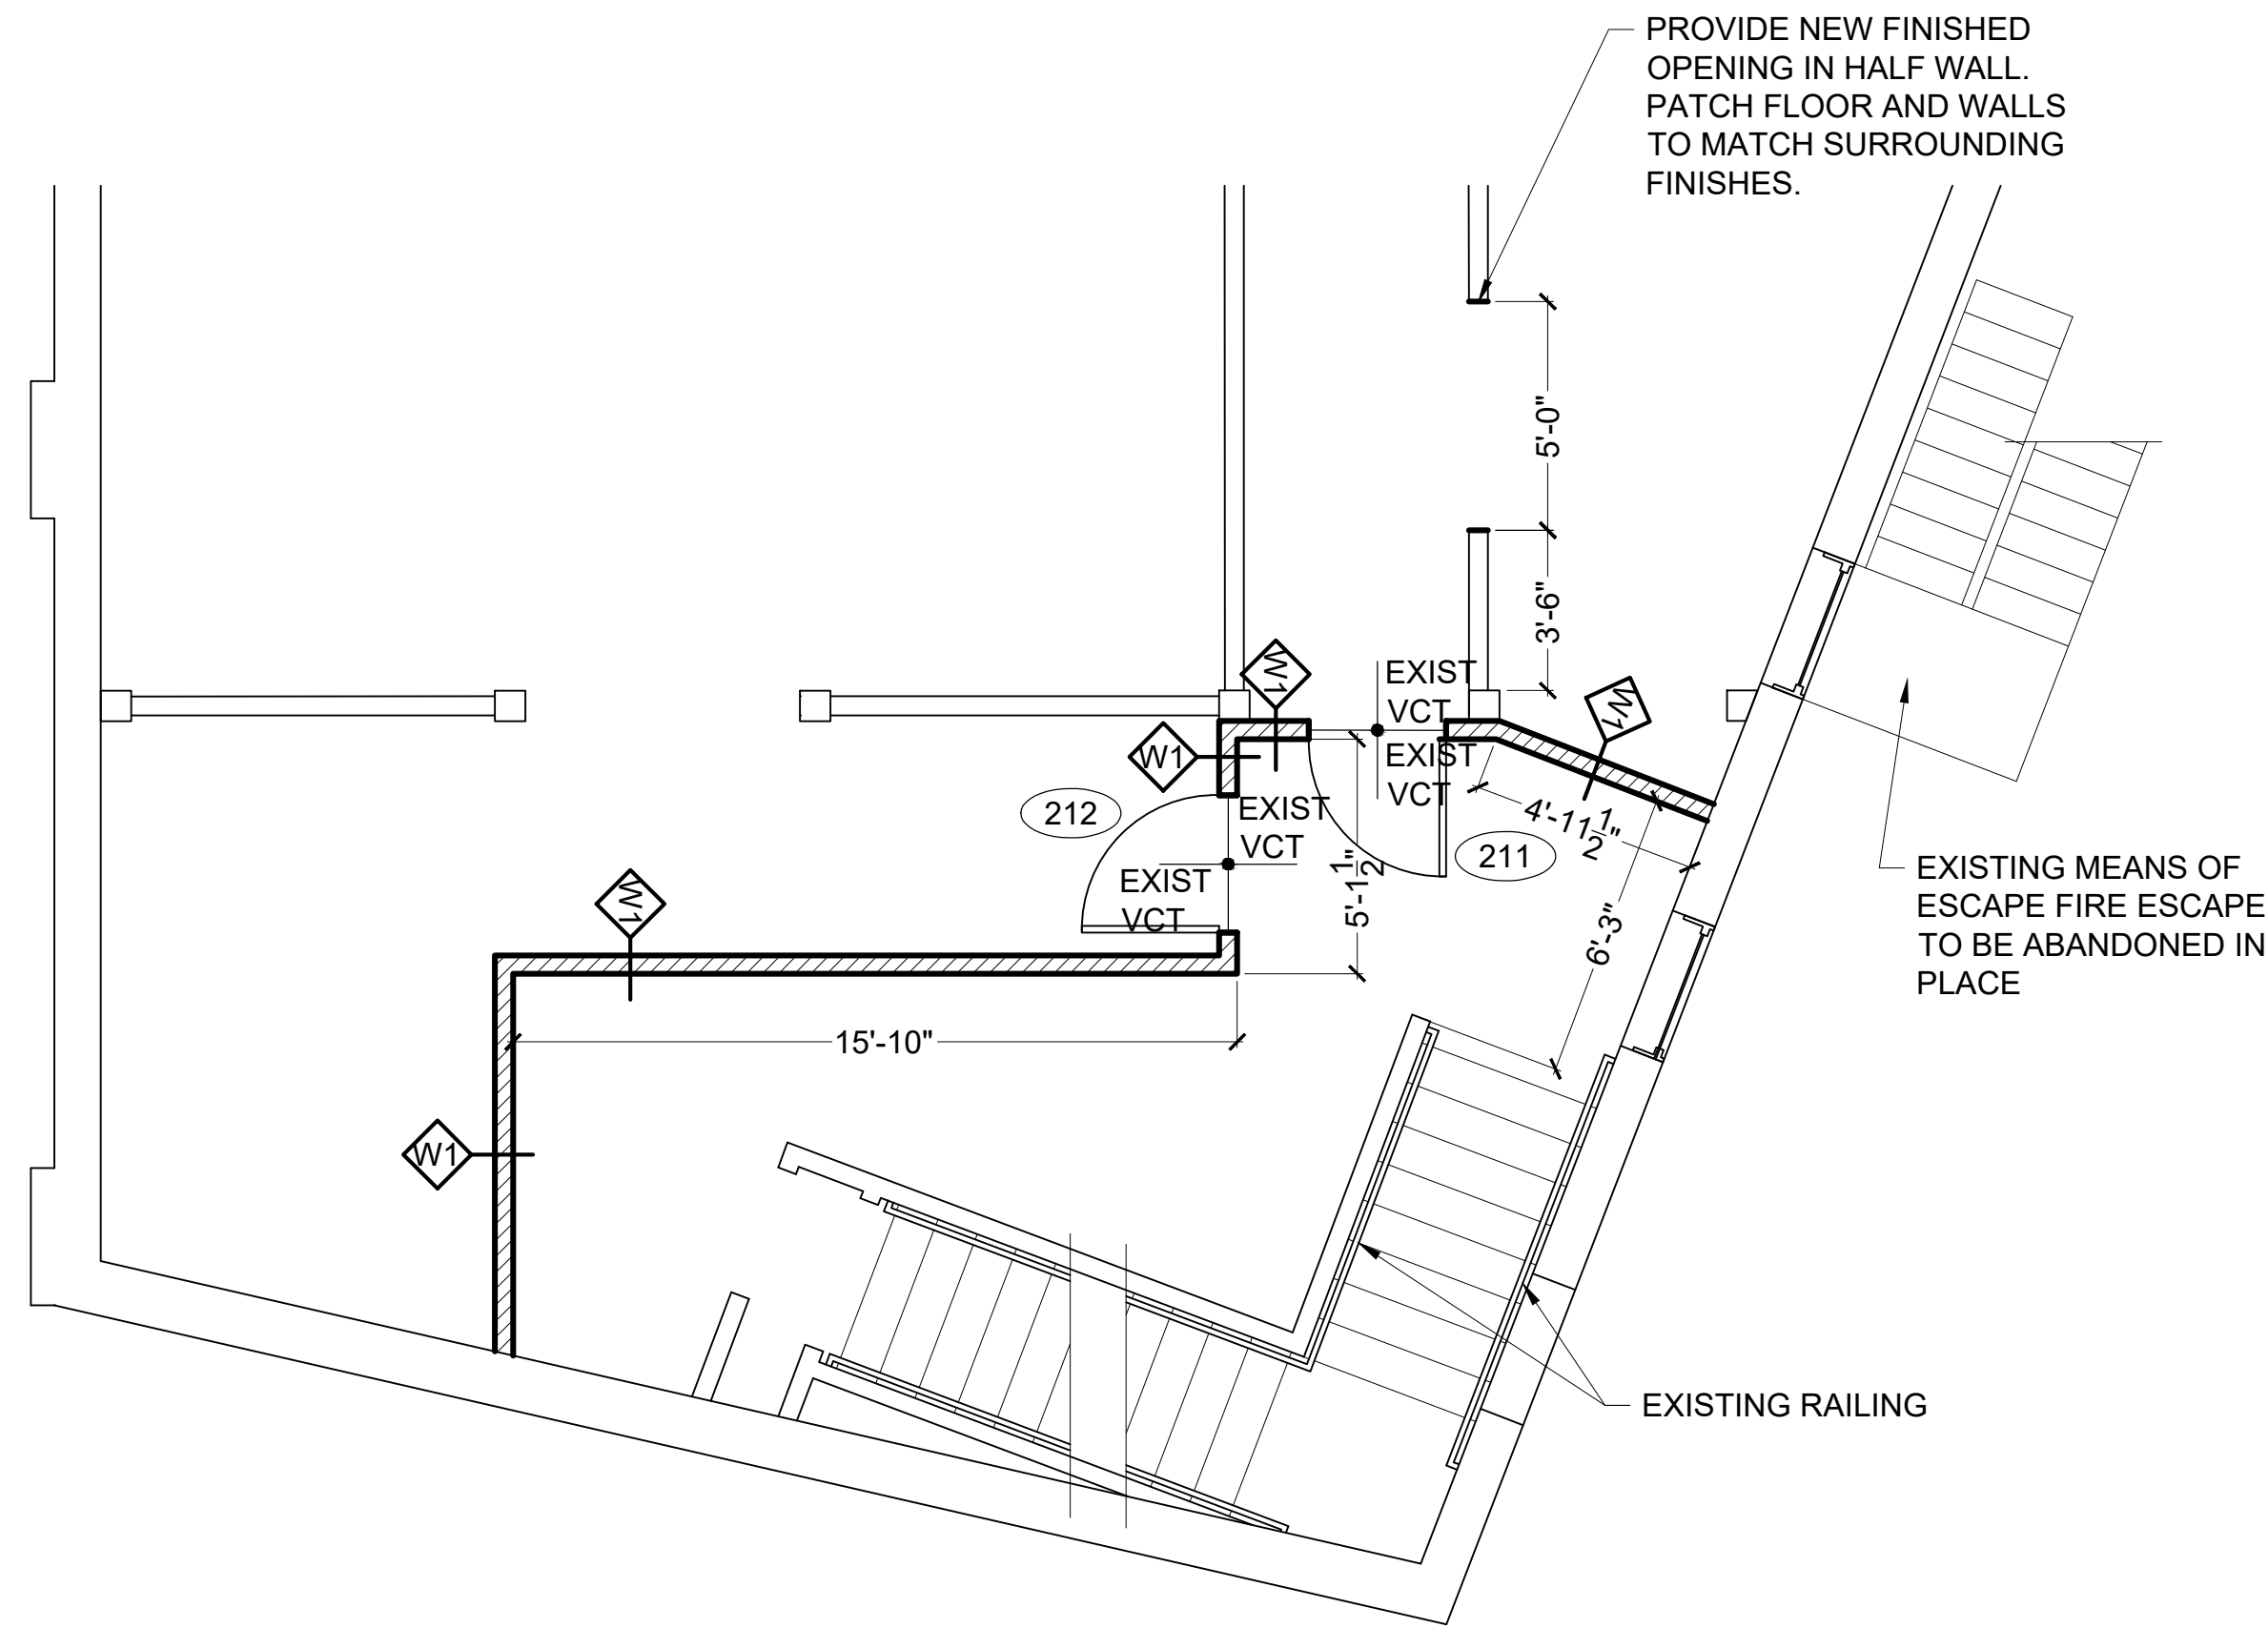

3 SECOND FLOOR EGRESS STAIR
SCALE: 1/4" = 1'-0"

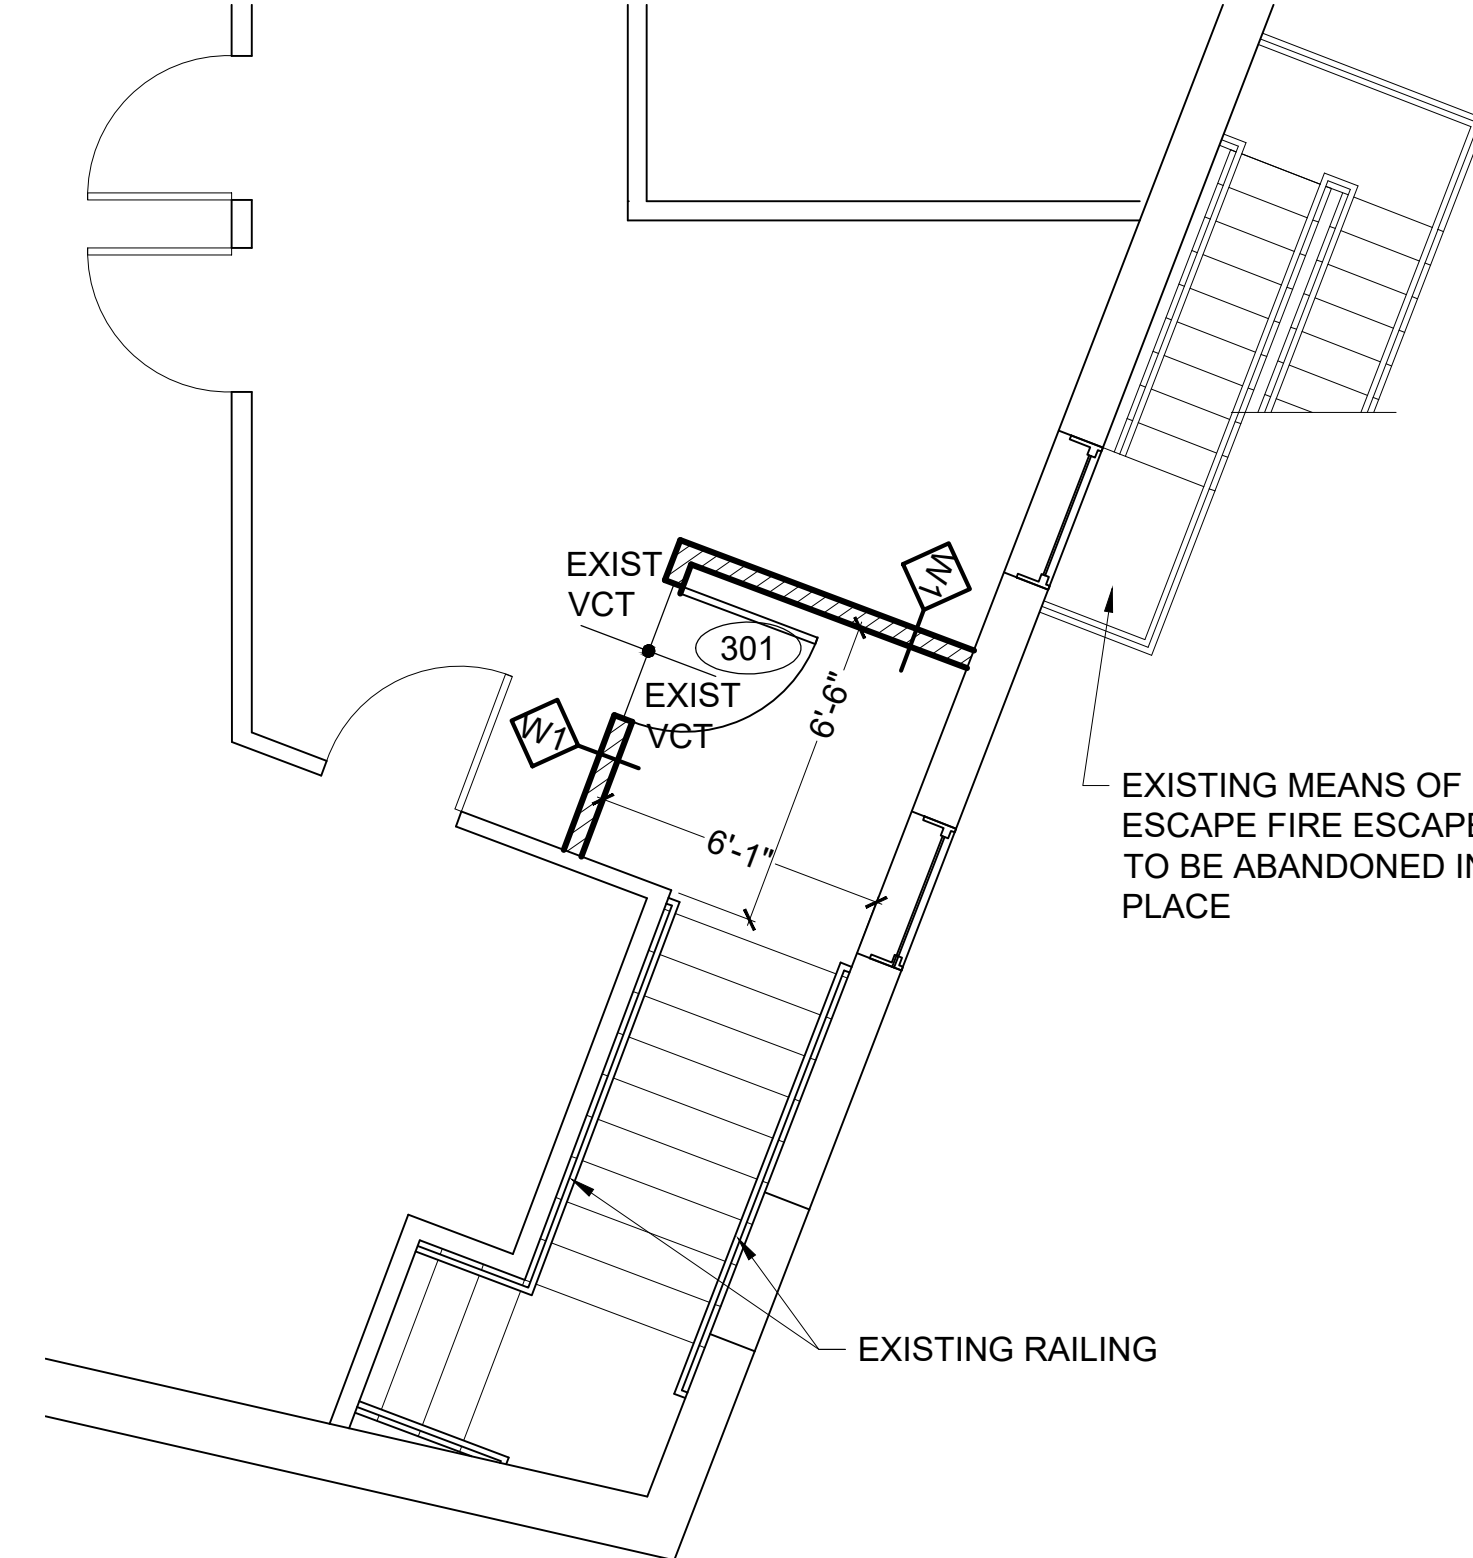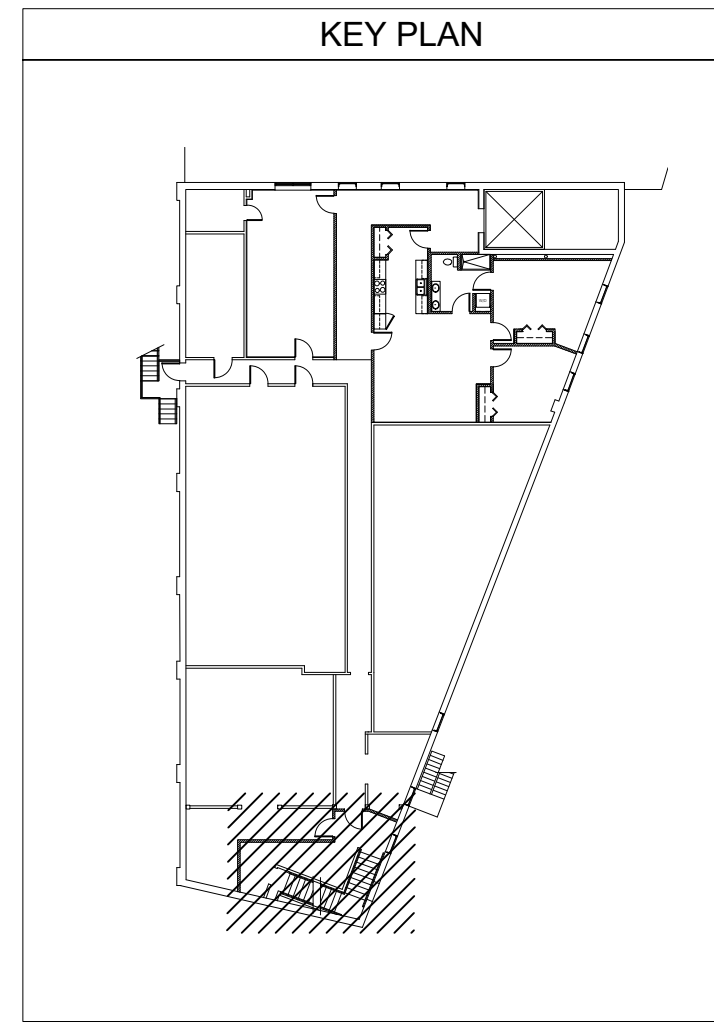

4 THIRD FLOOR EGRESS STAIR
SCALE: 1/4" = 1'-0"

