


COPYRIGHT: Reuse or reproduction of the contents of this document is not permitted without written permission of Ripcord Engineering, Inc.

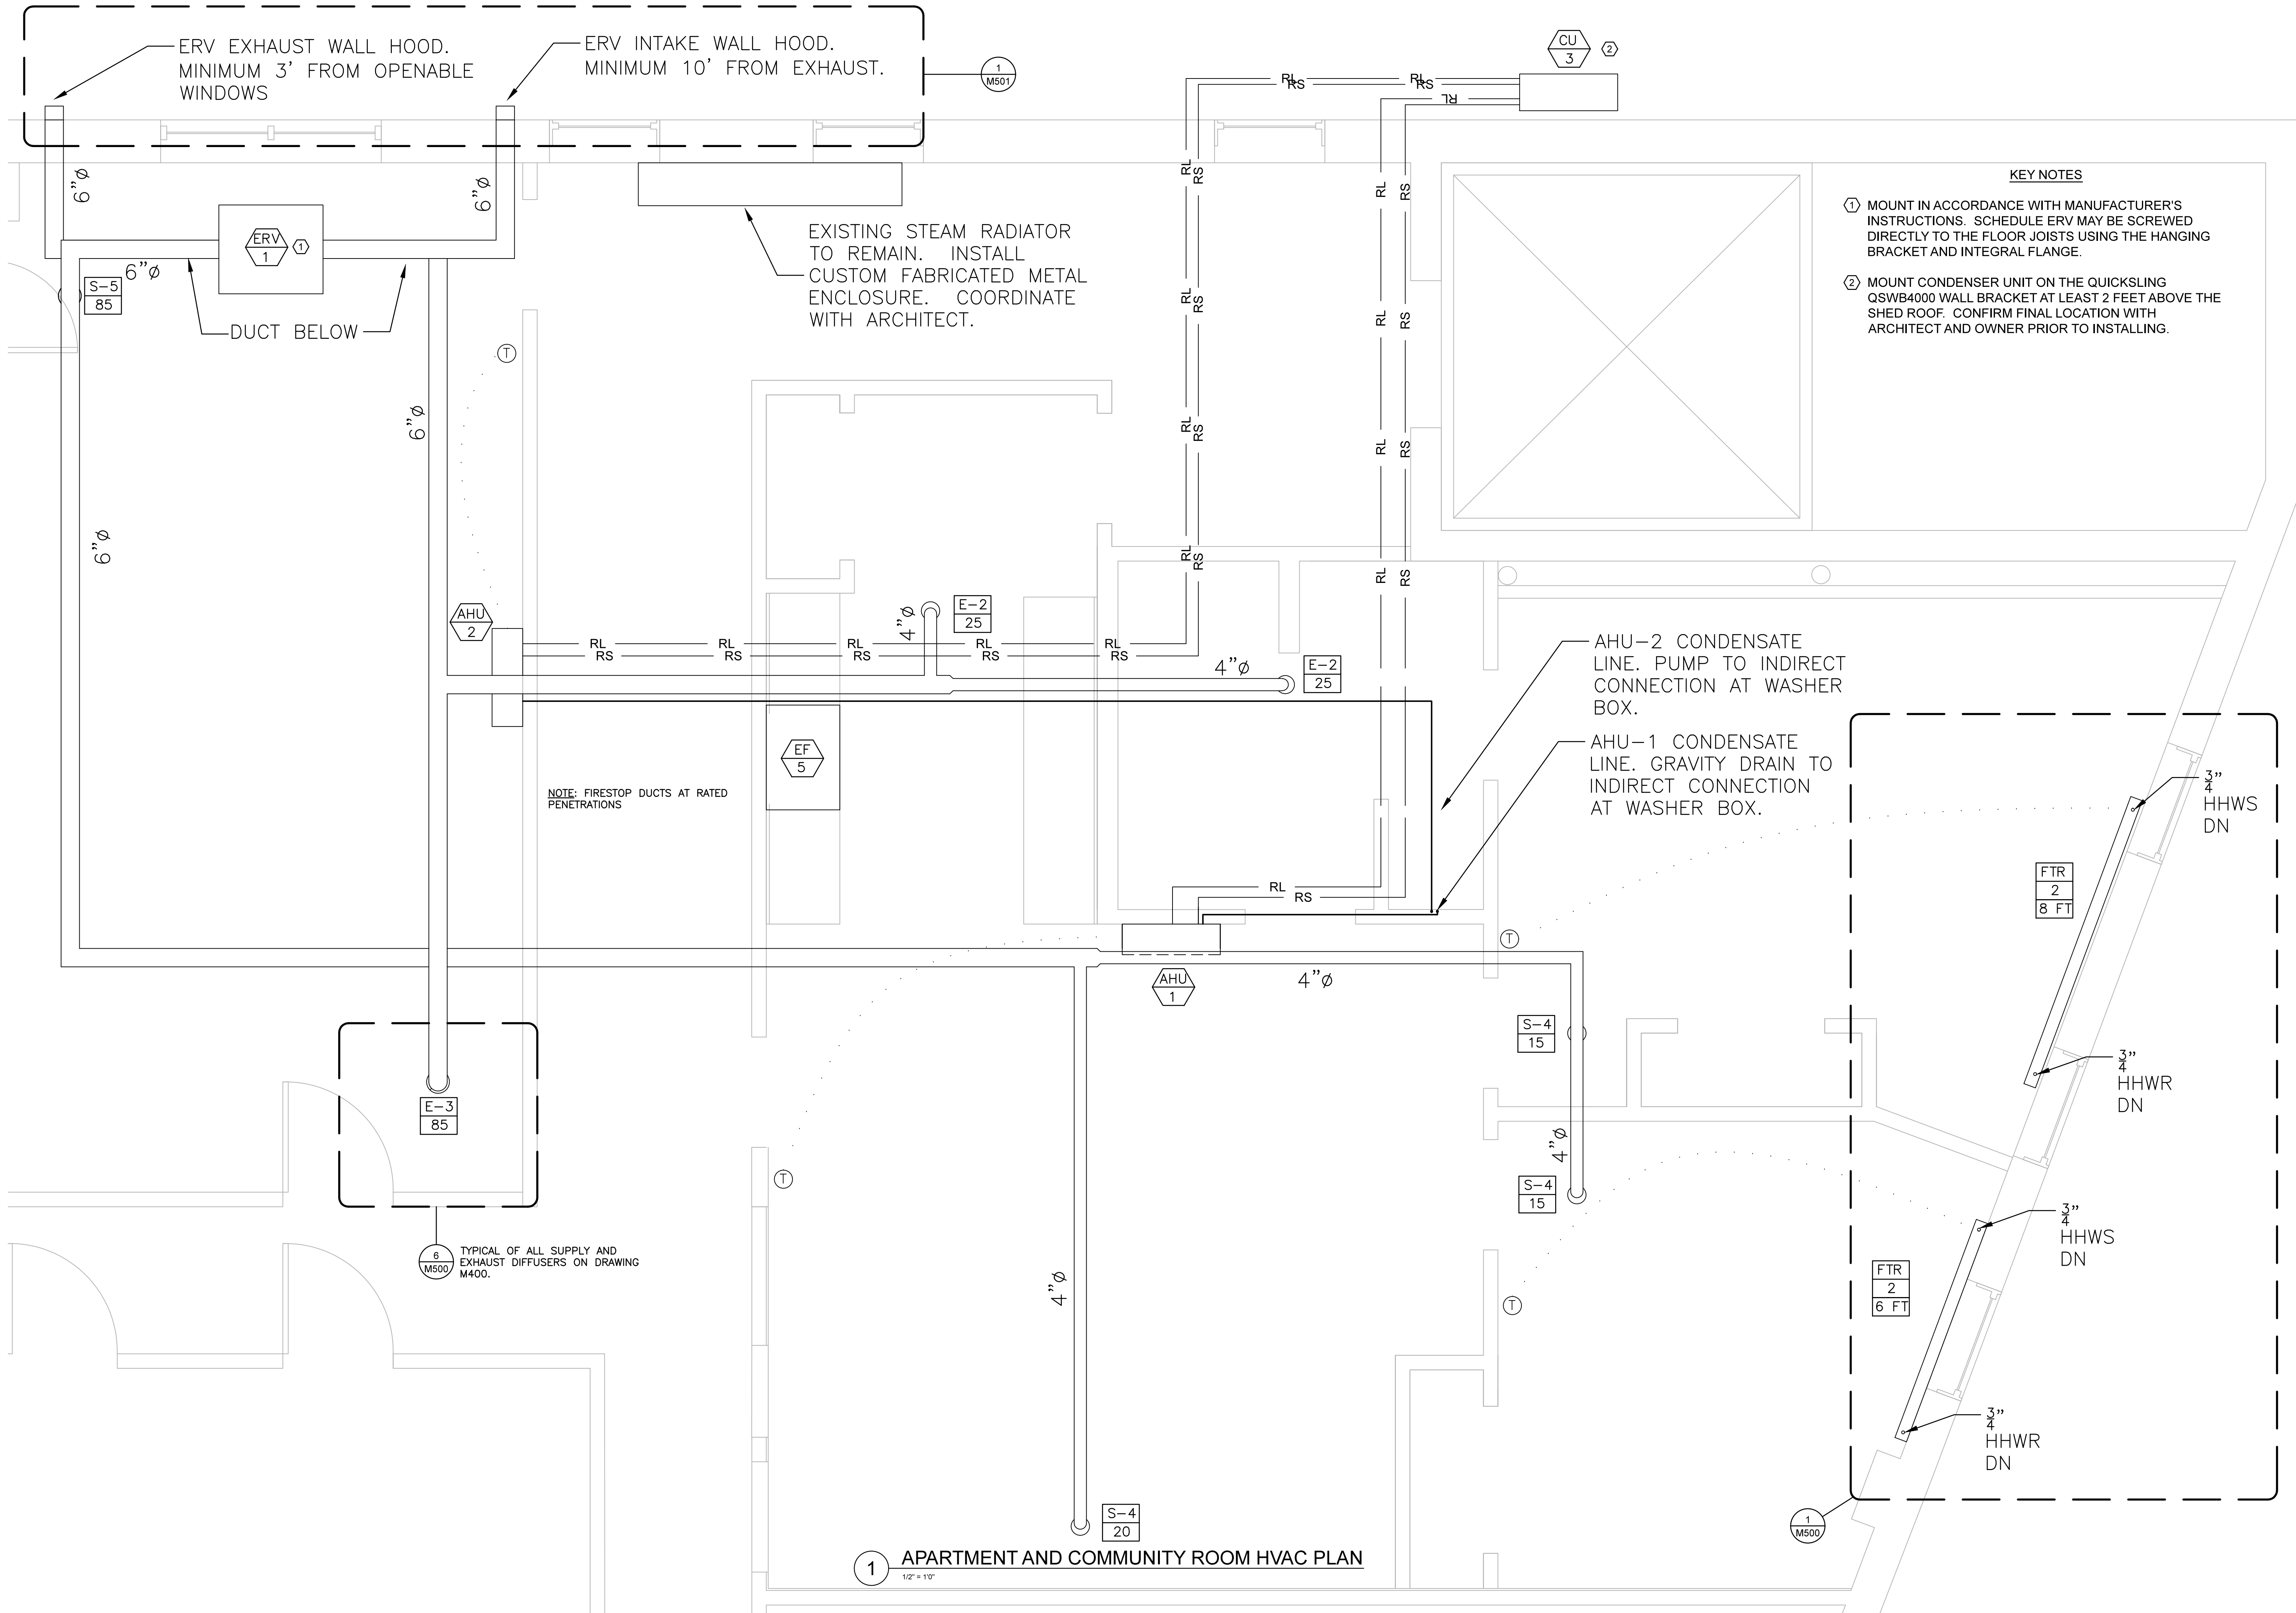

1 APARTMENT AND COMMUNITY ROOM HVAC PLAN
1/2" = 10"

ISSUE DATE: 10/25/16
SHEET SCALE: 1/2" = 10"

DRAWN BY: SMB
SHEET TITLE: APARTMENT AND COMMUNITY ROOM HVAC PLAN

REVISIONS

1	
2	
3	
4	
5	

PROJECT NO. 15031
PROJECT NAME: SALVATION ARMY ARC
PORTLAND, ME

Ripcord Engineering
PO Box 4175
Portland, ME 04101
207.331.7900
sonia.barrantes@ripcordengineering.com

RIPCORD ENGINEERING

STATE OF MAINE
SONIA M. BARRANTES
Professional Engineer
No. 12534
EXPIRES 12/31/2020

M
M104