



1 TYPICAL DUCT & PIPING SUPPORT RACK
NO SCALE

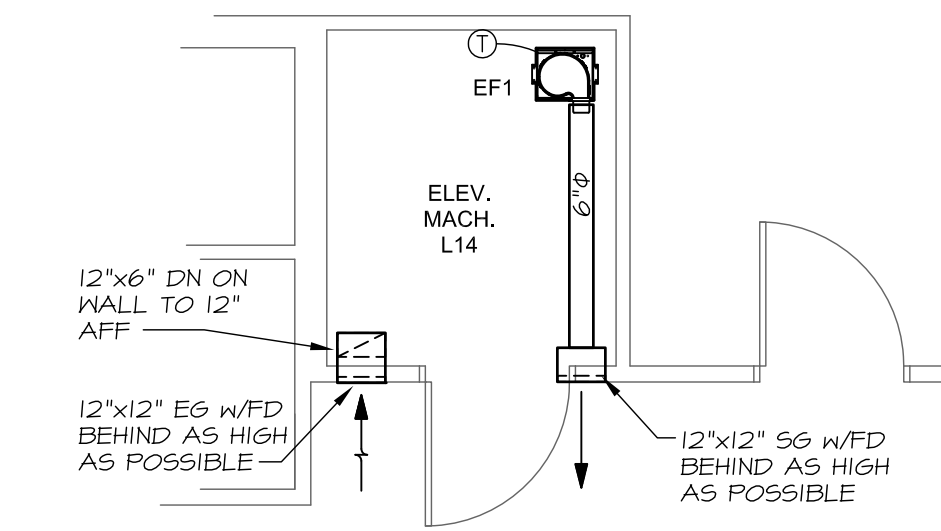


2 ELEVATOR MACH. ROOM
SCALE: 1/4" = 1'-0"

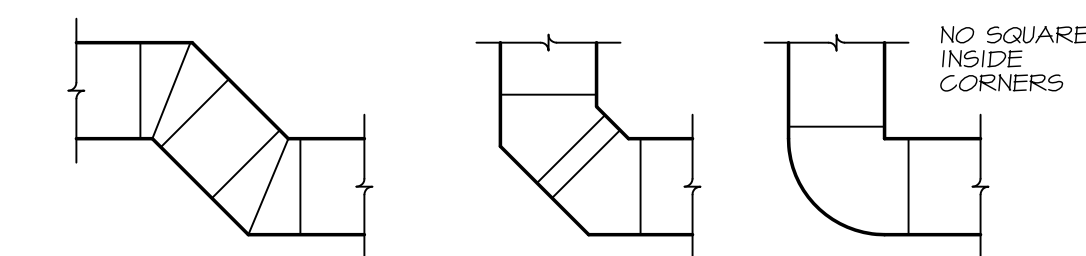


3 UNACCEPTABLE DUCT FITTINGS
NO SCALE

THESE TYPES OF FITTINGS PROHIBITED UNLESS SPECIFICALLY INDICATED OTHERWISE


ELBOWS TO BE SMOOTH, LONG RADIUS ONLY SEGMENTED ELBOWS ARE PROHIBITED

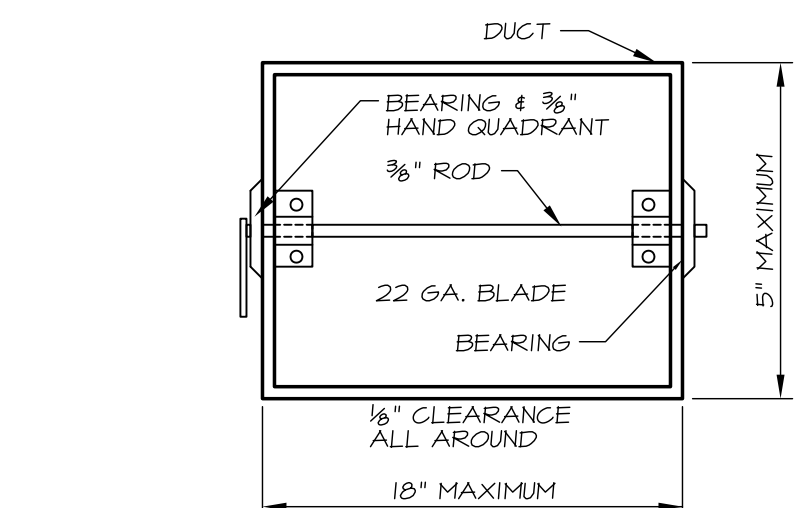


4 SHOP FABRICATED MANUAL DAMPER
NO SCALE

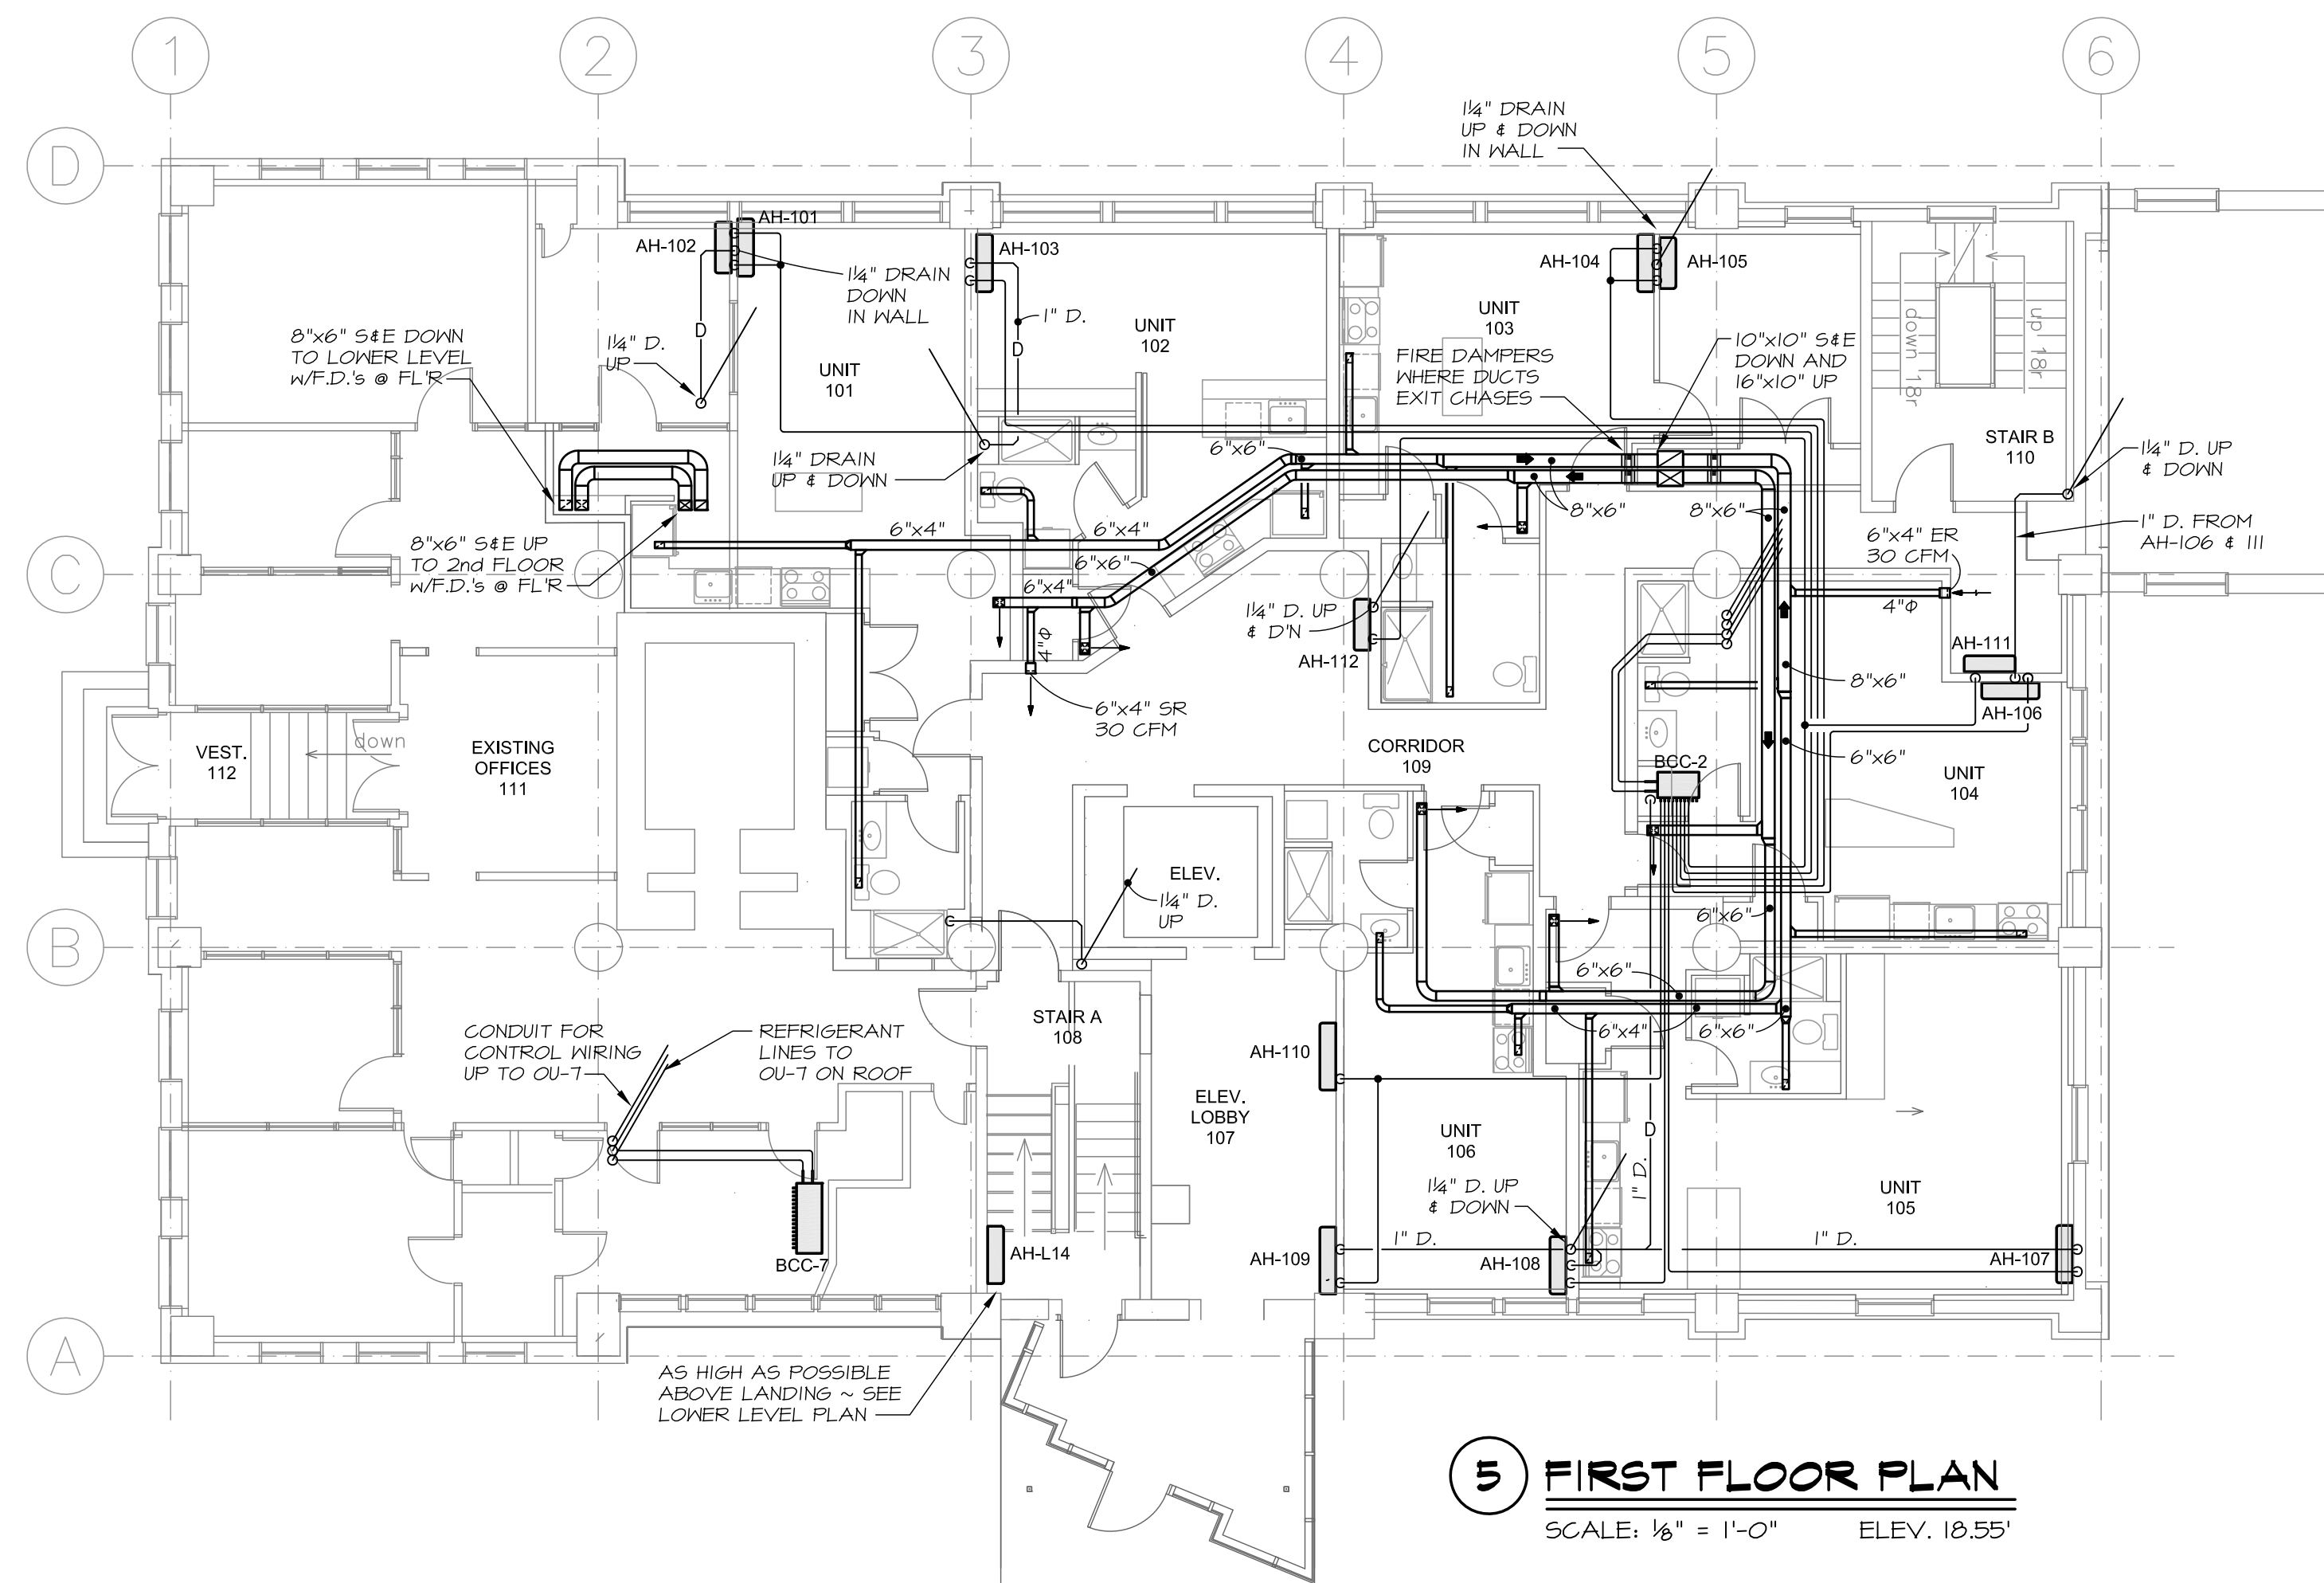

5 FIRST FLOOR PLAN
SCALE: 1/8" = 1'-0" ELEV. 10.55'

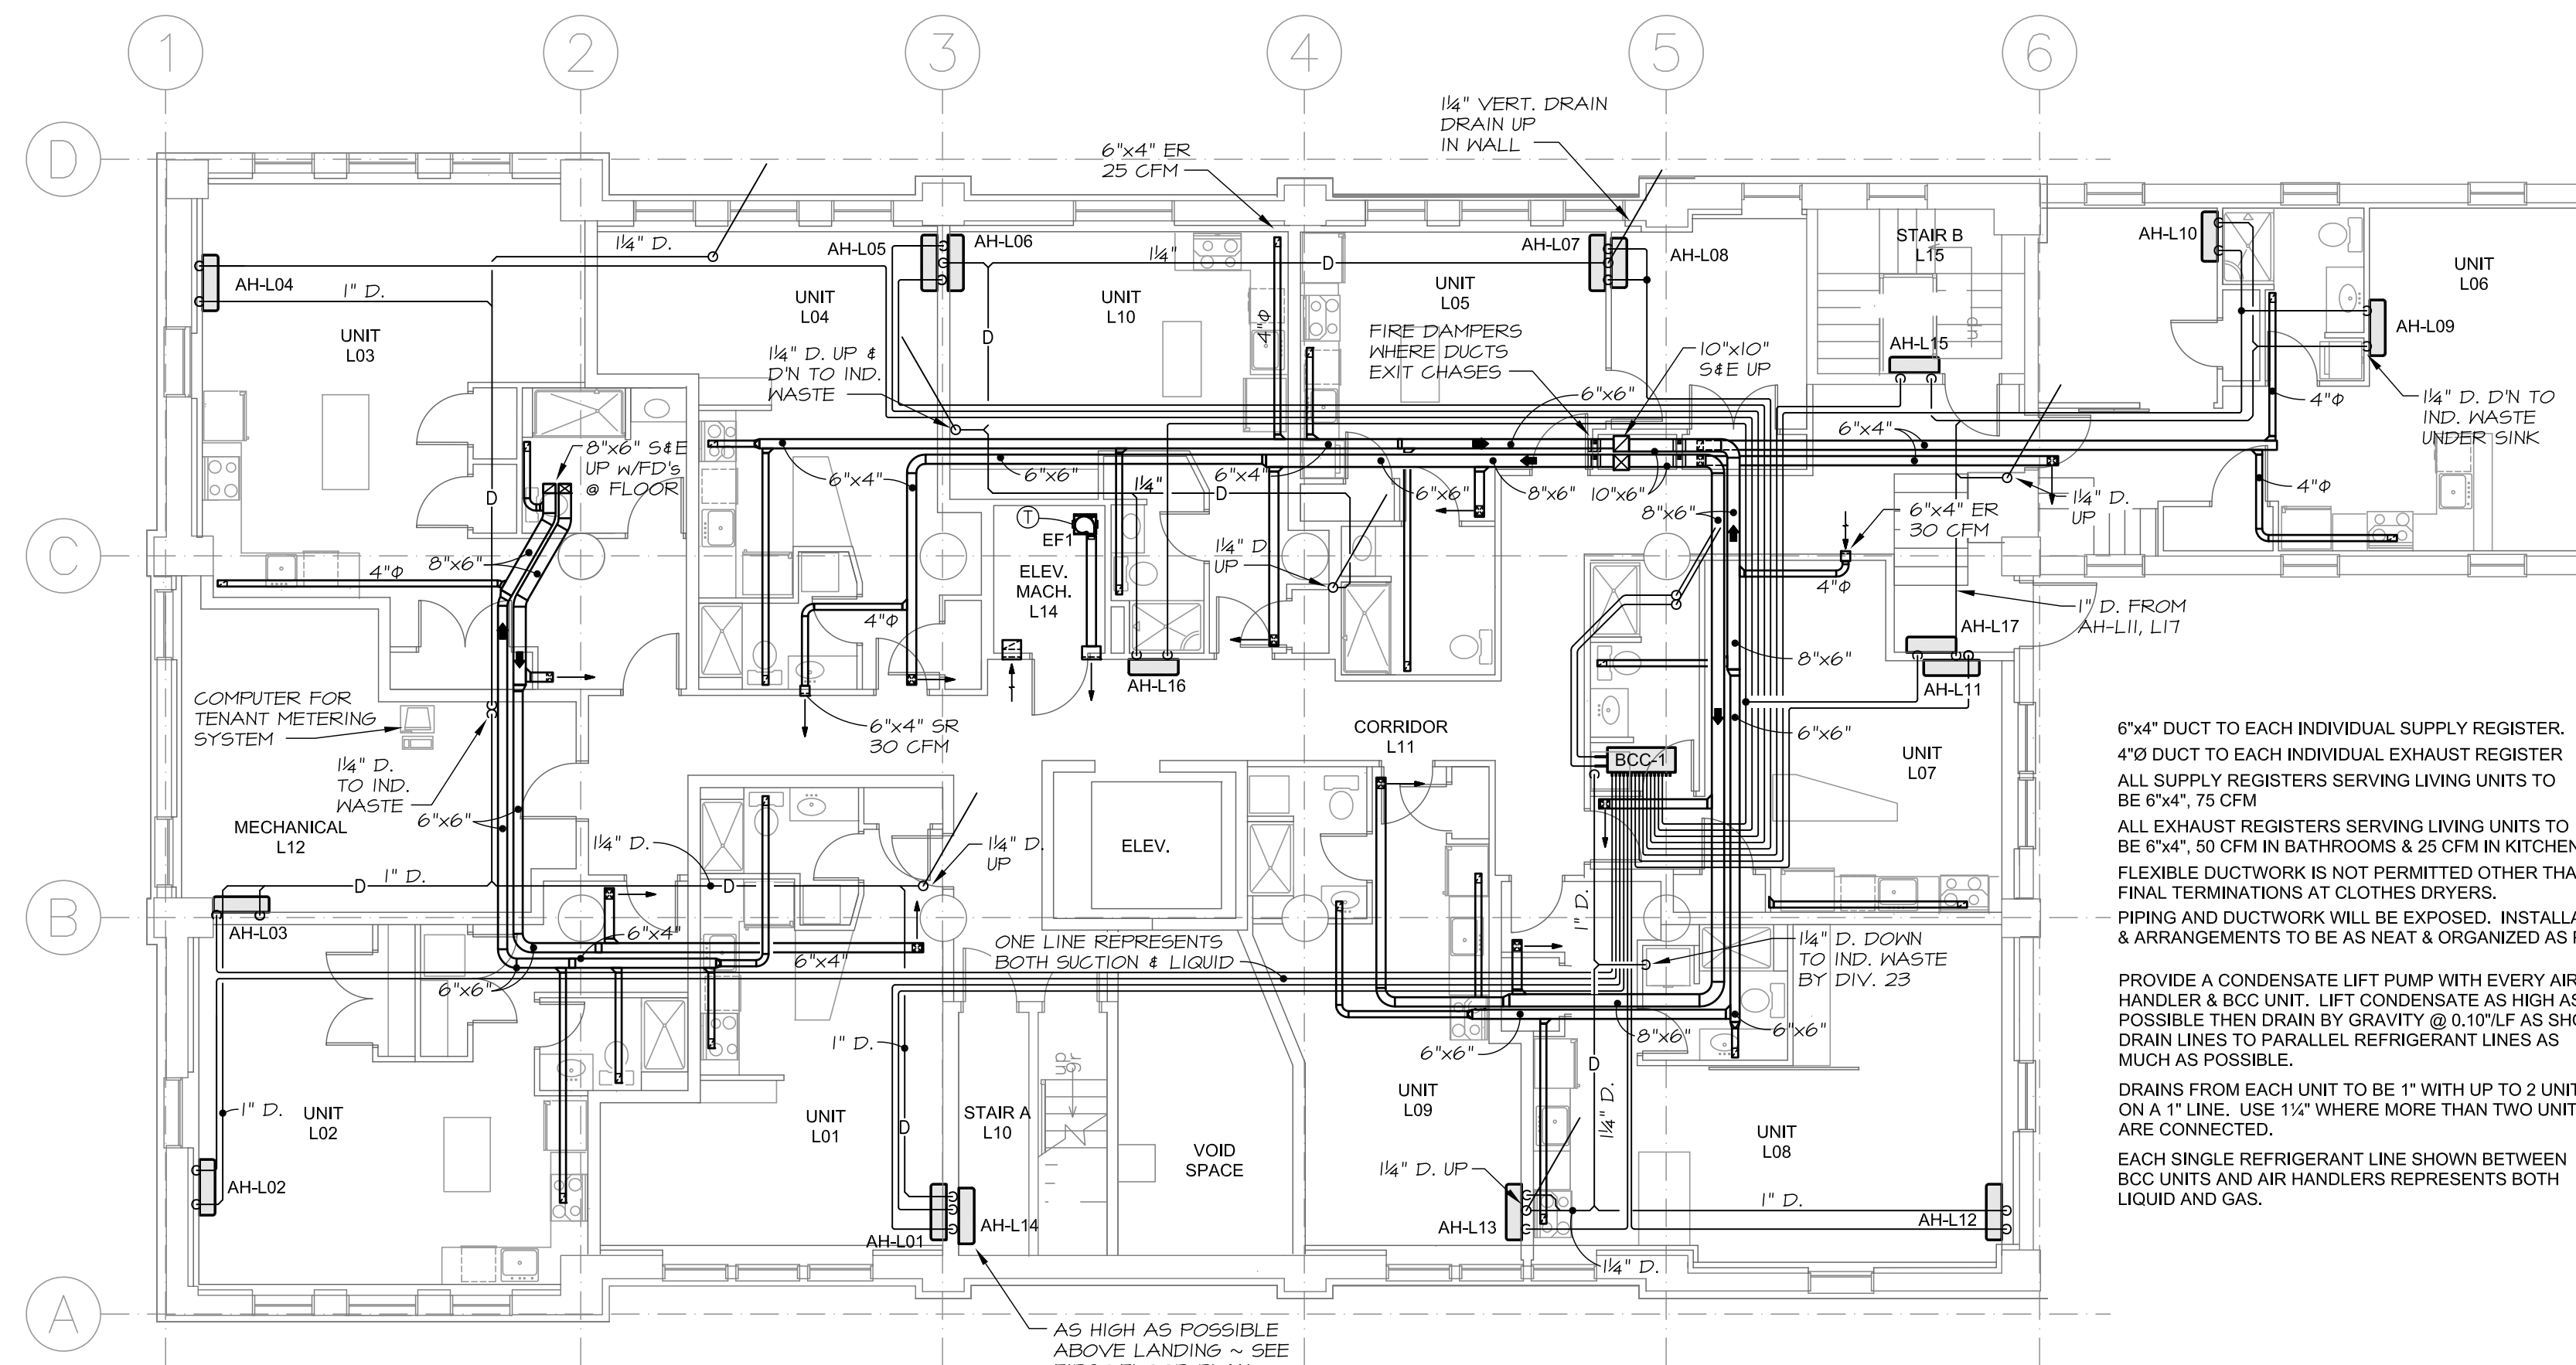

6 LOWER LEVEL PLAN
SCALE: 1/8" = 1'-0" ELEV. 07.55'

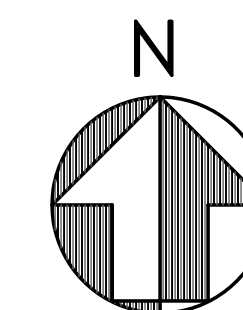


project name

Schlotterbeck Block
117 Preble Street
Portland, Maine

Schlotterbeck Block LLC
goduti/thomas architects

44 oak st.
portland, maine 04101
ph. 207-775-3184
fax 207-774-0486

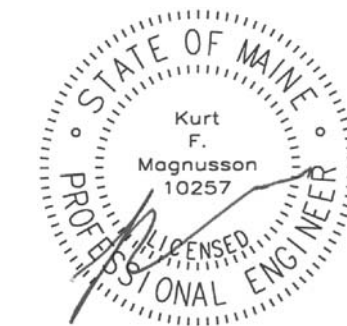

Revise Unit L06 3.8.2016
Add Unit L10 3.8.2016

revisions
date
March 15, 2016
sheet title

Lower Level and 1st Floor
Mechanical Plans
sheet title line 3

scale
Noted
drawn by
R.E.M.
project number
schlotterbeck
sheet number



M1