



BASEMENT

RELOCATE EXTC  
DIFFUSER

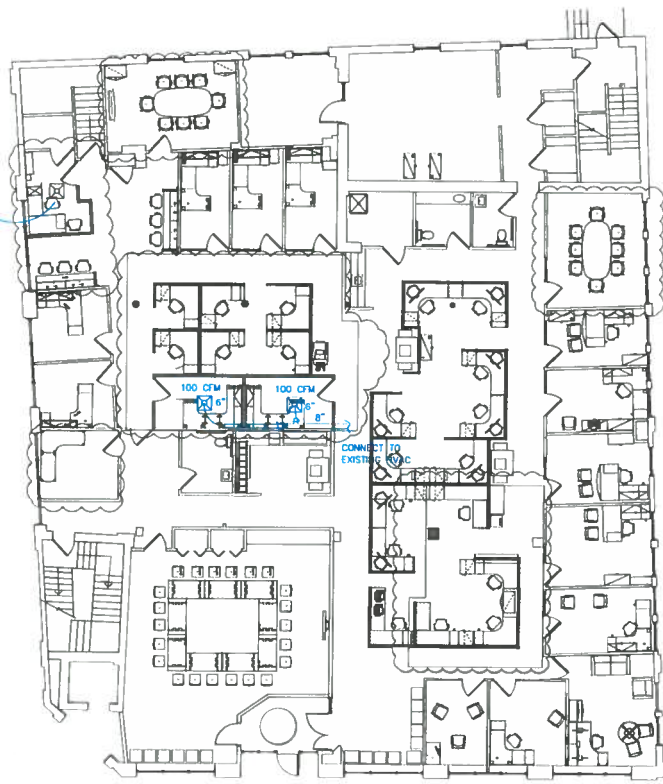

1st FLOOR

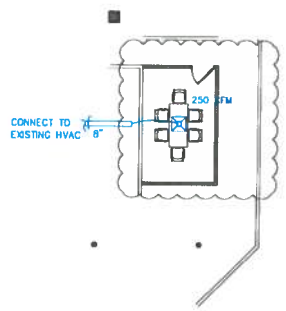

2nd FLOOR

DATE	12/2/14
REVISIONS	1. Change to include 2nd floor
DESIGNER	David T. Hester
AAA ENERGY SERVICE CO. Commercial Dept. • P.O. Box 908 1000 S. Main Street • Suite 100 90778-9008 • FAX (207) 863-5371	
QUALITY IS BUILT TO EXCEED THE EXPECTATIONS	
PROJECT	AVESTA HOUSING OFFICE REMODEL PROPOSED MECHANICAL
DATE	8/28/14
SCALE	1/8" = 1'-0"
DRAWN BY	KJD
CHECKED BY	INITIALS
JOB NUMBER	TBD
CAD FILE	AVSTA
SHEET NUMBER	M1
1 OF 1 SHEET	

SCALE - N.T.S.

NEW HVAC PLAN

M1.01