



BUILDING A MECHANICAL AND PLUMBING PLAN
SCALE - 1/8" = 1'-0"

NOTE - SANITARY, GREASE WASTE AND RUL PIPING SHALL BE CAST IRON "NO HUB" ONLY ABOVE GRADE AND CAST IRON WITH PUSH ON JOINTS BELOW GRADE.

NOTE - STUB SUPPLY AND RETURN DUCTS INTO SPACE. PROVIDE DUCT SMOKE DETECTORS ON SUPPLY AND RETURN DUCT FOR ALL SYSTEMS EXCEEDING 2000 CFM.

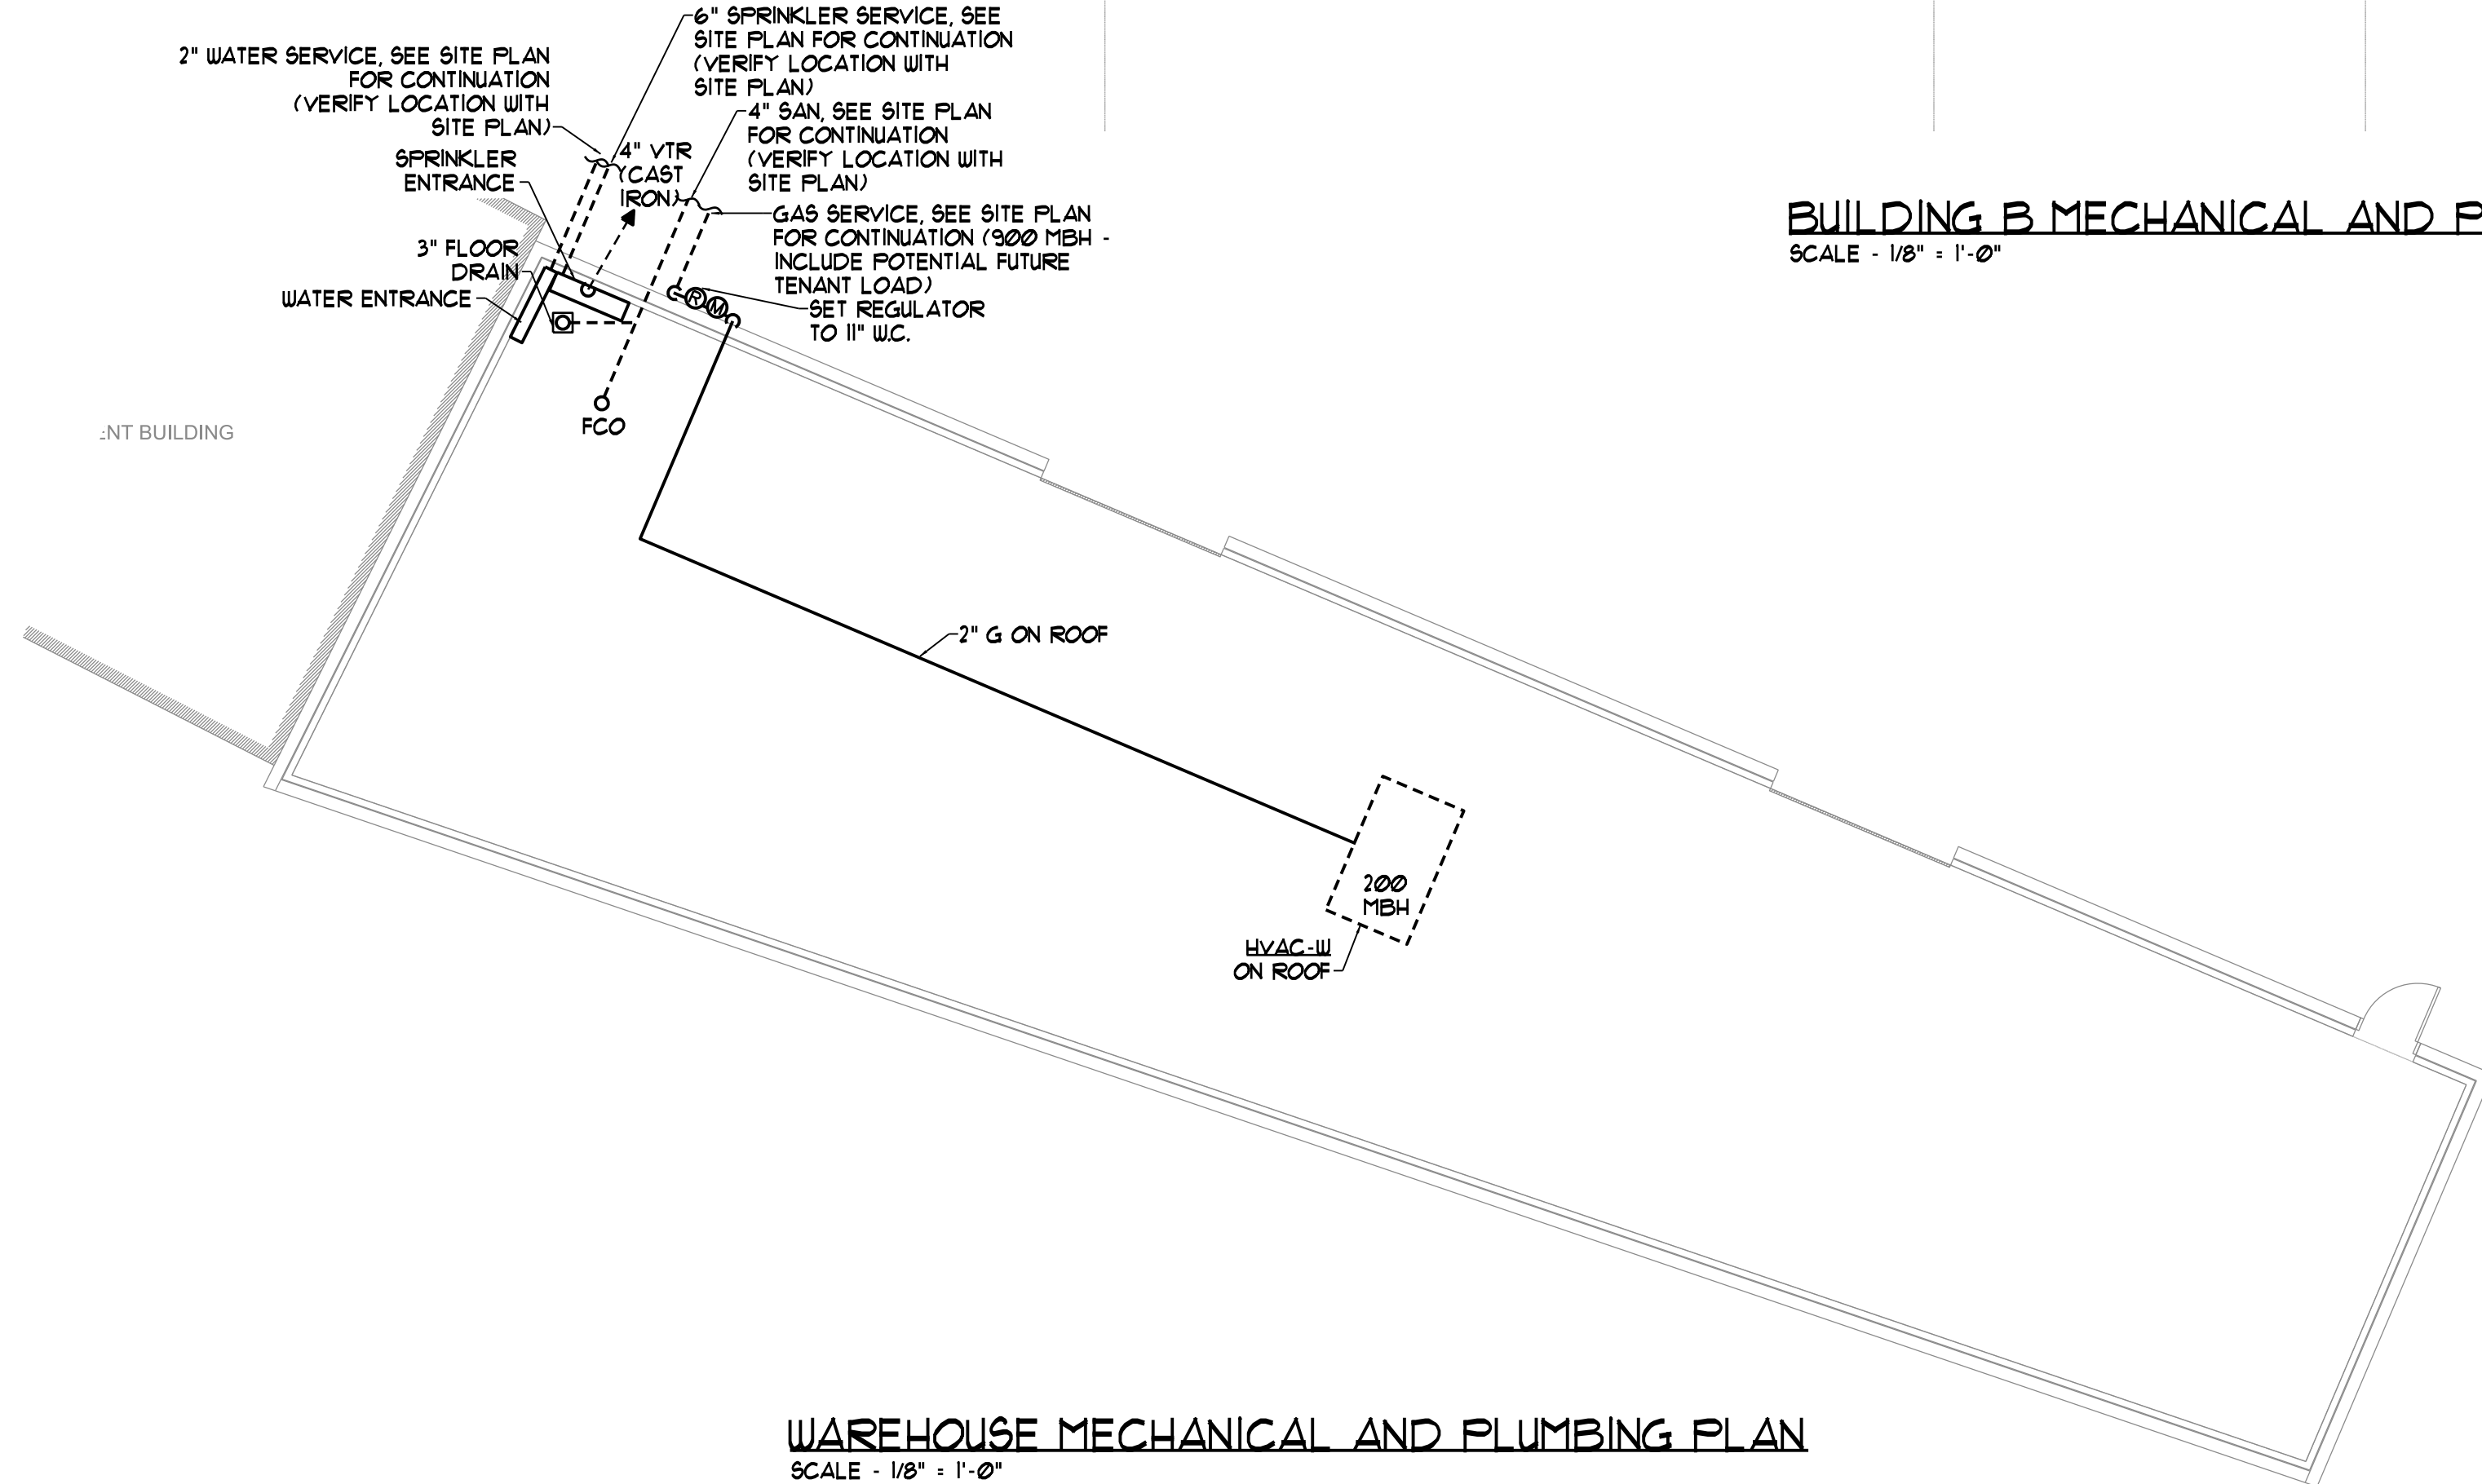

WAREHOUSE MECHANICAL AND PLUMBING PLAN
SCALE - 1/8" = 1'-0"

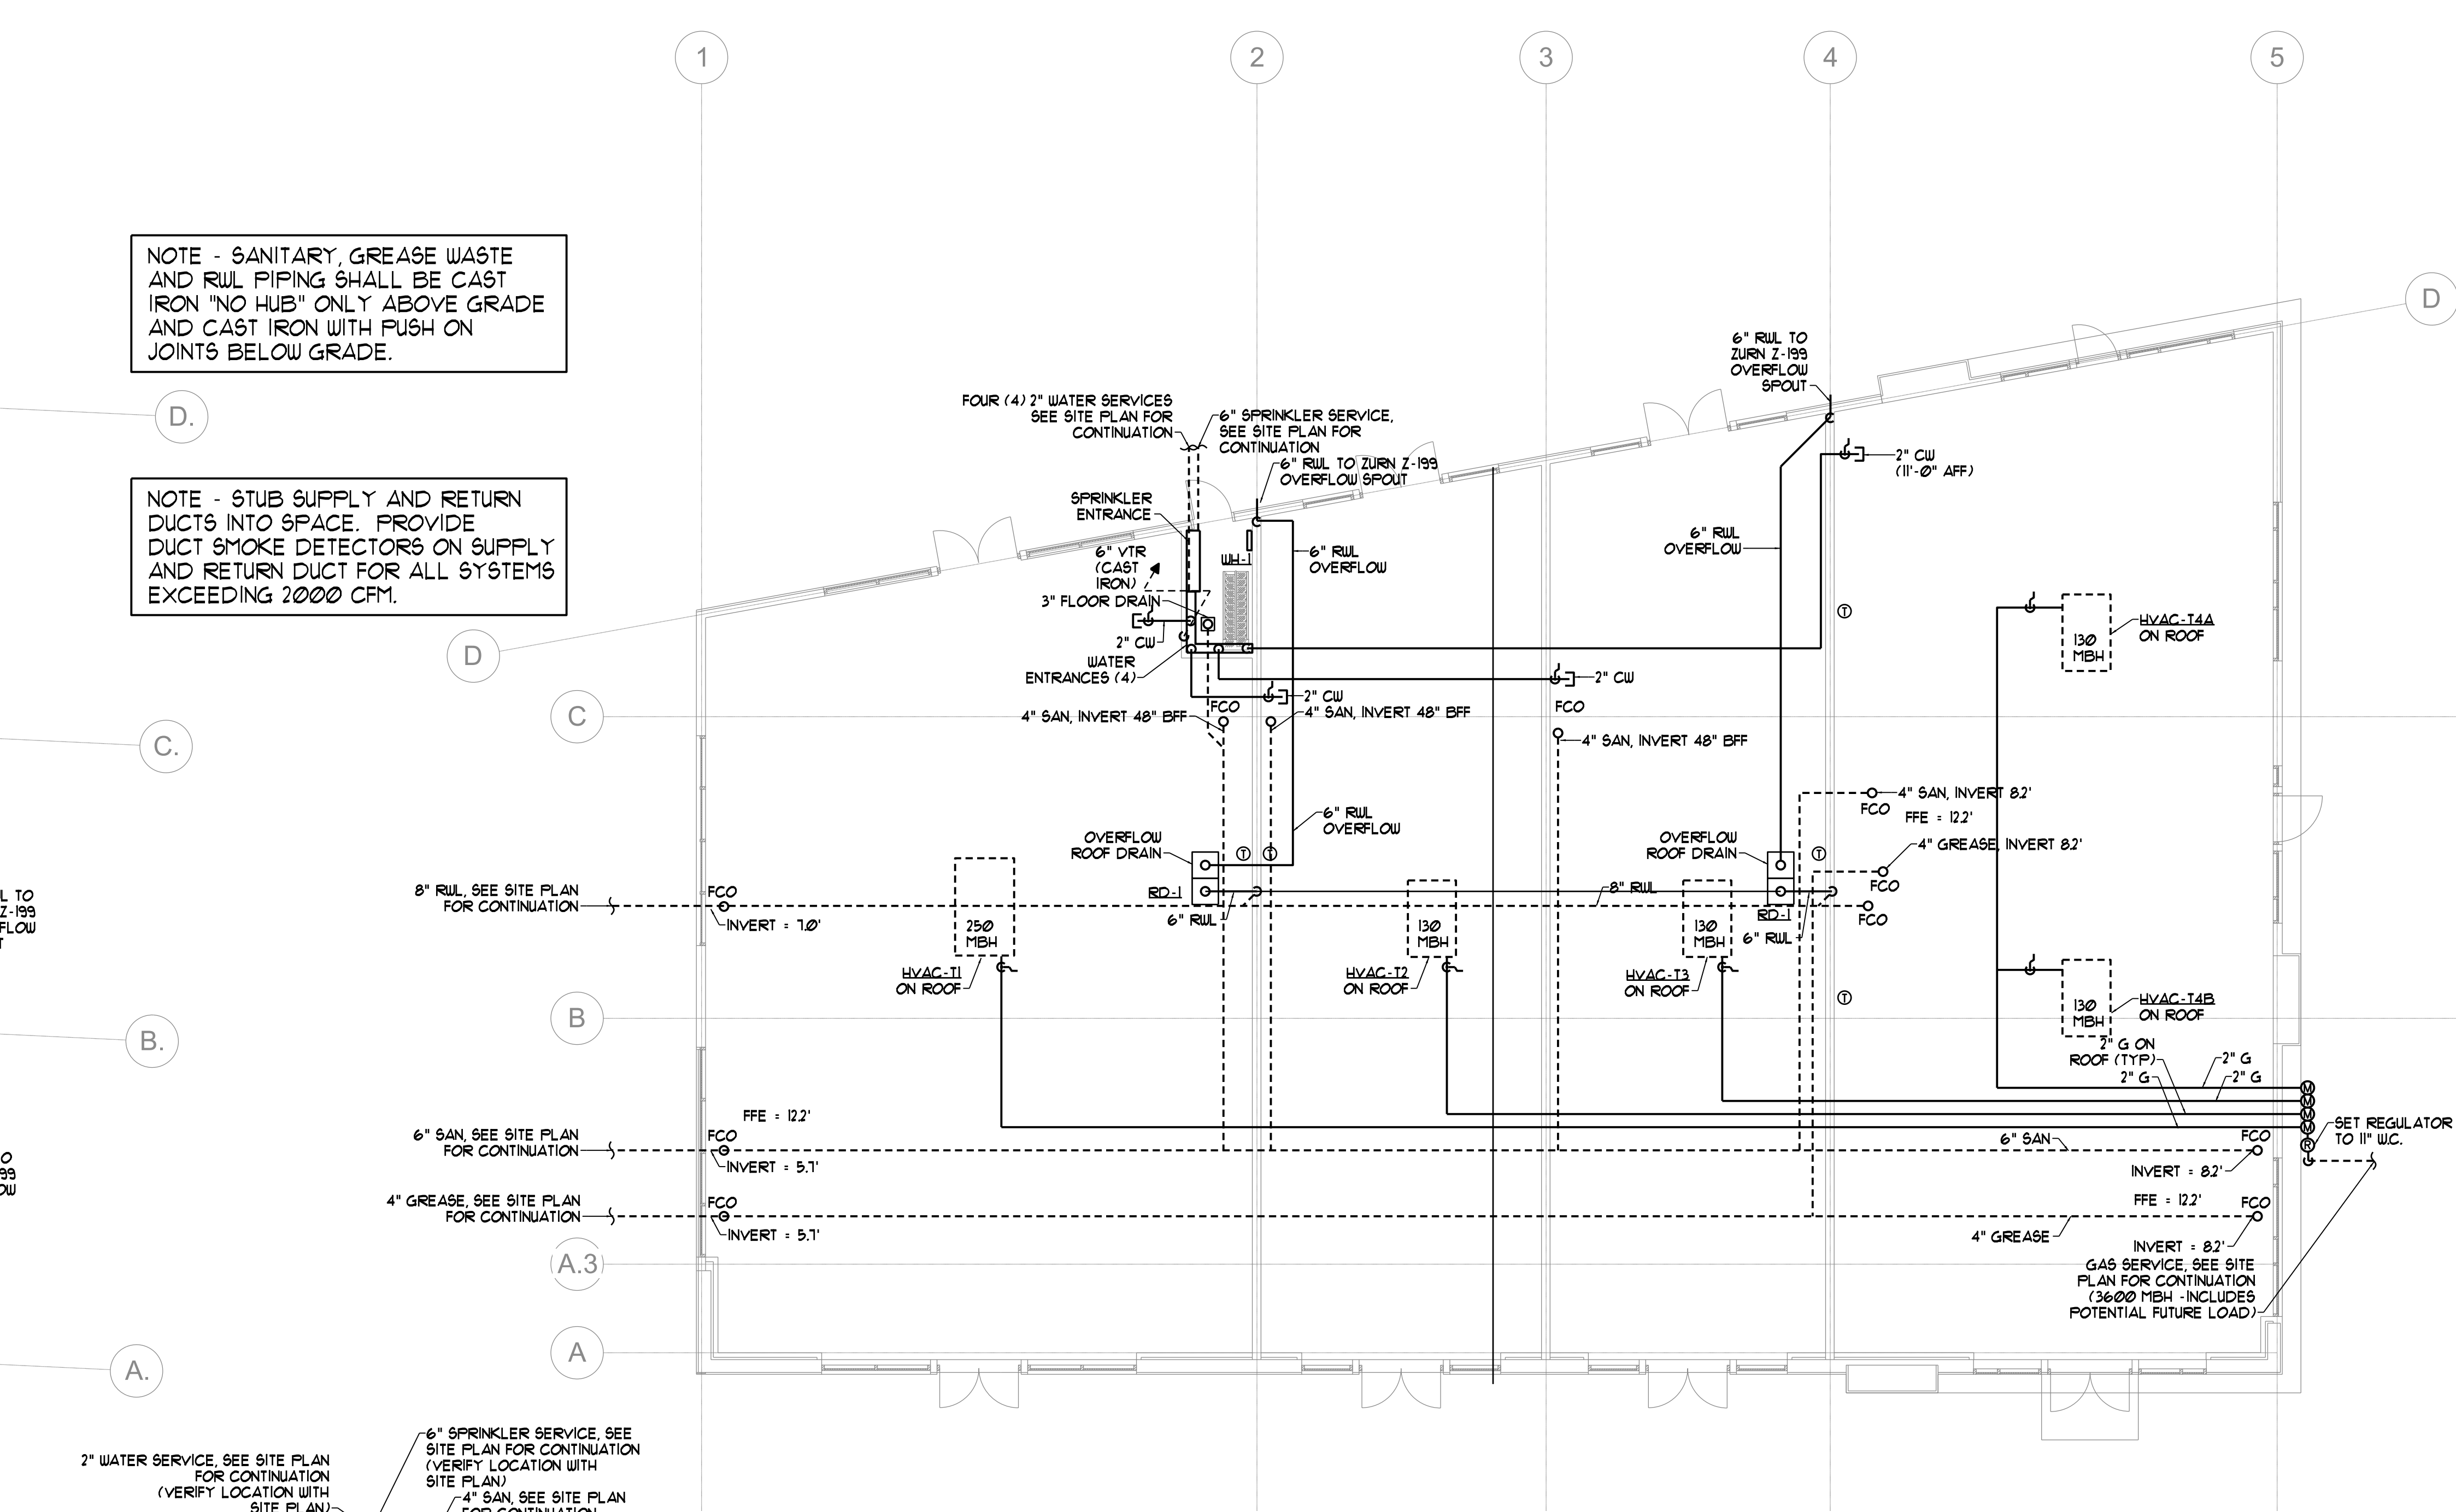

BUILDING B MECHANICAL AND PLUMBING PLAN
SCALE - 1/8" = 1'-0"

BENNETT ENGINEERING MECHANICAL ELECTRICAL 100788248	
Prepared For:	
Consulting Engineer:	
ARCHETYPE architects 48 Union Wharf, Portland, Maine 04101 (207) 772-6022 Fax (207) 772-4056	
Architect:	
CENTURY TIRE PORTLAND, MAINE	
Project:	
Revisions:	
Date:	Scale:
03/16/2015	As Noted
MECHANICAL AND PLUMBING PLAN	
M1.01	