

THIS DRAWING IS AN INSTRUMENT OF SERVICE AND AS SUCH REMAINS THE PROPERTY OF CHIPOTLE MEXICAN GRILL, INC. PERMISSION FOR USE OF THIS DOCUMENT IS LIMITED AND CAN BE EXTENDED ONLY BY WRITTEN AGREEMENT WITH CHIPOTLE MEXICAN GRILL, INC.



CHIPOTLE MEXICAN GRILL, INC.
1401 WYMKOP STREET, SUITE 500
DENVER, CO 80202
TELEPHONE: (303) 595-4000
FAX: (303) 595-4014
INTERNET: WWW.CHIPOTLE.COM

STORE NO.: 2603
PORTLAND MARGINAL WAY
195 KENNEBEC ST
PORTLAND, ME 04101

Issue Record:
09/15/15 PERMIT/LANDLORD REVIEW

Revisions:

Drawn: AJJ Checked: RTJ


Project No.: 1401163

Contents:

Electrical Details

E300


Date of Last Print: 09/15/15

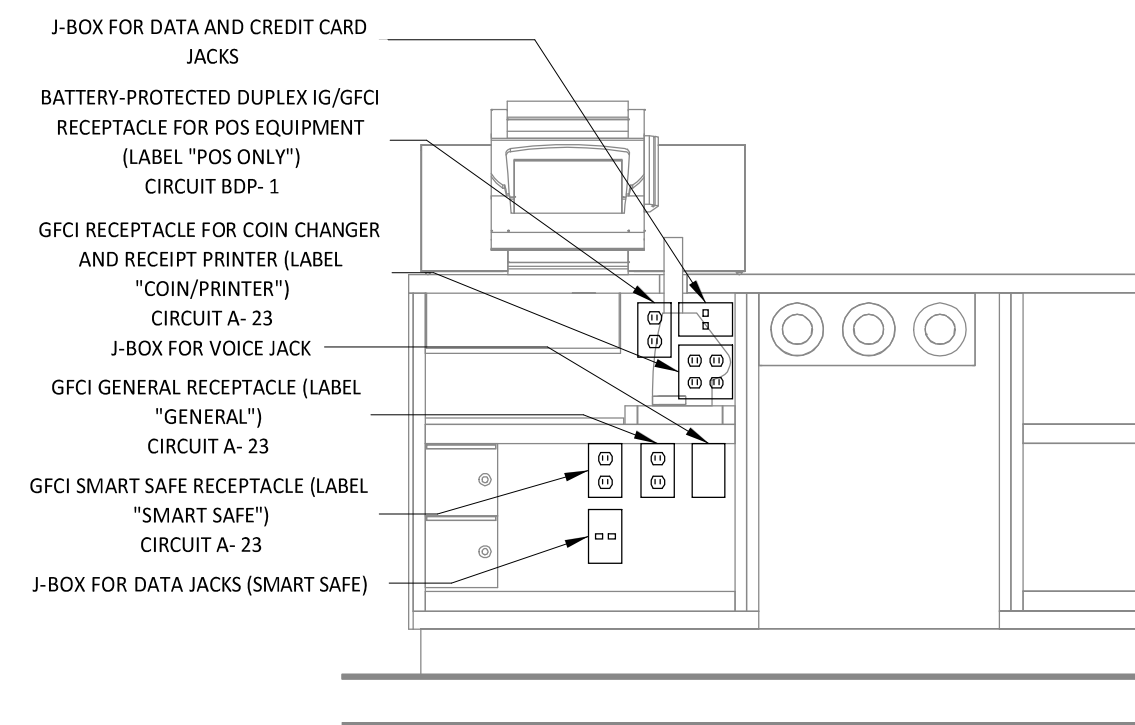


POS COUNTER ELECTRICAL ELEVATION
E300 N.T.S.

CO2 ALARM OPTIONS	
CO2 DETECTOR	X
CO2 REMOTE DISPLAY UNIT	X
REMOTE STROBE	
RELAY	


NOTE: EQUIPMENT SHOWN IS TYPICAL. SEE PLAN FOR ACTUAL EQUIPMENT AND LOCATIONS.

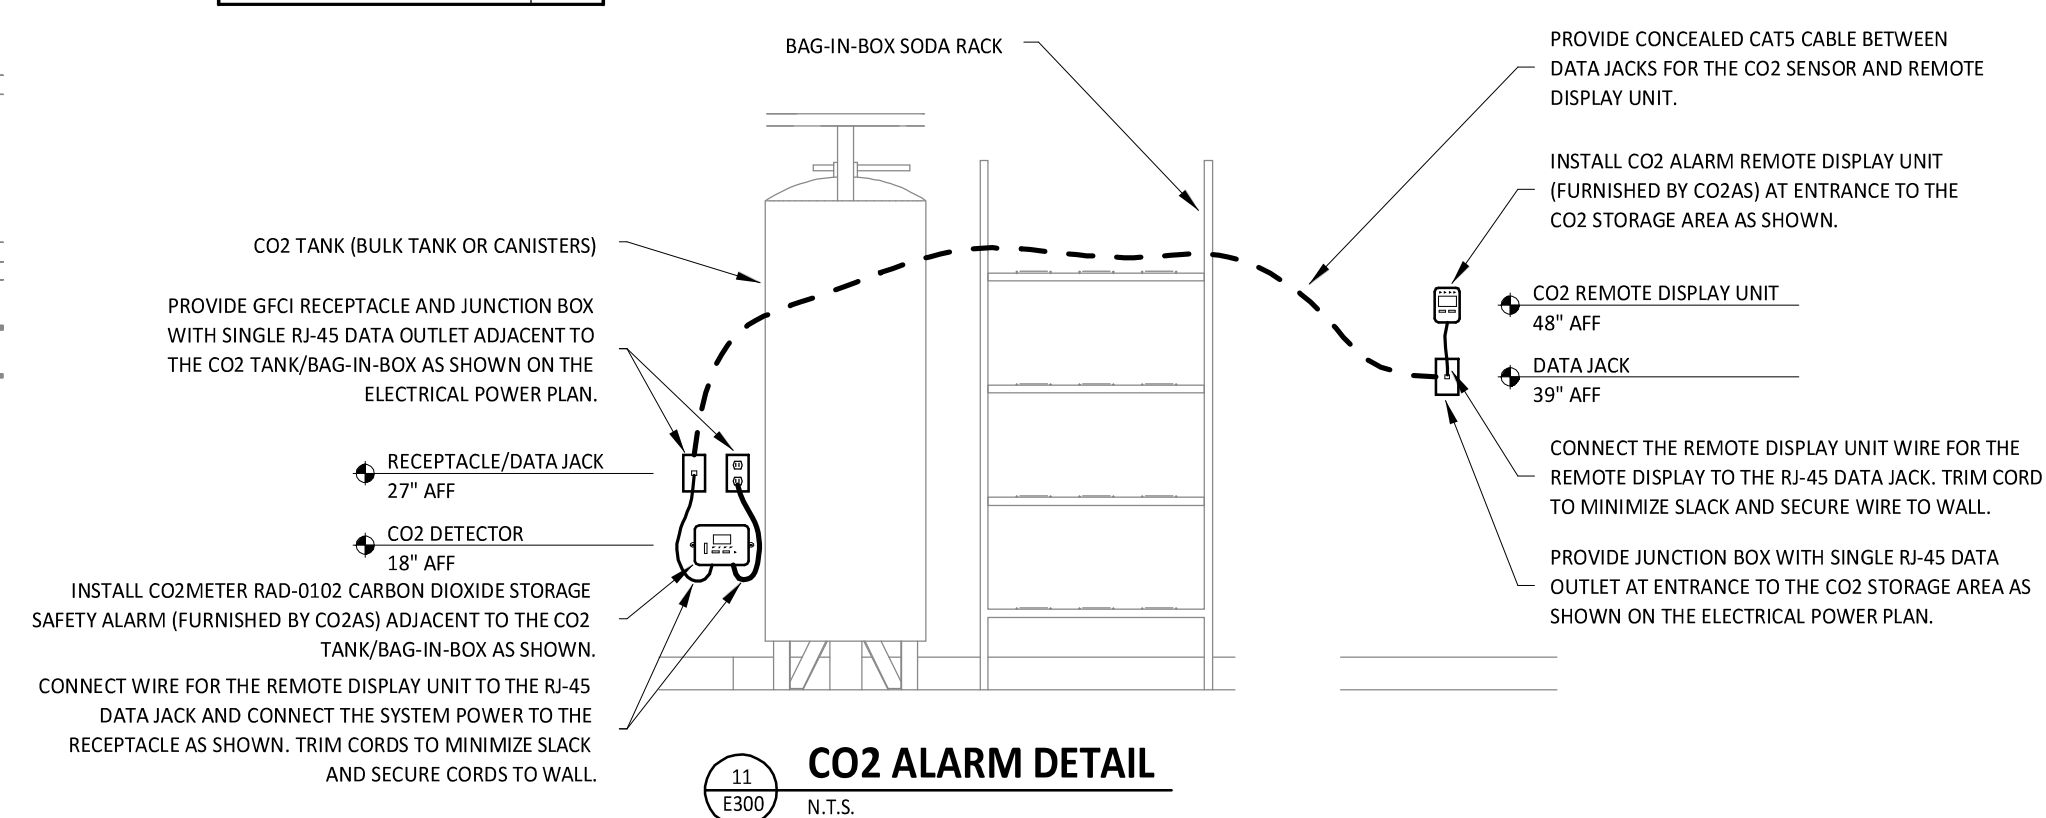


CO2 ALARM DETAIL
E300 N.T.S.

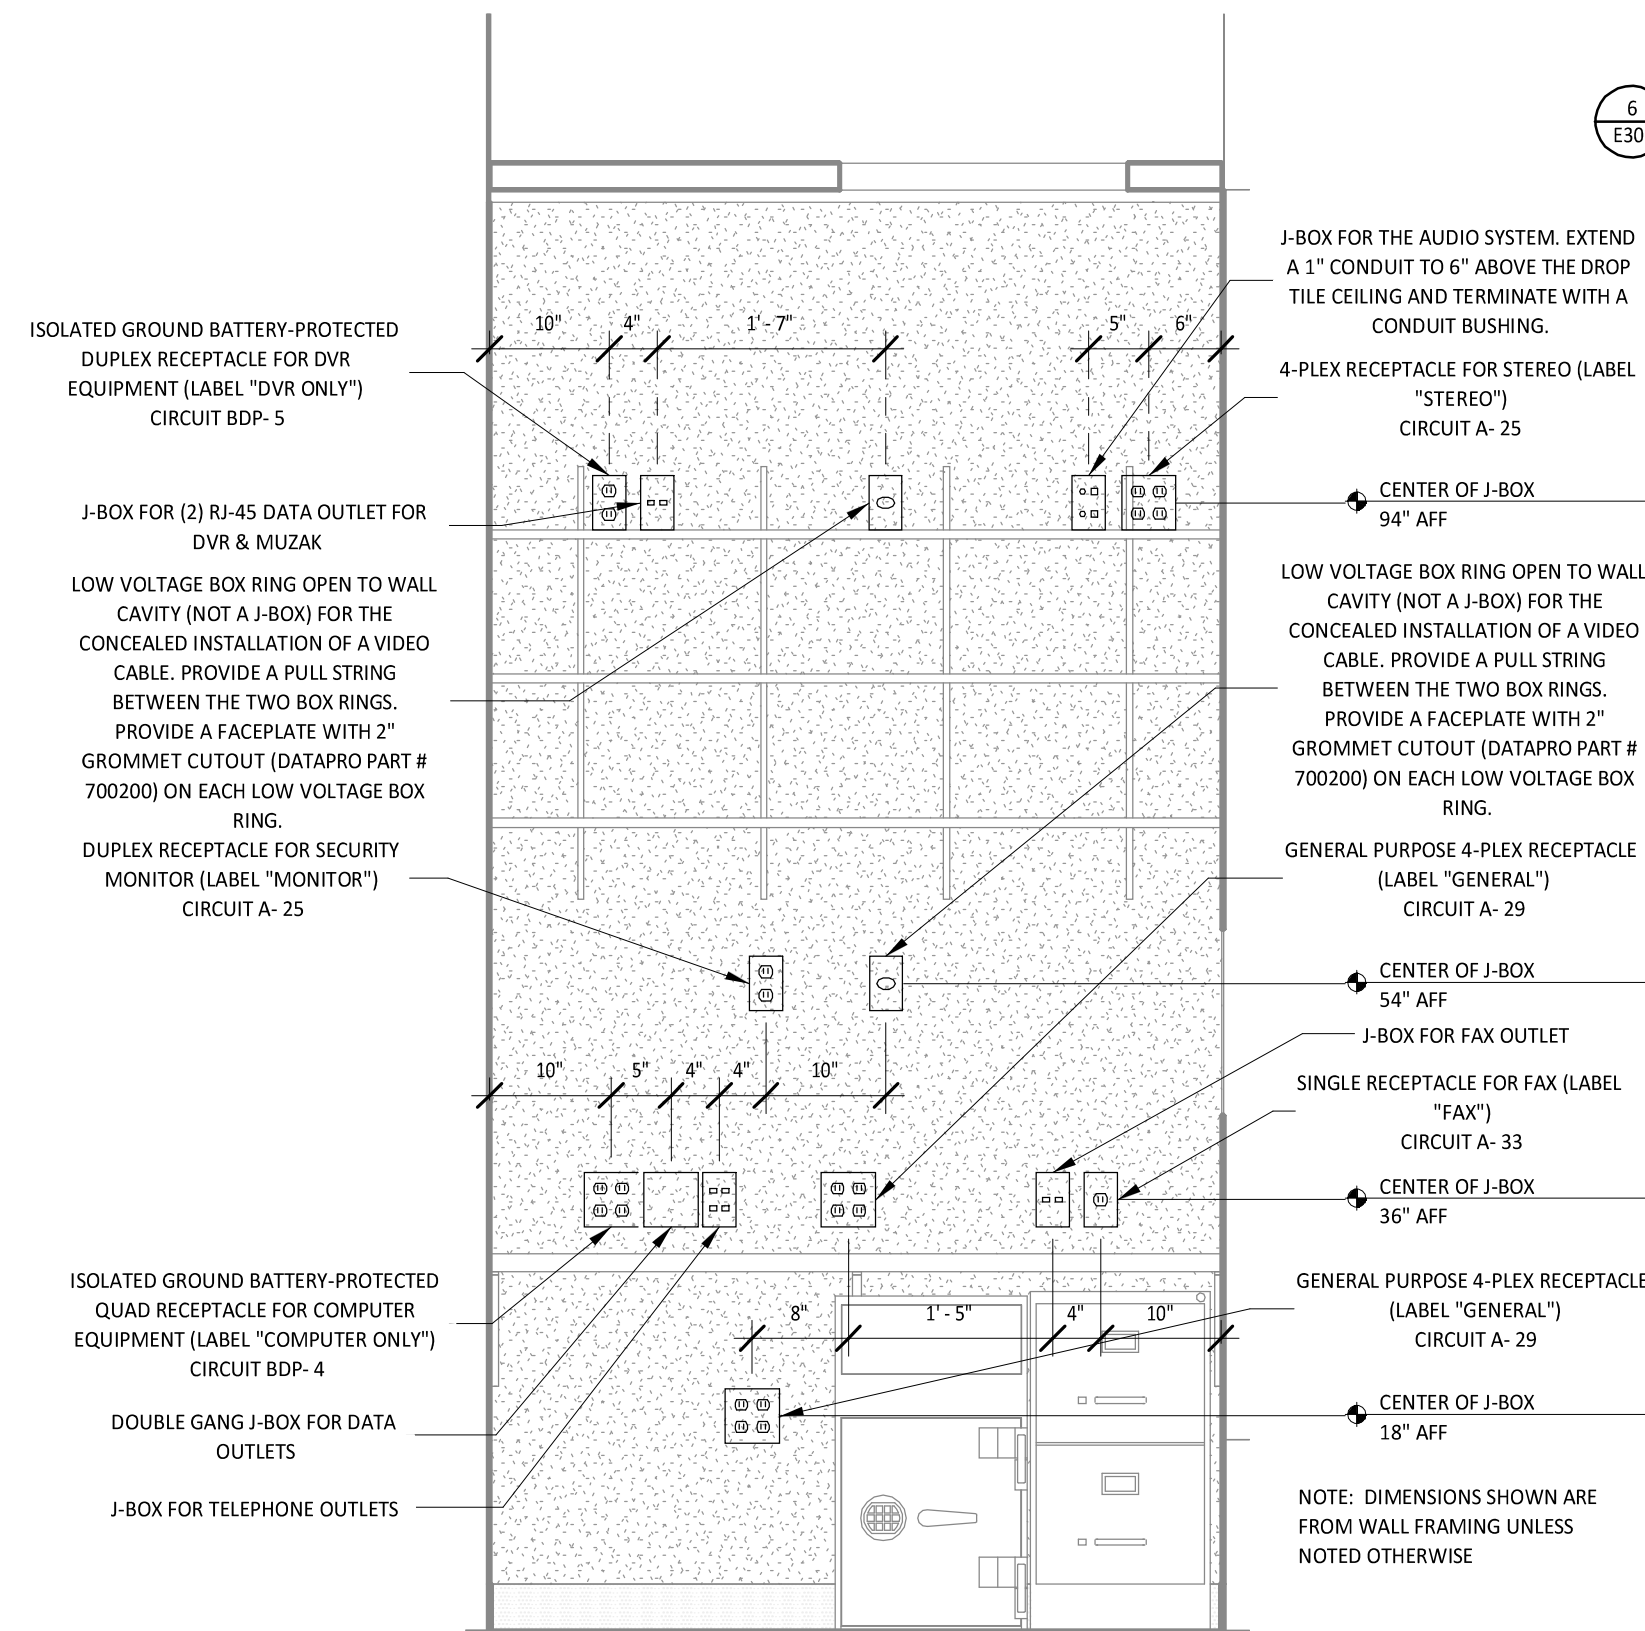


OFFICE DESK ELECTRICAL ELEVATION
E300 N.T.S.

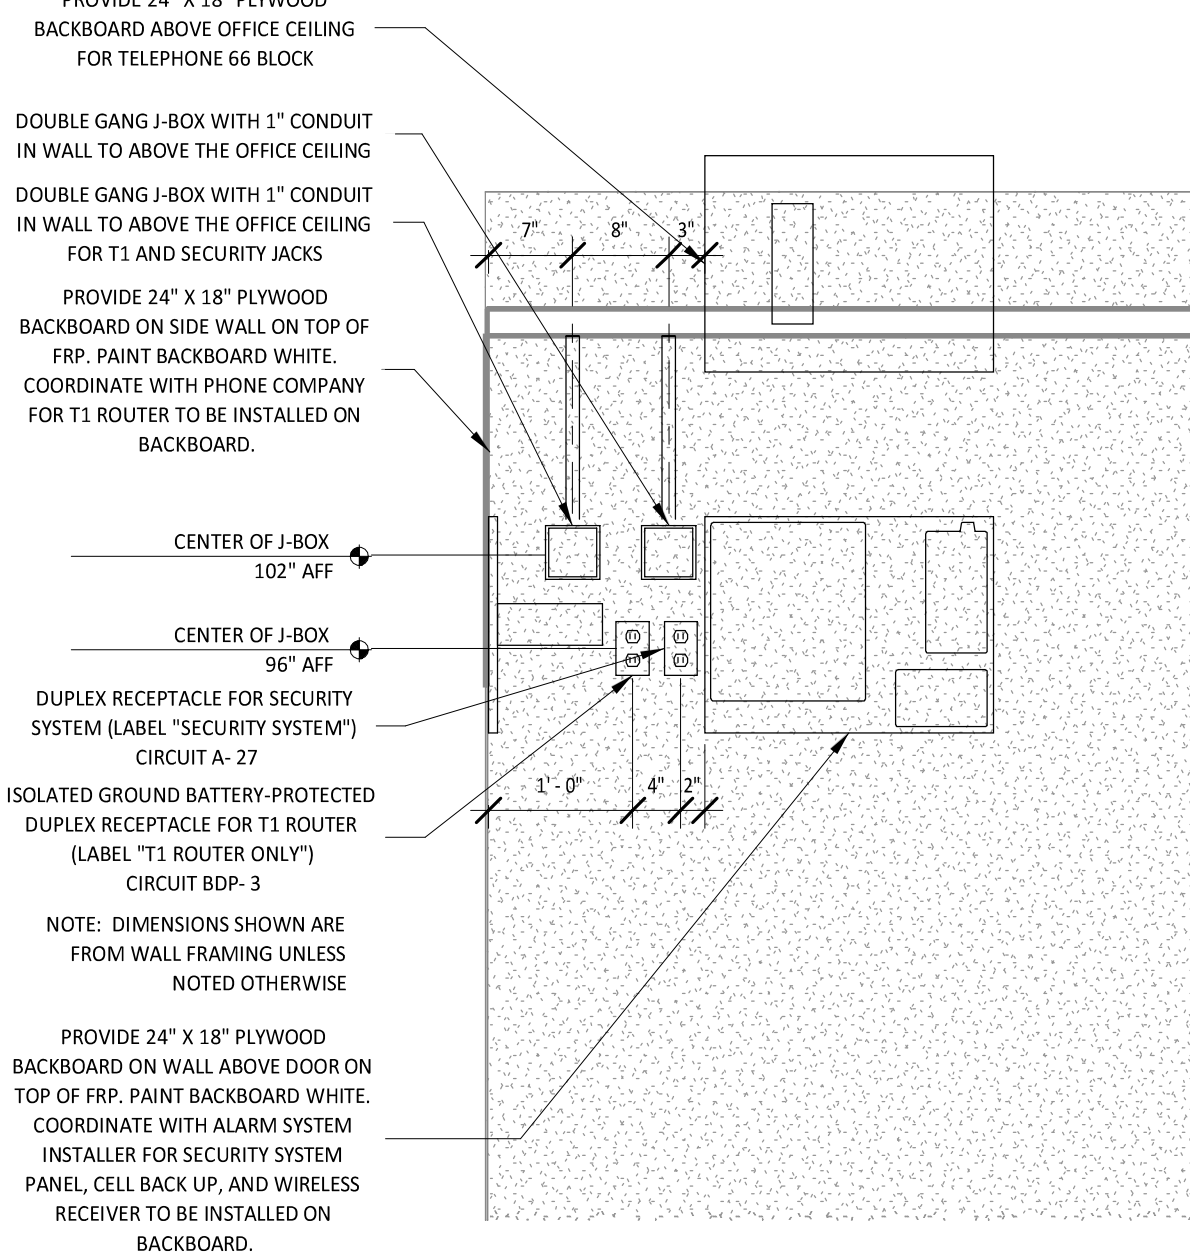


OFFICE EQUIPMENT ELECTRICAL ELEVATION
E300 N.T.S.

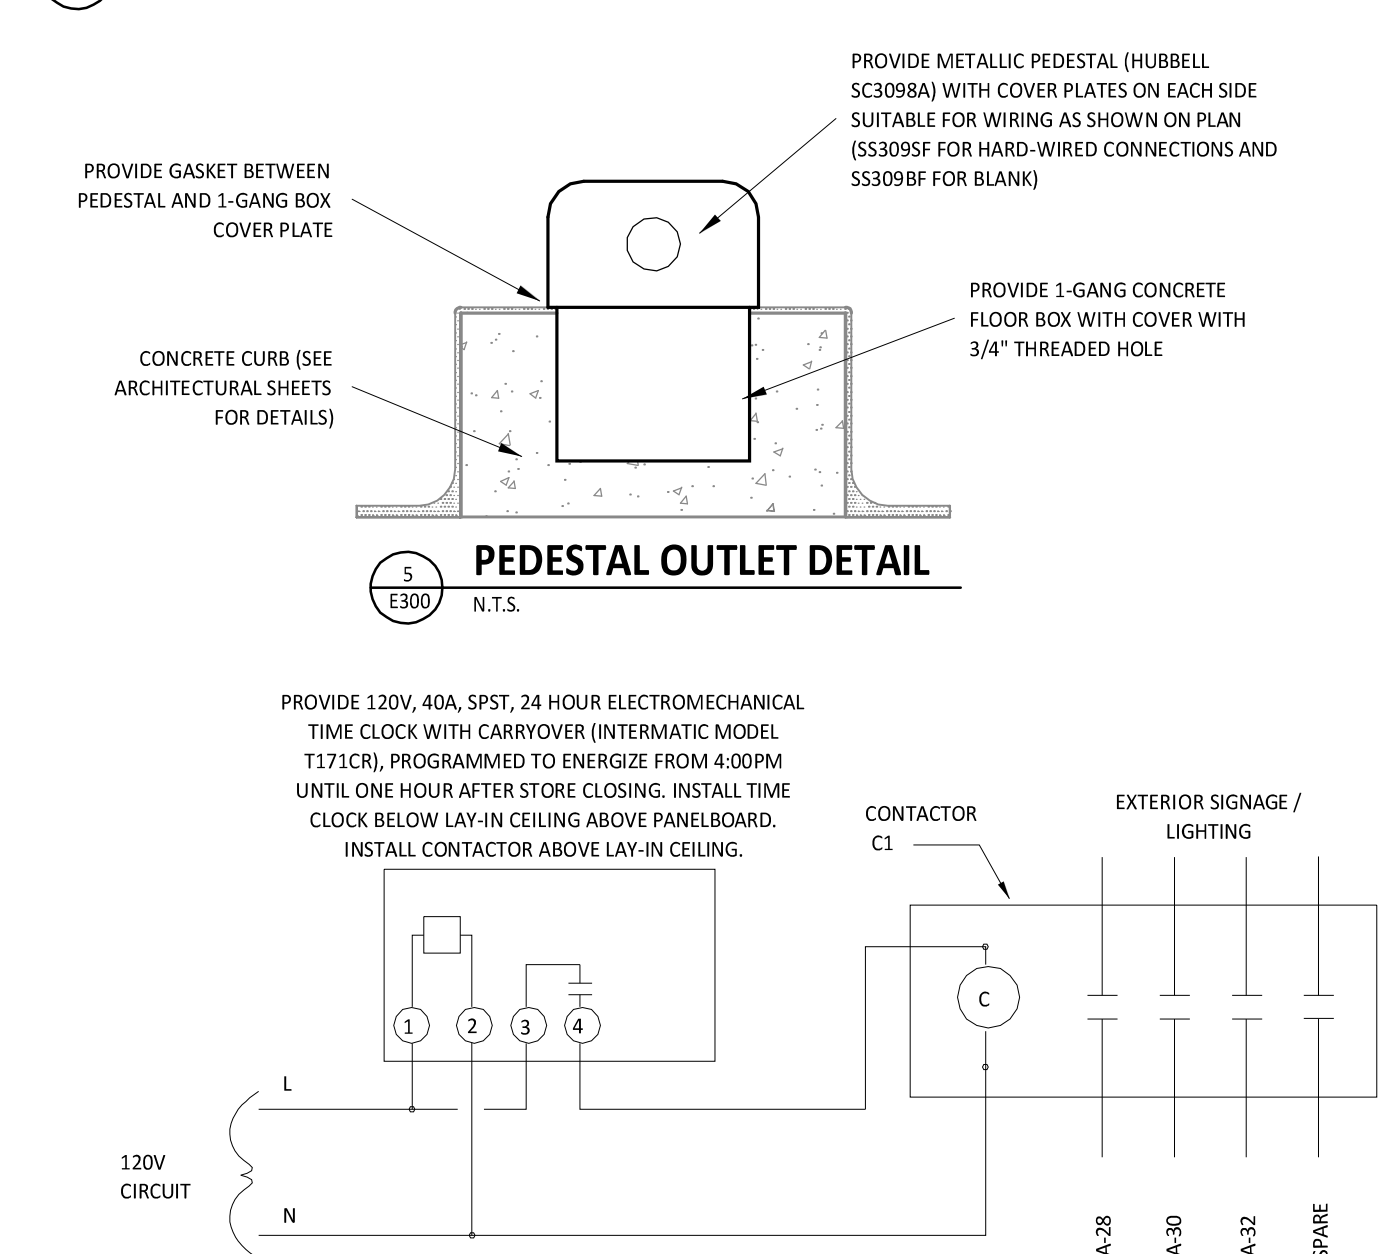


EXTERIOR SIGN LIGHTING CONTROL
E300 N.T.S.

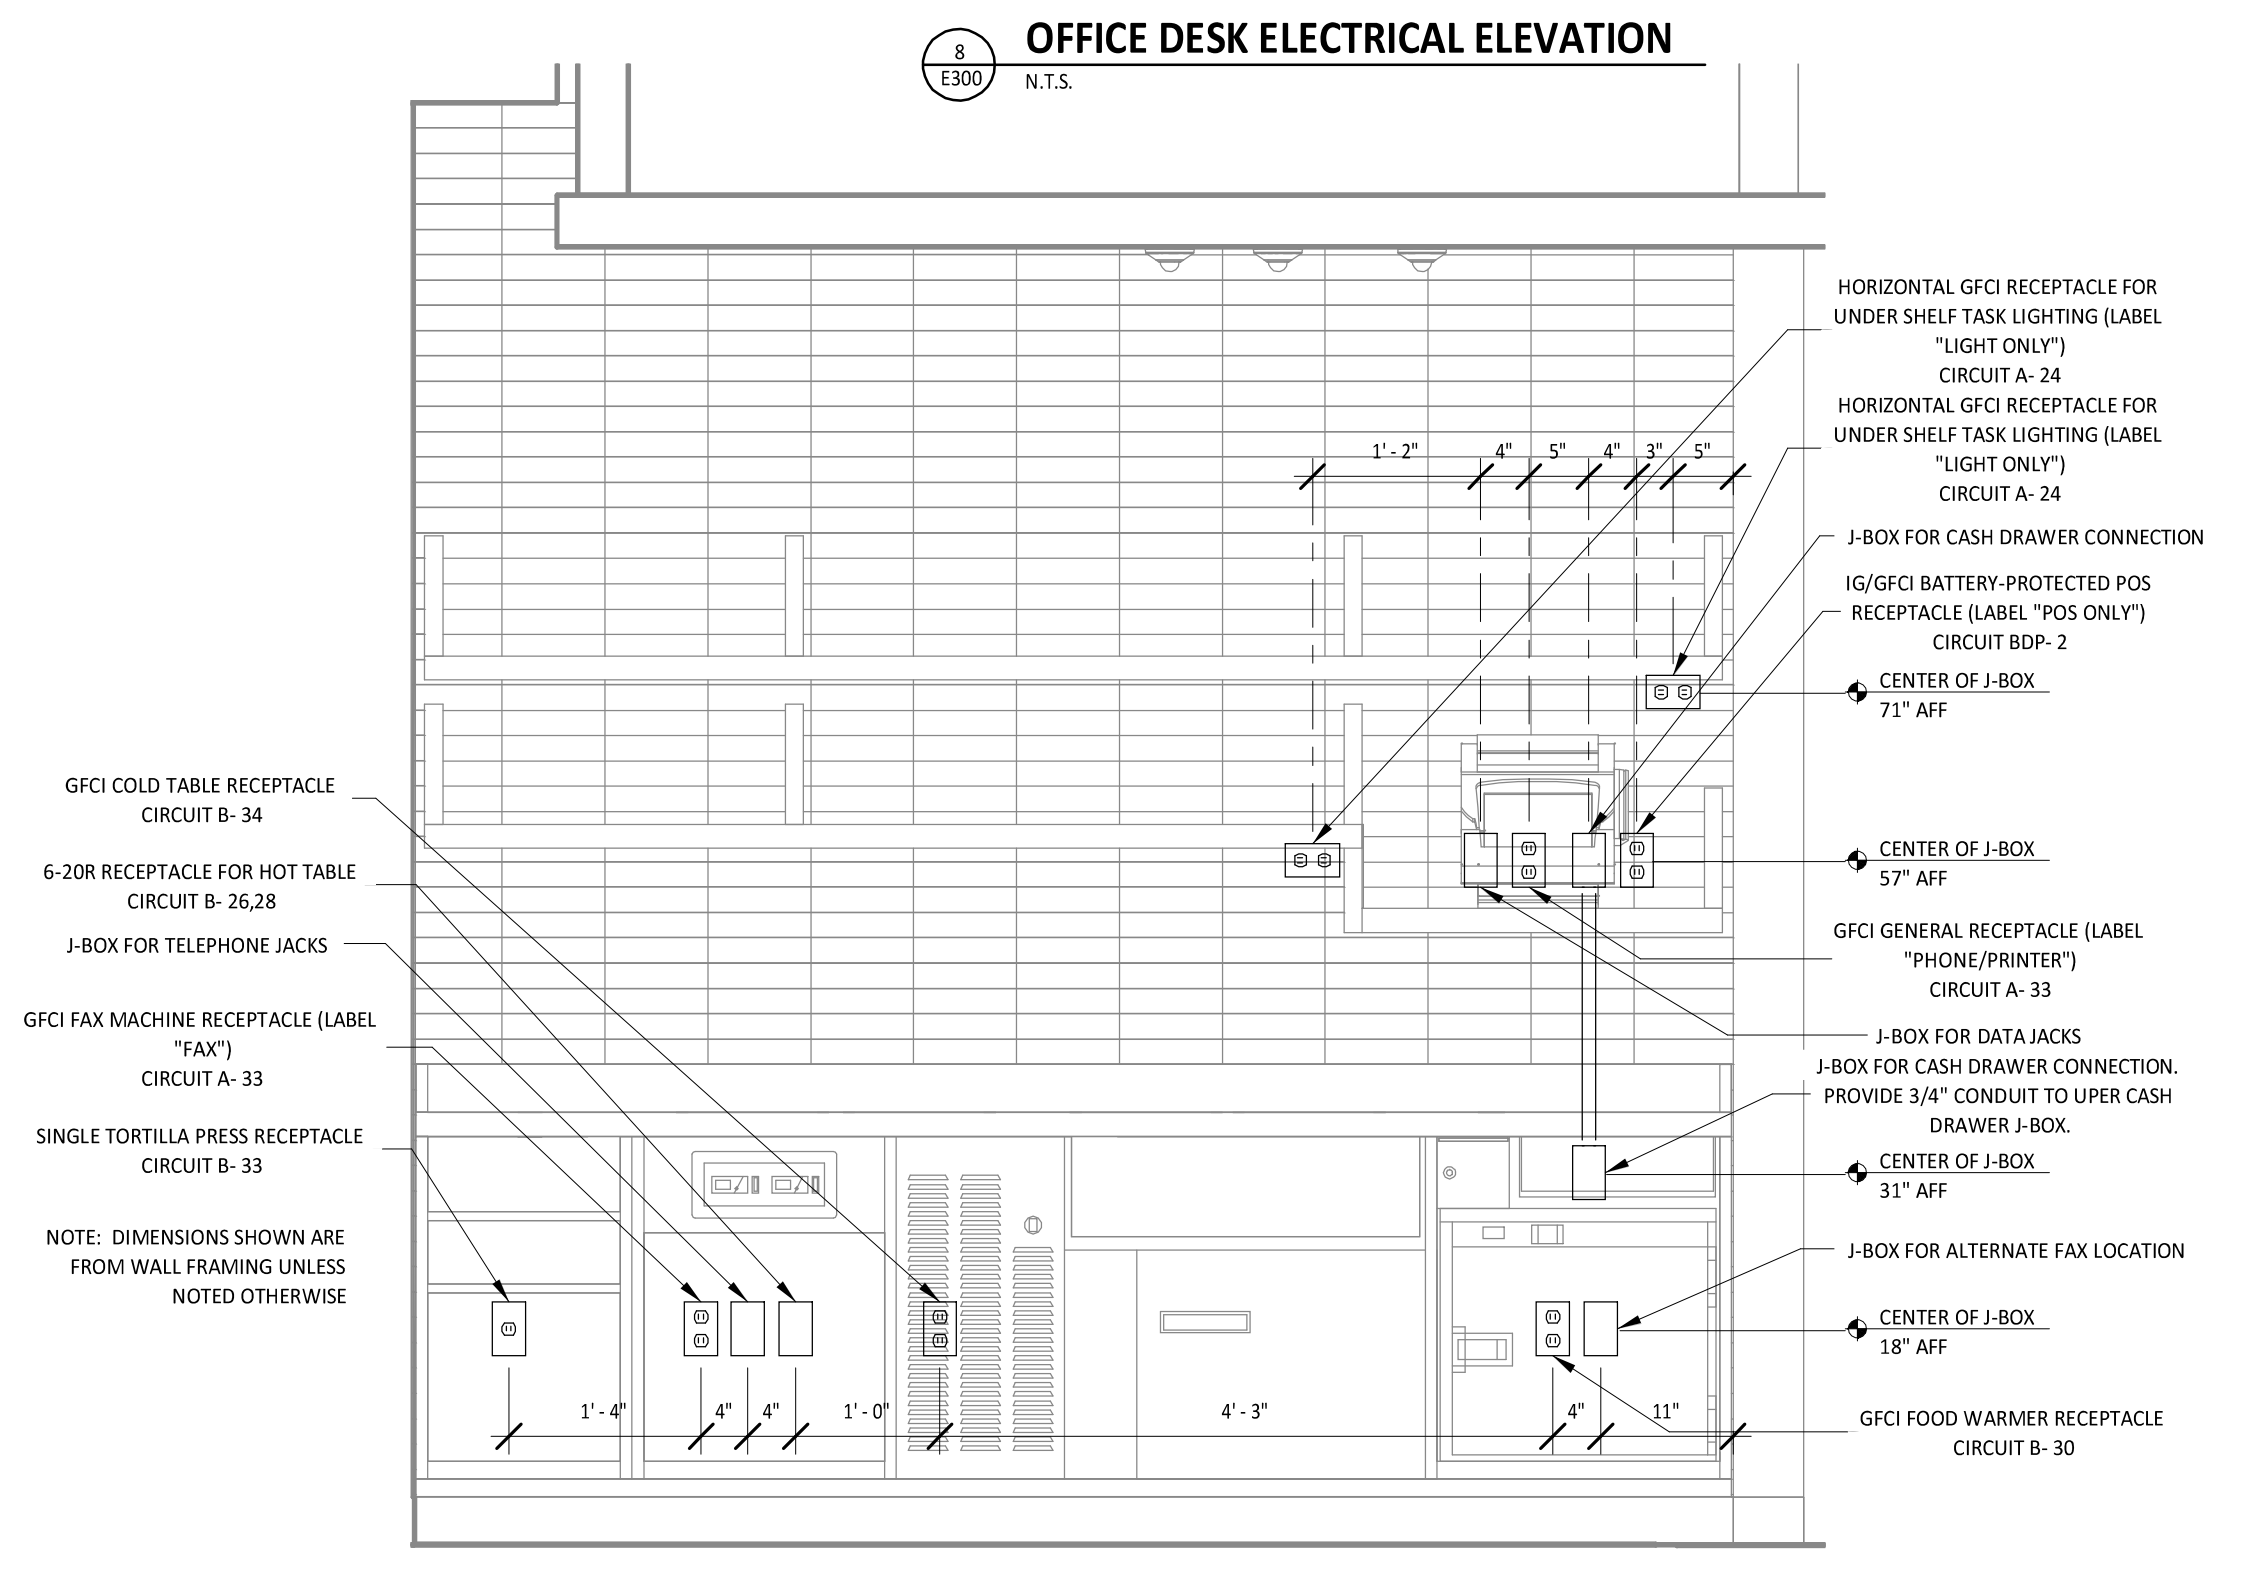

FAX LINE ELECTRICAL ELEVATION
E300 N.T.S.

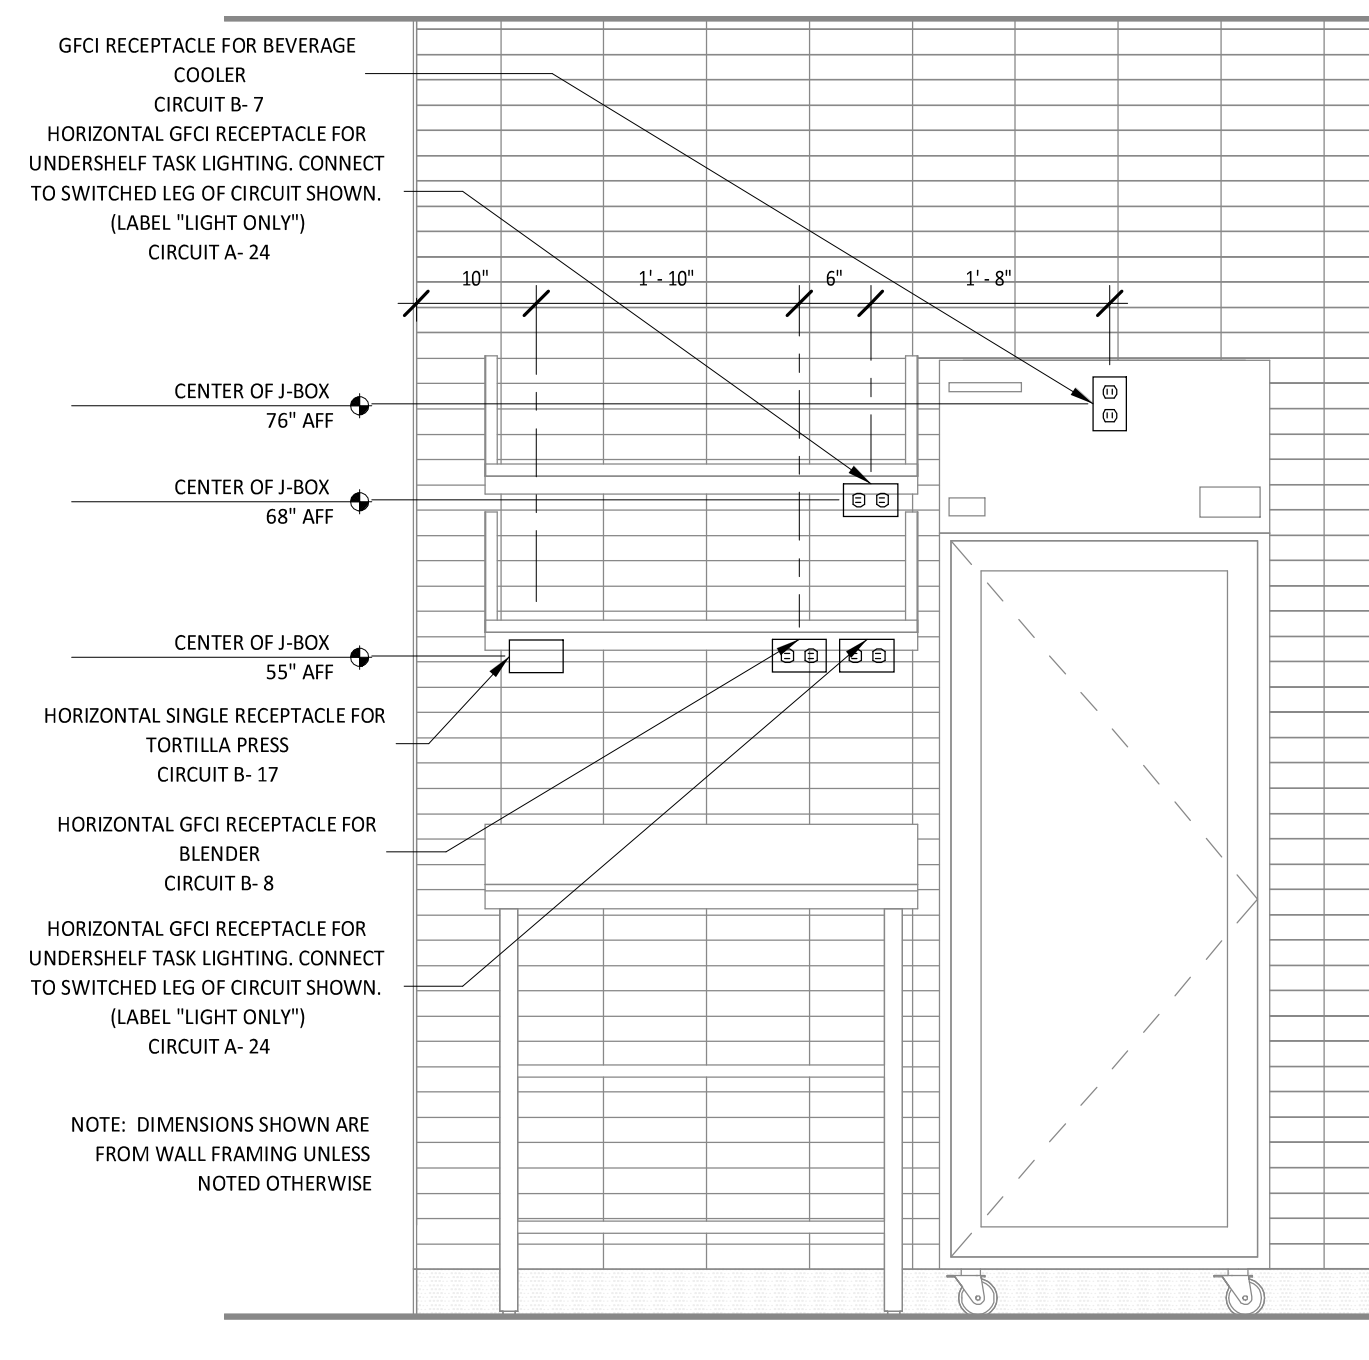

CHIP TABLE ELECTRICAL ELEVATION
E300 N.T.S.

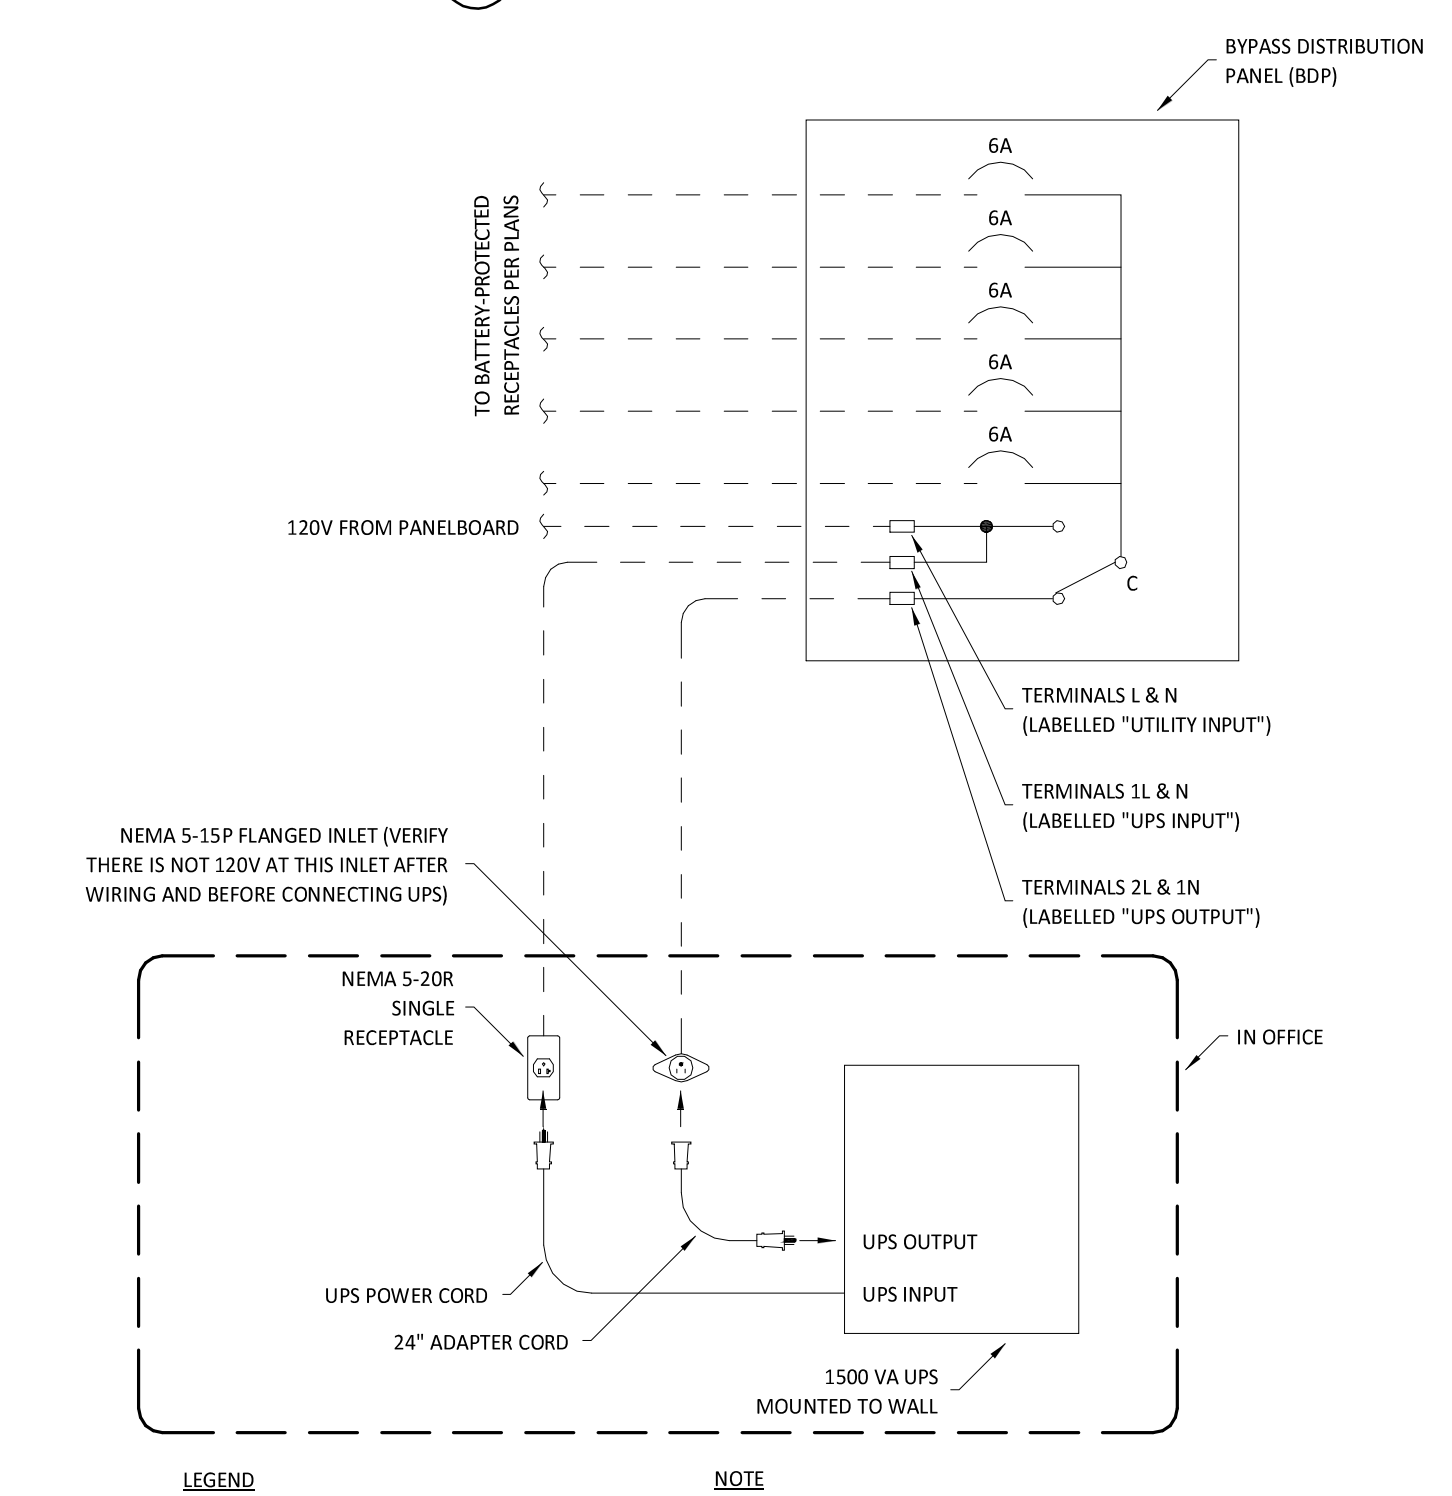

BYPASS DISTRIBUTION PANEL WIRING DIAGRAM
E300 N.T.S.