

MATERIAL SCHEDULE		
CATEGORY	APPLICATION	ALLOWABLE MATERIAL
SPRINKLER HEAD	EXPOSED STRUCTURE CEILING	CHROME UPRIGHT
	PLYWOOD CEILING	BRONZE CONCEALED PENDENT WITH BRASS COVER PLATE
	GYPSUM BOARD CEILING	CHROME RECESSED PENDENT WITH CHROME ESCUTCHEON
	LAY-IN CEILING	CHROME RECESSED PENDENT WITH CHROME ESCUTCHEON
	WALK-IN COOLER	FREEZE-PROOF PENDENT

FIRE PROTECTION SCHEDULE				
ROOM NUM.	DESCRIPTION	CEILING	HEIGHT	HAZARD
100	MAIN ENTRY	GYPSUM BOARD	7'-6"	LIGHT
101	DINING	EXPOSED STRUCTURE	VARIES	LIGHT
102	UTENSIL	EXPOSED STRUCTURE	VARIES	LIGHT
103	PASSAGE	EXPOSED STRUCTURE	VARIES	LIGHT
104	POS	GYPSUM BOARD	9'-0"	ORD. HAZ. 1
105	ORDERING	EXPOSED STRUCTURE	VARIES	LIGHT
106	SERVING	GYPSUM BOARD	9'-0"	ORD. HAZ. 1
107	COOKING	GYPSUM BOARD	9'-0"	ORD. HAZ. 1
108	KITCHEN	LAY-IN	10'-0"	ORD. HAZ. 1
109	CLOFFICE	LAY-IN	10'-0"	ORD. HAZ. 1
110	COOLER	INTEGRAL	9'-4"	ORD. HAZ. 1
111	MENS	GYPSUM BOARD	7'-2"	LIGHT
112	WOMENS	GYPSUM BOARD	7'-2"	LIGHT

**FIRE PROTECTION SCHEDULE NOTES**


- A CEILING HEIGHT SHOWN IS APPROXIMATE. SEE ARCHITECTURAL REFLECTED CEILING PLAN FOR EXACT CEILING HEIGHT.

**FIRE PROTECTION GENERAL NOTES**


- A FIRE PROTECTION WORK SHALL BE DONE IN ACCORDANCE WITH THE BUILDING CODE, NFPA, LOCAL FIRE DEPARTMENT STANDARDS, AND THE AUTHORITY HAVING JURISDICTION. SEE SHEET A000 FOR THE PREVAILING CODES.
- B MODIFY THE EXISTING HEAD LAYOUT AND FIRE ALARM SYSTEM IN THE SPACES SHOWN TO SUIT THE NEW FLOOR PLAN. PROVIDE NEW HEADS AND DEVICES AS NECESSARY FOR A COMPLETE SYSTEM. PROVIDE HYDRAULIC CALCULATIONS FOR REVISED FIRE PROTECTION SYSTEM.
- C COORDINATE HEAD LAYOUT WITH EXPOSED DUCTWORK, LIGHT FIXTURES, HVAC EQUIPMENT, AND ARCHITECTURAL CEILING ELEMENTS. SEE ARCHITECTURAL REFLECTED CEILING PLAN FOR LOCATIONS. PROVIDE HEADS IN LAY-IN CEILINGS AT QUARTER POINTS ALONG LONG AXIS OF CEILING TILES. SUBMIT HEAD LAYOUT SHOP DRAWINGS TO ARCHITECT PRIOR TO SUBMITTING FOR PERMIT APPROVAL.
- D OBTAIN PERMITS, APPROVALS, AND INSPECTIONS FOR REVISED FIRE PROTECTION AND ALARM SYSTEMS.
- E CEILING HEIGHTS AND CEILING FIXTURE PLACEMENTS SHOWN ARE APPROXIMATE. SEE ARCHITECTURAL RCP FOR EXACT CEILING HEIGHTS AND CEILING FIXTURE DIMENSIONS.
- F THE TERM "FURNISH" MEANS SUPPLY AND DELIVER TO THE PROJECT SITE, READY FOR UNLOADING, UNPACKING, ASSEMBLY, INSTALLATION, AND SIMILAR OPERATIONS. THE TERM "INSTALL" DESCRIBES THE OPERATIONS AT THE PROJECT SITE INCLUDING THE ACTUAL UNLOADING, UNPACKING, ASSEMBLY, ERECTING, PLACING, ANCHORING, APPLYING, WORKING TO DIMENSION, FINISHING, CURING, PROTECTING, CLEANING, AND SIMILAR OPERATIONS. THE TERM "PROVIDE" MEANS TO FURNISH AND INSTALL, COMPLETE AND READY FOR THE INTENDED USE.

**FOR REFERENCE ONLY:  
FIRE PROTECTION AND ALARM  
SYSTEMS ARE TO BE DESIGNED BY THE  
GENERAL CONTRACTOR**

APPROXIMATELY 2,200 SF

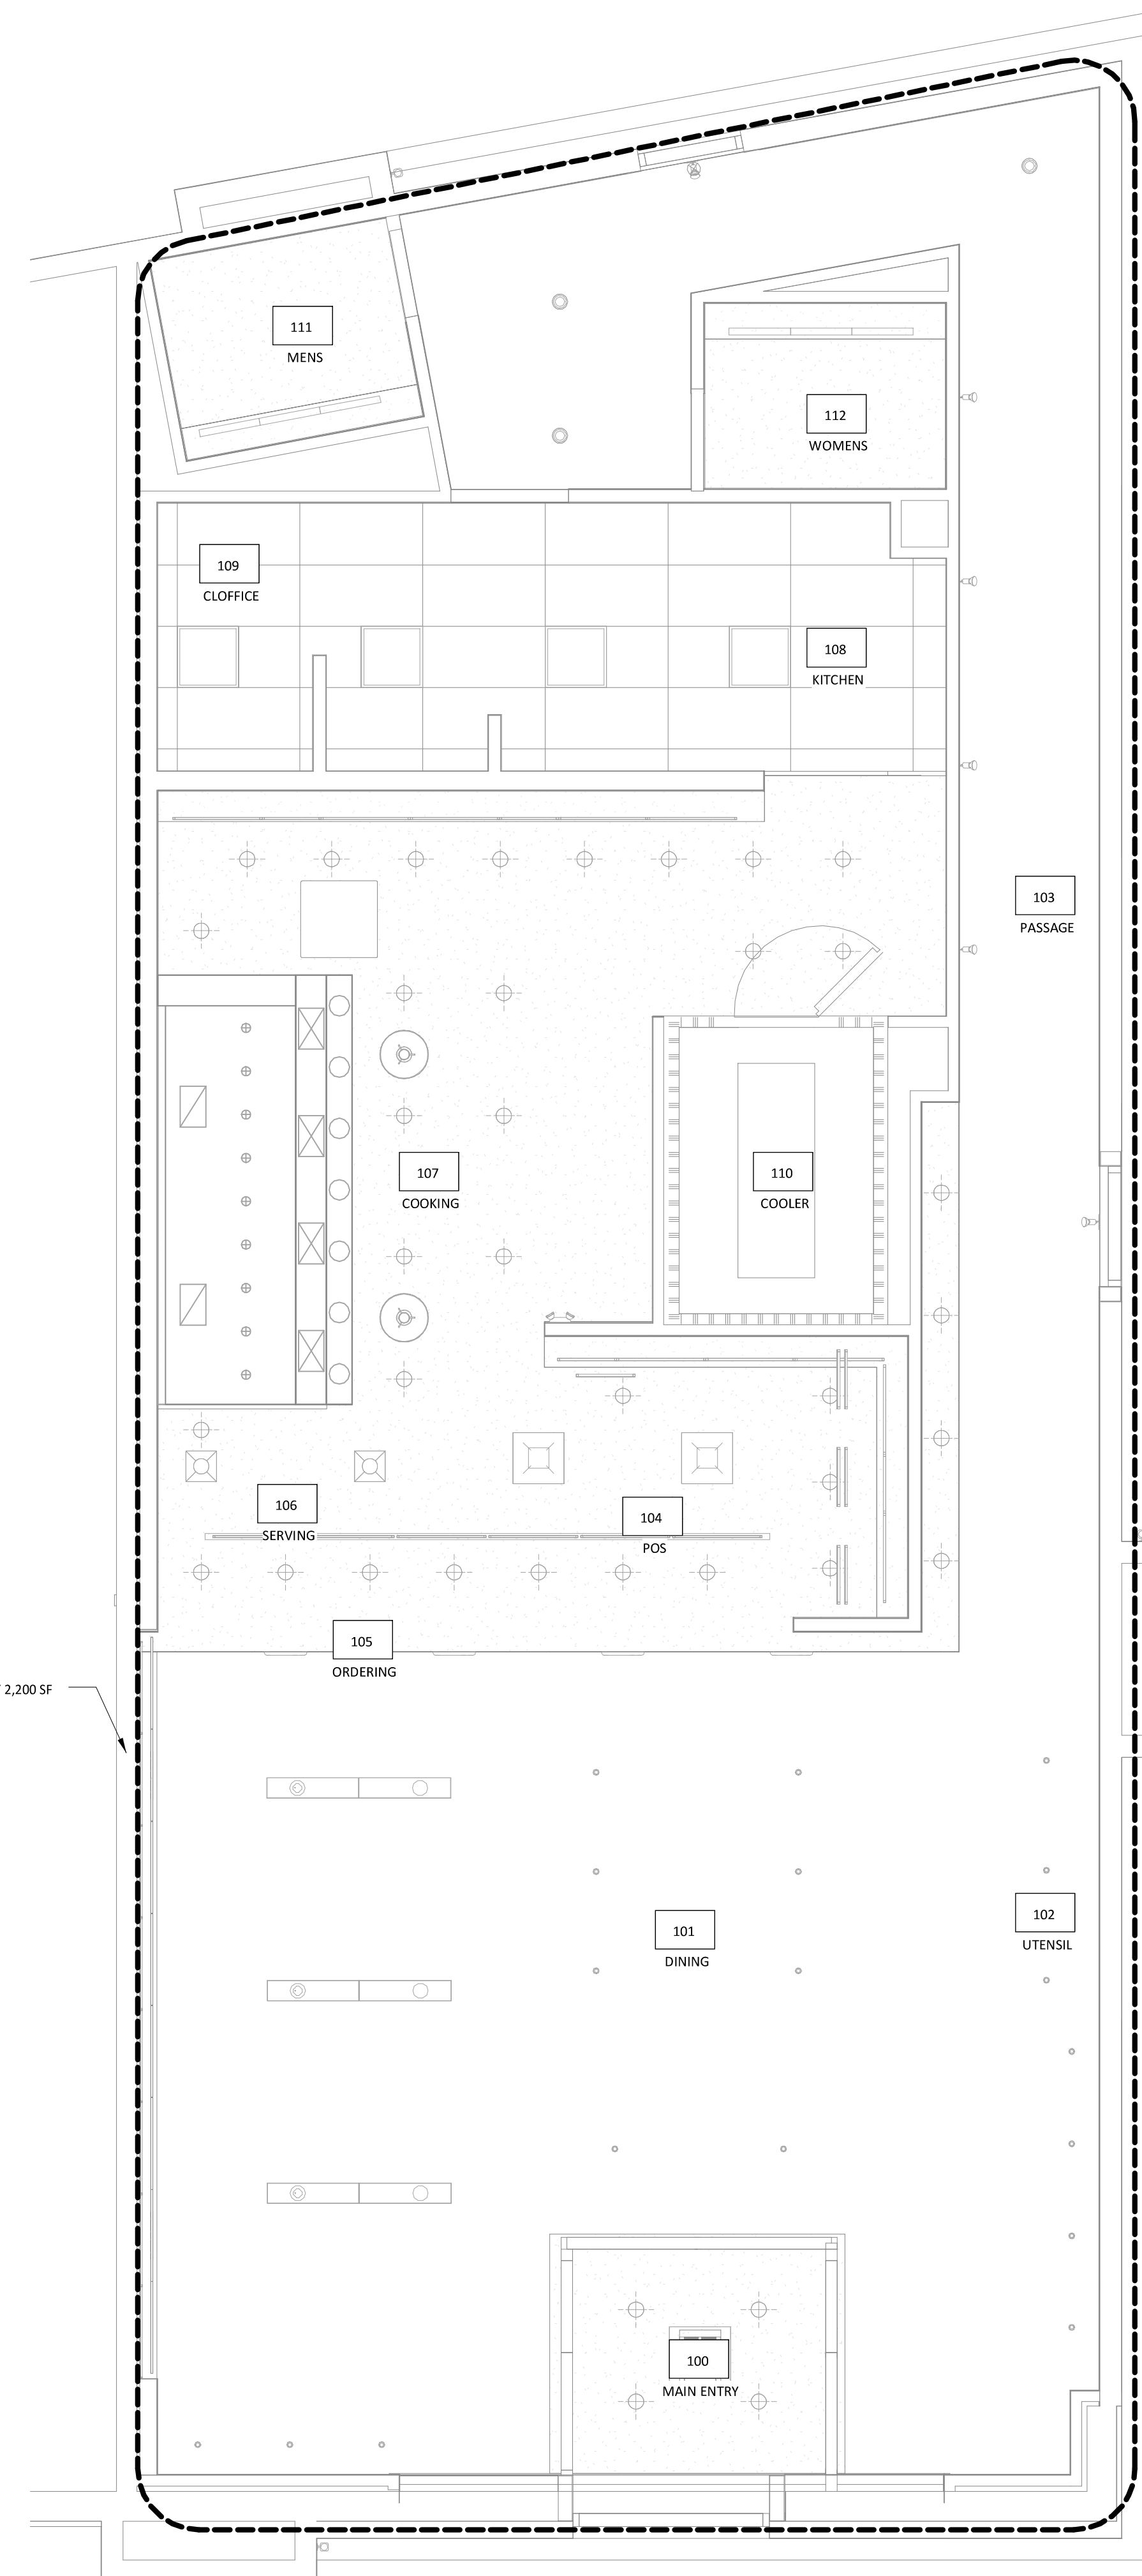

788 Morrison Road  
Columbus, Ohio 43230  
Phone: (614) 751-9610  
Fax: (614) 552-5240  
Contact: Andrew Janosik  
(614) 328-2028  
ajanosik@nationalengineering.com

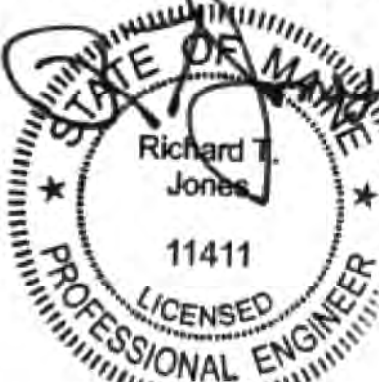

COPYRIGHT 2015  
THIS DRAWING IS AN INSTRUMENT OF SERVICE AND AS SUCH  
REMAINS THE PROPERTY OF CHIPOTLE MEXICAN GRILL, INC.  
PERMISSION FOR USE OF THIS DOCUMENT IS LIMITED AND  
CAN BE EXTENDED ONLY BY WRITTEN AGREEMENT WITH  
CHIPOTLE MEXICAN GRILL, INC.



CHIPOTLE MEXICAN GRILL, INC.  
1401 WYNNCOOP STREET, SUITE 500  
DENVER, CO 80202  
TELEPHONE: (303) 595-4000  
FAX: (303) 595-4014  
INTERNET: WWW.CHIPOTLE.COM

STORE NO.: 2603  
PORTLAND MARGINAL WAY  
195 KENNEBEC ST  
PORTLAND, ME 04101

Issue Record:  
09/15/15 PERMIT/LANDLORD REVIEW

Revisions:

Drawn: AJJ  
Checked: RTJ

Project No.  
1401163

Contents:  
Fire Protection Plan

F100

Date of Last Print:  
09/15/15