


4575

TPRit

These drawings and specifications are copyrighted and subject to copyright protection as an "architectural work" under sec. 102 of the copyright act, 17 U.S.C. As amended January 2003. The protection includes, without limitation, the overall form, arrangement and composition of spaces, and elements of the design. Under such protection, unauthorized use of these drawings and specifications may result in cessation of construction, building seizure, and/or monetary liability.

**T-Mobile**  
 12020 SE 36th STREET, 4TH FLOOR  
 BELLEVUE, WA 98006  
 www.t-mobile.com  
**MARGINAL WAY & FOREST AVENUE**  
 195 KENNEBEC ST BLDG B  
 SUITE 2  
 PORTLAND, MAINE 04101

REFLECTED CEILING PLAN

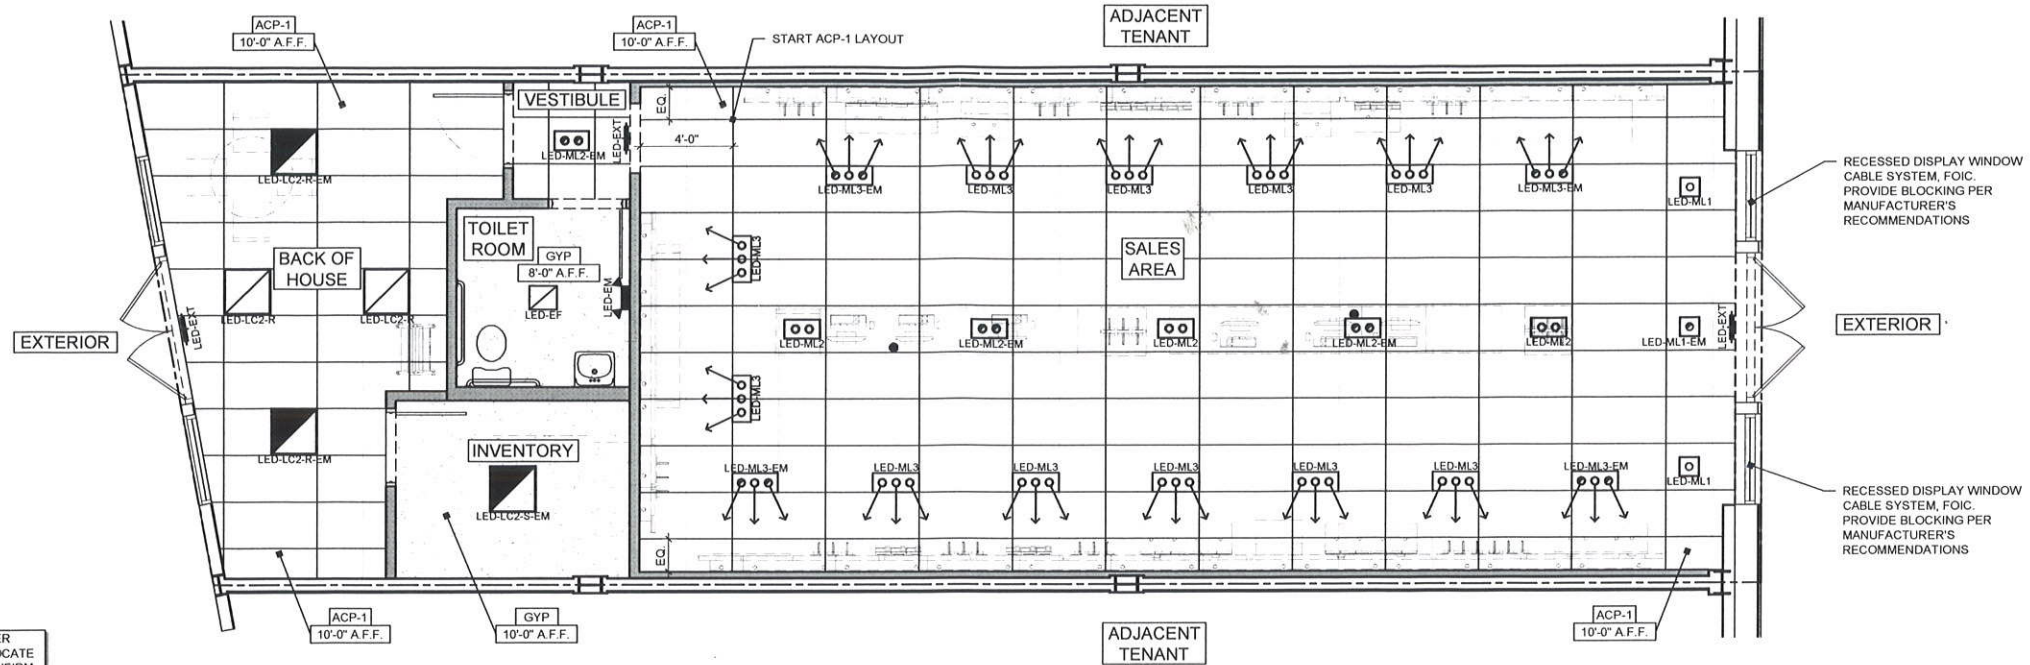

GC TO CONTACT ARMSTRONG WORLD INDUSTRIES CUSTOMER SERVICE REP FOR T-MOBILE PREFERRED PRICING AND TO LOCATE LOCAL DISTRIBUTOR OF ARMSTRONG PRODUCTS. GC TO CONFIRM WITH LOCAL DISTRIBUTOR ORDER IS FOR T-MOBILE PROJECT:  
 CONTACT SHERRY BRUNT OR BETH RINEHART  
 CUSTOMER SERVICE REPRESENTATIVES  
 ARMSTRONG WORLD INDUSTRIES, INC.  
 PO BOX 3001  
 LANCASTER, PA 17604  
 PHONE: 800-442-4212  
 FAX: 800-233-5598  
 EMAIL: BPO\_STRATEGIC\_ACCOUNTS@ARMSTRONG.COM

D1 REFLECTED CEILING PLAN  
 1/8" = 1'-0"

| SYMBOL | DESCRIPTION   | CEILING HEIGHT        | SYMBOL       | DESCRIPTION   | SYMBOL        | DESCRIPTION  |
|--------|---|-----------------------|--------------|---|---------------|--|
| ACP-1  | FOR NEW: ARMSTRONG - 1761C, FINE FISSURED SECOND LOOK, CLASS A, 24"X48" TEGULAR EDGE, ARMSTRONG PRELUDE XL 15/16" TEE GRID. | 10'-6" A.F.F. OPTIMAL | LED-ML1      | SINGLE HEAD ADJUSTABLE GIMBAL RING 358H X 45V, 40' LEDPAR30, FLUSH MOUNT FIXTURE  | LED-LC2-S     | SURFACE MOUNTED 2x2' LED EDGE-LIT FLAT DIMMABLE PANEL, 4000K, WHITE PAINTED ALUMINUM FINISH  |
|        | FOR EXISTING: ARMSTRONG - DESIGNER SERIES *ARM 737C, 24"X24" TEGULAR EDGE, 15/16" TEE GRID, CLASS 'A' RATING                |                       | LED-ML1-EM   | SINGLE HEAD ADJUSTABLE GIMBAL RING 358H X 45V, 40' LEDPAR30, FLUSH MOUNT FIXTURE - WIRED TO MINI-INVERTER FOR EMERGENCY OPERATION   | LED-LC2-S-EM  | SURFACE MOUNTED 2x2' LED EDGE-LIT FLAT DIMMABLE PANEL, 4000K, WHITE PAINTED ALUMINUM FINISH, WIRED TO BOH INVERTER FOR EMERGENCY OPERATION |
| ACP-3  | ARMSTRONG - MESA, 3/4" THICK, COLOR: WHITE, ARMSTRONG PRELUDE XL 15/16" TEE GRID, 24"X24" ANGLED TEGULAR EDGE.              | 10'-6" A.F.F. OPTIMAL | LED-ML2      | DUAL HEAD ADJUSTABLE GIMBAL RING 358H X 45V, 40' LEDPAR30, FLUSH MOUNT FIXTURE  | LED-LC2-P     | PENDANT MOUNTED 2x2' LED EDGE-LIT FLAT DIMMABLE PANEL, 4000K, WHITE PAINTED ALUMINUM FINISH  |
| GYP    | FOR NEW: 5/8" GYPSUM BOARD OVER 3 5/8" METAL FRAMING MEMBERS @ 16" O.C. FINISH TO BE P-2. SEE SHEET A-2.                    | 8'-0" A.F.F. OPTIMAL  | LED-ML2-EM   | DUAL HEAD ADJUSTABLE GIMBAL RING 358H X 45V, 40' LEDPAR30, FLUSH MOUNT FIXTURE - WIRED TO MINI-INVERTER FOR EMERGENCY OPERATION     | LED-LC2-P-EM  | PENDANT MOUNTED 2x2' LED EDGE-LIT FLAT DIMMABLE PANEL, 4000K, WHITE PAINTED ALUMINUM FINISH, WIRED TO BOH INVERTER FOR EMERGENCY OPERATION |
|        | FOR EXISTING: 5/8" GYPSUM BOARD OVER EXISTING METAL FRAMING MEMBERS @ 16" O.C. FINISH TO BE P-2. SEE SHEET A-2.             |                       | LED-ML3      | TRIPLE HEAD ADJUSTABLE GIMBAL RING 358H X 45V, 40' LEDPAR30, FLUSH MOUNT FIXTURE  | LED-EF        | PANASONIC CEILING MOUNTED VENTILATION FAN WITH LED LIGHT MOTION SENSOR.  |
|        |   |                       | LED-ML3-EM   | TRIPLE HEAD ADJUSTABLE GIMBAL RING 358H X 45V, 40' LEDPAR30, FLUSH MOUNT FIXTURE - WIRED TO MINI-INVERTER FOR EMERGENCY OPERATION   | LED-EXT       | NORA LIGHTING WHITE LED EXIT SIGN WITH BATTERY BACKUP  |
|        |   |                       | LED-LC2-R    | RECESSED 2x2' LED EDGE-LIT FLAT DIMMABLE PANEL, 4000K, WHITE PAINTED ALUMINUM FINISH  | LED-EM        | EMERGI-LITE RECESSED EMERGENCY LED LIGHTING  |
|        |   |                       | LED-LC2-R-EM | RECESSED 2x2' LED EDGE-LIT FLAT DIMMABLE PANEL, 4000K, WHITE PAINTED ALUMINUM FINISH, WIRED TO BOH INVERTER FOR EMERGENCY OPERATION | LED-EM-E      | NORA LIGHTING WHITE LED EXIT SIGN WITH EMERGENCY LIGHTING  |
|        |   |                       |              |   | ACP-1         | CEILING SYSTEM / FINISH  |
|        |   |                       |              |   | 10'-6" A.F.F. | CEILING HEIGHT   |

- LIGHTING, ELECTRICAL EQUIPMENT, HVAC EQUIPMENT, AND SPRINKLERS ARE TO BE MOUNTED AT POINTS IN ACT AS NOTED IN GRAPHIC BELOW UNLESS OTHERWISE DIMENSIONED ON RCP.
    - 2X2 ACT TILE
    - 2X4 ACT TILE
  - CENTER ACT GRID WITHIN EACH ROOM UNLESS OTHERWISE NOTED.
  - NO CEILING REQUIRED IN JANITORS CLOSET, IF APPLICABLE.
  - PLACEMENT AND NUMBER OF EMERGENCY LIGHTS, NIGHT LIGHTS, AND EXIT LIGHTS ALONG WITH MOUNTING HEIGHT TO BE CONFIRMED BY PARTNER'S ARCHITECT. SPECIFICATIONS SHOWN ARE FOR REFERENCE ONLY.
  - GC TO ADJUST PERIMETER ADJUSTABLE LIGHTS TO BE TARGETED BETWEEN 5'-9" TO 6'-3" VERTICALLY FROM FLOOR TO WASH RETAIL WALL DISPLAYS.
- GC SHALL INSTALL CEILING IN ACCORDANCE WITH  
 ICC ESR 1308  
 ICC ESR 1289  
 IBC SECTION 2508
- GENERAL CONTRACTOR SHALL FIELD VERIFY EXISTING EGRESS LIGHTING AND PROVIDE NEW EMERGENCY LIGHT FIXTURES AS REQUIRED BY FIRE MARSHALL.
- GC TO CONTACT EDSS ENERGY DESIGN SERVICE SYSTEMS FOR T-MOBILE PREFERRED PRICING.
- CONTACT MICHAEL NORDLOH  
 810-227-3377  
 MNORDLOH@EDSSENERGY.COM

|    |                               |
|----|-------------------------------|
| A1 | CEILING LEGEND                |
|    | NOT ALL USED AT THIS LOCATION |

|    |                               |
|----|-------------------------------|
| A4 | SYMBOL LEGEND                 |
|    | NOT ALL USED AT THIS LOCATION |

|     |       |
|-----|-------|
| A10 | NOTES |
|-----|-------|

**AAD-FITCH, Inc.**  
**FITCH**  
 16435 North Scottsdale Rd, Suite 195  
 Scottsdale, Arizona 85254  
 P: 480.999.7223  
 F: 480.999.7223  
 www.aad-fitch.com

DESIGN DEVELOPMENT DRAWINGS

DEALER CONTACT:  
 CUSTOM WIRELESS  
 CONTACT: DAN BURKE  
 PHONE: 781-888-3456

DATE: 03.03.2016 SHEET:  
 SCALE: N.T.S.  
 DRAWN BY: GJC  
 PROJECT No: 320104626

**A-4**

FILE NAME: TMB-15-A4.DWG  
 DRAWN BY: GJC  
 DATE: 03/03/2016 10:00 AM