




**BUILDING A FIRE ALARM PLAN**  
SCHEMATIC: NO SCALE

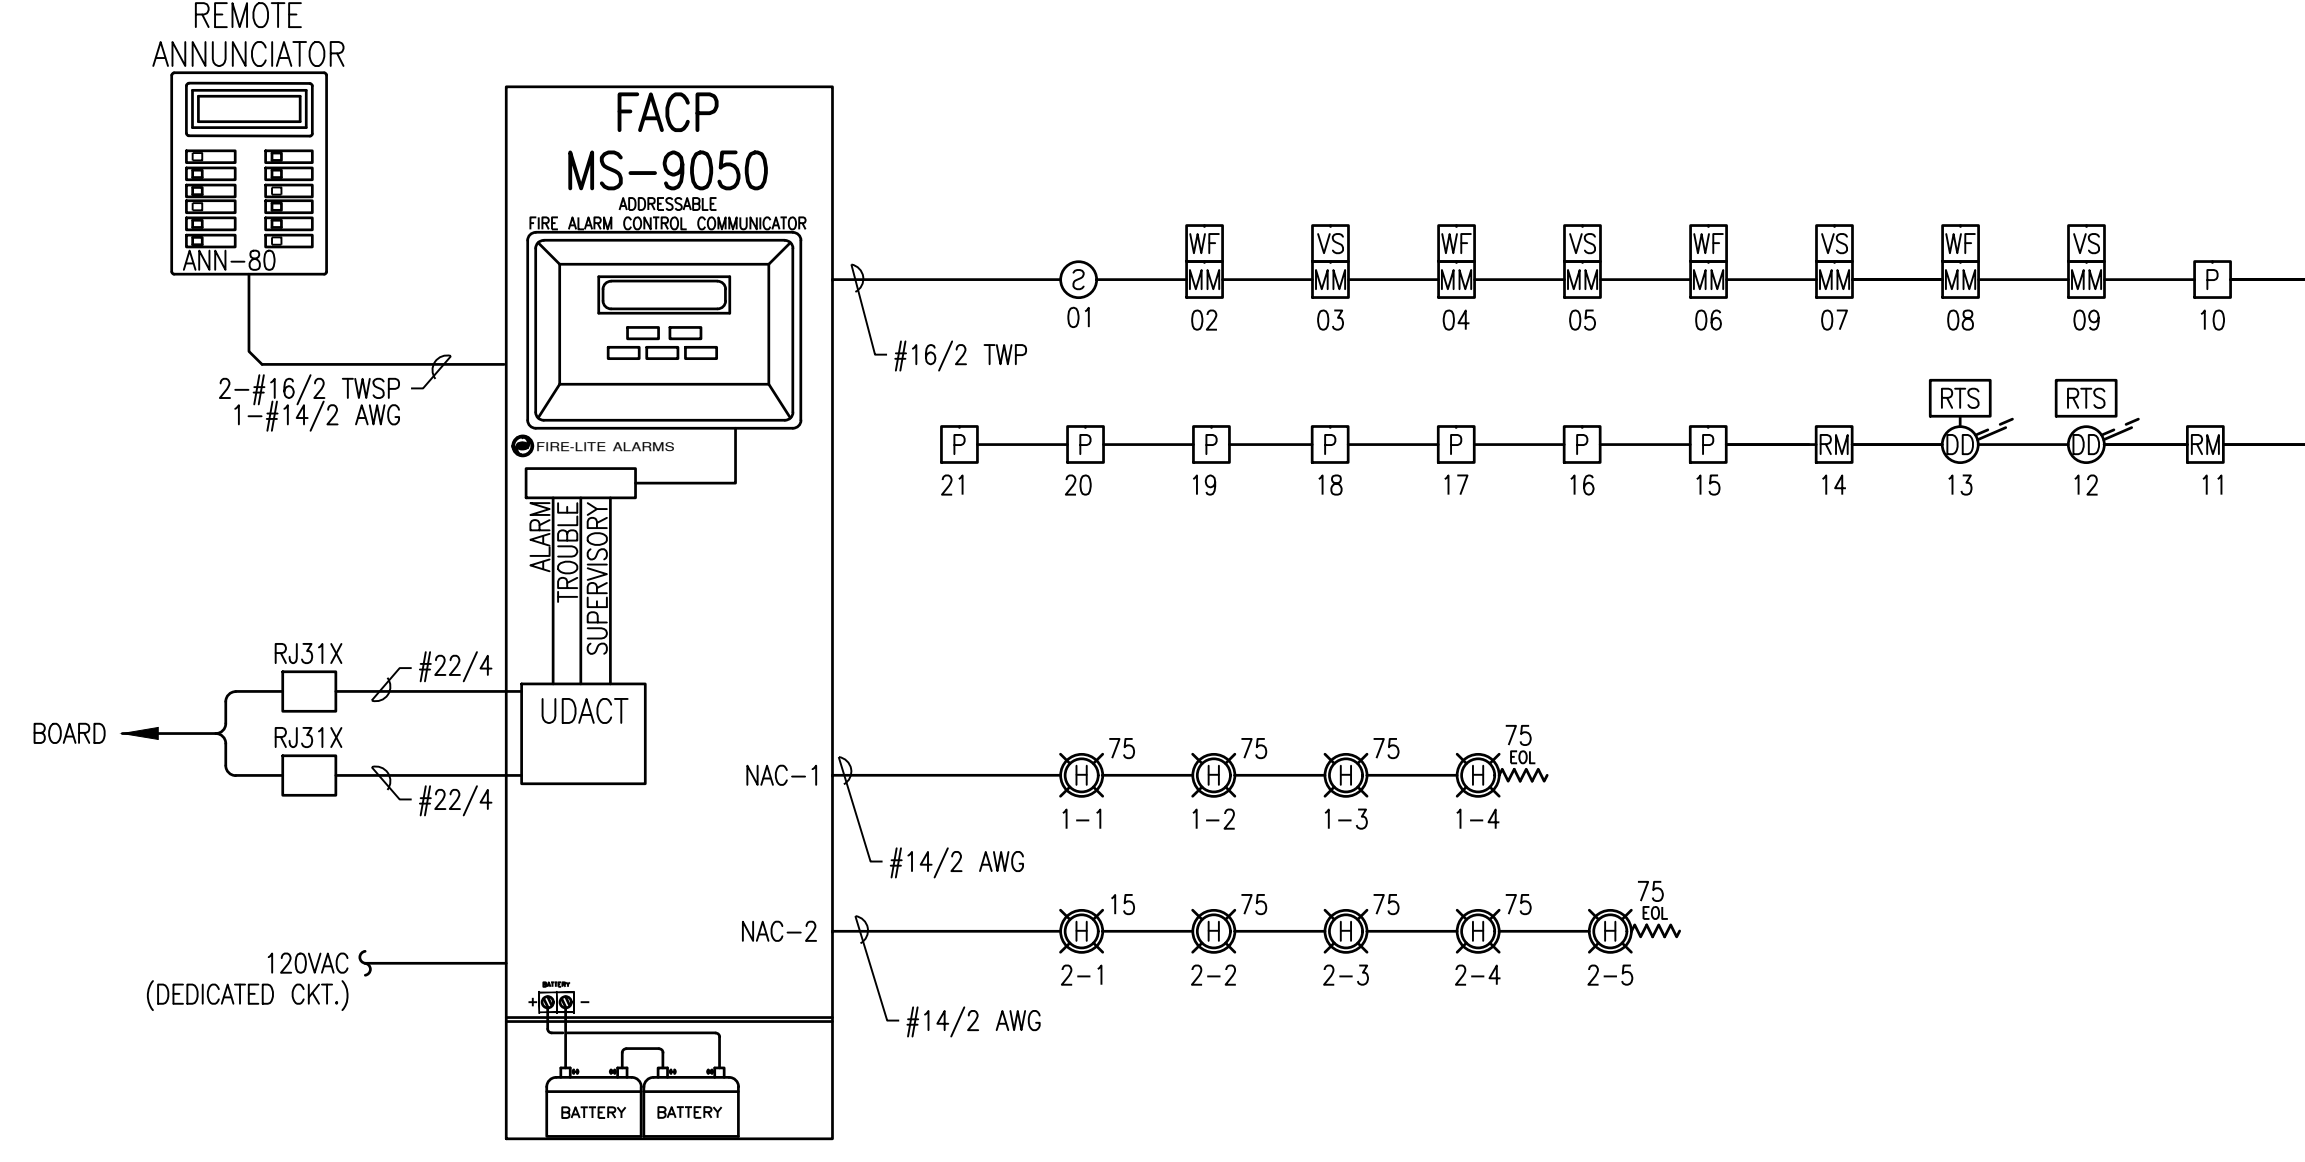

**BUILDING B FIRE ALARM PLAN**  
SCHEMATIC: NO SCALE

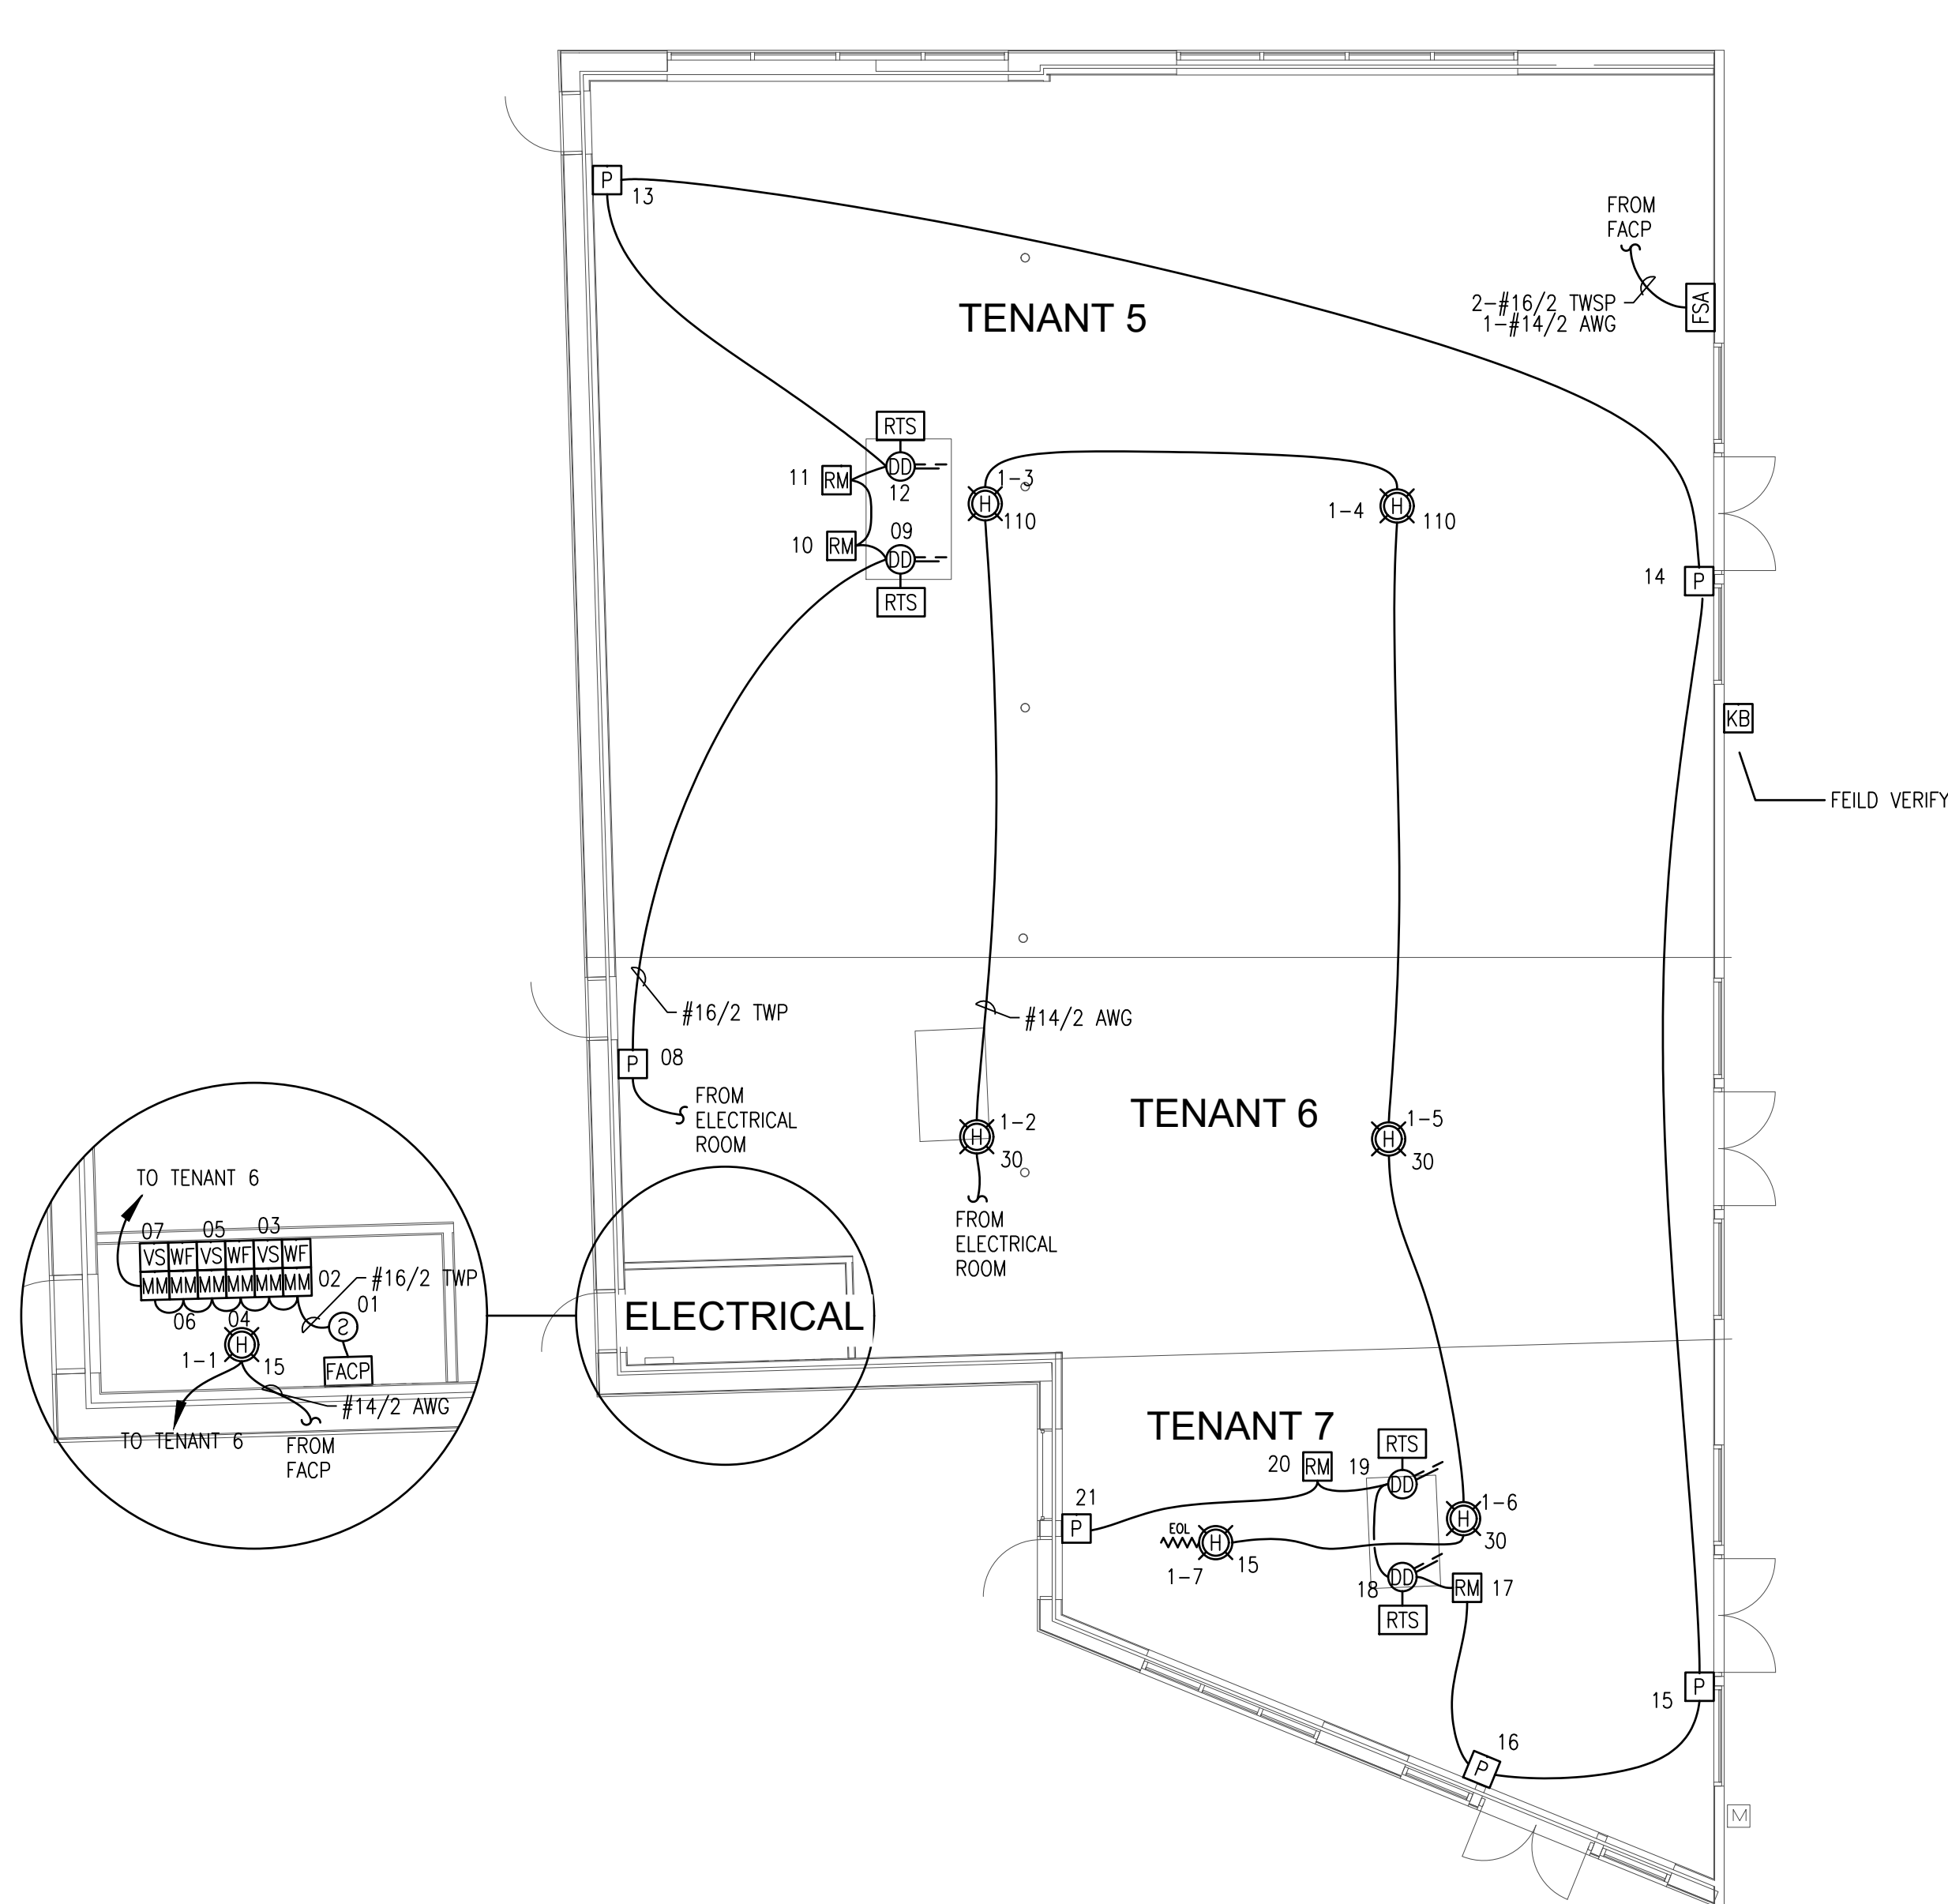

**BUILDING A FIRE ALARM PLAN**  
SCALE: 1/8"=1'-0"

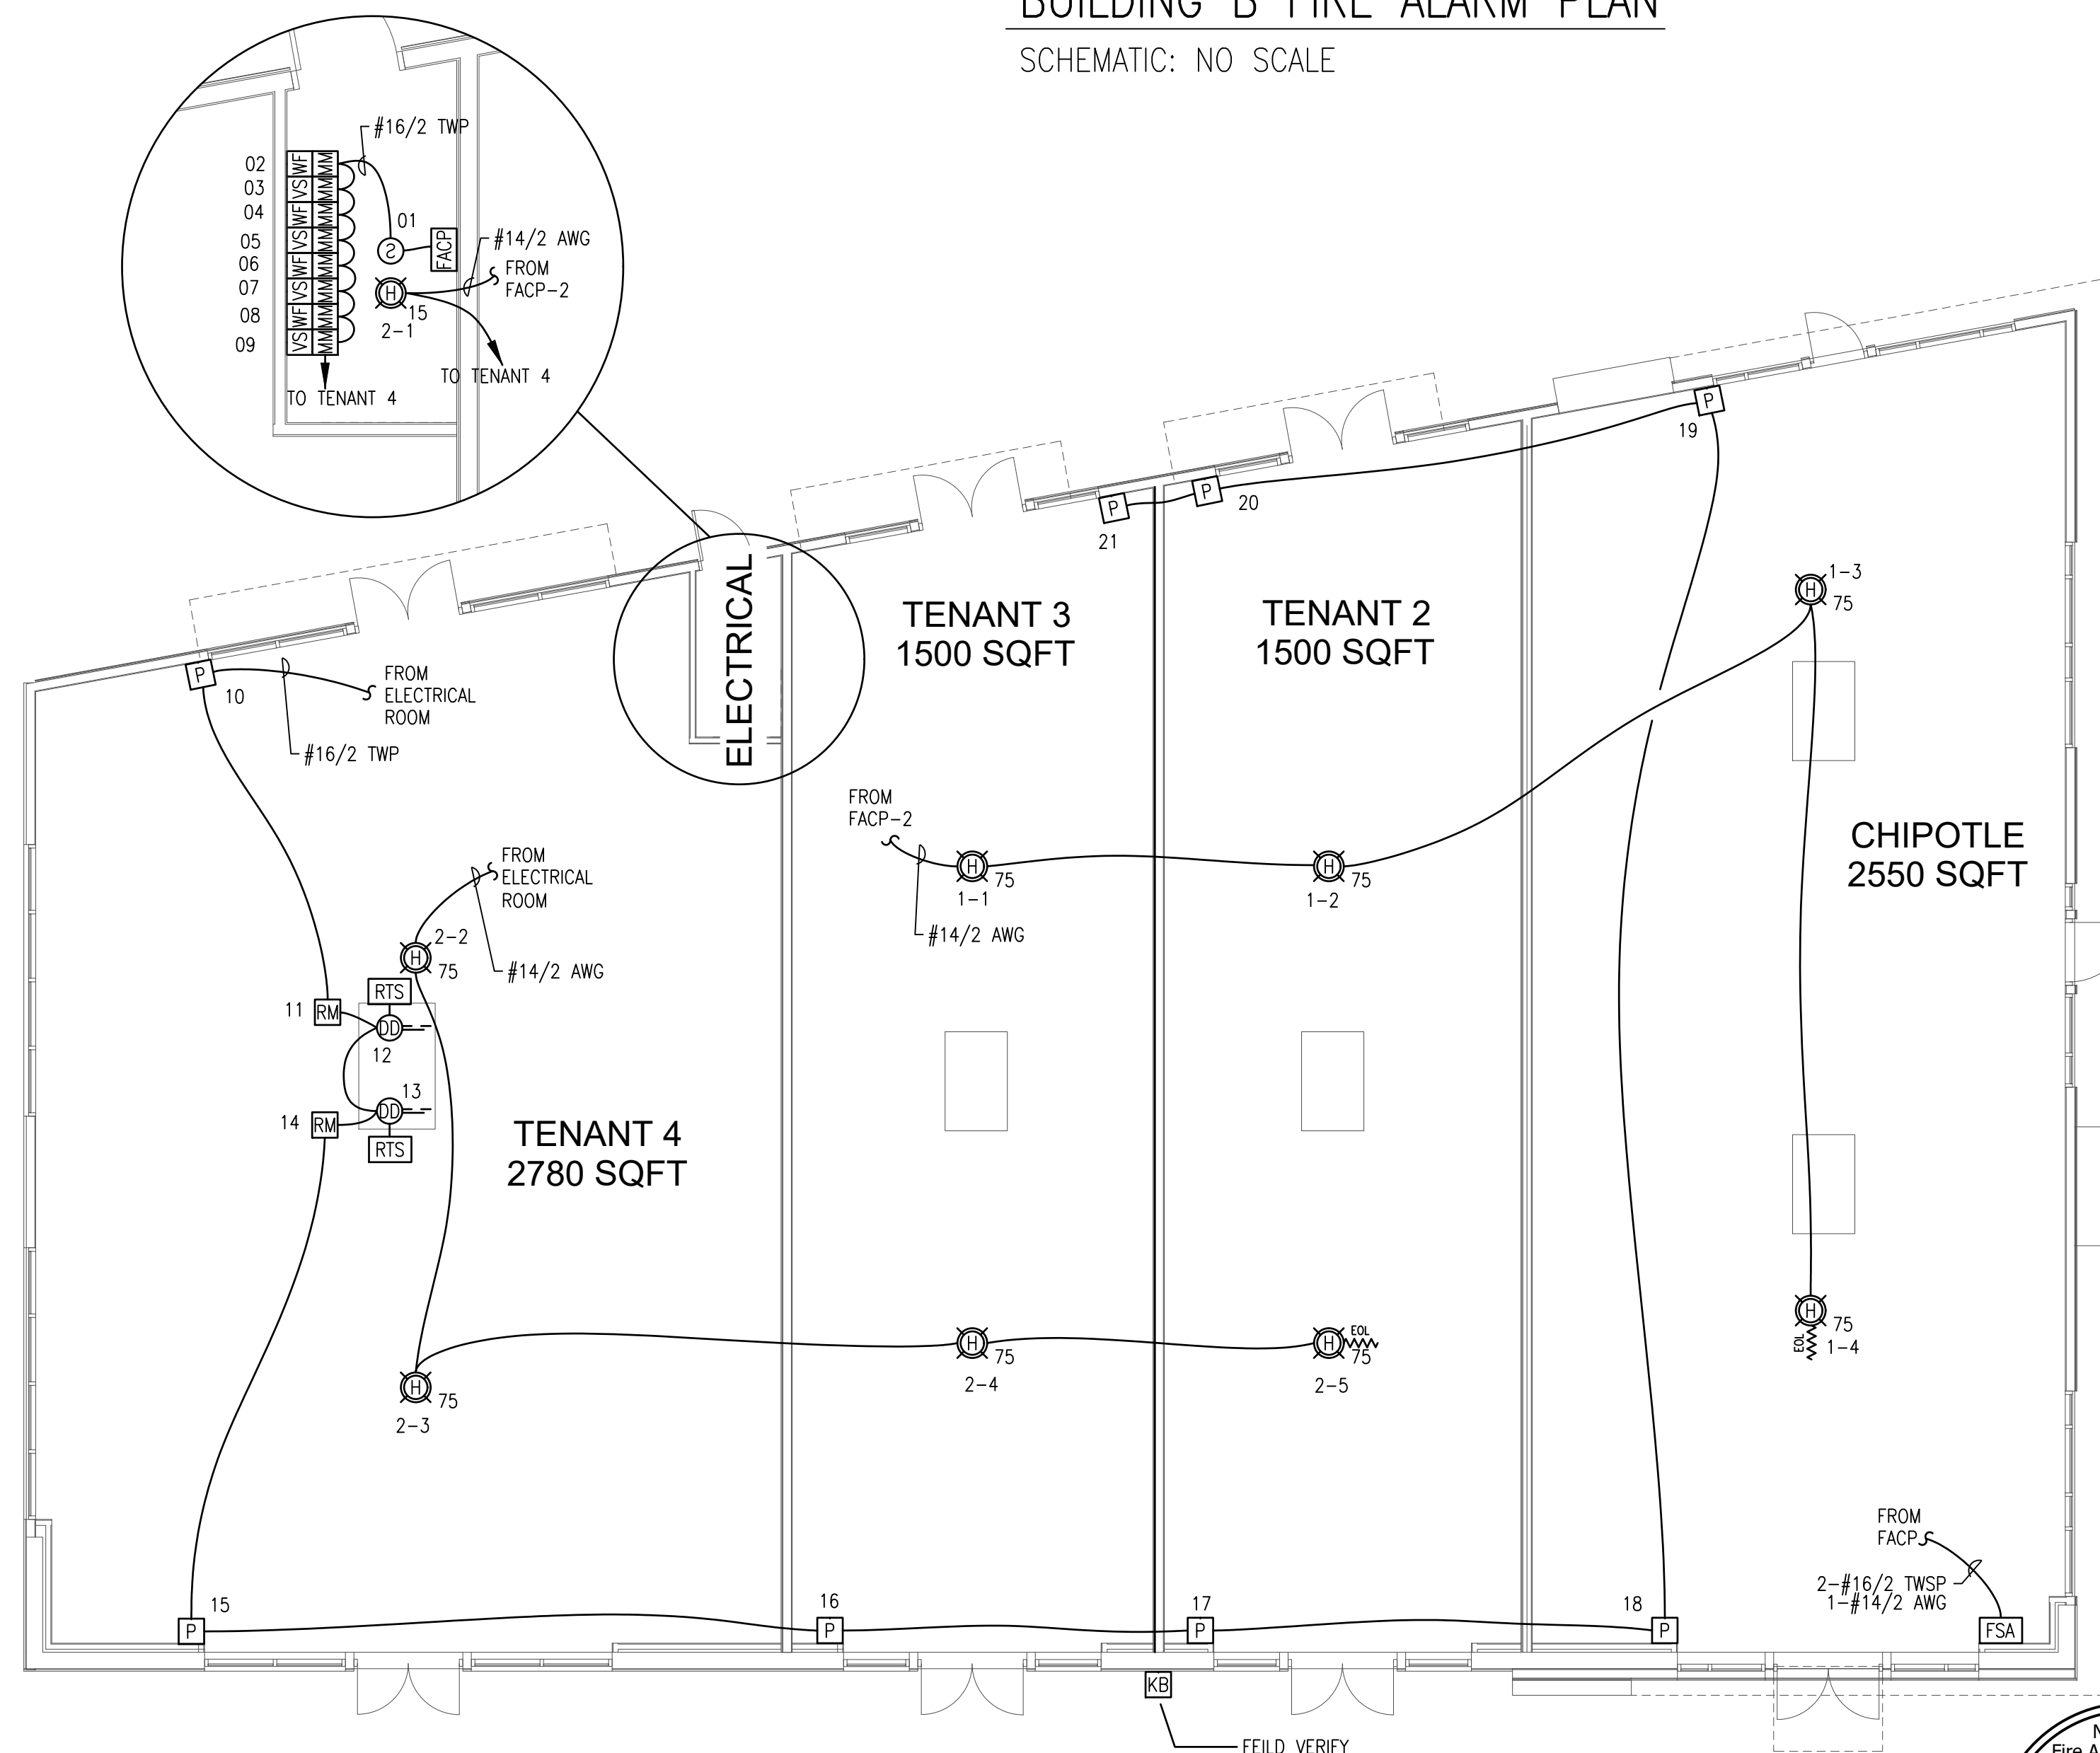

**BUILDING B FIRE ALARM PLAN**  
SCALE: 1/8"=1'-0"

NICET IV  
Fire Alarm Systems  
Wayne B. Haws / Signature  
Date: 3/3/16  
Fire Protection Engineering  
Technology  
Fire Alarm Systems  
Cert. No. 90496

Shop drawings created by  
5784 W. 4800 St.  
Hesper, UT 84315  
Office: 801.985.0410  
**UNICAD** Inc.  
Fire Alarm Design & Drafting Services

REVISION	DESCRIPTION	DATE
0	ISSUED FOR REVIEW & APPROVAL	3/3/2016

**SEACOAST SECURITY**  
4 Summer Street • Freeport, Maine 04032  
Office: (207) 706-3369 • Fax: (207) 865-0852

**CENTURY TIRE**  
**185 KENEBC STREET**  
**PORTLAND, MAINE 04101**  
**BUILDING A & B FIRE ALARM PLAN, RISER DIAGRAM**

DRAWN	CWS UNICAD JOB #16129
CHECKED	WAYNE B. HAWS NICET IV 90496
DATE	3/3/2016
REVISION	0
SCALE	1/8"=1'-0"