


NOTE:
 NEW 9'x 9' (MAXIMUM) FACE COLUMN FOR ELEC./PLUMBING
 CASE BEARING LOAD WITH CEILING ON (4) SIDES.
 CASE BEARING LOAD WITH CEILING ON (2) SIDES.
 FIGURE LAYOUT - TYPICAL OF (1) F.R.P. PANELS ON TWO
 (2) COLUMNS IN BEVERAGE COOLER.

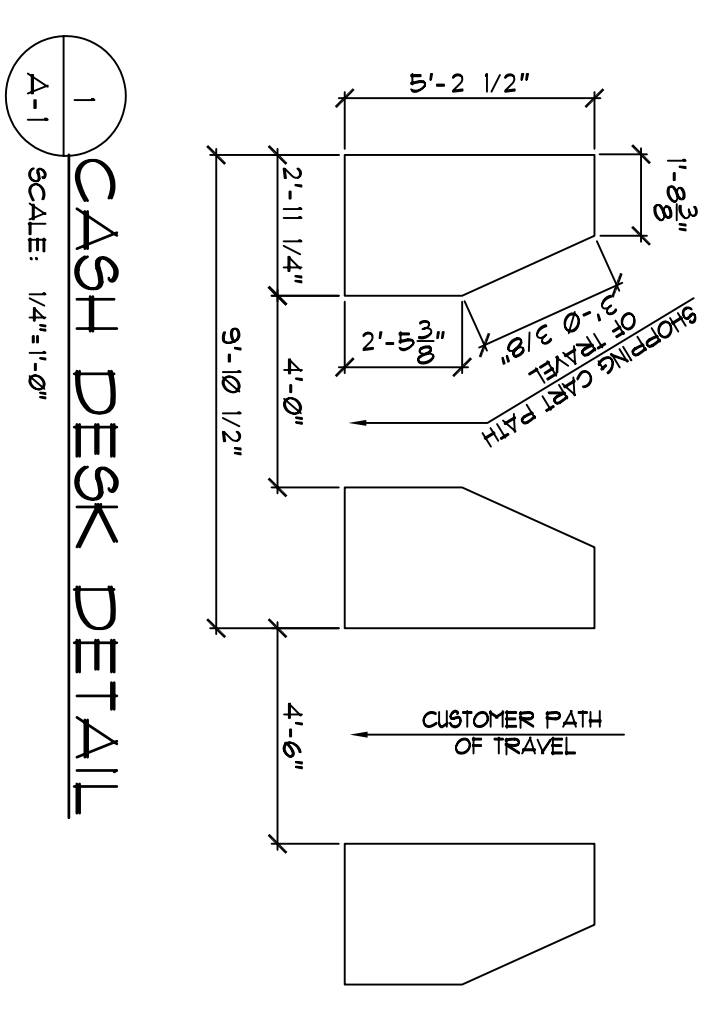

FIXTURE FLOOR PLAN
 SCALE: 1/8" = 1'-0"

PROJECT
TRADER JOE'S
 87 MARGINAL WAY
 PORTLAND, ME. 04101

SHEET NAME
FIXTURE FLOOR PLAN

SALES :	17,224 sq. ft.	DATE	04/28/10
STOCK :	5,424 sq. ft.	JOB No.	FT-7972
MISC. :	1,464 sq. ft.	DRAWN BY:	FTA
TOTAL :	23,930 sq. ft.	TENANT STORE No.	XXXX
		SPACE No.	XXXX

REVISIONS		COMMENTS
NO.	DATE	

SEAL

Jeffrey Taylor
 Architect

572 North Broadway
 White Plains, N.Y. 10603
 Tel: 914 298 0011
 Fax: 914 298 0022