

ELECTRICAL NOTES:

- ALL WIRING SHALL BE IN CONFORMITY WITH THE NATIONAL ELECTRICAL CODE (NEC) AND THE NATIONAL FIRE ALARM CODE (NFPA 70).
- CONNECTIONS FROM OUTLET BOXES TO LIGHT FIXTURES SHALL BE MADE BY RIGID CONDUIT UNLESS OTHERWISE NOTED.
- THE ELECTRICAL CONTRACTOR SHALL VERIFY THE EXISTING CONDITIONS TO ASSURE THAT THE NEW WORK WILL FIT TO EXISTING STRUCTURES, INCLUDING CONDUIT AND WIRING. SHOWN ON THESE DRAWINGS AND IN THE FIELD. THE CONTRACTOR SHALL VERIFY ALL CONDITIONS PRIOR TO FABRICATION OR PERFORMANCE OF WORK. IN THE EVENT OF A DISCREPANCY OR SICH DISCREPANCY, THE CONTRACTOR SHALL STOP WORK IMMEDIATELY AND NOTIFY THE ARCHITECT/ENGINEER FOR RESOLUTION.

ELECTRICAL VERIFICATION NOTE:

PRIOR TO INSTALLATION OF RIGID ELECTRICAL WIRING, THE CONTRACTOR SHALL CHECK THE DATA OF ALL ELECTRICAL EQUIPMENT IN ORDER TO OBTAIN CORRECT WIRE SIZES, VOLTAGES, AND OVER-CURRENT PROTECTION. ADEQUATE SERVICE CAPACITY MUST BE PROVIDED. ADEQUATE ELECTRICAL INTERFERENCES.


FLOODLIGHT THAT IS OUTLET STRIP MUST MEET ALL NATIONAL LISTED PRODUCT REQUIREMENTS FOR THE TYPE OF COLOR FINISH (A-1).

NOTE:
ELECTRICAL CONTRACTOR TO VERIFY ALL WIRING REQUIREMENTS FOR THE CASE DEROST SYSTEM WITH REFRIGERATION MANUFACTURERS REPRESENTATIVE PRIOR TO WORK BEGINNING.

SEE SHEET E-1 FOR UNDER SHELF LIGHT FIXTURE TYPE (5) SPECIFICATION LOCATED AT FREEZER CASE SHELVING

GENERAL NOTES:

- A SURVEY OF EXISTING CONDITIONS WAS NOT COMPLETED BY THIS ENGINEER. THE EXISTING CONDITIONS DERIVED ARE BASED ON INFORMATION PROVIDED BY OTHERS. THE ELECTRICAL CONTRACTOR SHALL VERIFY ALL CONDITIONS IN THE FIELD. ANY DISCREPANCIES BETWEEN THE DOCUMENTED EXISTING CONDITIONS AND THE FIELD CONDITIONS SHALL BE NOTED IMMEDIATELY FOR DECISIONS AND INSTRUCTIONS REGARDING ANY CHANGES THAT MAY NEED TO BE INCORPORATED INTO THE WORK TO FULFILL THE INTENT OF THE DESIGN.
- THE ELECTRICAL CONTRACTOR SHALL BE FIELD RESPONSIBLE TO HAVE EXAMINED THE SITE PRIOR TO SUBMITTING HIS ESTIMATE AND TO HAVE EXPANDED AND FAMILIARIZED HIMSELF WITH THE SITE CONDITIONS AND SPECIFICATIONS WITH THE RESULTS OF HIS EXAMINATION OF THE SITE AND ASSURE HIMSELF THAT ALL REQUIREMENTS FOR A COMPLETE AND ACCURATE CONTRACT SHALL BE PROVIDED TO THE ELECTRICAL CONTRACTOR BECAUSE OF UNUSUALITY WITH THE SITE CONDITIONS.
- IT IS NOT INTENDED THAT THE DRAWINGS SHOW ALL DETAILS OF CONSTRUCTION. HOWEVER, THE ELECTRICAL CONTRACTOR SHALL BE REQUIRED TO FINISH AND INSTALL ALL MATERIALS NECESSARY TO ACCORDANCE WITH THE BEST PRACTICE AND TO THE FULL EXTENT OF THE DRAWINGS AND SPECIFICATIONS. THE ELECTRICAL CONTRACTOR SHALL BE RESPONSIBLE FOR VERIFYING ALL DIMENSIONS AND CONDITIONS JUST AS THOSE REQUIRED BY BOTH. SHOULD THESE APPEAR TO BE DISCREPANCIES OR UNUSUAL CONDITIONS, THE CONTRACTOR SHALL CONTACT THE ARCHITECT/ENGINEER FOR DECISIONS, FURTHERMORE, HIS INTERPRETATION SHALL BE FINAL, CONCLUSIVE AND BINDING.
- WITH THE SUBMISSION OF BID, THE ELECTRICAL CONTRACTOR SHALL HAVE AGREED TO HAVE INCLUDED THE COST OF ALL REQUIRED ITEMS AND MATERIALS AND THAT HE WILL BE FIELD RESPONSIBLE FOR THE CORRECTION OF ANY DEFICIENCIES IN THE SYSTEM.
- DO NOT ABANDON ANY UTILITIES OR MATERIALS WITHIN THE DEEMED WORK AREA. ALL UTILITIES AND MATERIALS SHALL BE REMOVED FROM THE PROJECT.

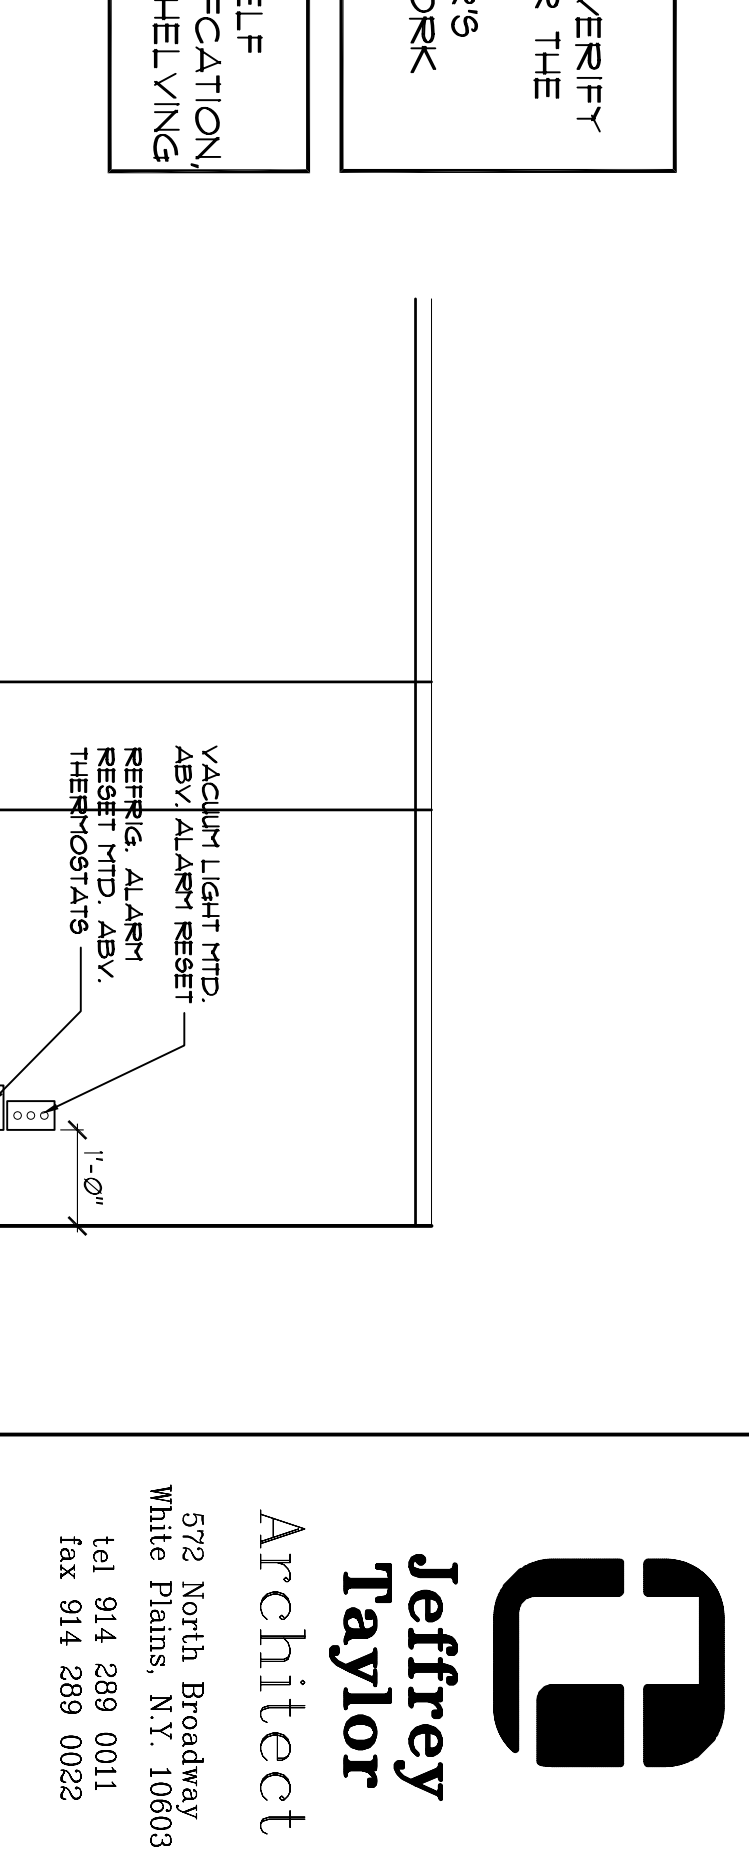

ELECTRICAL POWER PLAN

SCALE: 1/8" = 1'-0"

REVISIONS:

NO.	DATE	COMMENTS

GENERAL NOTES:

- SALES FLOOR 120V DUPLEX OUTLETS ARE TO BE LOCATED BEFORE START OF CONSTRUCTION IN THE SALES AREA.
- CONNECTIONS FROM OUTLET BOXES TO LIGHT FIXTURES SHALL BE MADE BY RIGID CONDUIT UNLESS OTHERWISE NOTED.
- CONNECTIONS FROM OUTLET BOXES TO LIGHT FIXTURES SHALL BE MADE BY RIGID CONDUIT UNLESS OTHERWISE NOTED.
- CONNECTIONS FROM OUTLET BOXES TO LIGHT FIXTURES SHALL BE MADE BY RIGID CONDUIT UNLESS OTHERWISE NOTED.

SALES:	17,224 sq. ft.	DATE:	04/28/10
STOCK:	5,424 sq. ft.	JOB No.:	FT-1912
TOTAL:	22,648 sq. ft.	DRAWN BY:	FTA
		TENANT STORE No.:	XXXX
		SPACE No.:	XXXX

PROJECT: **TRADER JOE'S**
87 MARGINAL WAY
PORTLAND, ME. 04101

SHEET NAME: **ELECTRICAL POWER PLAN**

Architect: **Jeffrey Taylor**
572 North Broadway
White Plains, N.Y. 10603
Tel 914 589 0011
Fax 914 589 0022

Engineer: **Don Penn**
633 WESTPORT PARKWAY SUITE 300
SHAPEWICH, TEXAS 78051
877-410-2888 FAX 817-251-9411