

Consultants  
Casco Bay Engineering  
Structural Engineer

Casco Bay Engineering  
Civil Engineer


TJM Consulting  
Food Service

Urban Dwellings  
Interior Design

Revisions

# Bowl Portland

58 Alder Street Portland, Maine

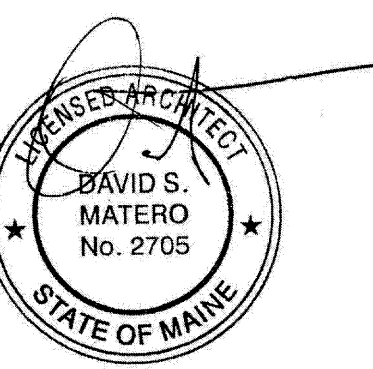

Job Number: 09.017

Date: 07.Dec.09


Scale: 1/4" = 1'-0"

Drawing Title:

## Enlarged Floor Plan Base Bid

# A1.2

Issue for Bid

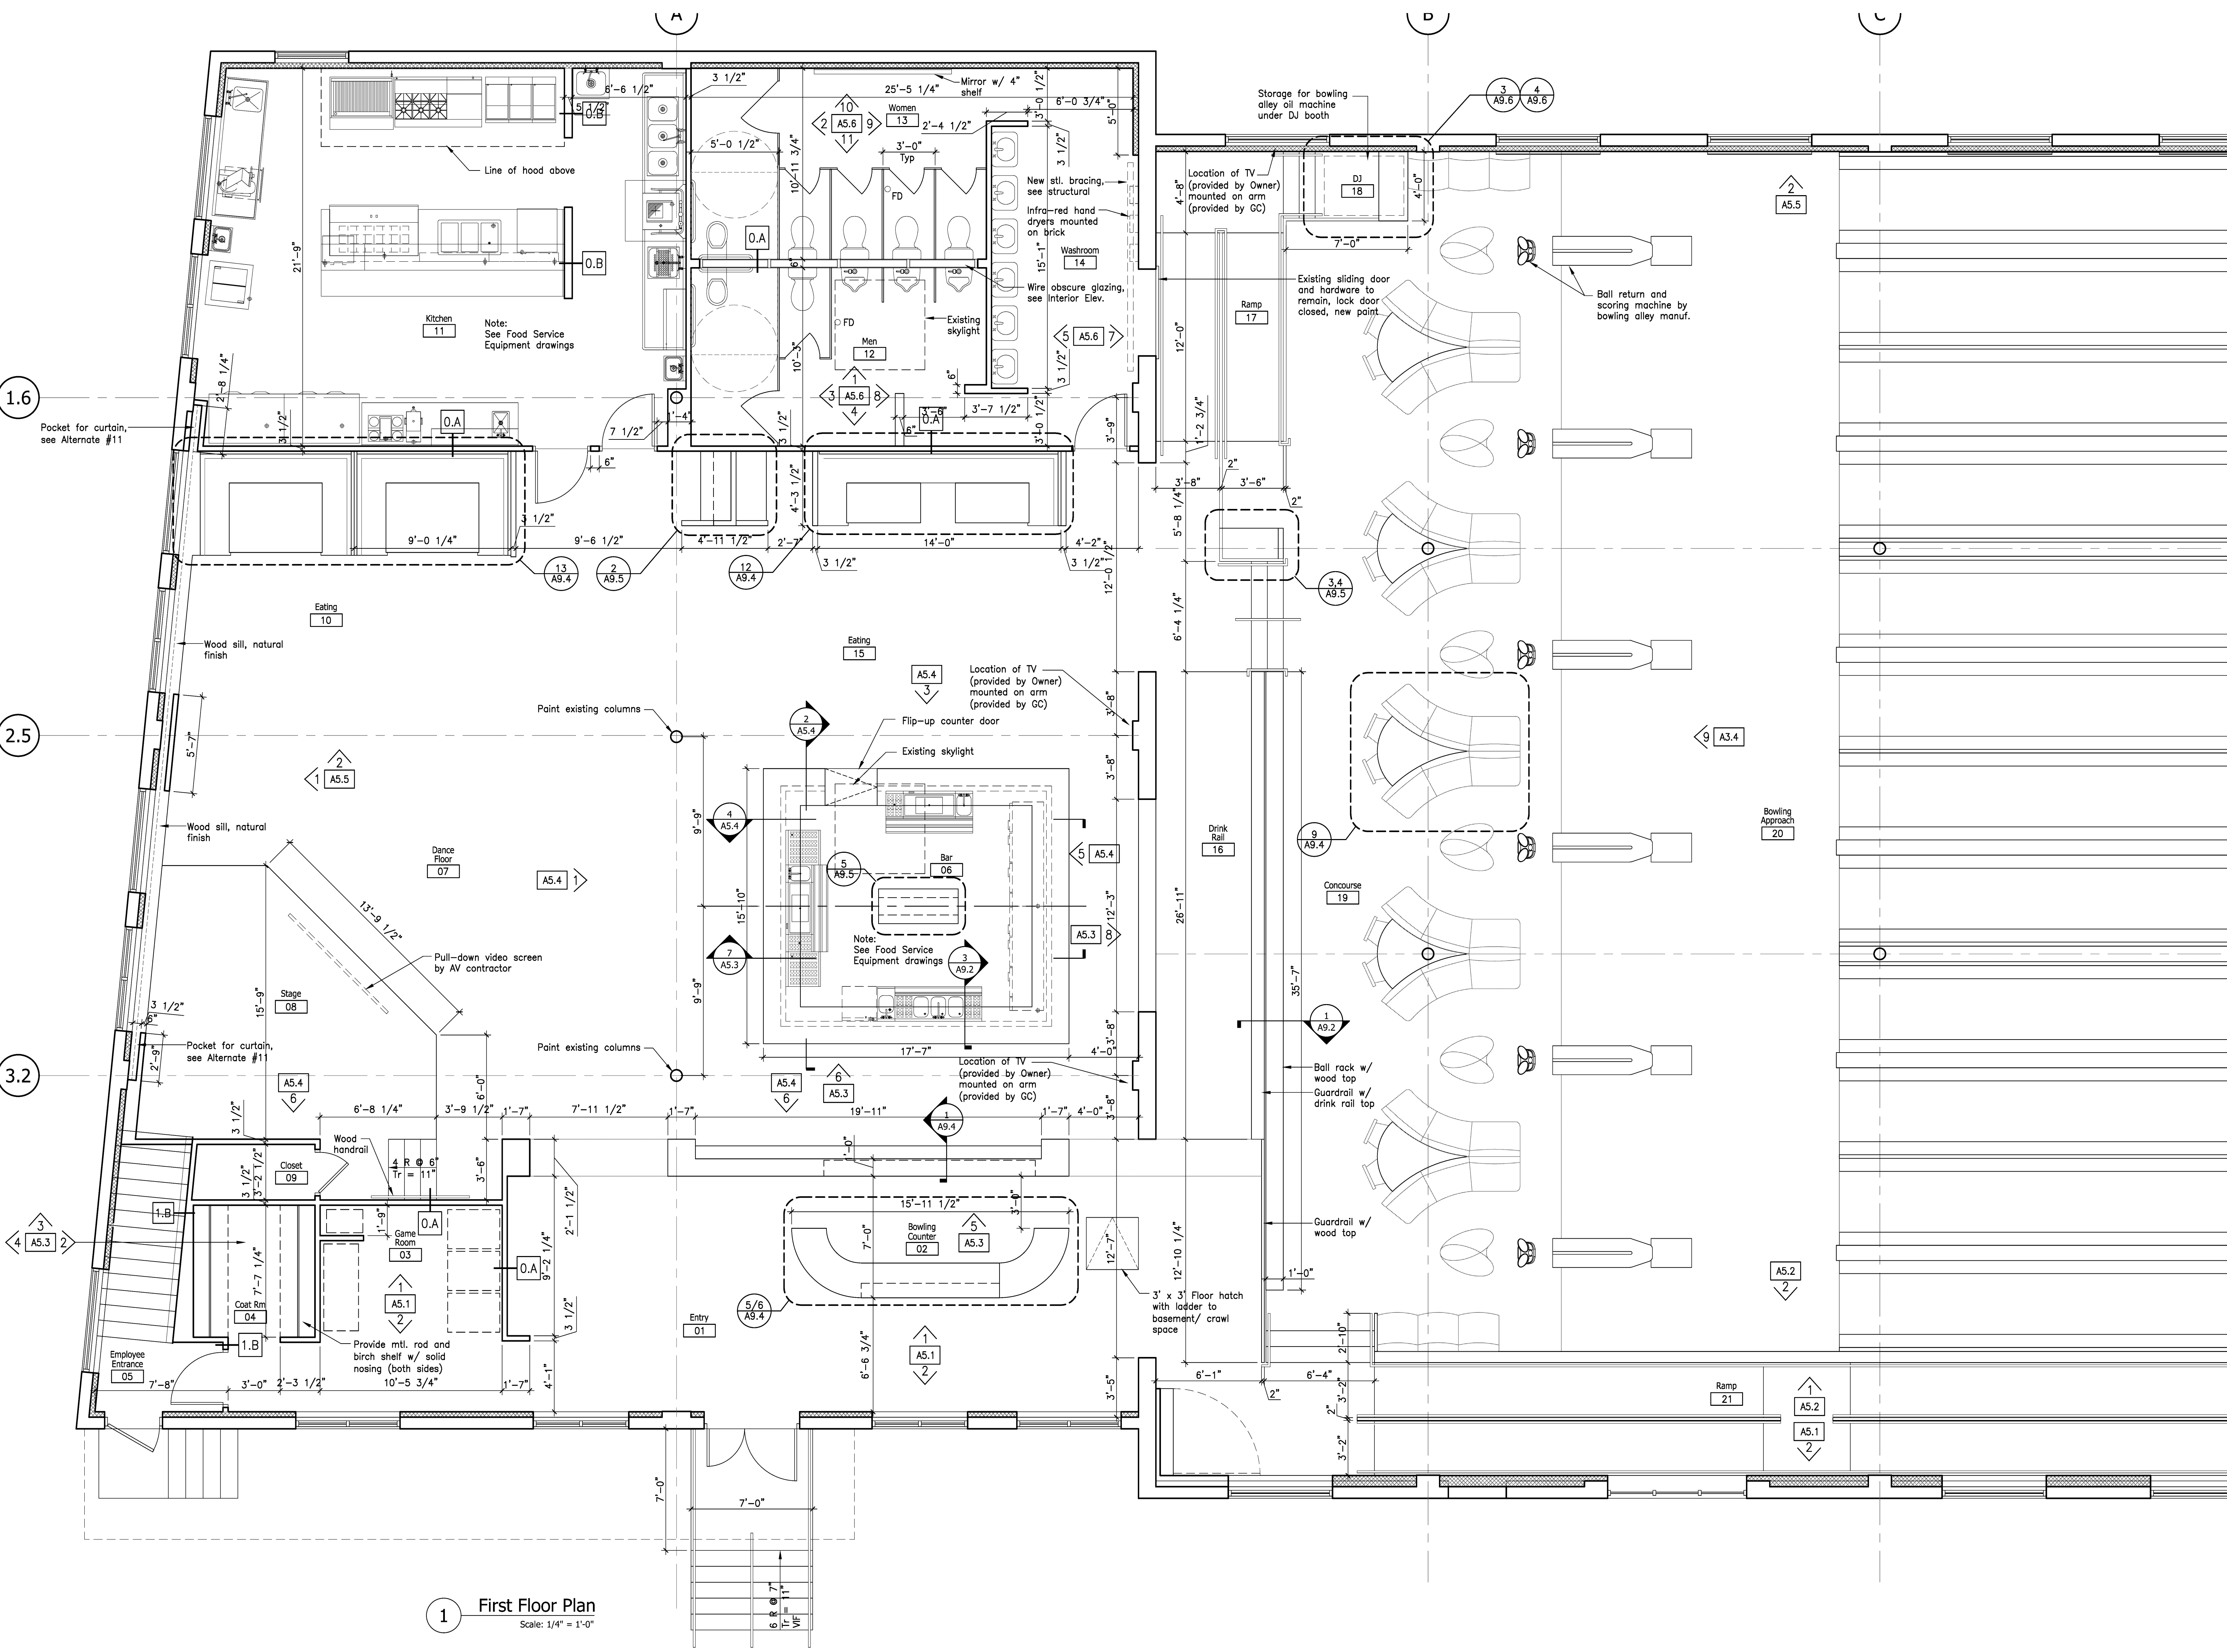

1 First Floor Plan  
Scale: 1/4" = 1'-0"