


FOR CONSTRUCTION

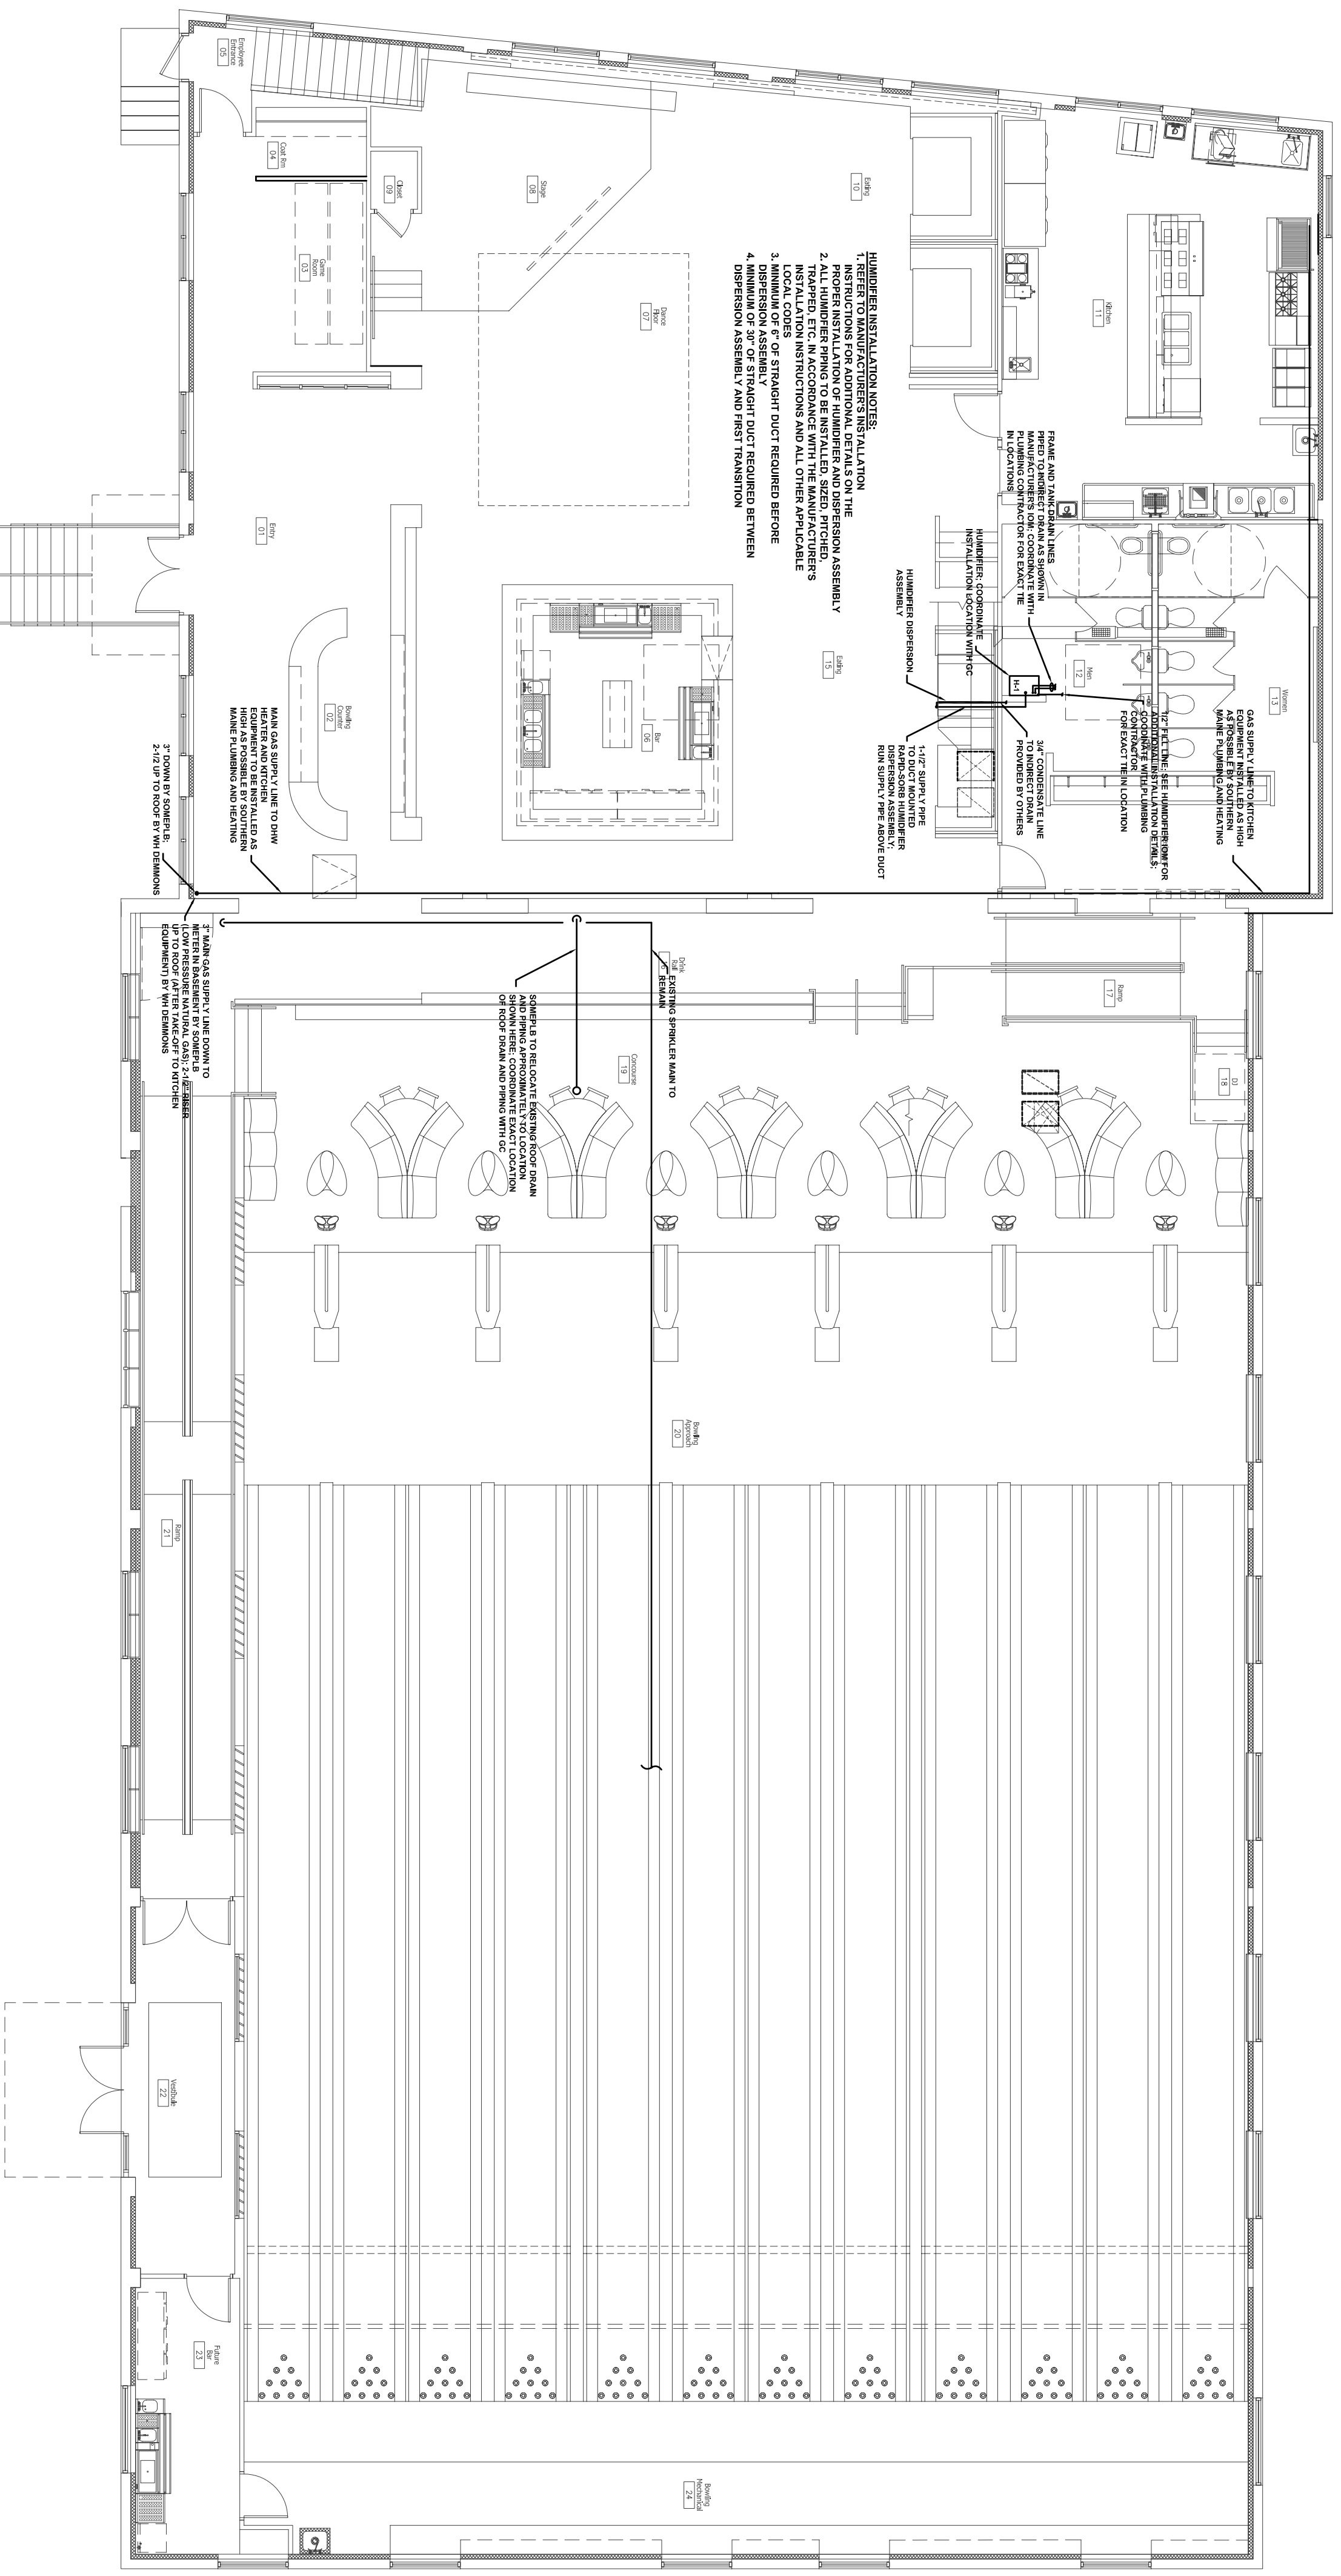

GAS AND HUMIDIFIER PIPING PLAN

SCALE: 1/8" = 1'-0"

**THESE DRAWINGS AND PLANS ARE THE PROPERTY OF WH DEMMONS INC.
 AND ARE AN INSTRUMENT OF SERVICE FOR THE OWNER'S USE FOR THIS
 PROJECT ON THIS SITE ONLY**

PROJECT NUMBER:	48076
ISSUED:	3.22.2010
DRAWN BY:	MGR / JLR
CHECKED BY:	DWM
FILENAME:	.DWG

BAYSIDE BOWLING
PORTLAND, ME
GAS AND HUMIDIFIER PIPING PLAN

M-3