
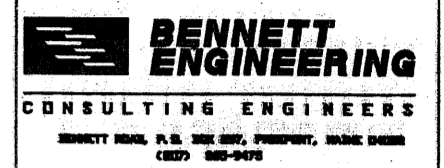
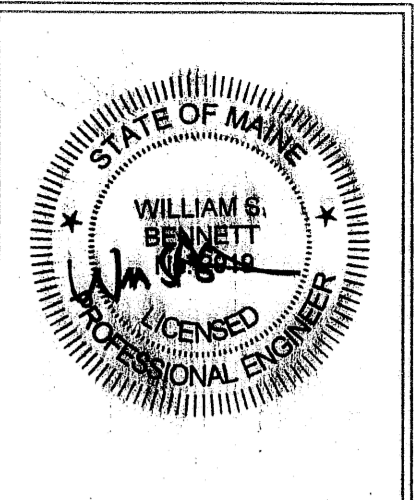
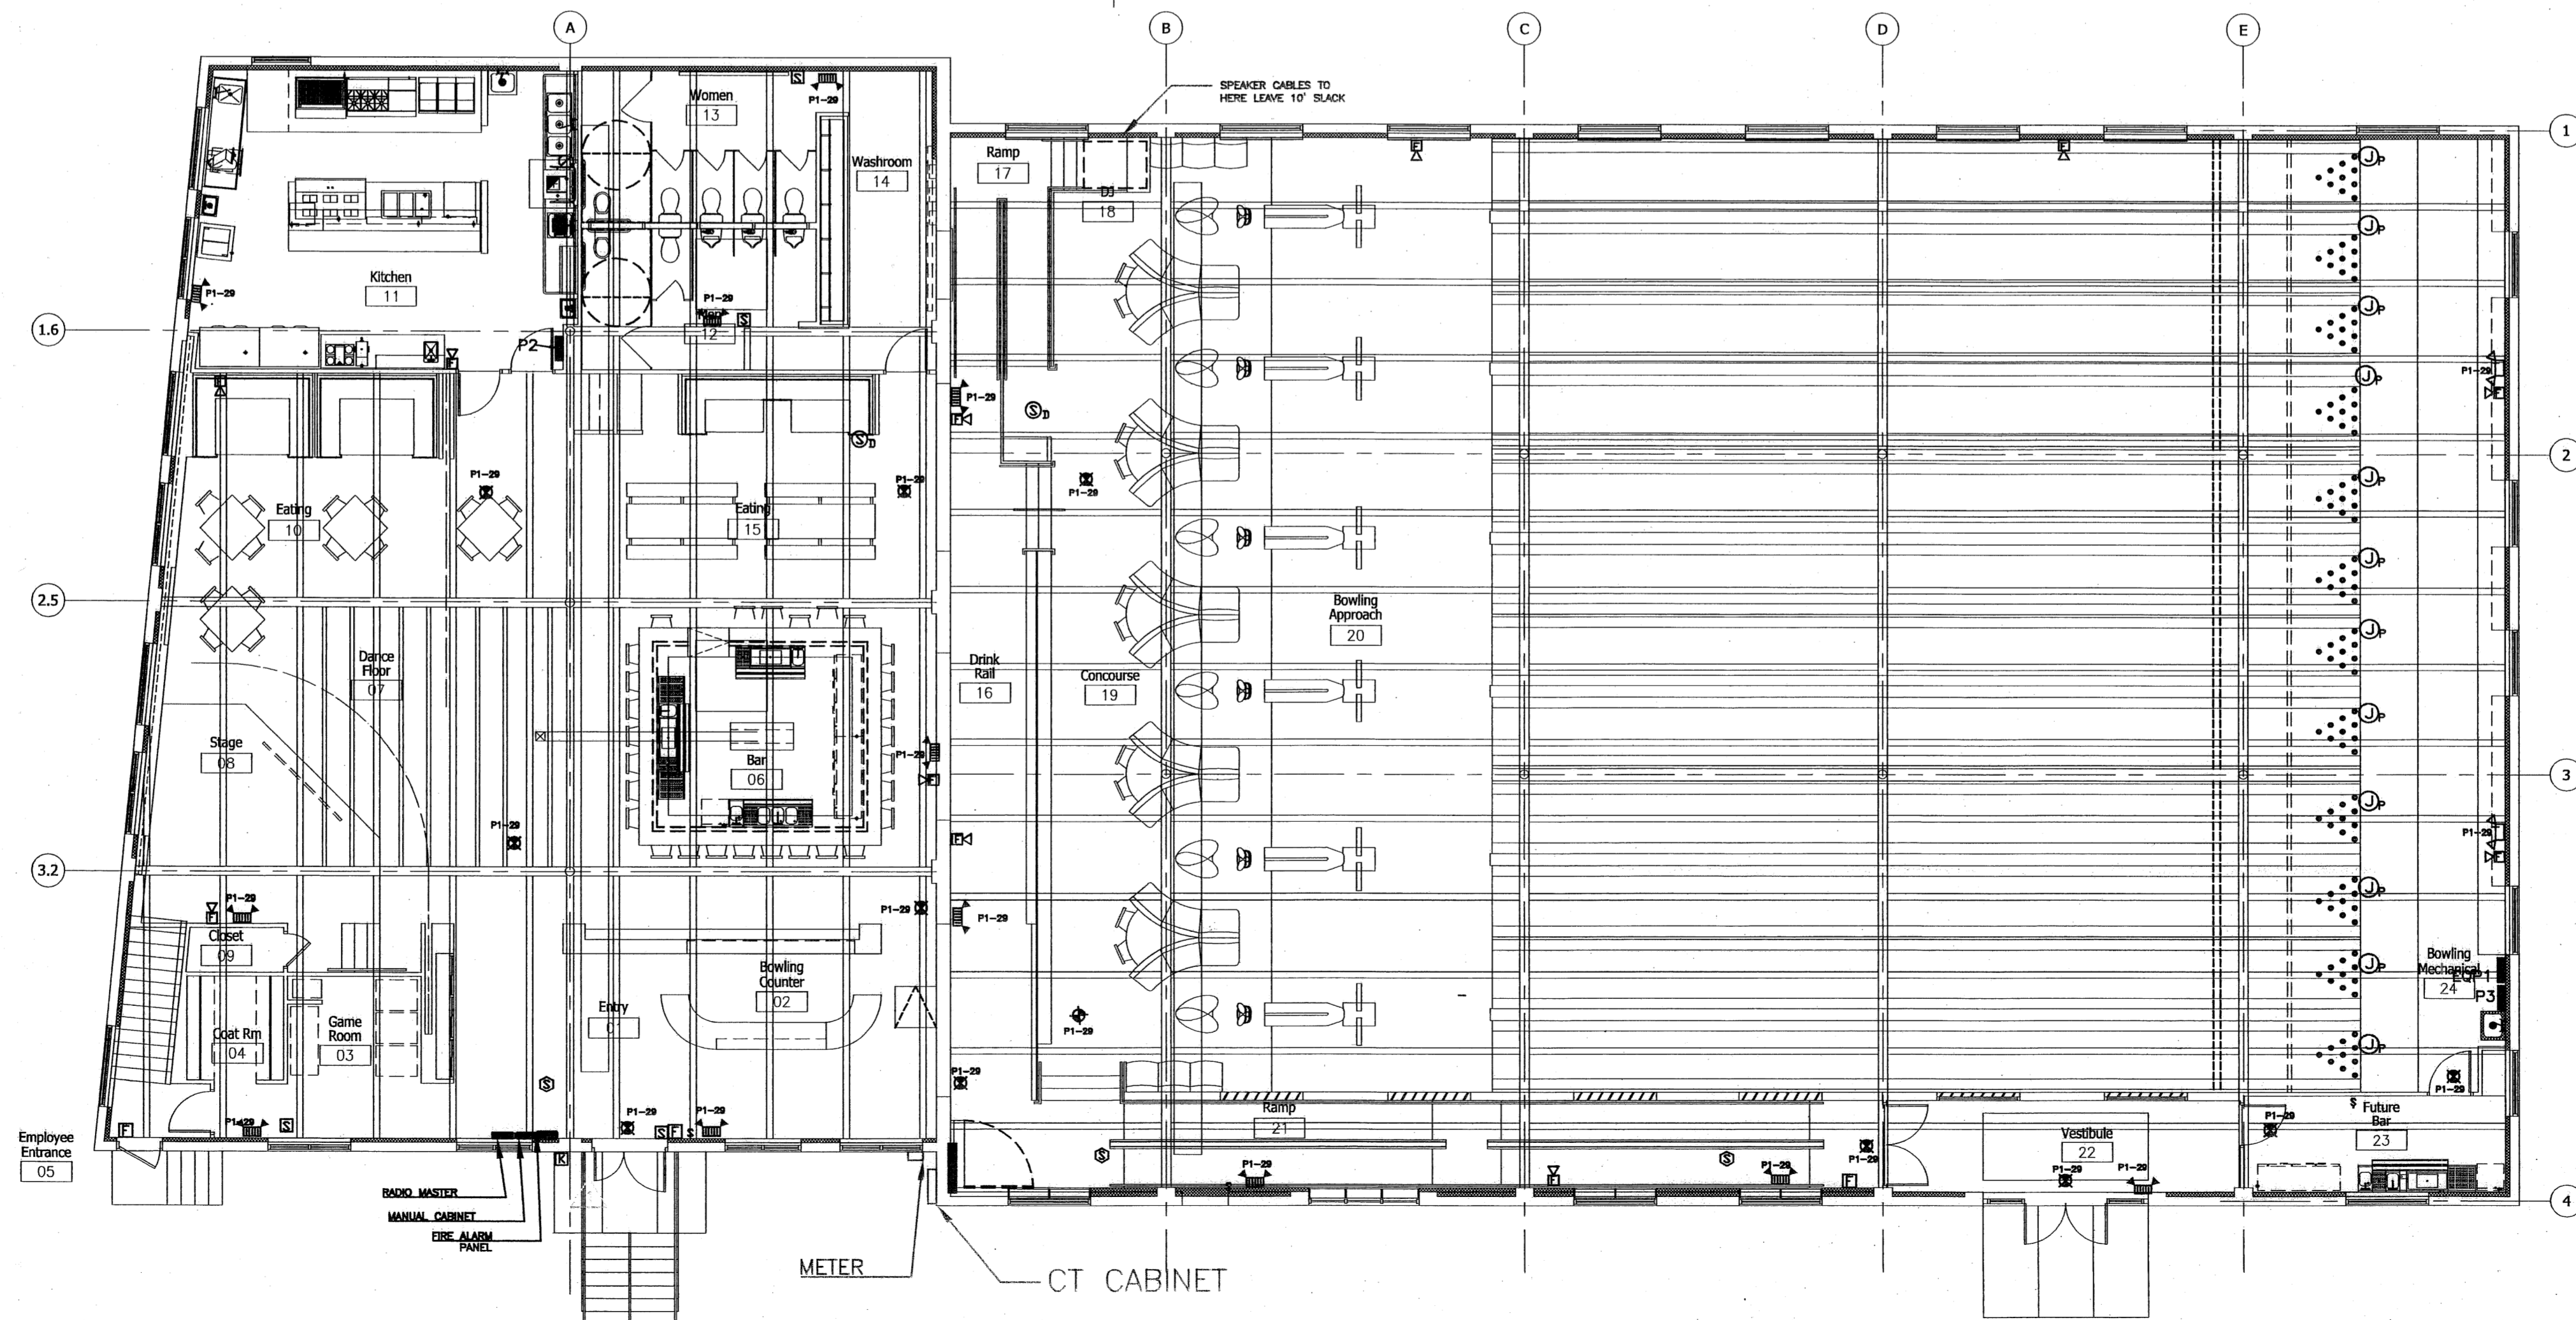


- SGA278
- F FIRE ALARM MANUAL STATION 48" AFF
- GAR-250M
- FK # FIRE ALARM SPEAKER AND STROBE UNIT - MOUNT 80" AFF EXCEPT NO CLOSER THAN 6" TO CEILING. NUMBER DENOTES CANDELA RATING
- T SPRINKLER TAMPER SWITCH
- FL SPRINKLER WATERFLOW SWITCH
- GIRP-VM
- S # FIRE ALARM VISUAL UNIT ( NUMBER DENOTES CANDELA RATING ) 6'8" AFF
- K KNOX BOX
- SGA-PS
- S FIRE ALARM SMOKE DETECTOR 'D' DENOTES DUCT SMOKE DETECTOR
- SGA-SD
- S<sub>D</sub> FIRE ALARM DUCT SMOKE DETECTOR
- 7144/7758
- R RADIO MASTER BOX

**FIRE ALARM SYSTEM**

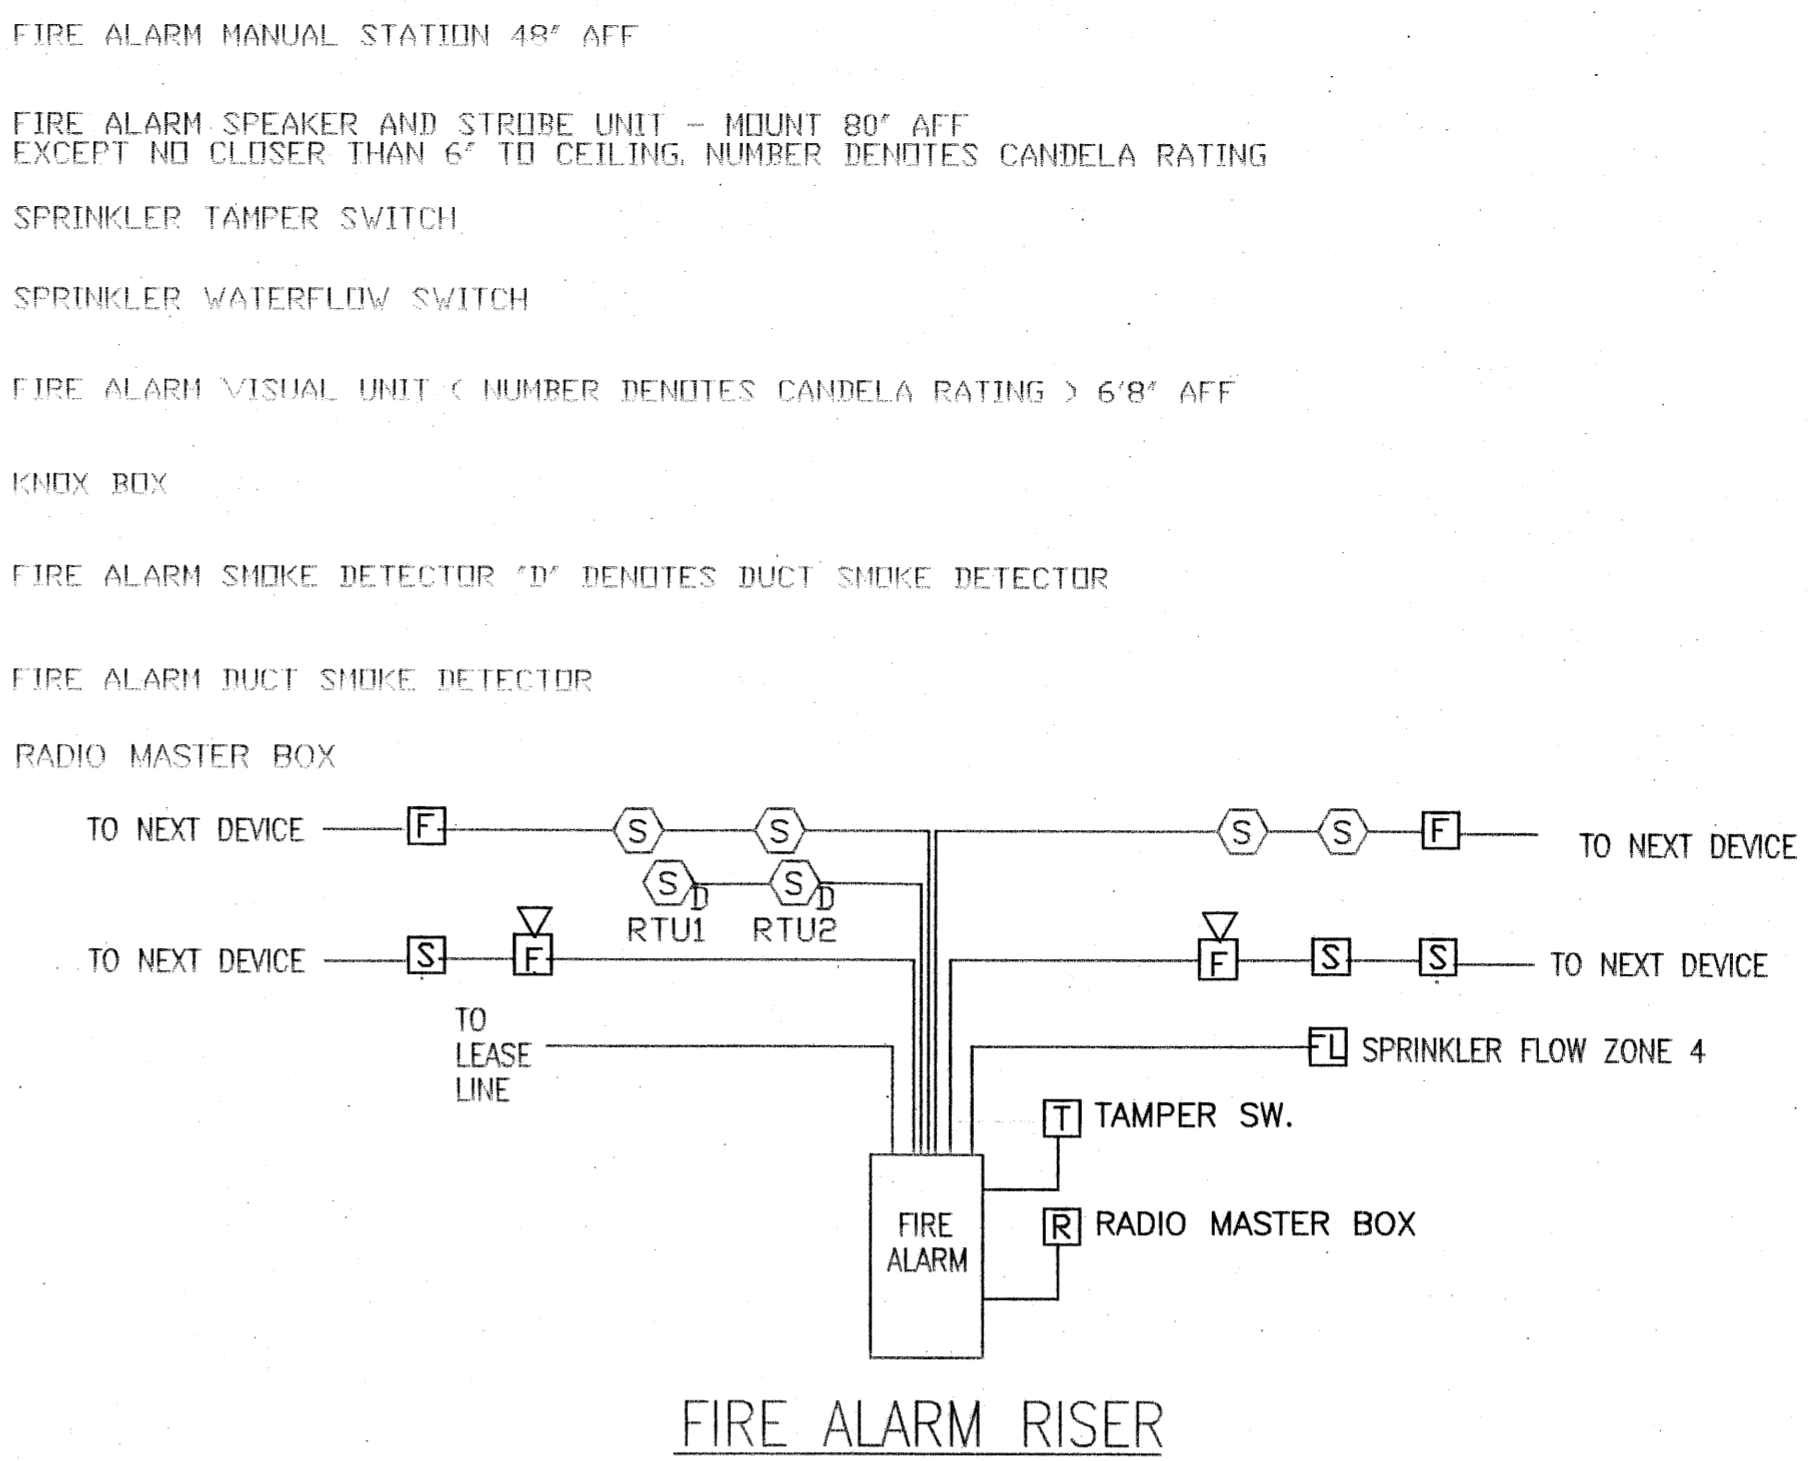

**BH Milliken**  
 ELECTRICAL CONTRACTORS  
 175 ANDERSON STREET  
 PORTLAND, MAINE 04101  
 PHONE: 879-1877  
 FAX: 774-1492  
THESE ELECTRICAL DRAWINGS ARE THE PROPERTY OF B.H. MILLIKEN ELECTRICAL CONTRACTORS INC. AND FOR THEIR USE ONLY.

**BOWL PORTLAND**  
 ALDER STREET  
 PORTLAND, MAINE

TITLE	LIFE SAFETY
SCALE: 1/8"=1'	DATE: 3-9-10
SHEET	
E401	

H:\Main\2010\Bowl\Bowl\Bowl.dwg, 1/11/2010 2:27:05 PM, ARCHD PLOT, 1/11/2010 2:27:05 PM, B.H. MILLIKEN, INC.