



**REFLECTED CEILING PLAN NOTES**

- 1.) SEE ELECTRICAL, MECHANICAL AND SPRINKLER DRAWINGS FOR LOCATIONS OF LIGHTING, EMERGENCY EXIT SIGNS EMERGENCY LIGHTING, MECHANICAL ELEMENTS (DUCTS, VENTS, ETC), SPRINKLER HEADS.
- 2.) G.C. TO ADJUST CEILING GRID AS REQUIRED TO ACCOMMODATE LIGHTING AND MECHANICAL ELEMENTS
- 3.) G.C. TO COORDINATE CEILING LAYOUT WITH TENANT FIT-UP WORK

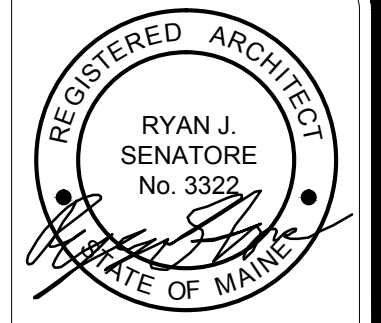

© 2016 RYAN SENATORE ARCHITECTURE

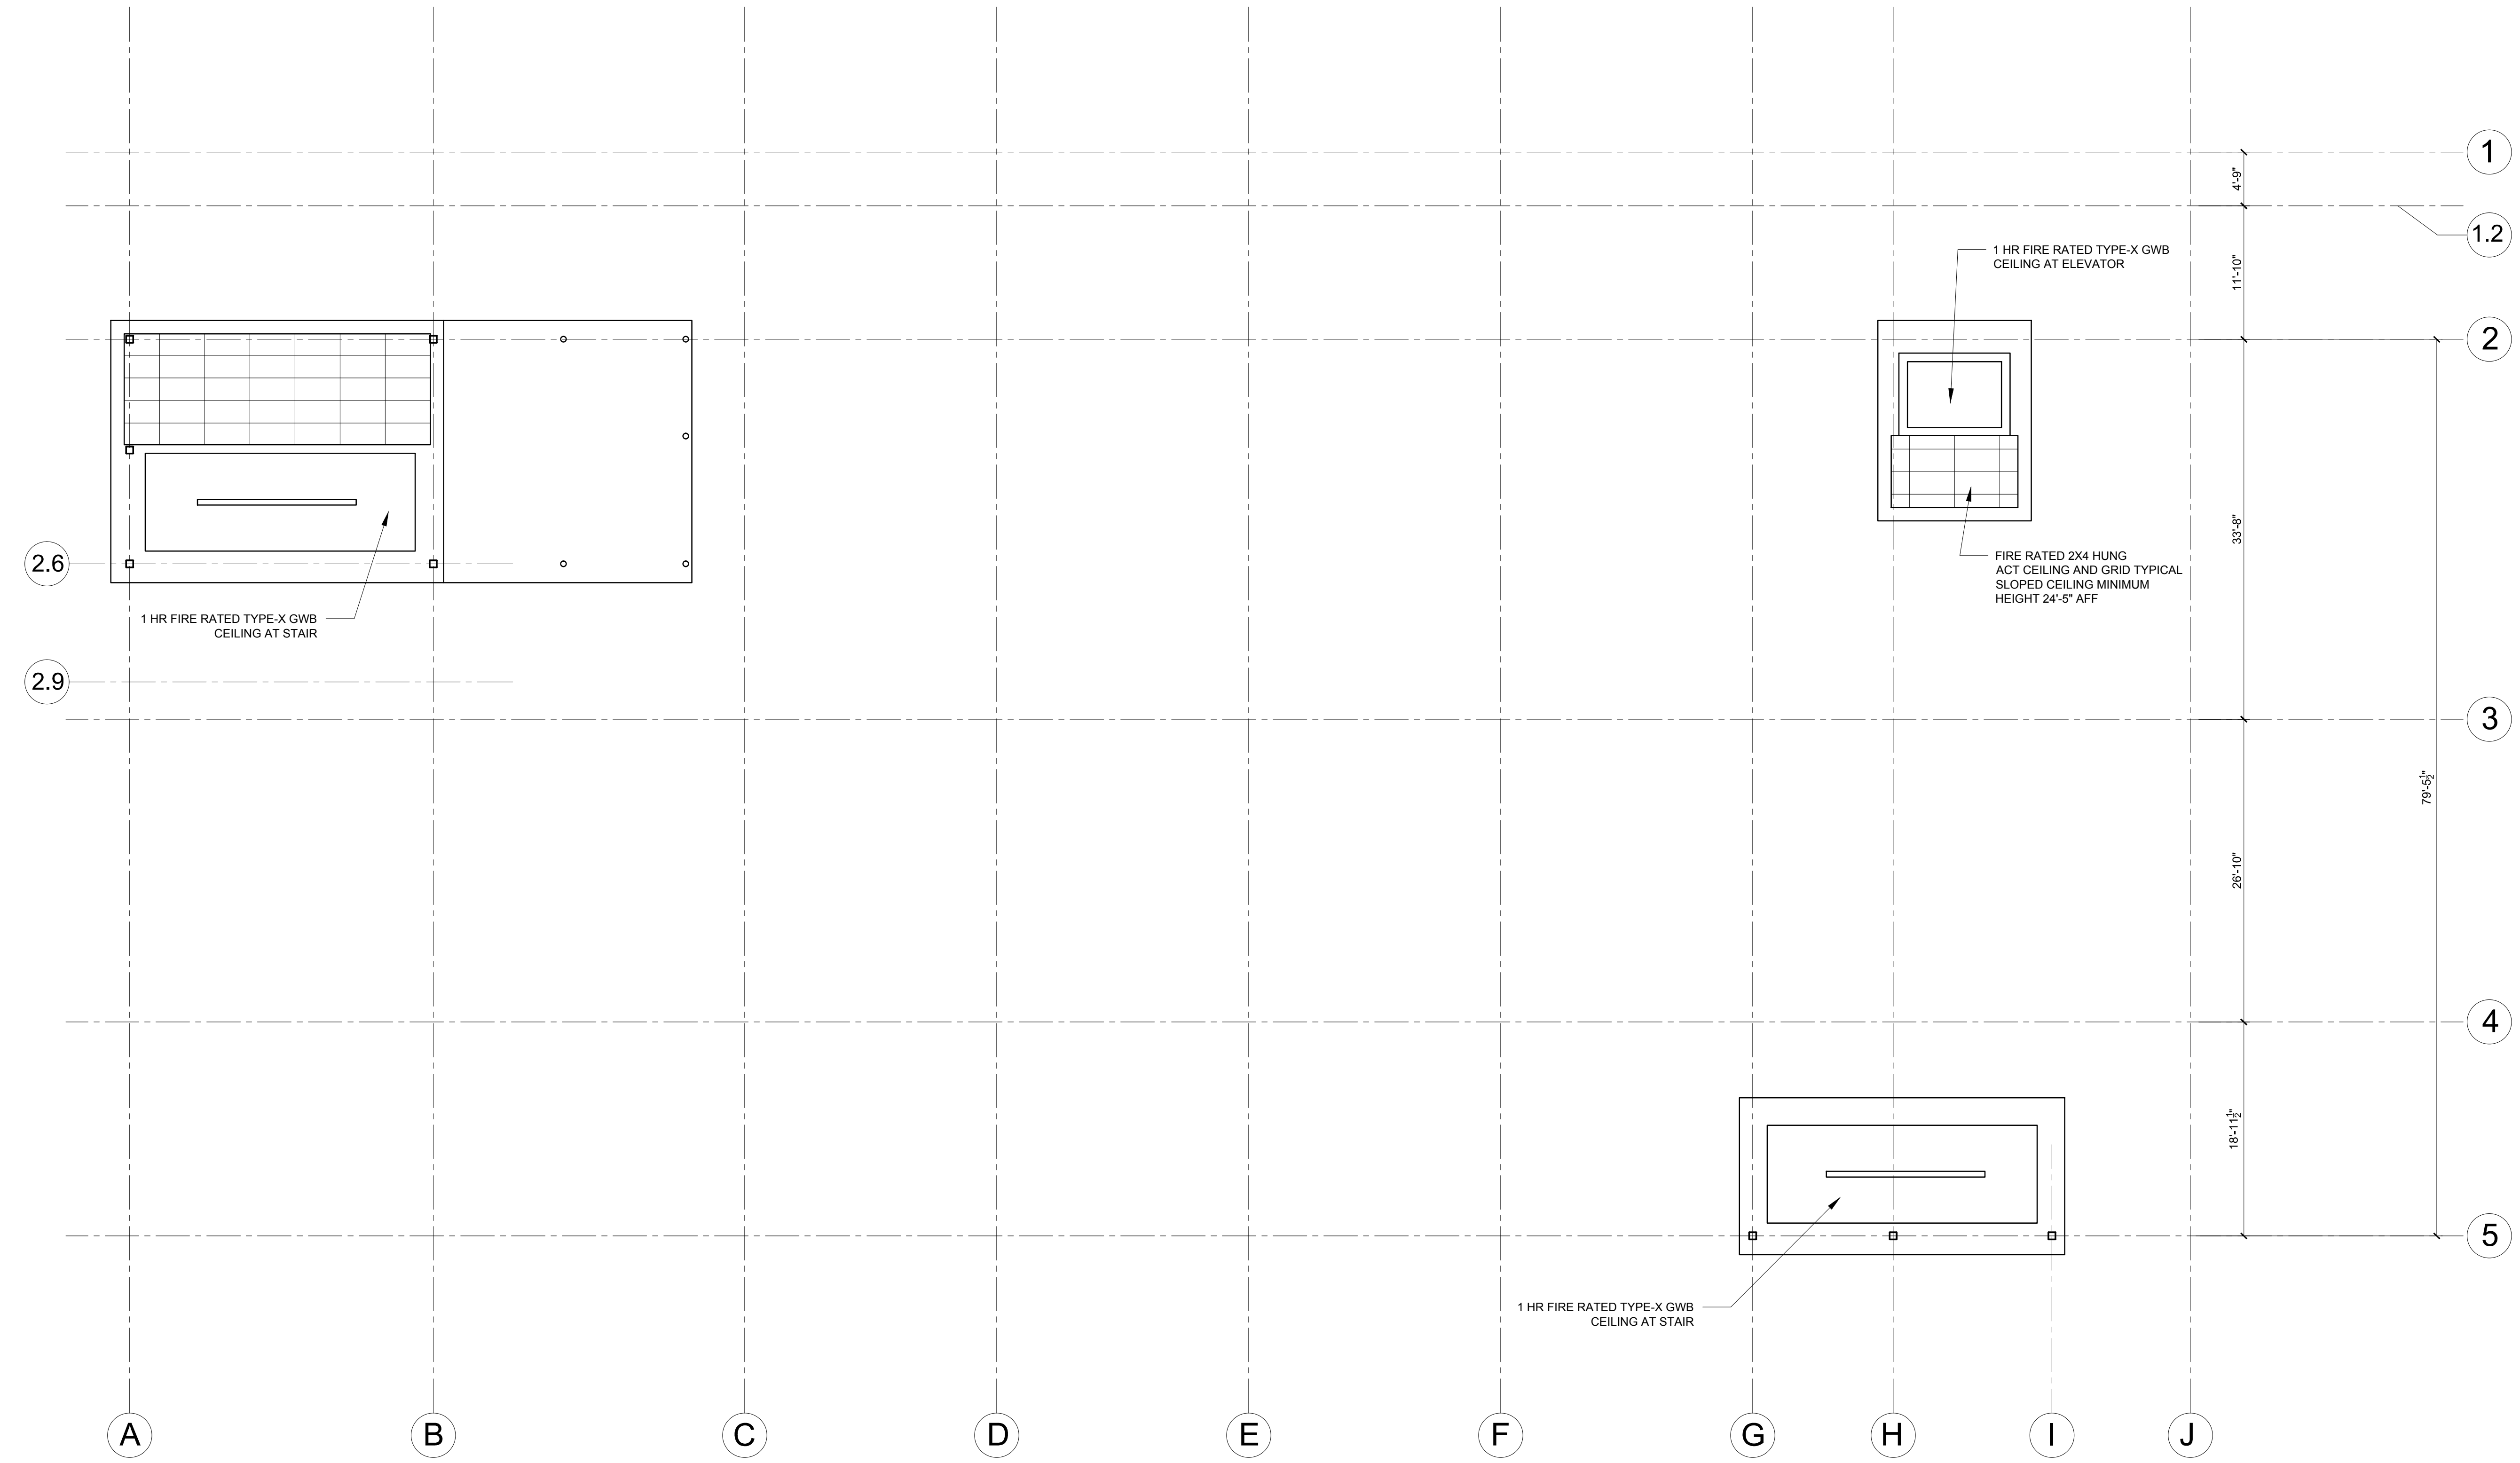

**ADDITION TO BAYSIDE BOWL**  
**ALDER STREET**  
**PORTLAND, MAINE**



**RYAN SENATORE ARCHITECTURE**  
 565 CONGRESS STREET  
 PORTLAND, MAINE 04101  
 207-656-6414  
 senatorearchitecture.com

**CONSULTANTS:**  
**STRUCTURAL:**  
 Structural Integrity  
 77 Oak Street  
 Portland, ME 04101  
 207-774-4814

REVISIONS:

DATE: JANUARY 29, 2016

PROJECT No. 1452

DRAWN BY: JPF / RRT / RJS

CHECKED BY: RJS

SCALE: AS NOTED

SHEET TITLE:  
**ROOF LEVEL REFLECTED CEILING PLAN**

**A1-8**

1 ROOF LEVEL REFLECTED CEILING PLAN  
 1/8" = 1'-0"