


© 2016 RYAN SENATORE ARCHITECTURE

ADDITION TO BAYSIDE BOWL
ALDER STREET
PORTLAND, MAINE

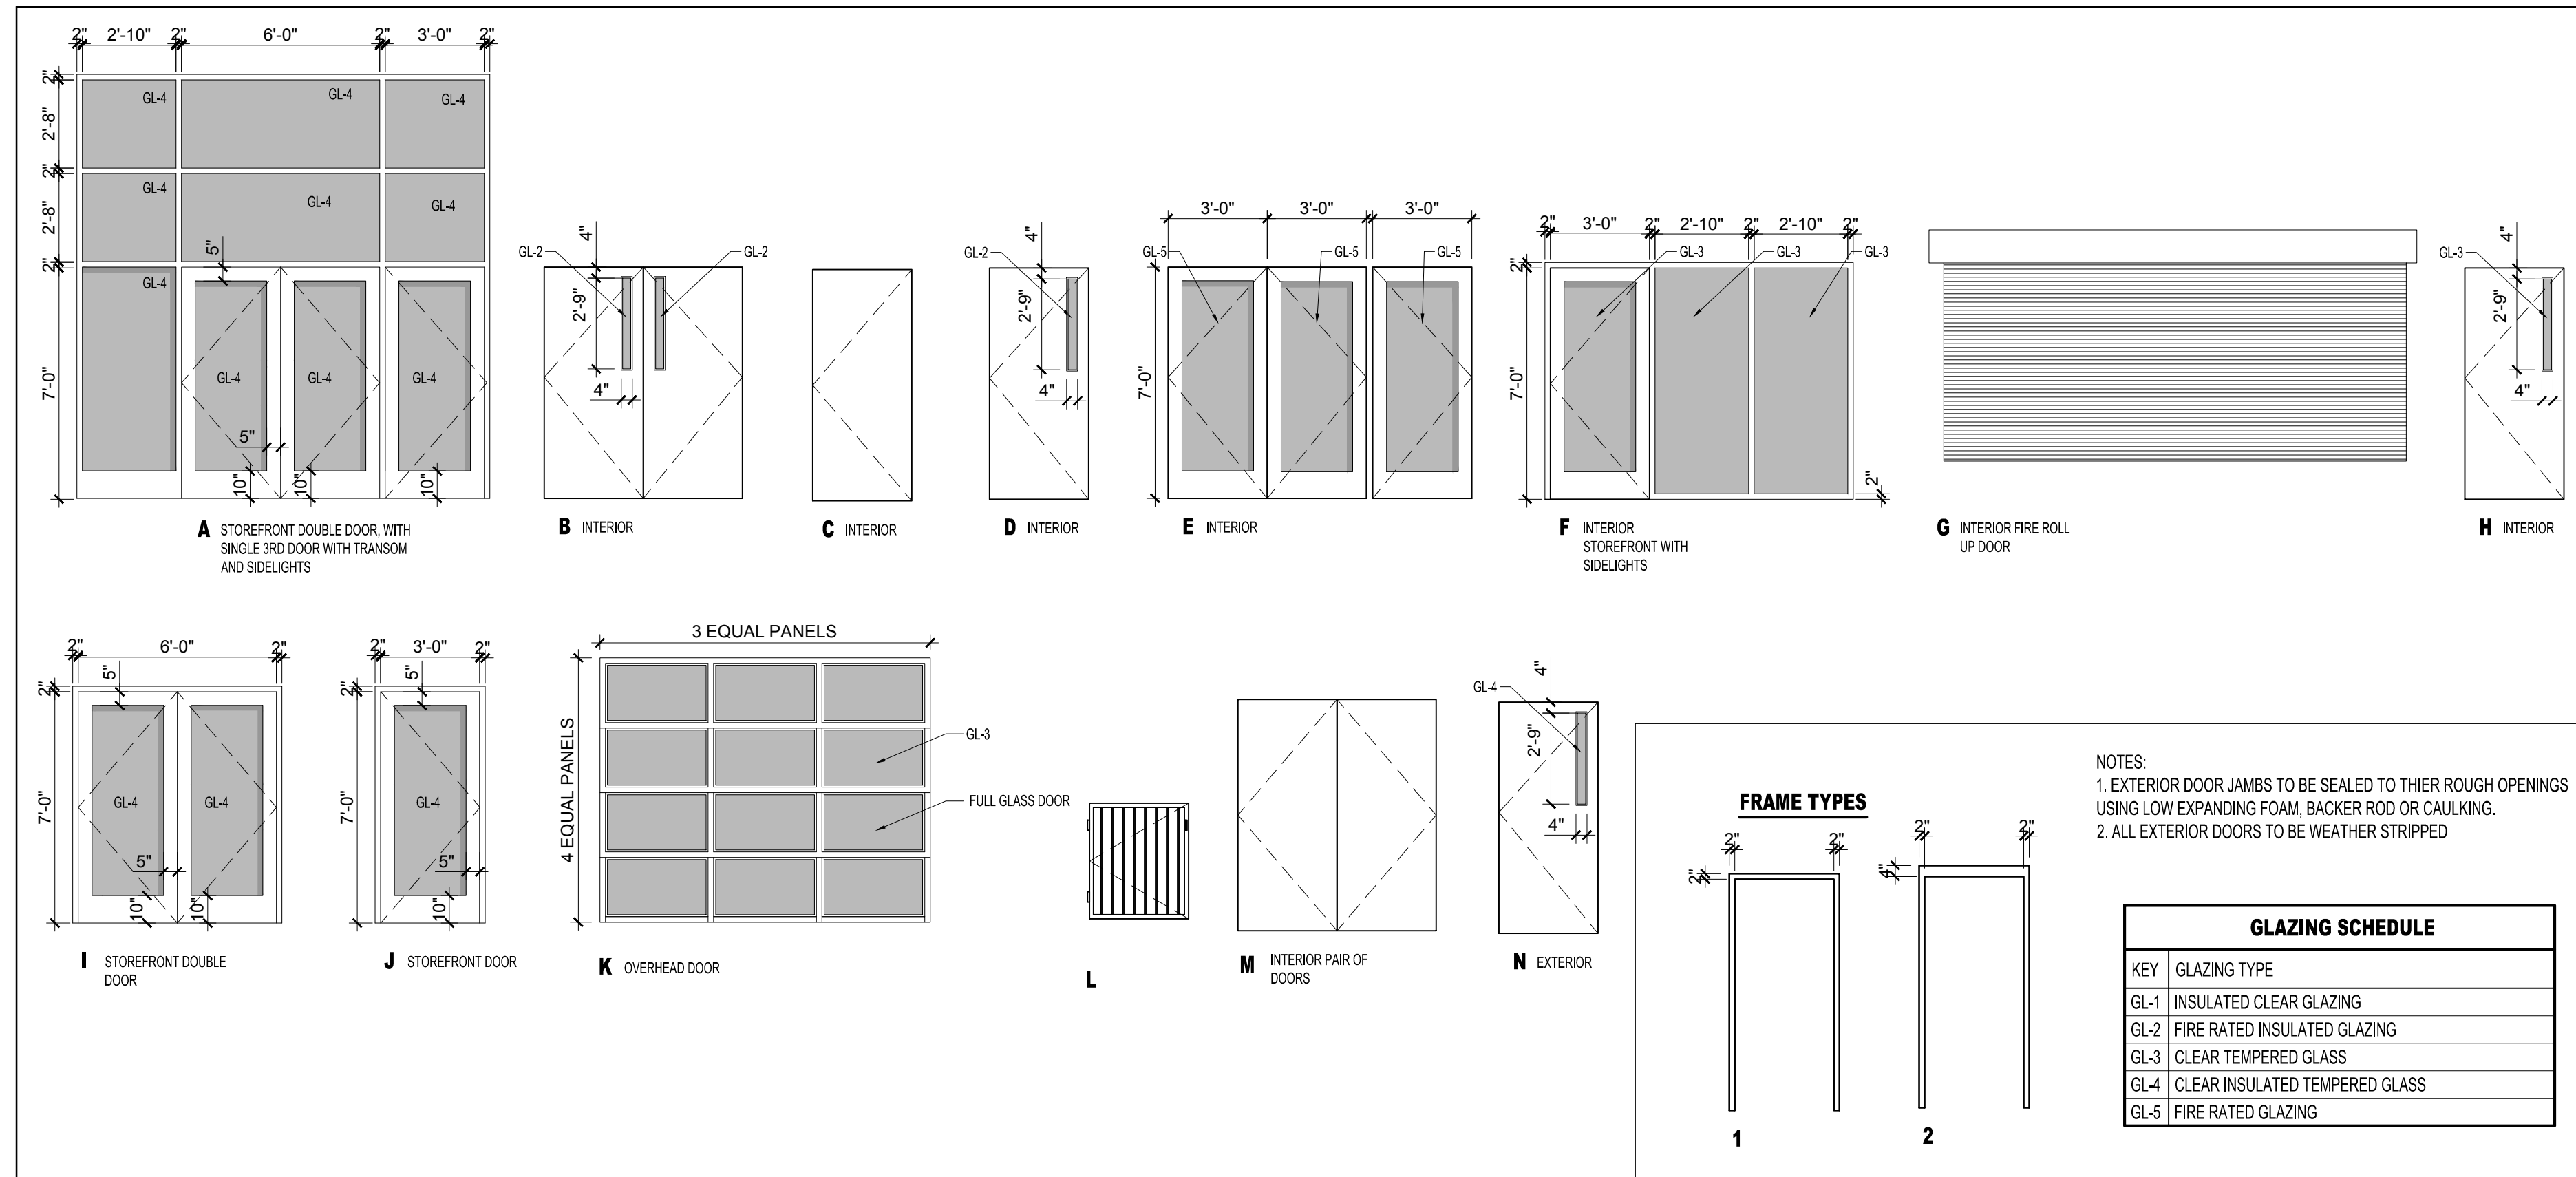

1 DOOR TYPES
 1/4" = 1'-0"

DOOR SCHEDULE																
DOOR NO.	TYPE	DOOR			INSULATED	FRAME					GENERAL					
		WIDTH	HEIGHT	THICKNESS		MATERIAL	THRESHOLD	HEAD	JAMB	SILL	CLOSER	FIRE RATING (MINUTES)	REMARKS			
100.1	A	6'-0"	7'-0"	1-3/4"	AL	PTD	Y	-	AL	AL	-	-	-	Y	-	THERMALLY BROKEN STOREFRONT DOUBLE DOORS, WITH THIRD SINGLE DOOR WITH TRANSOM AND SIDELIGHTS WITH PANIC HARDWARE
100.2	E	9'-0"	7'-0"	1-3/4"	STL	PTD	Y	1	STL	AL	-	-	-	Y	60	FULL GLASS PAIR OF DOORS WITH THIRD SINGLE DOOR WITH 60 MINUTE FIRE RATED GLASS WITH PANIC HARDWARE
102.1	D	3'-0"	7'-0"	1-3/4"	STL	PTD	Y	2	STL	AL	-	-	-	Y	60	PANIC HARDWARE
102.2	L	3'-0"	3'-2"	1-1/2"	STL	PTD	-	-	STL	-	-	-	-	-	-	GATE WITH LATCH HARDWARE
103.1	M	6'-0"	7'-0"	1-3/4"	STL	PTD	-	1	STL	AL	-	-	-	Y	-	PAIR OF DOORS
103.2	H	3'-0"	7'-0"	1-3/4"	STL	PTD	-	1	STL	-	-	-	-	Y	-	-
104.1	F	3'-0"	7'-0"	1-3/4"	AL	PTD	-	-	AL	-	-	-	-	Y	-	STOREFRONT DOOR WITH SIDELIGHTS
104.2	M	6'-0"	7'-0"	1-3/4"	STL	PTD	Y	1	STL	AL	-	-	-	Y	90	PAIR OF DOORS
107.1	B	6'-0"	7'-0"	1-3/4"	STL	PTD	Y	2	STL	AL	-	-	-	Y	90	PAIR OF DOORS, MAGNETIC HOLD OPENS TIED TO FIRE ALARM SYSTEM
107.2	G	14'-0"	7'-0"	-	STL	PTD	-	-	STL	-	-	-	-	Y	90	FIRE RATED OVERHEAD ROLLING DOOR WITH AUTOMATIC CLOSER TIED TO FIRE ALARM SYSTEM WITH LASER EYE SAFETY FEATURE, OVERHEAD DOOR MODEL 640 COUNTER DOOR, FUSEABLE LINK
109.1	C	3'-0"	7'-0"	1-3/4"	STL	PTD	Y	1	STL	-	-	-	-	Y	-	-
110.1	C	3'-0"	7'-0"	1-3/4"	STL	PTD	Y	1	STL	-	-	-	-	Y	-	-
111.1	D	3'-0"	7'-0"	1-3/4"	STL	PTD	Y	2	STL	AL	-	-	-	Y	90	-
111.2	H	3'-0"	7'-0"	1-3/4"	STL	PTD	-	1	STL	-	-	-	-	Y	-	FREE PUSH HARDWARE (SERVING DOOR) NIGHT LOCK FUNCTION
111.3	H	3'-0"	7'-0"	1-3/4"	STL	PTD	-	1	STL	-	-	-	-	Y	-	FREE PUSH HARDWARE (SERVING DOOR) NIGHT LOCK FUNCTION
112.1	I	6'-0"	7'-0"	1-3/4"	AL	PTD	Y	-	AL	AL	-	-	-	Y	-	THERMALLY BROKEN STOREFRONT DOUBLE DOORS
112.2	C	3'-0"	7'-0"	1-3/4"	STL	PTD	-	1	STL	-	-	-	-	Y	-	-
114.1	D	3'-0"	7'-0"	1-3/4"	STL	PTD	Y	2	STL	AL	-	-	-	Y	60	PANIC HARDWARE
114.2	J	3'-0"	7'-0"	1-3/4"	AL	PTD	Y	-	AL	AL	-	-	-	Y	-	THERMALLY BROKEN STOREFRONT DOOR WITH PANIC HARDWARE
114.3	L	3'-0"	3'-2"	1-1/2"	STL	PTD	-	-	STL	-	-	-	-	-	-	GATE WITH LATCH HARDWARE
115.1	J	3'-0"	7'-0"	1-3/4"	AL	PTD	Y	-	AL	AL	-	-	-	Y	-	THERMALLY BROKEN STOREFRONT DOOR WITH PANIC HARDWARE
115.2	H	3'-0"	7'-0"	1-3/4"	STL	PTD	-	1	STL	-	-	-	-	Y	-	-
115.3	K	10'-0"	8'-0"	1-3/4"	AL	PTD	-	-	AL	-	-	-	-	-	-	FULL GLASS OVERHEAD DOOR WITH CHAIN PULL LOCK
117.1	N	3'-0"	7'-0"	1-3/4"	STL	PTD	Y	1	STL	AL	-	-	-	Y	-	PANIC HARDWARE, THERMALLY BROKEN DOOR AND FRAME
201.1	C	3'-0"	7'-0"	1-3/4"	STL	PTD	Y	2	STL	AL	-	-	-	Y	60	PANIC HARDWARE
203.1	D	3'-0"	7'-0"	1-3/4"	STL	PTD	Y	2	STL	AL	-	-	-	Y	60	PANIC HARDWARE
217.1	D	3'-0"	7'-0"	1-3/4"	STL	PTD	Y	2	STL	AL	-	-	-	Y	60	PANIC HARDWARE
300.1	J	3'-0"	7'-0"	1-3/4"	AL	PTD	Y	-	AL	AL	-	-	-	Y	-	THERMALLY BROKEN STOREFRONT DOOR WITH PANIC HARDWARE
301.1	D	3'-0"	7'-0"	1-3/4"	STL	PTD	Y	2	STL	AL	-	-	-	Y	60	PANIC HARDWARE
303.1	D	3'-0"	7'-0"	1-3/4"	STL	PTD	Y	2	STL	AL	-	-	-	Y	60	PANIC HARDWARE
304.1	D	3'-0"	7'-0"	1-3/4"	STL	PTD	Y	2	STL	AL	-	-	-	Y	60	PANIC HARDWARE

RSA
 RYAN SENATORE ARCHITECTURE
 565 CONGRESS STREET
 PORTLAND, MAINE 04101
 207-650-6414
 senatorearchitecture.com

CONSULTANTS:
 STRUCTURAL: Structural Integrity
 77 Oak Street
 Portland, ME 04101
 207-774-4614

REVISIONS:

DATE: JANUARY 29, 2016

PROJECT No. 1452

DRAWN BY: JPF / RRT / RJS

CHECKED BY: RJS

SCALE: AS NOTED

SHEET TITLE:
DOOR SCHEDULE