

ADDITION TO BAYSIDE BOWL
ALDER STREET
PORTLAND, MAINE

CONSULTANTS:

ELECTRICAL:
BENNETT ENGINEERING
7 BENNETT ROAD
FREEPORT, ME 04032
207-865-9475



**BENNETT
ENGINEERING**
MECHANICAL - ELECTRICAL
(207) 865-9475

REVISIONS:

03/24/2016 PERMIT SET

DATE: 18 MAR 2016


PROJECT No. ...

DRAWN BY: CAT

CHECKED BY: SAJ

SCALE: 1/8" = 1'-0" U.N.O.

SHEET TITLE:
FIRST FLOOR
LIGHTING PLAN

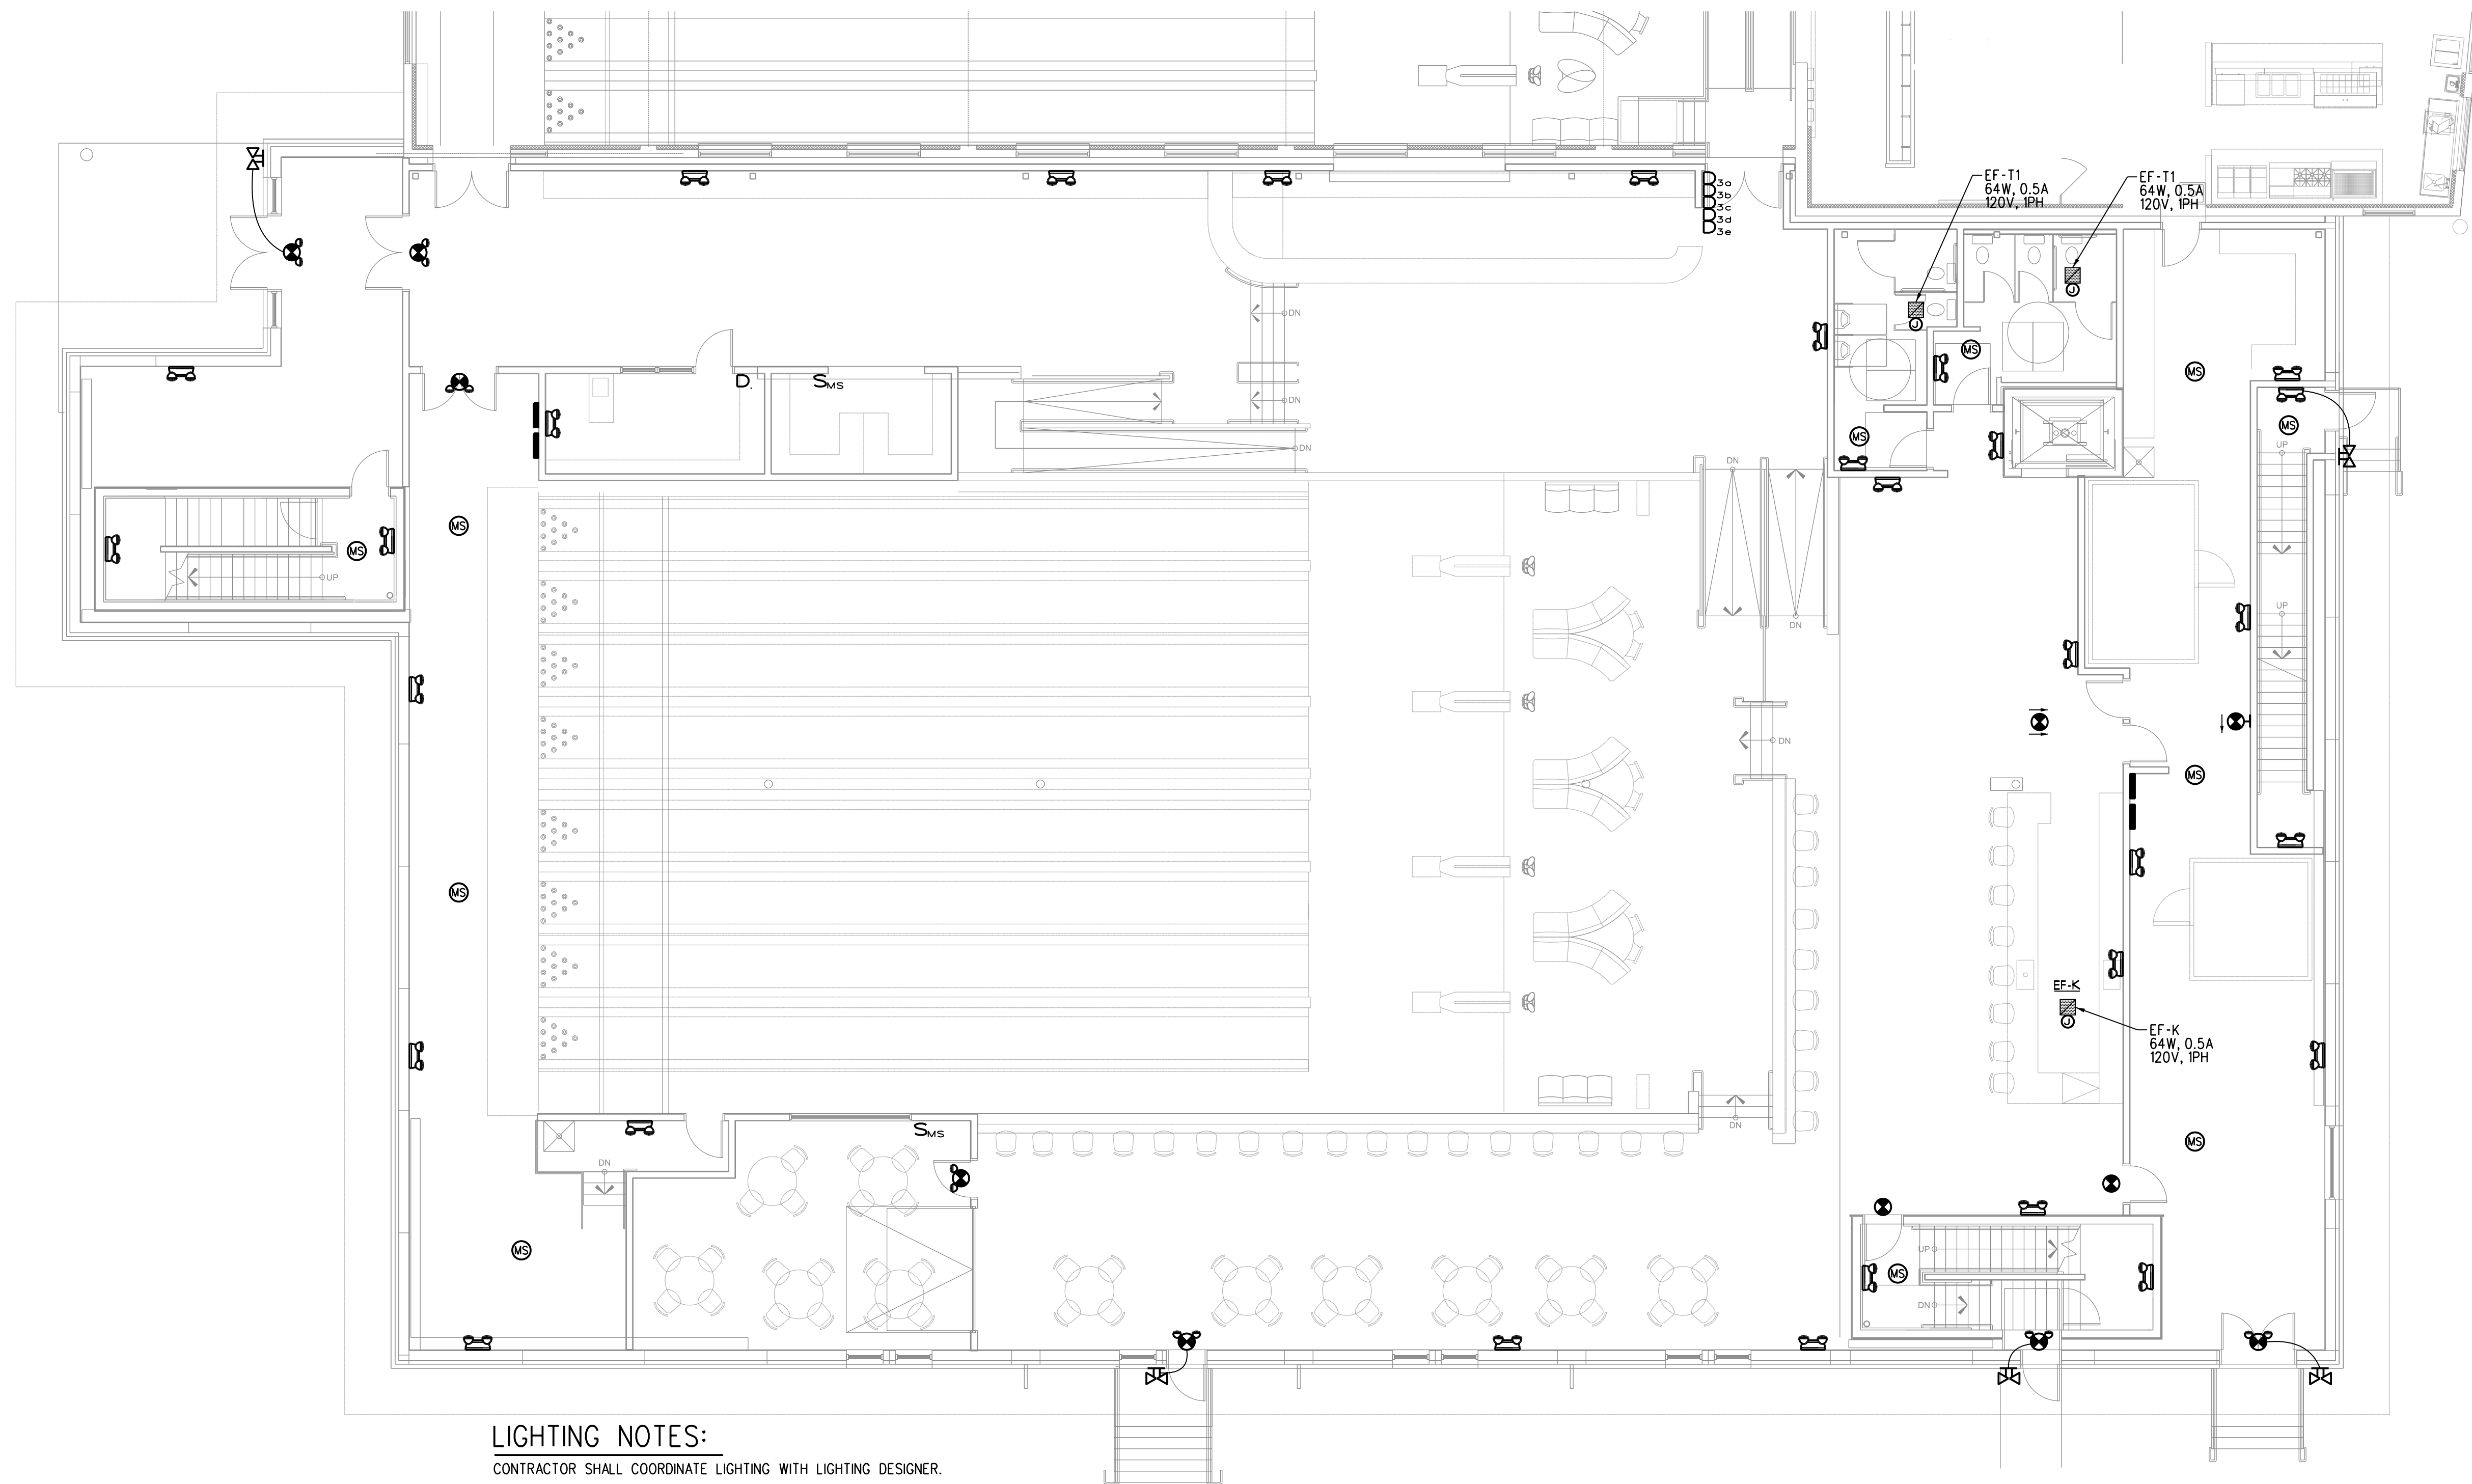

LIGHTING NOTES:
CONTRACTOR SHALL COORDINATE LIGHTING WITH LIGHTING DESIGNER.

FIRST FLOOR LIGHTING PLAN
SCALE: 1/8" = 1'-0"