

ADDITION TO BAYSIDE BOWL  
ALDER STREET  
PORTLAND, MAINE

CONSULTANTS:

ELECTRICAL:  
BENNETT ENGINEERING  
7 BENNETT ROAD  
FREEPORT, ME 04032  
207-865-9475



**BENNETT  
ENGINEERING**  
MECHANICAL - ELECTRICAL  
(207) 865-9475

REVISIONS:

03/24/2016 PERMIT SET

DATE: 18 MAR 2016

PROJECT No. ...

DRAWN BY: CAT


CHECKED BY: SAJ

SCALE: 1/8" = 1'-0" U.N.O.

SHEET TITLE:

MEZZANINE  
POWER PLAN

E2.2

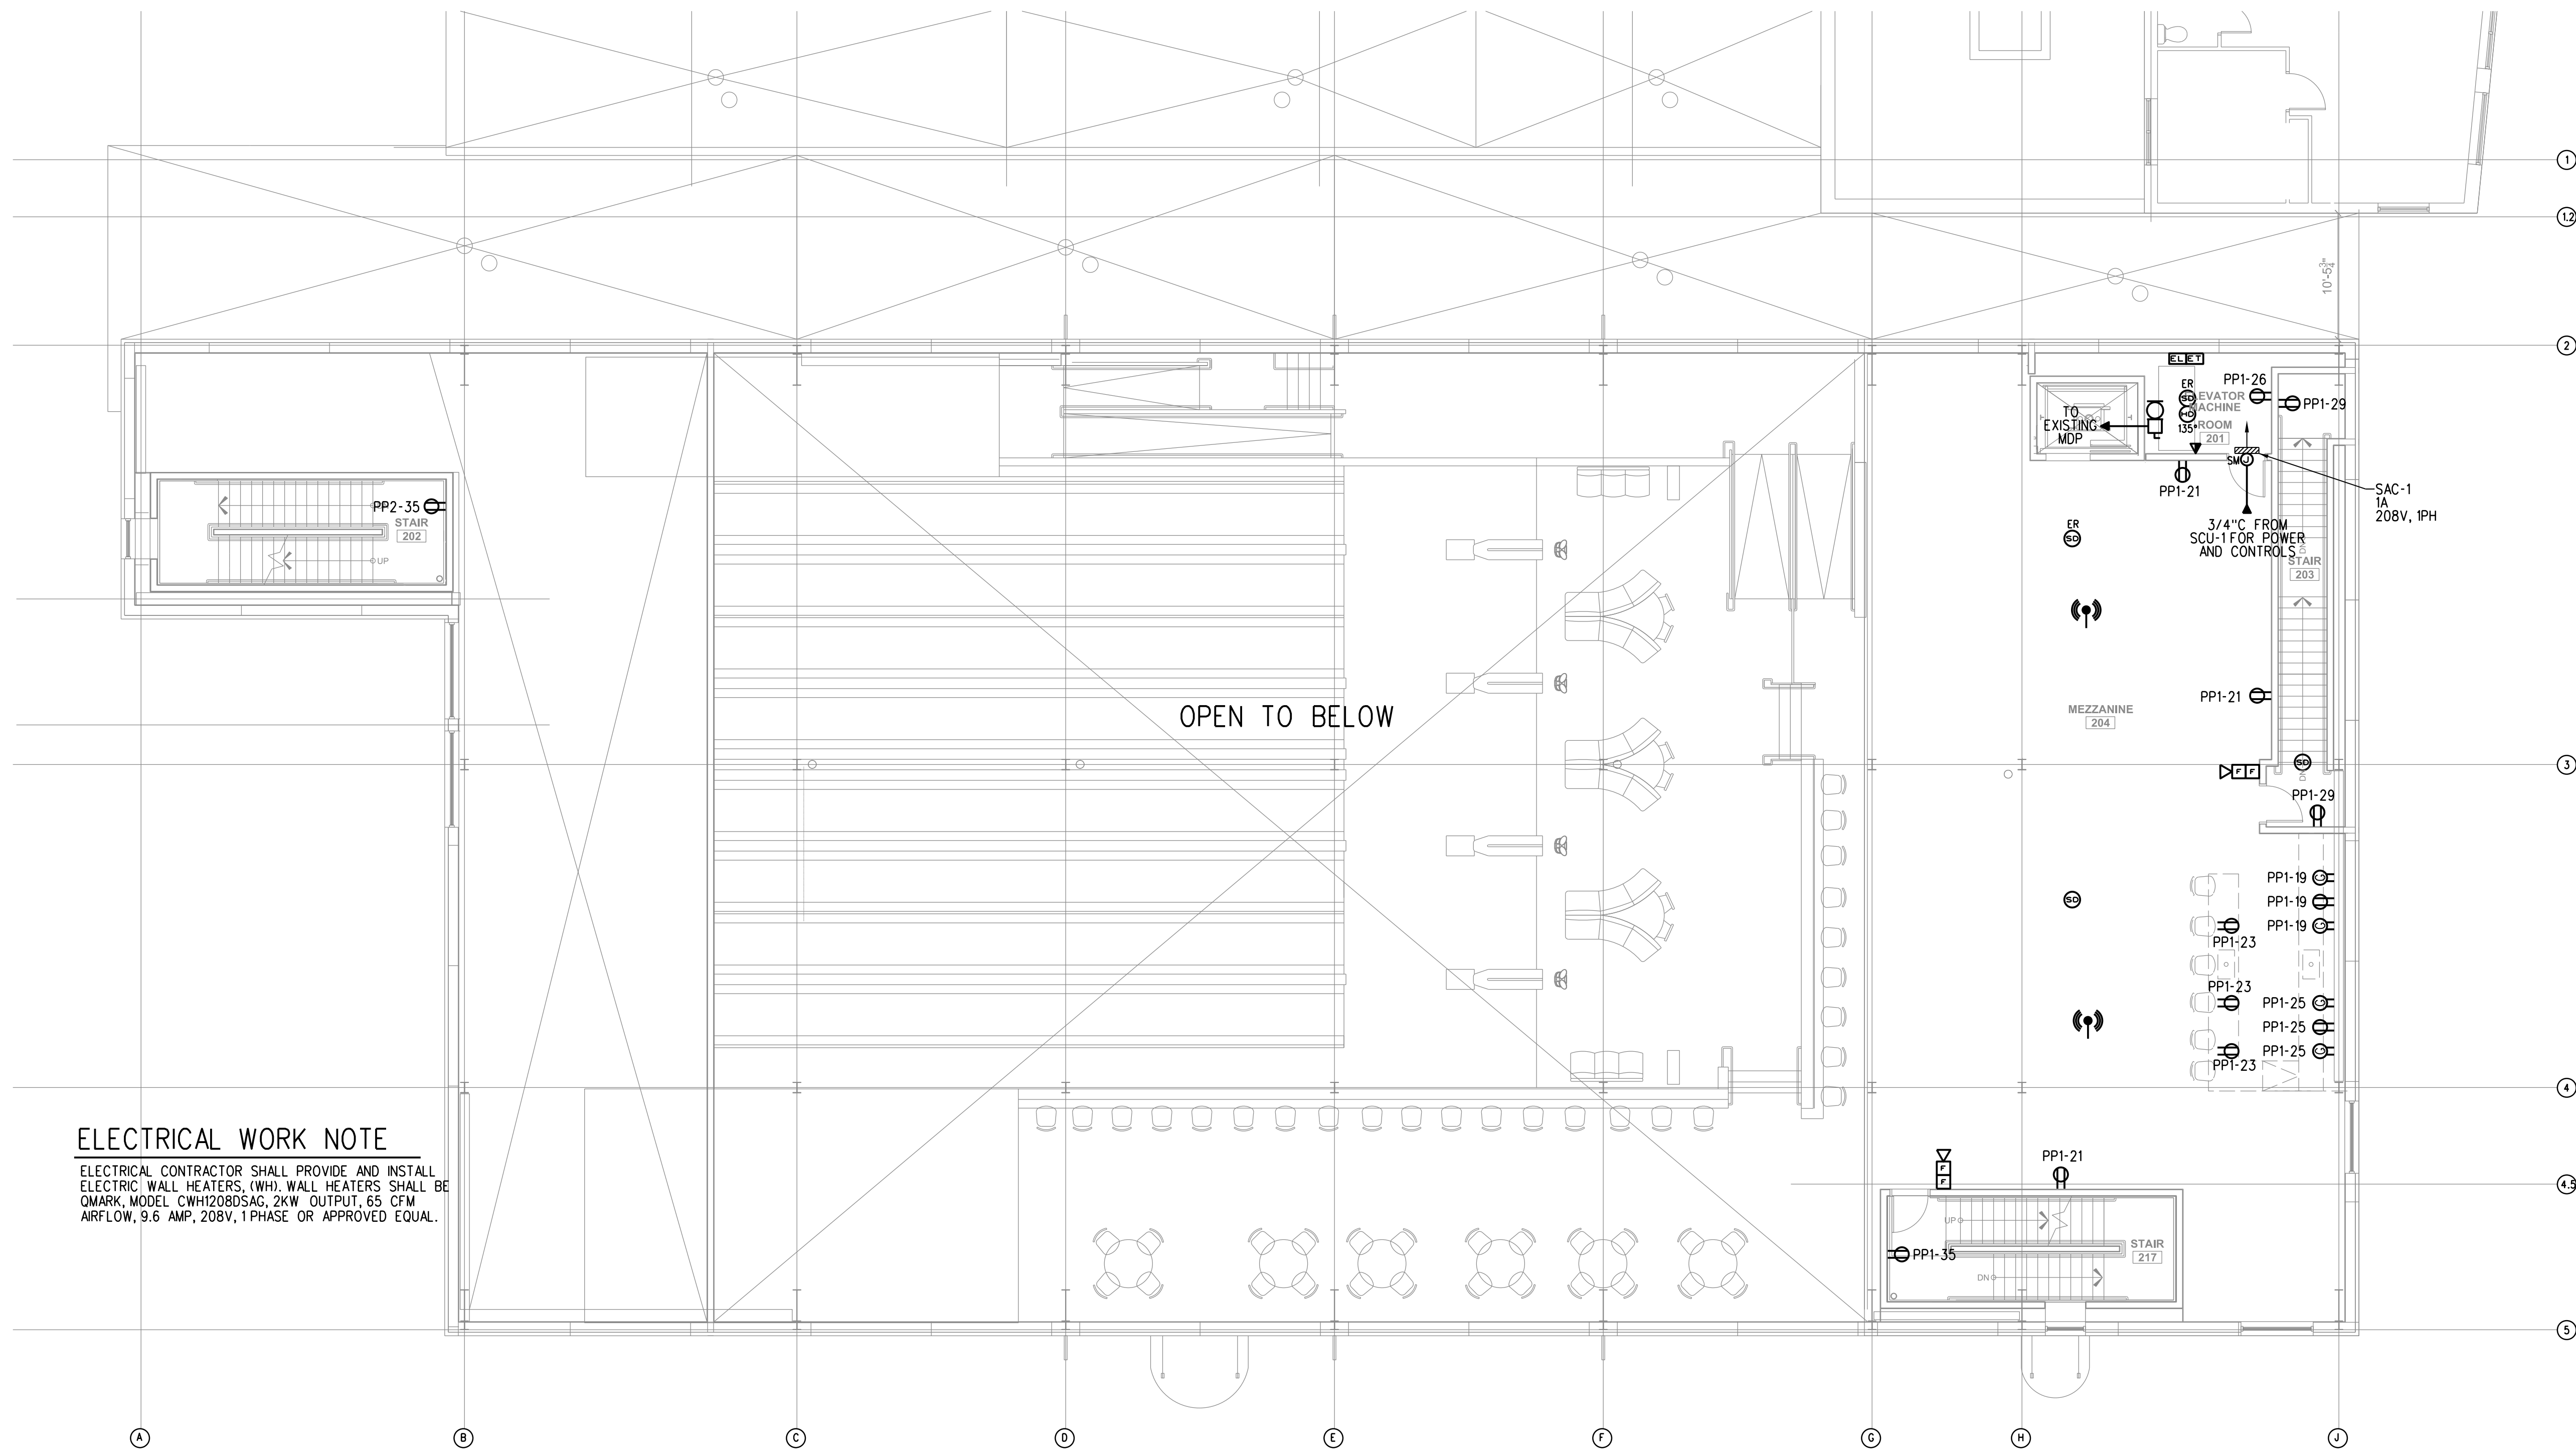

**ELECTRICAL WORK NOTE**

ELECTRICAL CONTRACTOR SHALL PROVIDE AND INSTALL  
ELECTRIC WALL HEATERS (WH). WALL HEATERS SHALL BE  
OMARK, MODEL CWH120BDSAG, 2KW OUTPUT, 65 CFM  
AIRFLOW, 9.6 AMP, 208V, 1PHASE OR APPROVED EQUAL.

OPEN TO BELOW

**MEZZANINE POWER PLAN**

SCALE: 1/8" = 1'-0"