

ADDITION TO BAYSIDE BOWL
 ALDER STREET
 PORTLAND, MAINE

CONSULTANTS:



REVISIONS:
 03/24/2016 PERMIT SET

DATE: 18 MAR 2016


PROJECT No. ...

DRAWN BY: SP Doel

CHECKED BY: SP Doel

SCALE: 1/8" = 1'-0" U.N.O.

SHEET TITLE:
 PLUMBING DETAILS

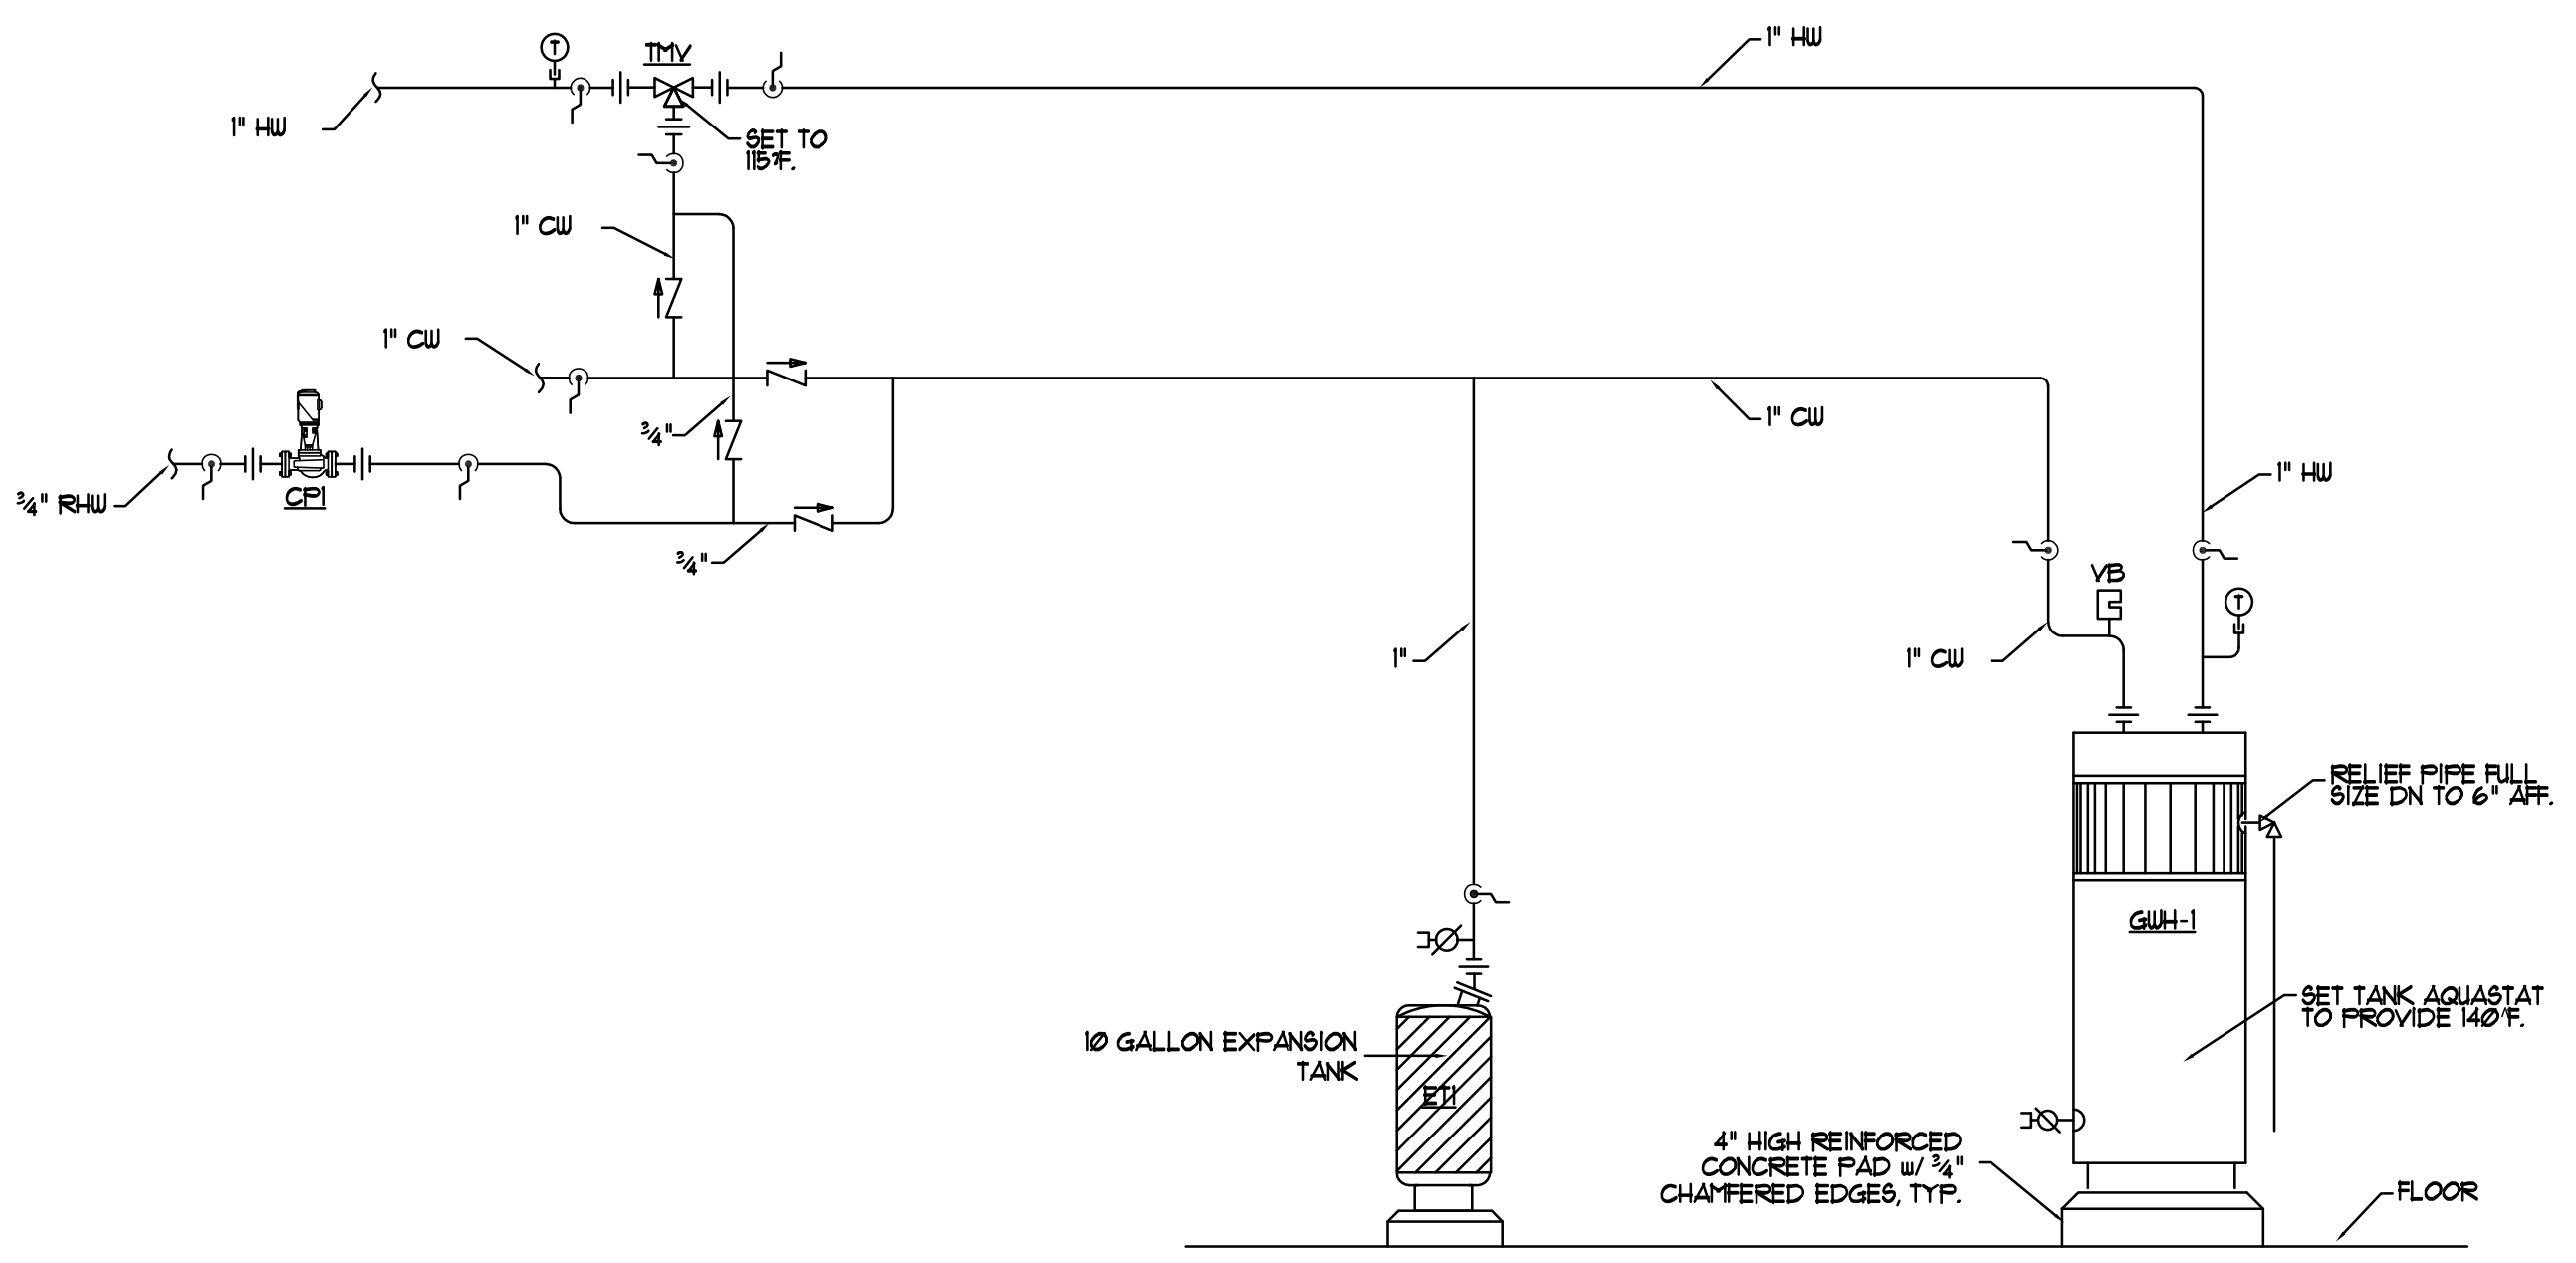

DOMESTIC HOT WATER PIPING SCHEMATIC
 NTS