


© 2016 RYAN SENATORE ARCHITECTURE

Provide comcheck.

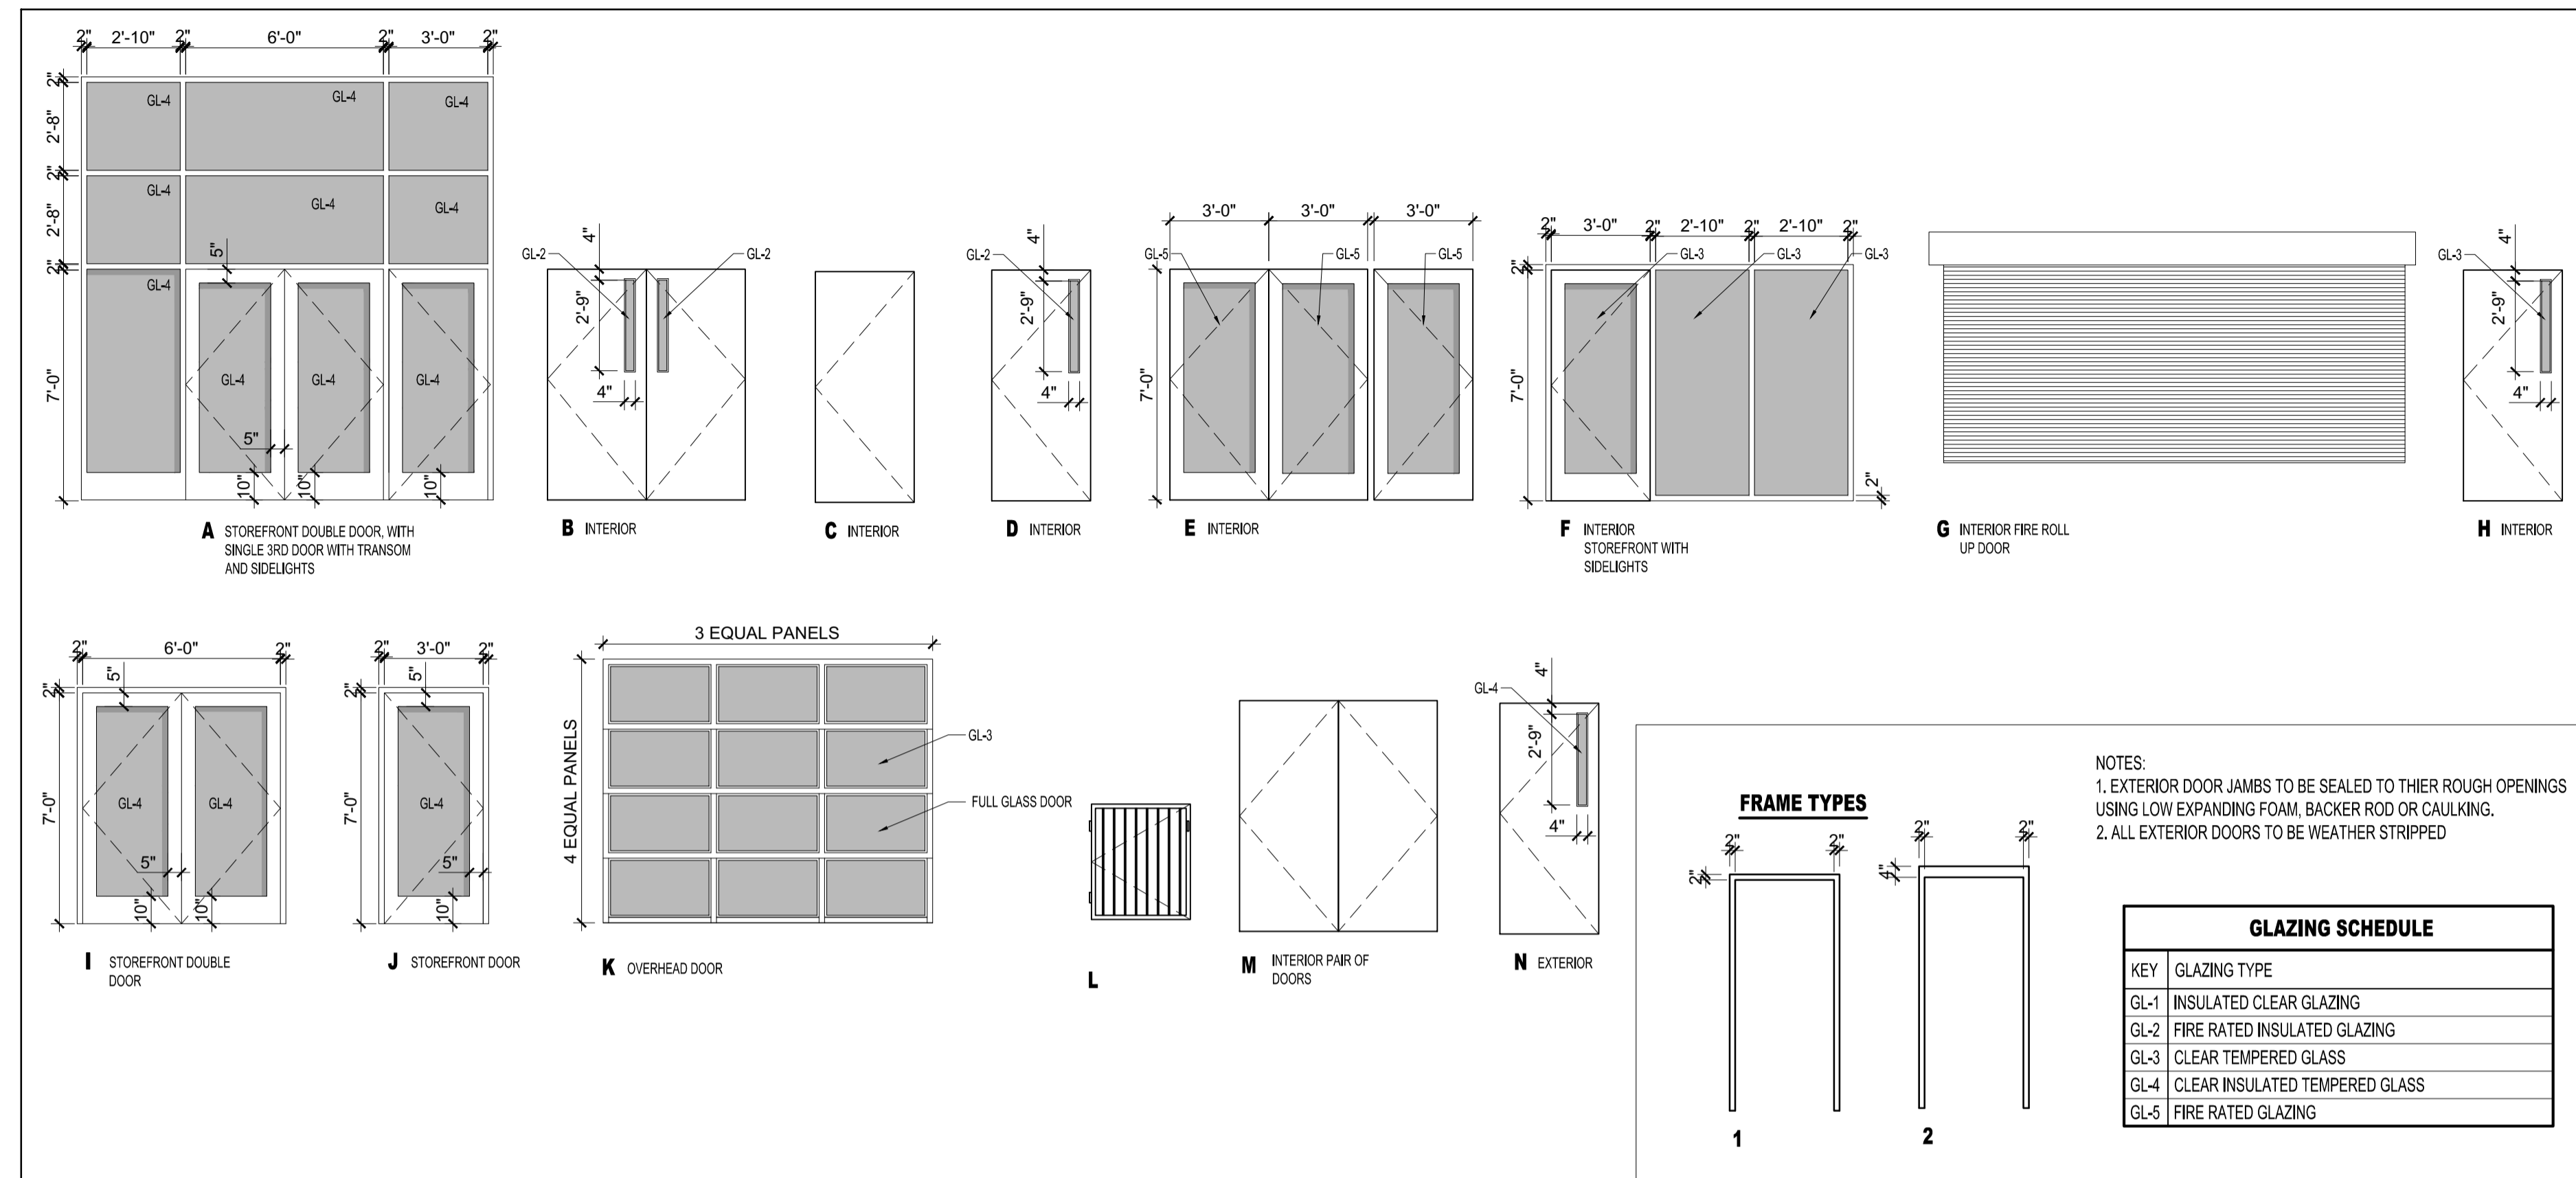

1 DOOR TYPES
1/4" = 1'-0"

DOOR NO.	DOOR				FRAME					GENERAL		REMARKS			
	TYPE	SIZE			MATERIAL	FINISH	INSULATED	TYPE	DETAILS				FIRE RATING (MINUTES)	HARDWARE KEY ML - MORTISE LOCK SET LS - LOCK SET PR - PRIVACY SET PS - PASSAGE SET UP - UPPER FULL PI - PEEPHOLE LENSE	
		WIDTH	HEIGHT	THICKNESS					THRESHOLD	HEAD	JAMB				SILL
100.1	A	6'-0"	7'-0"	1-3/4"	AL	PTD	Y	-	AL	AL	-	-	Y	-	THERMALLY BROKEN STOREFRONT DOUBLE DOORS, WITH THIRD SINGLE DOOR WITH TRANSOM AND SIDELIGHTS WITH PANIC HARDWARE
100.2	E	9'-0"	7'-0"	1-3/4"	STL	PTD	Y	1	STL	AL	-	-	Y	60	FULL GLASS PAIR OF DOORS WITH THIRD SINGLE DOOR WITH 60 MINUTE FIRE RATED GLASS WITH PANIC HARDWARE
102.1	D	3'-0"	7'-0"	1-3/4"	STL	PTD	Y	2	STL	AL	-	-	Y	60	PANIC HARDWARE
102.2	L	3'-0"	3'-2"	1-1/2"	STL	PTD	-	-	STL	-	-	-	-	-	GATE WITH LATCH HARDWARE
103.1	M	6'-0"	7'-0"	1-3/4"	STL	PTD	-	1	STL	AL	-	-	Y	-	PAIR OF DOORS
103.2	H	3'-0"	7'-0"	1-3/4"	STL	PTD	-	1	STL	-	-	-	Y	-	-
104.1	F	3'-0"	7'-0"	1-3/4"	AL	PTD	-	-	AL	-	-	-	Y	-	STOREFRONT DOOR WITH SIDELIGHTS
104.2	M	6'-0"	7'-0"	1-3/4"	STL	PTD	Y	1	STL	AL	-	-	Y	90	PAIR OF DOORS
107.1	B	6'-0"	7'-0"	1-3/4"	STL	PTD	Y	2	STL	AL	-	-	Y	90	PAIR OF DOORS, MAGNETIC HOLD OPENS TIED TO FIRE ALARM SYSTEM
107.2	G	14'-0"	7'-0"	-	STL	PTD	-	-	STL	-	-	-	Y	90	FIRE RATED OVERHEAD ROLLING DOOR WITH AUTOMATIC CLOSER TIED TO FIRE ALARM SYSTEM WITH LASER EYE SAFETY FEATURE, OVERHEAD DOOR MODEL 640 COUNTER DOOR, FUSEABLE LINK
109.1	C	3'-0"	7'-0"	1-3/4"	STL	PTD	Y	1	STL	-	-	-	Y	-	-
110.1	C	3'-0"	7'-0"	1-3/4"	STL	PTD	Y	1	STL	-	-	-	Y	-	-
111.1	D	3'-0"	7'-0"	1-3/4"	STL	PTD	Y	2	STL	AL	-	-	Y	90	-
111.2	H	3'-0"	7'-0"	1-3/4"	STL	PTD	-	1	STL	-	-	-	Y	-	FREE PUSH HARDWARE (SERVING DOOR) NIGHT LOCK FUNCTION
111.3	H	3'-0"	7'-0"	1-3/4"	STL	PTD	-	1	STL	-	-	-	Y	-	FREE PUSH HARDWARE (SERVING DOOR) NIGHT LOCK FUNCTION
112.1	I	6'-0"	7'-0"	1-3/4"	AL	PTD	Y	-	AL	AL	-	-	Y	-	THERMALLY BROKEN STOREFRONT DOUBLE DOORS
112.2	C	3'-0"	7'-0"	1-3/4"	STL	PTD	-	1	STL	-	-	-	Y	-	-
114.1	D	3'-0"	7'-0"	1-3/4"	STL	PTD	Y	2	STL	AL	-	-	Y	60	PANIC HARDWARE
114.2	J	3'-0"	7'-0"	1-3/4"	AL	PTD	Y	-	AL	AL	-	-	Y	-	THERMALLY BROKEN STOREFRONT DOOR WITH PANIC HARDWARE
114.3	L	3'-0"	3'-2"	1-1/2"	STL	PTD	-	-	STL	-	-	-	-	-	GATE WITH LATCH HARDWARE
115.1	J	3'-0"	7'-0"	1-3/4"	AL	PTD	Y	-	AL	AL	-	-	Y	-	THERMALLY BROKEN STOREFRONT DOOR WITH PANIC HARDWARE
115.2	H	3'-0"	7'-0"	1-3/4"	STL	PTD	-	1	STL	-	-	-	Y	-	-
115.3	K	10'-0"	8'-0"	1-3/4"	AL	PTD	-	-	AL	-	-	-	-	-	FULL GLASS OVERHEAD DOOR WITH CHAIN PULL LOCK
117.1	N	3'-0"	7'-0"	1-3/4"	STL	PTD	Y	1	STL	AL	-	-	Y	-	PANIC HARDWARE, THERMALLY BROKEN DOOR AND FRAME
201.1	C	3'-0"	7'-0"	1-3/4"	STL	PTD	Y	2	STL	AL	-	-	Y	60	PANIC HARDWARE
203.1	D	3'-0"	7'-0"	1-3/4"	STL	PTD	Y	2	STL	AL	-	-	Y	60	PANIC HARDWARE
217.1	D	3'-0"	7'-0"	1-3/4"	STL	PTD	Y	2	STL	AL	-	-	Y	60	PANIC HARDWARE
300.1	J	3'-0"	7'-0"	1-3/4"	AL	PTD	Y	-	AL	AL	-	-	Y	-	THERMALLY BROKEN STOREFRONT DOOR WITH PANIC HARDWARE
301.1	D	3'-0"	7'-0"	1-3/4"	STL	PTD	Y	2	STL	AL	-	-	Y	60	PANIC HARDWARE
303.1	D	3'-0"	7'-0"	1-3/4"	STL	PTD	Y	2	STL	AL	-	-	Y	60	PANIC HARDWARE
304.1	D	3'-0"	7'-0"	1-3/4"	STL	PTD	Y	2	STL	AL	-	-	Y	60	PANIC HARDWARE

Per Section 706.8 Openings, clarify if the two sets of double doors at the fire wall meet the requirements referenced in Section 715.4. Under remarks the two sets of double doors are not consistently noted. Clarify and revise.

ADDITION TO BAYSIDE BOWL
ALDER STREET
PORTLAND, MAINE



RYAN SENATORE ARCHITECTURE
565 CONGRESS STREET
PORTLAND, MAINE 04101
207-650-6414
senatorearchitecture.com

CONSULTANTS:
STRUCTURAL: Structural Integrity
77 Oak Street
Portland, ME 04101
207-774-4614

REVISIONS:

DATE: JANUARY 29, 2016

PROJECT No. 1452

DRAWN BY: JPF / RRT / RJS

CHECKED BY: RJS

SCALE: AS NOTED

SHEET TITLE:
DOOR SCHEDULE