


NOTE:
1. SEE SHEET E-001 FOR LEGEND AND GENERAL NOTES.


KEYED NOTE:
① •

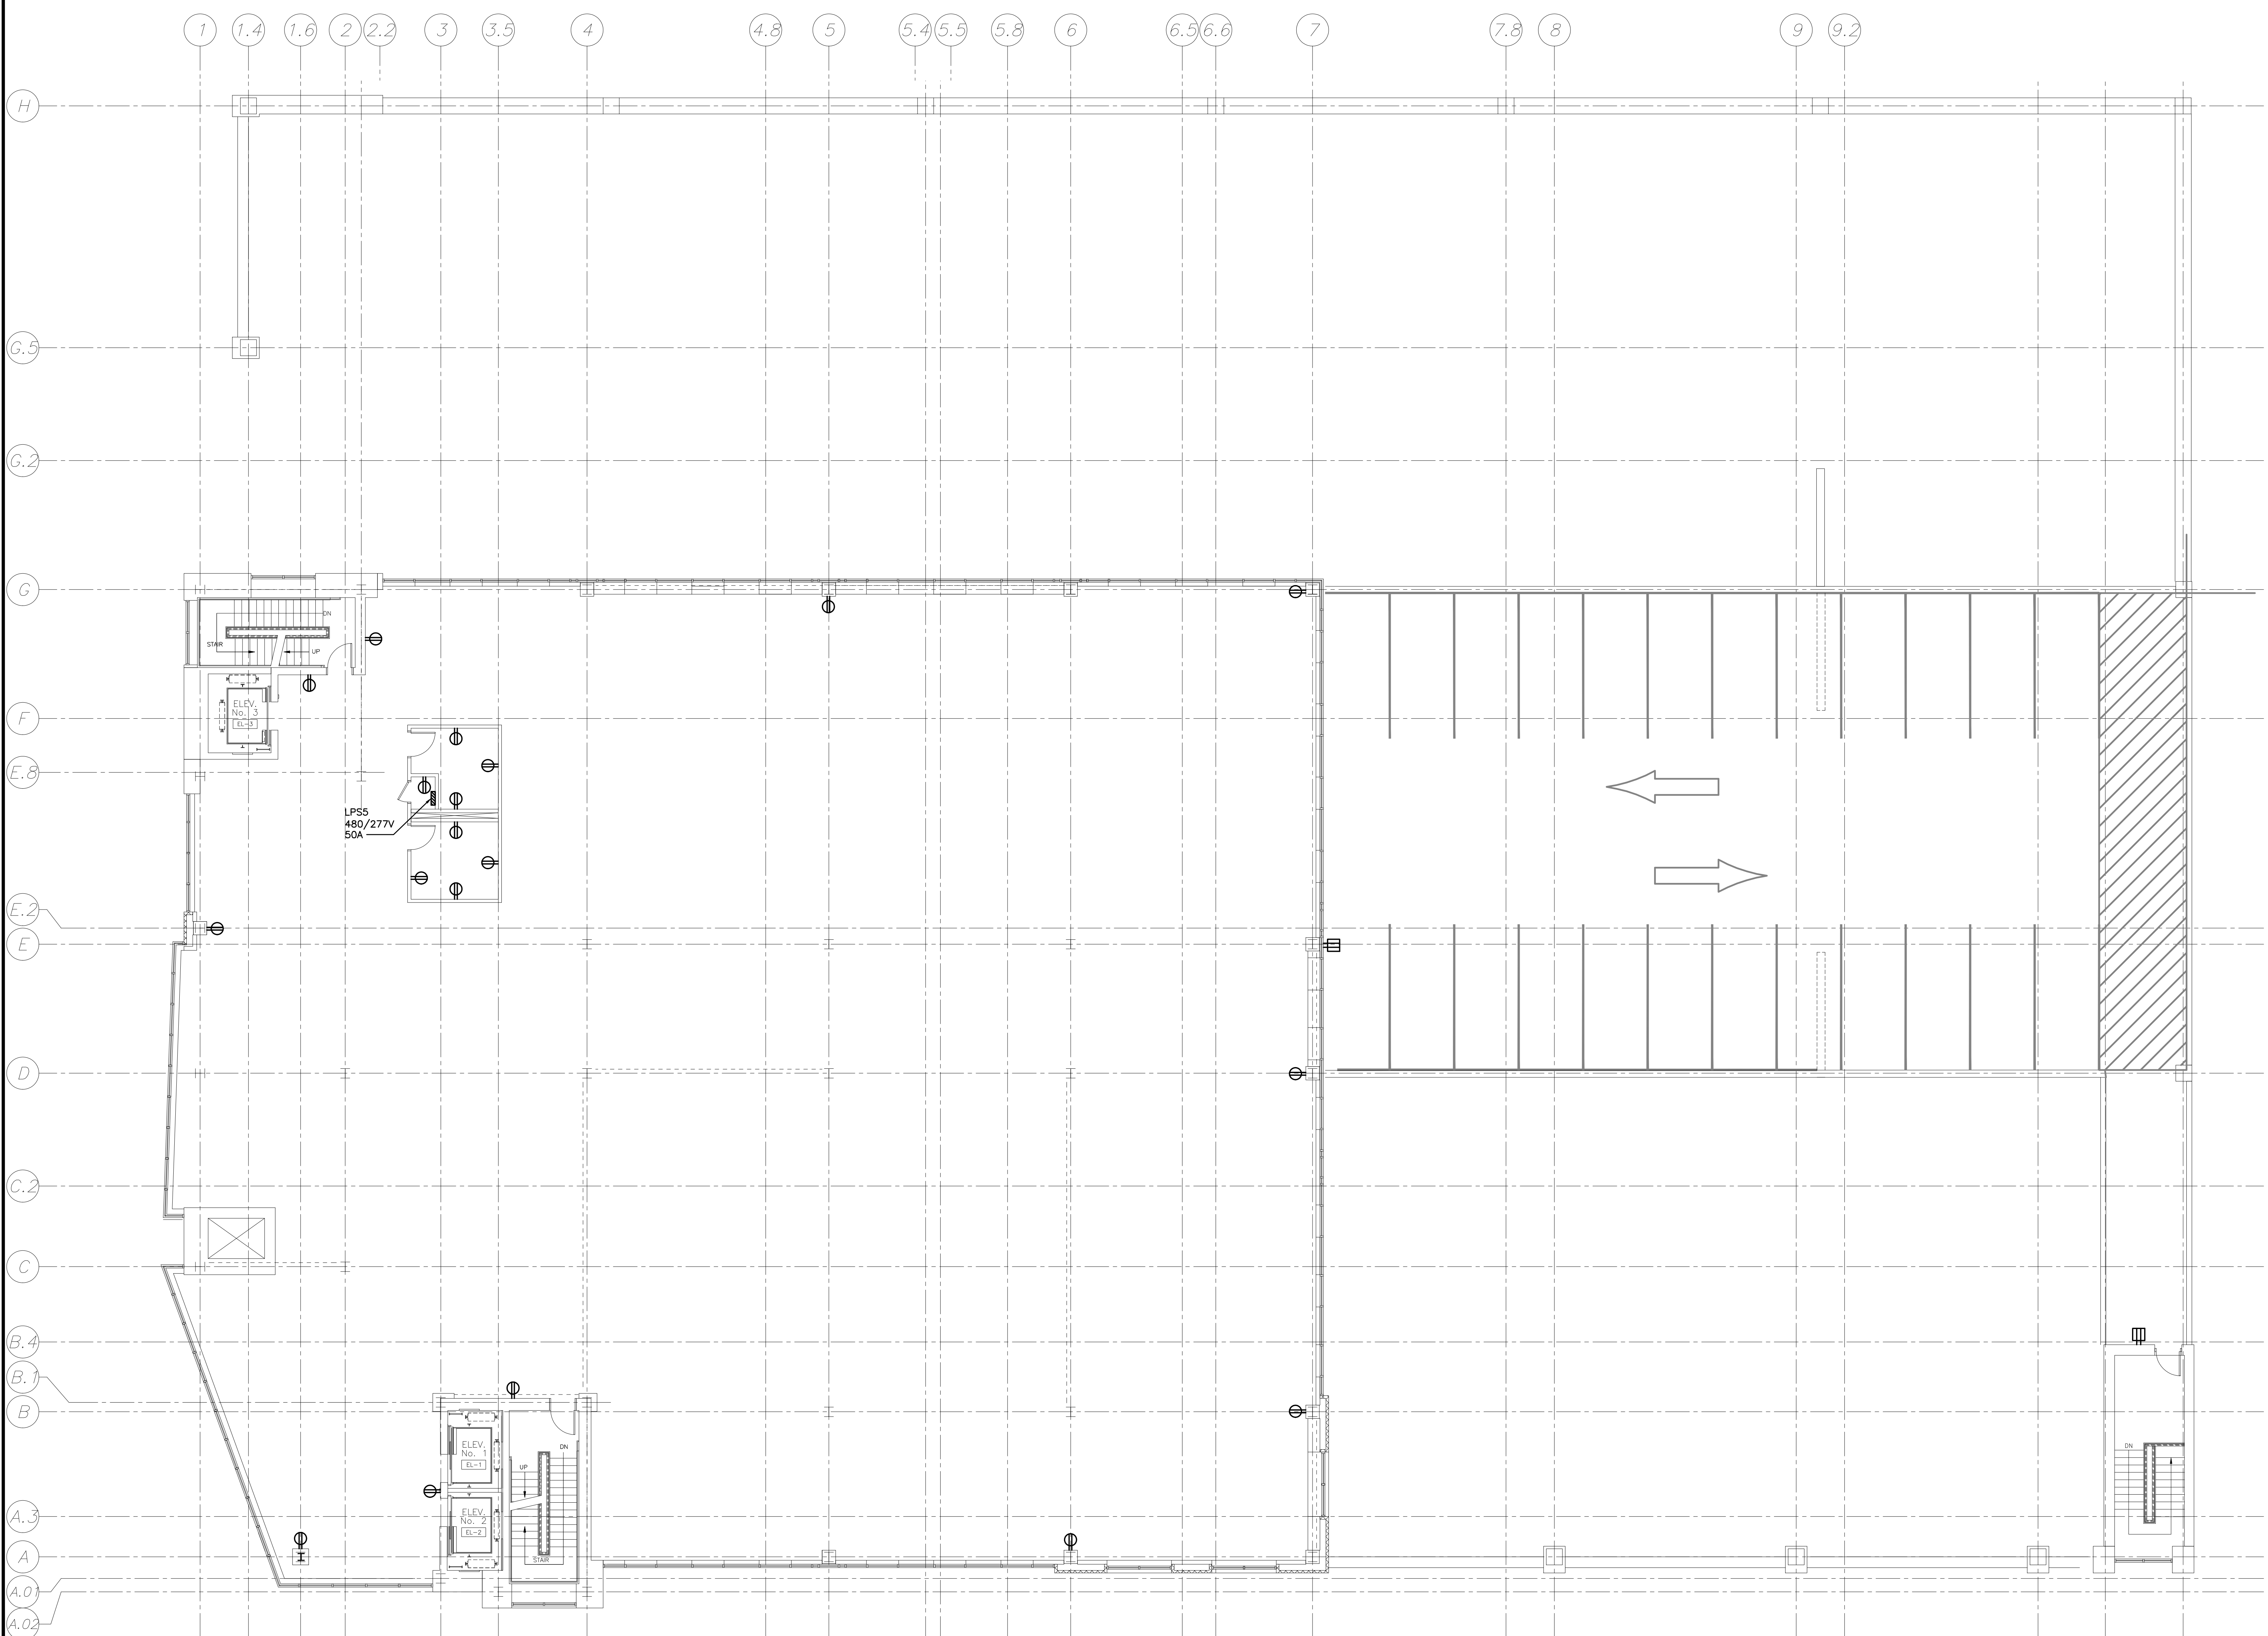

ESB
E.S. BOULOS CO
ELECTRICAL CONTRACTORS
45 BRADLEY DRIVE
WESTBROOK, ME 04092
TEL: (207) 464-3706
FAX: (207) 464-1833

Project Title
84 MARGINAL WAY
Portland, Maine

HA Project No. 06196

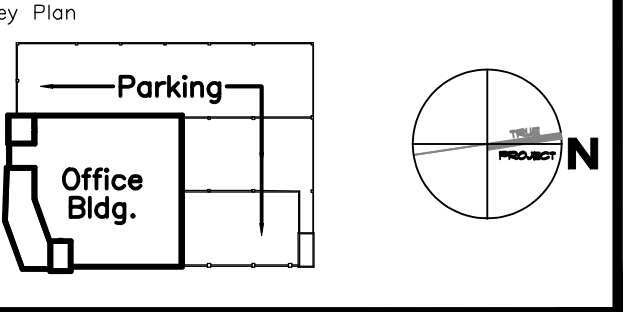

Mark	Date	Description
-	5-18-07	50% CONSTRUCTION DOCUMENTS
-	3-23-07	25% CONSTRUCTION DOCUMENTS

Mark	Date	Description
-	5-18-07	50% CONSTRUCTION DOCUMENTS
-	3-23-07	25% CONSTRUCTION DOCUMENTS

Drawing Status
50% CONSTRUCTION DOCUMENTS
(NOT FOR CONSTRUCTION)

Drawing Title
FIFTH FLOOR POWER PLAN

PA / PE: DJT Drawn By: CDS

Drawing Number
EP105

A1 FLOOR PLAN
1/8"=1'-0"