


NOTE:
1. SEE SHEET E-001 FOR LEGEND AND GENERAL NOTES.

KEYED NOTE:
① •

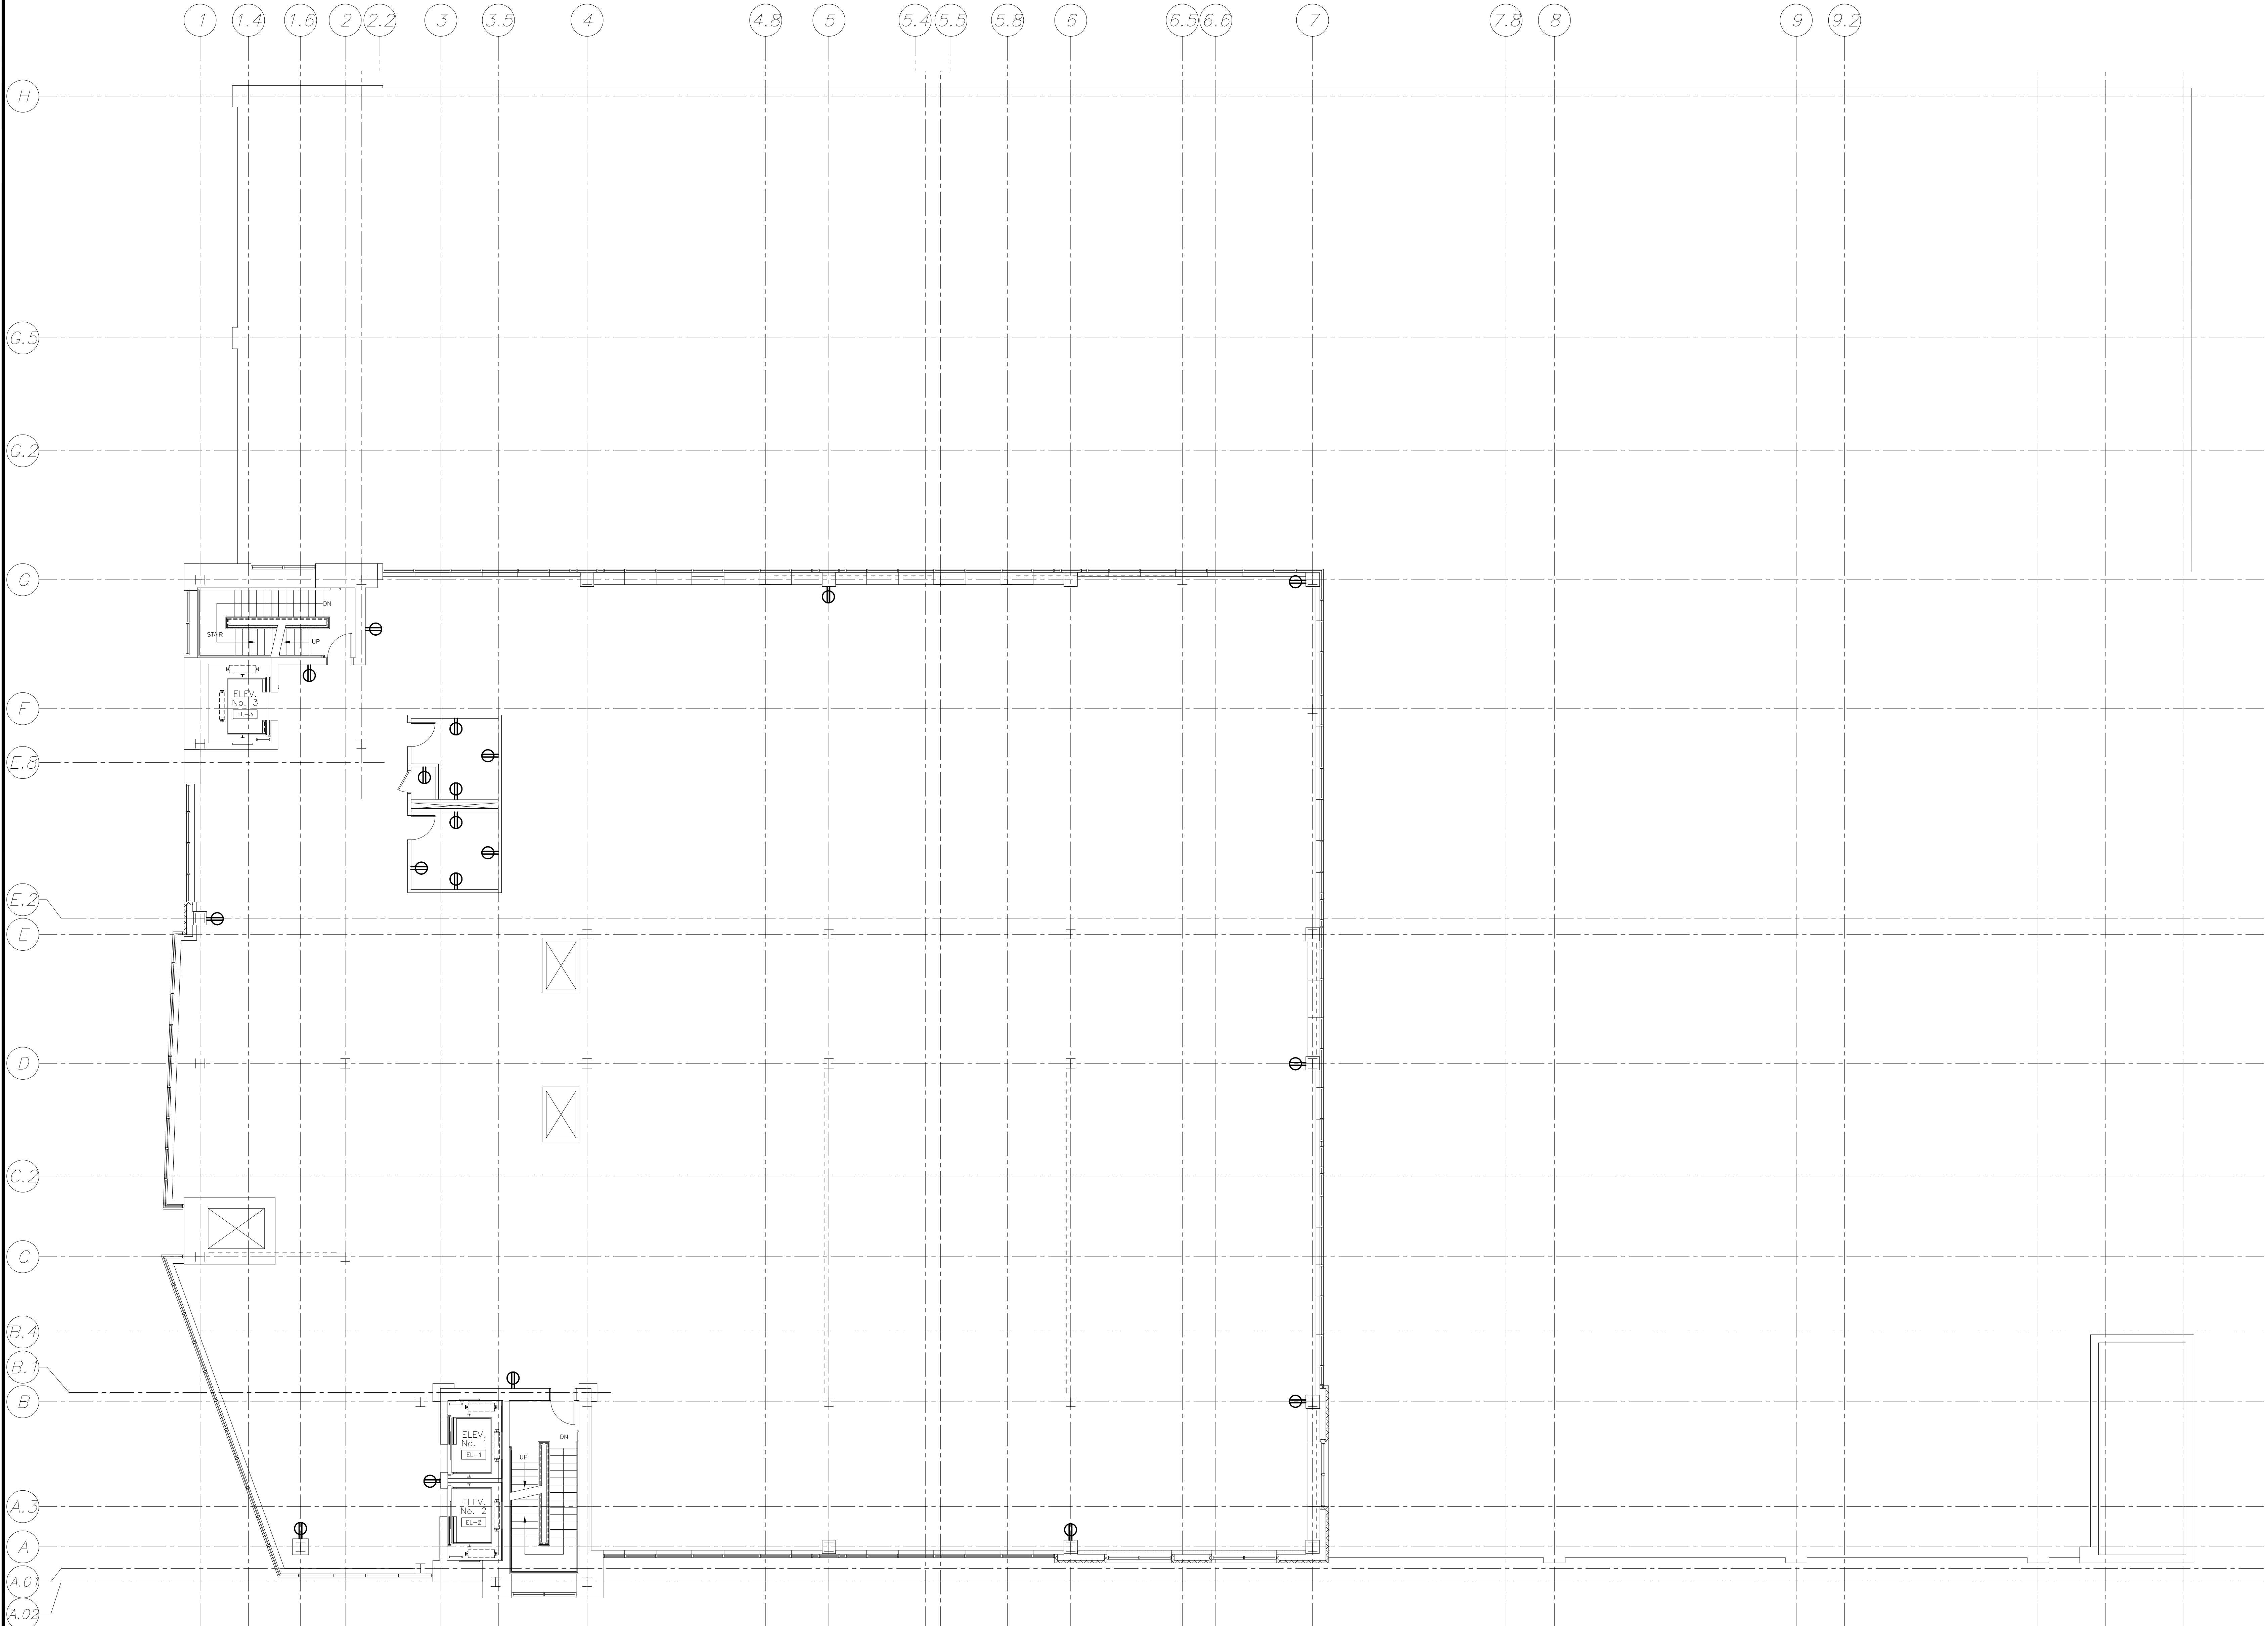

A1 FLOOR PLAN
1/8"=1'-0"

Mark	Date	Description
-	5-18-07	50% CONSTRUCTION DOCUMENTS
-	3-23-07	25% CONSTRUCTION DOCUMENTS

Drawing Status
50% CONSTRUCTION DOCUMENTS
(NOT FOR CONSTRUCTION)

Drawing Title
SIXTH FLOOR POWER PLAN

PA / PE: DJT Drawn By: CDS
Drawing Number

EP106