




NOTE:
1. SEE SHEET E-001 FOR LEGEND AND GENERAL NOTES.

KEYED NOTE:
① •

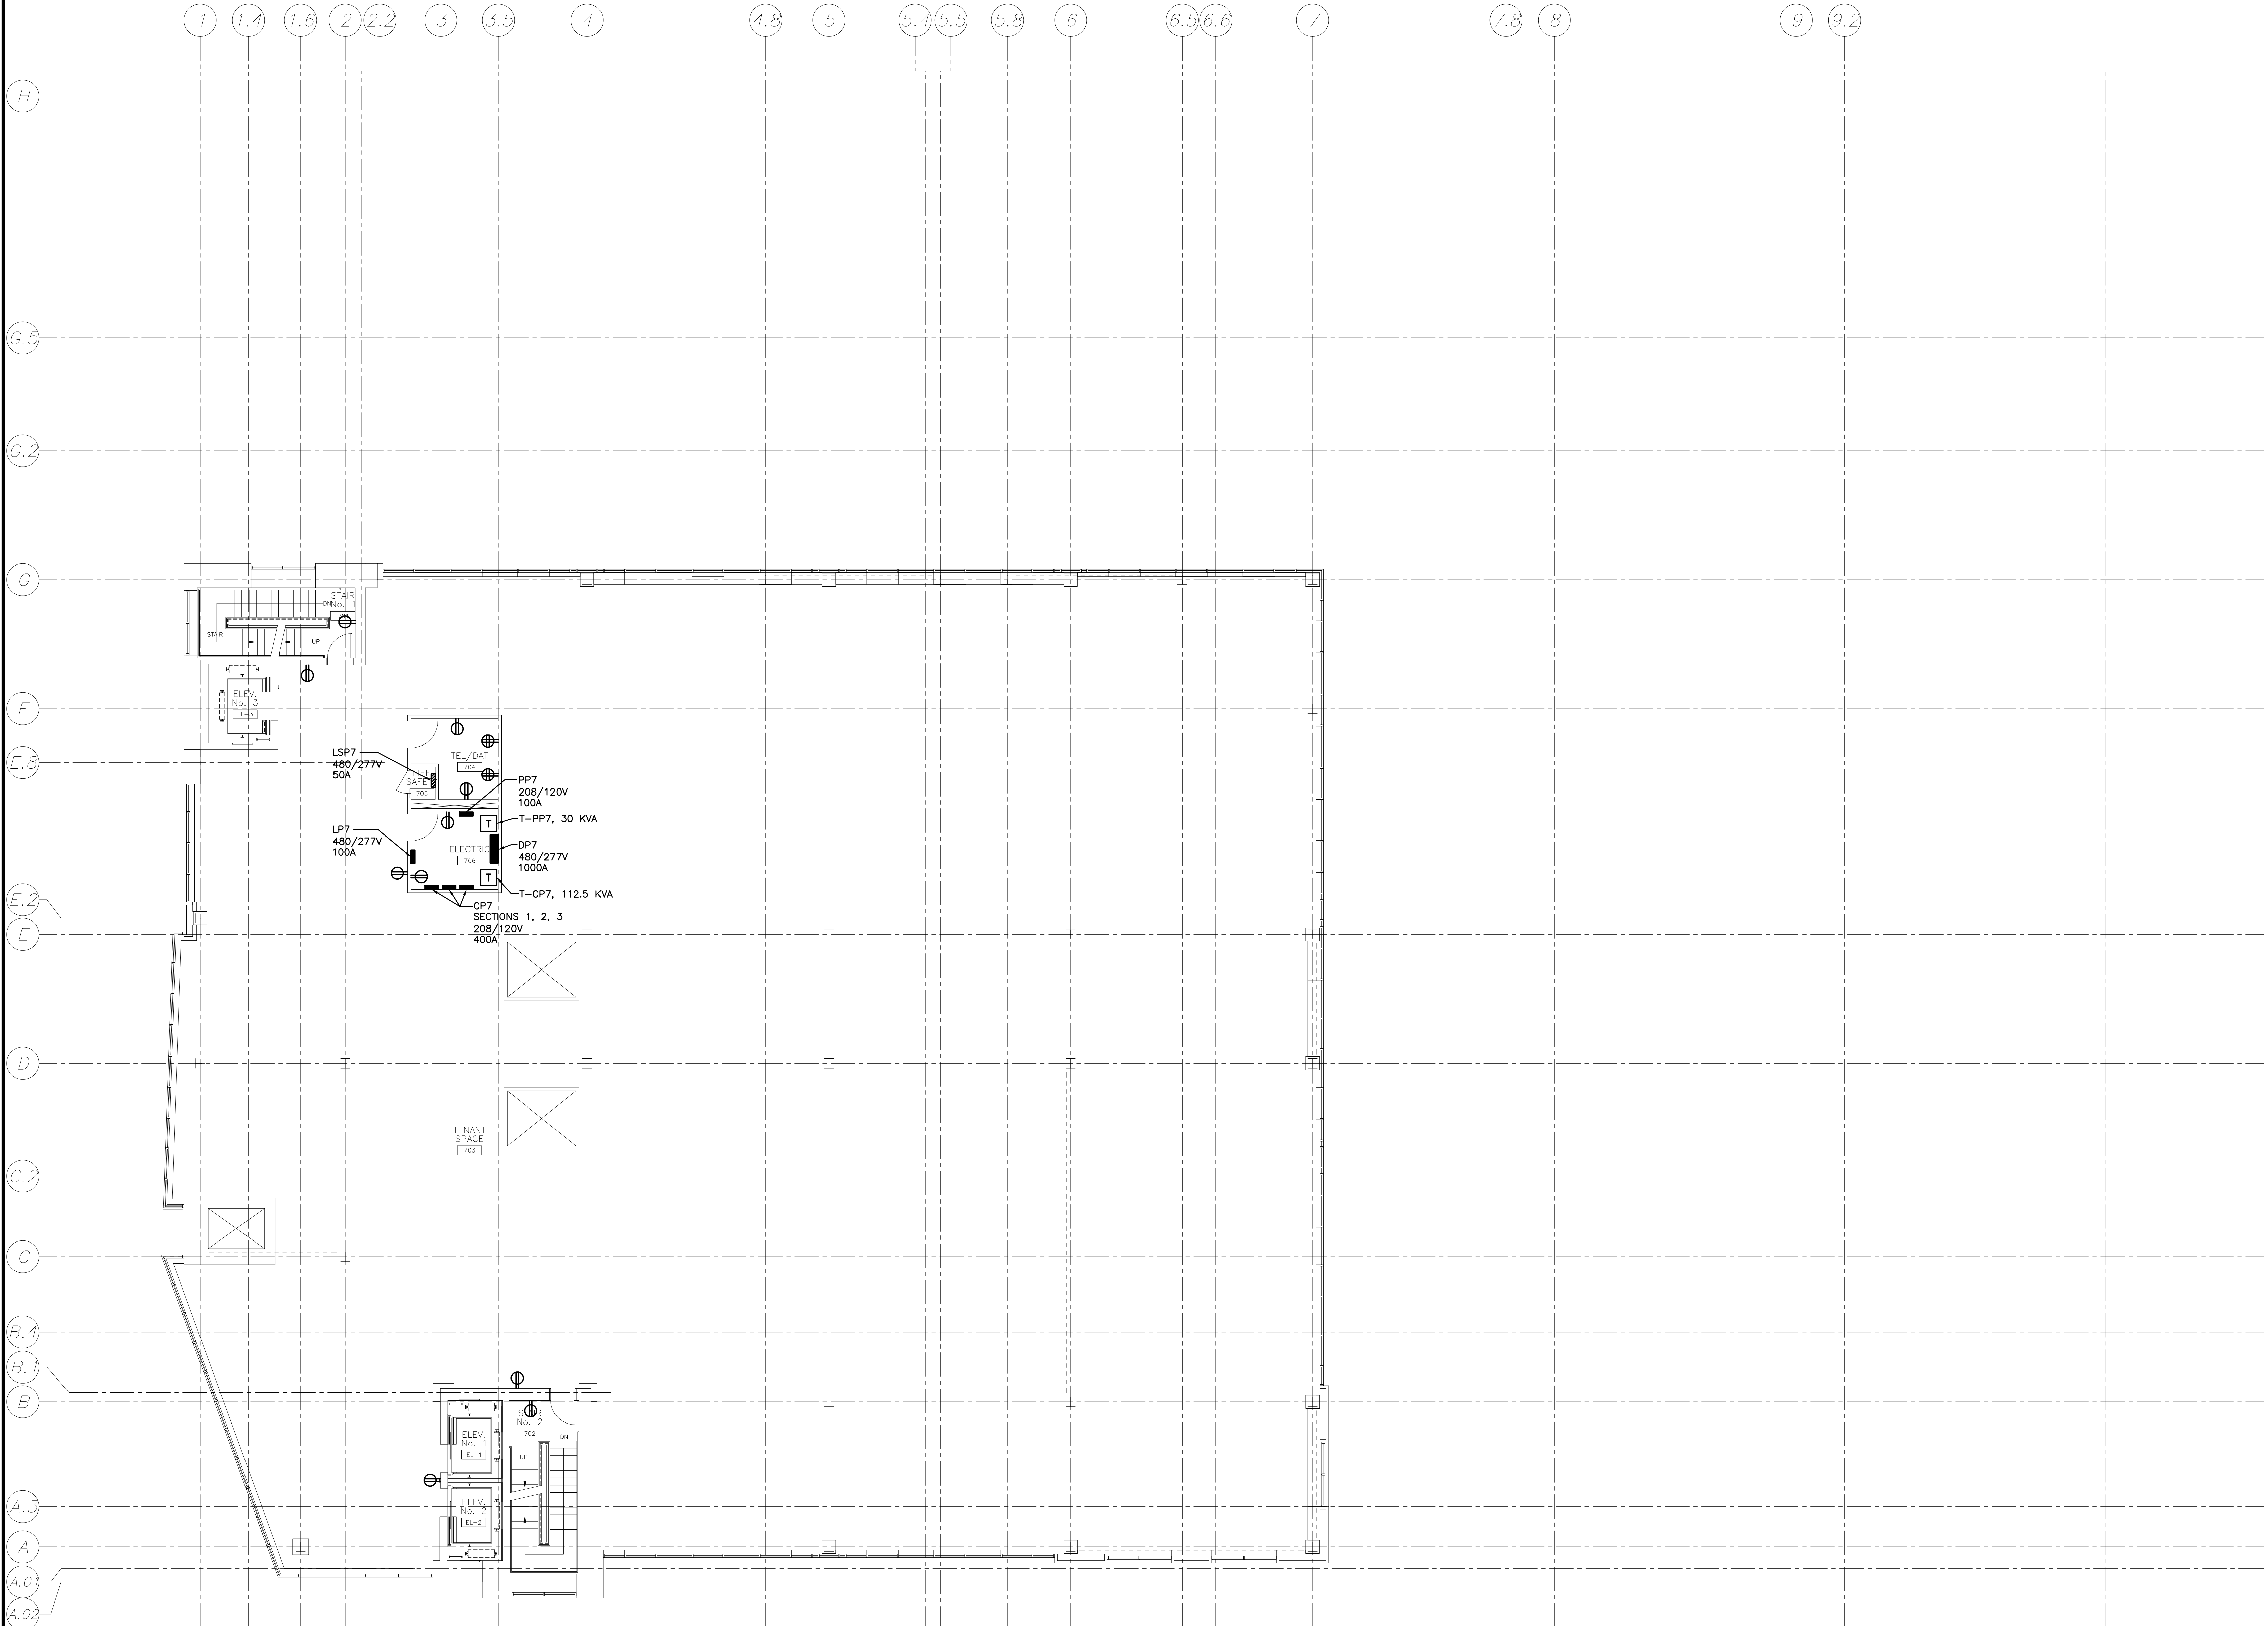

A1 FLOOR PLAN
1/8"=1'-0"

| Mark | Date | Description |
|------|---------|----------------------------|
| - | 5-18-07 | 50% CONSTRUCTION DOCUMENTS |
| - | 3-23-07 | 25% CONSTRUCTION DOCUMENTS |

Drawing Status
50% CONSTRUCTION DOCUMENTS
(NOT FOR CONSTRUCTION)

Drawing Title
SEVENTH FLOOR POWER PLAN

PA / PE: DJT Drawn By: CDS

Drawing Number

EP107