


NOTE:
 1. SEE SHEET E-001 FOR LEGEND AND GENERAL NOTES.


KEYED NOTE:
 ① •

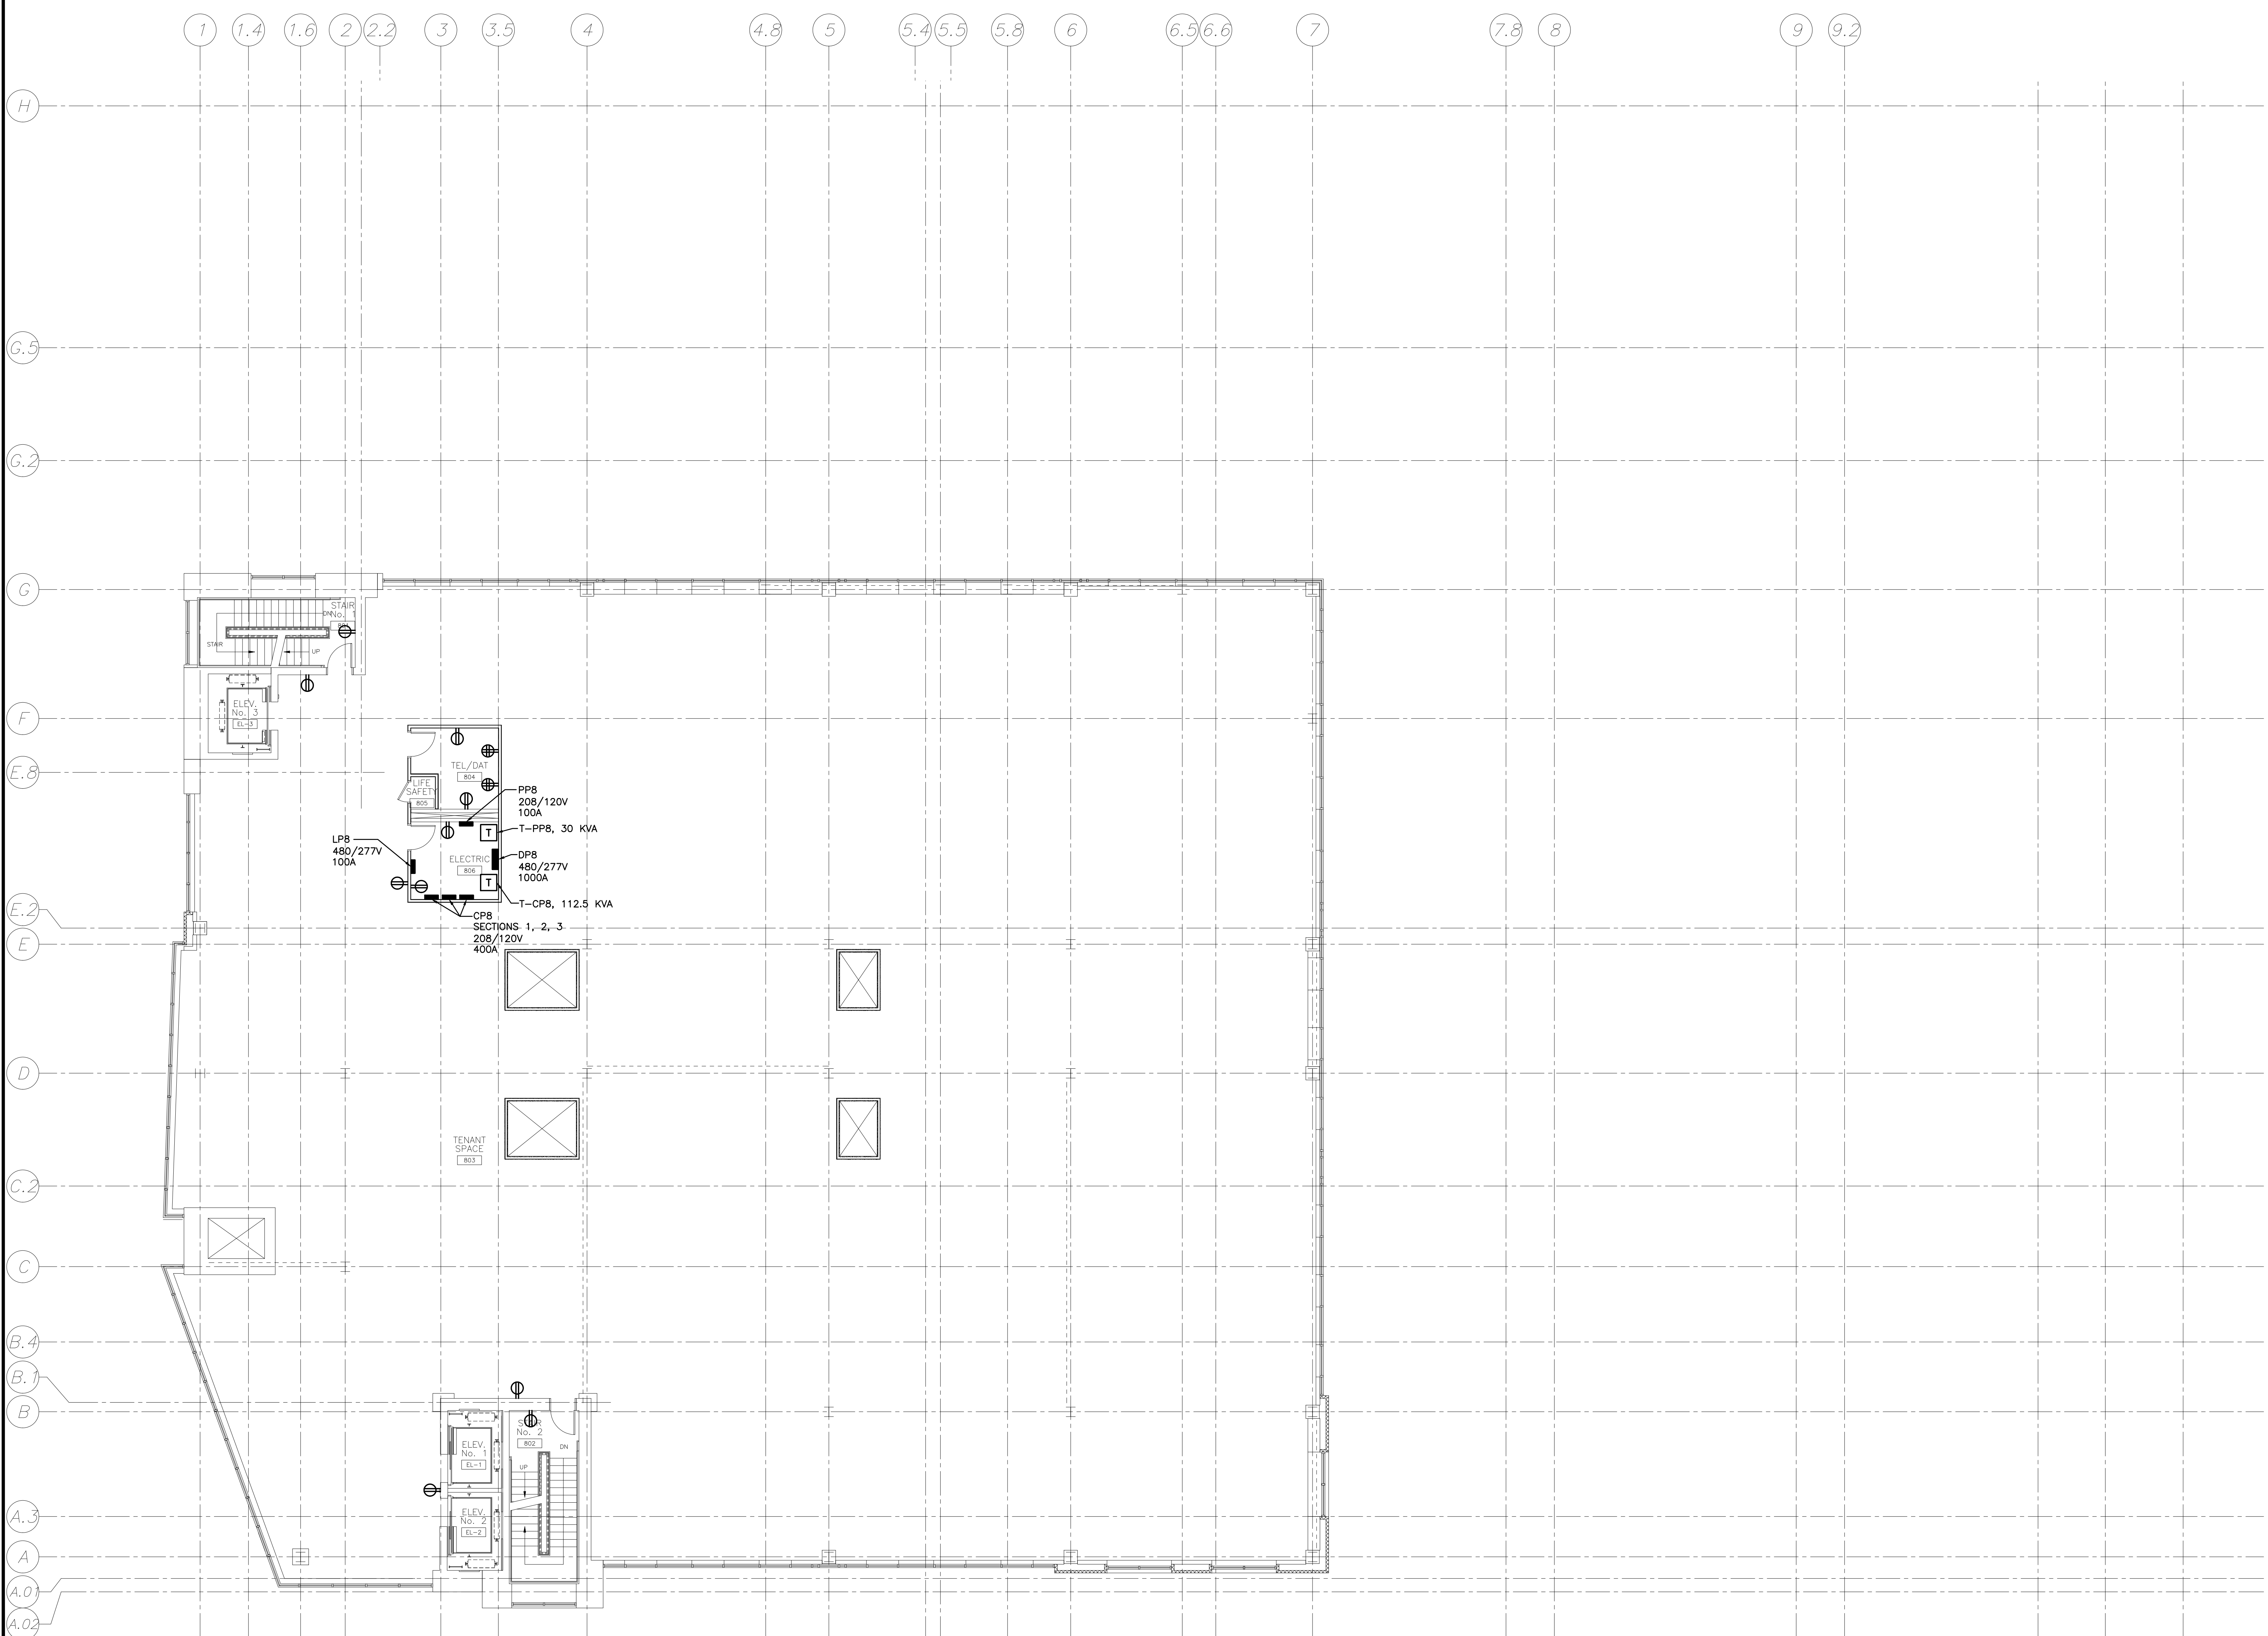

ESB
 E.S. BOULOS CO
 ELECTRICAL CONTRACTORS
 45 BRADLEY DRIVE
 WESTBROOK, ME 04092
 TEL: (207) 464-3706
 FAX: (207) 464-1833

Project Title
 84 MARGINAL WAY
 Portland, Maine

HA Project No. 06196

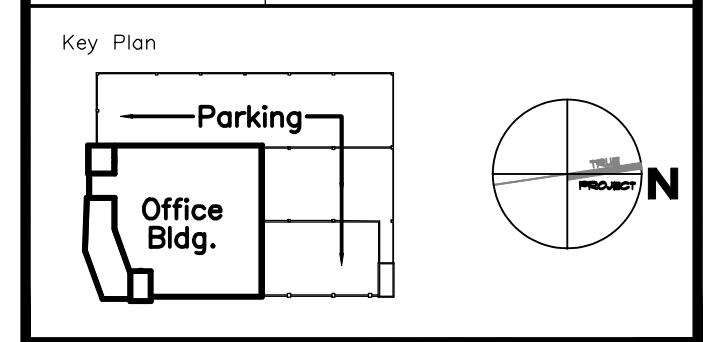

Mark	Date	Description
-	5-18-07	50% CONSTRUCTION DOCUMENTS
-	3-23-07	25% CONSTRUCTION DOCUMENTS

Mark	Date	Description
-	5-18-07	50% CONSTRUCTION DOCUMENTS
-	3-23-07	25% CONSTRUCTION DOCUMENTS

Drawing Status
50% CONSTRUCTION DOCUMENTS
 (NOT FOR CONSTRUCTION)

Drawing Title
EIGHTH FLOOR POWER PLAN

PA / PE: DJT Drawn By: CDS

Drawing Number

EP108

A1 FLOOR PLAN
 1/8"=1'-0"