



NOTE:
1. SEE SHEET E-001 FOR LEGEND AND GENERAL NOTES.

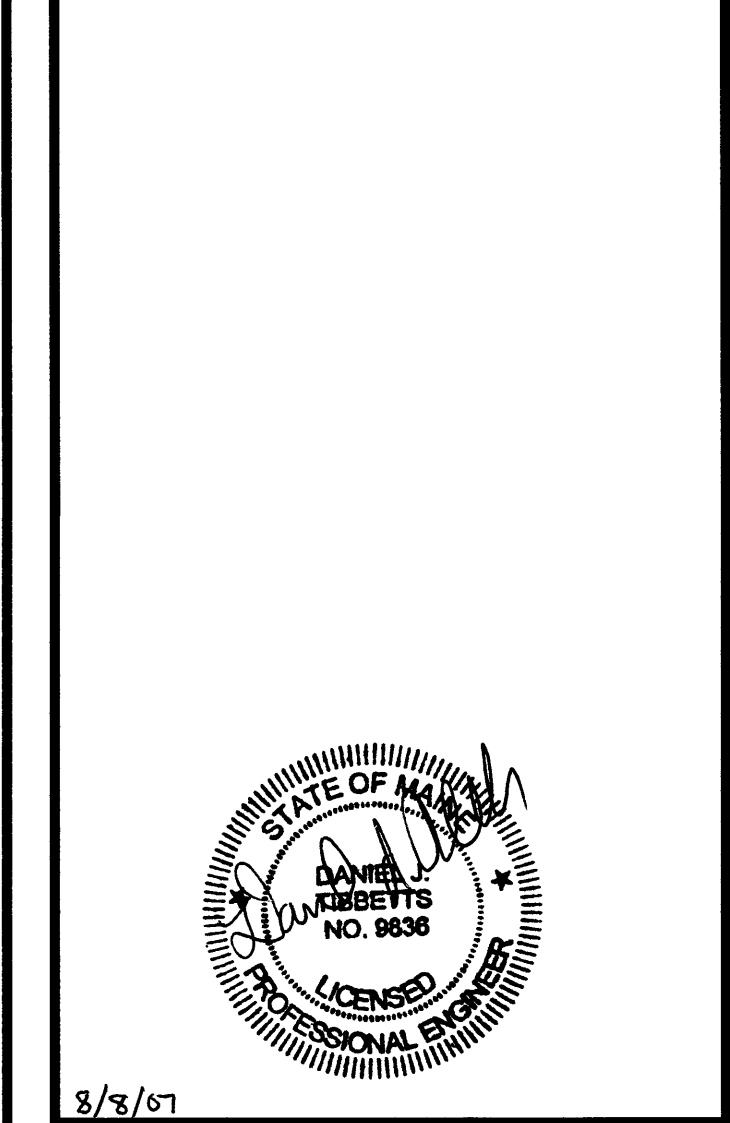

ESB
E.S. BOULOS CO
ELECTRICAL CONTRACTORS
45 BRADLEY DRIVE
WESTBROOK, ME 04092
TEL: (207) 464-3706
FAX: (207) 464-1833

Project Title
84 MARGINAL WAY
Portland, Maine
HA Project No. **06196**
Key Plan
Office Bldg. Parking
N

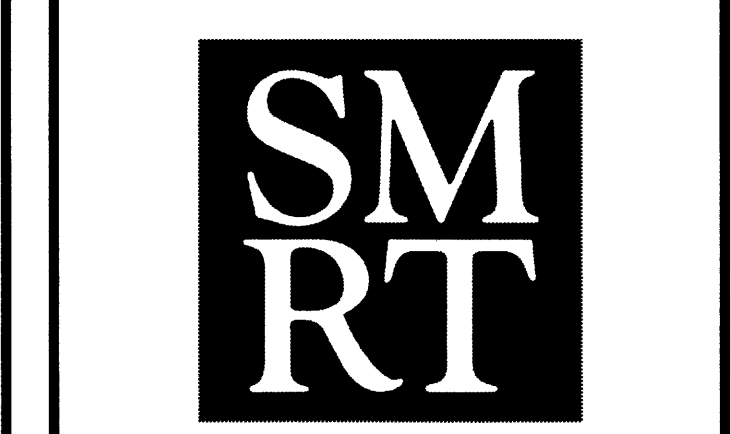


| Mark | Date | Description |
|------|---------|----------------------------|
| 0 | 8-8-07 | ISSUED FOR CONSTRUCTION |
| - | 8-2-07 | ISSUED FOR PERMIT |
| - | 5-18-07 | 50% CONSTRUCTION DOCUMENTS |
| - | 3-23-07 | 25% CONSTRUCTION DOCUMENTS |

Drawing Status
ISSUED FOR CONSTRUCTION

Drawing Title
FIRST FLOOR LIGHTING PLAN
PA / PE: DJT Drawn By: CDS
Drawing Number

EL101
SMRT CAD FILE: EL101-07053

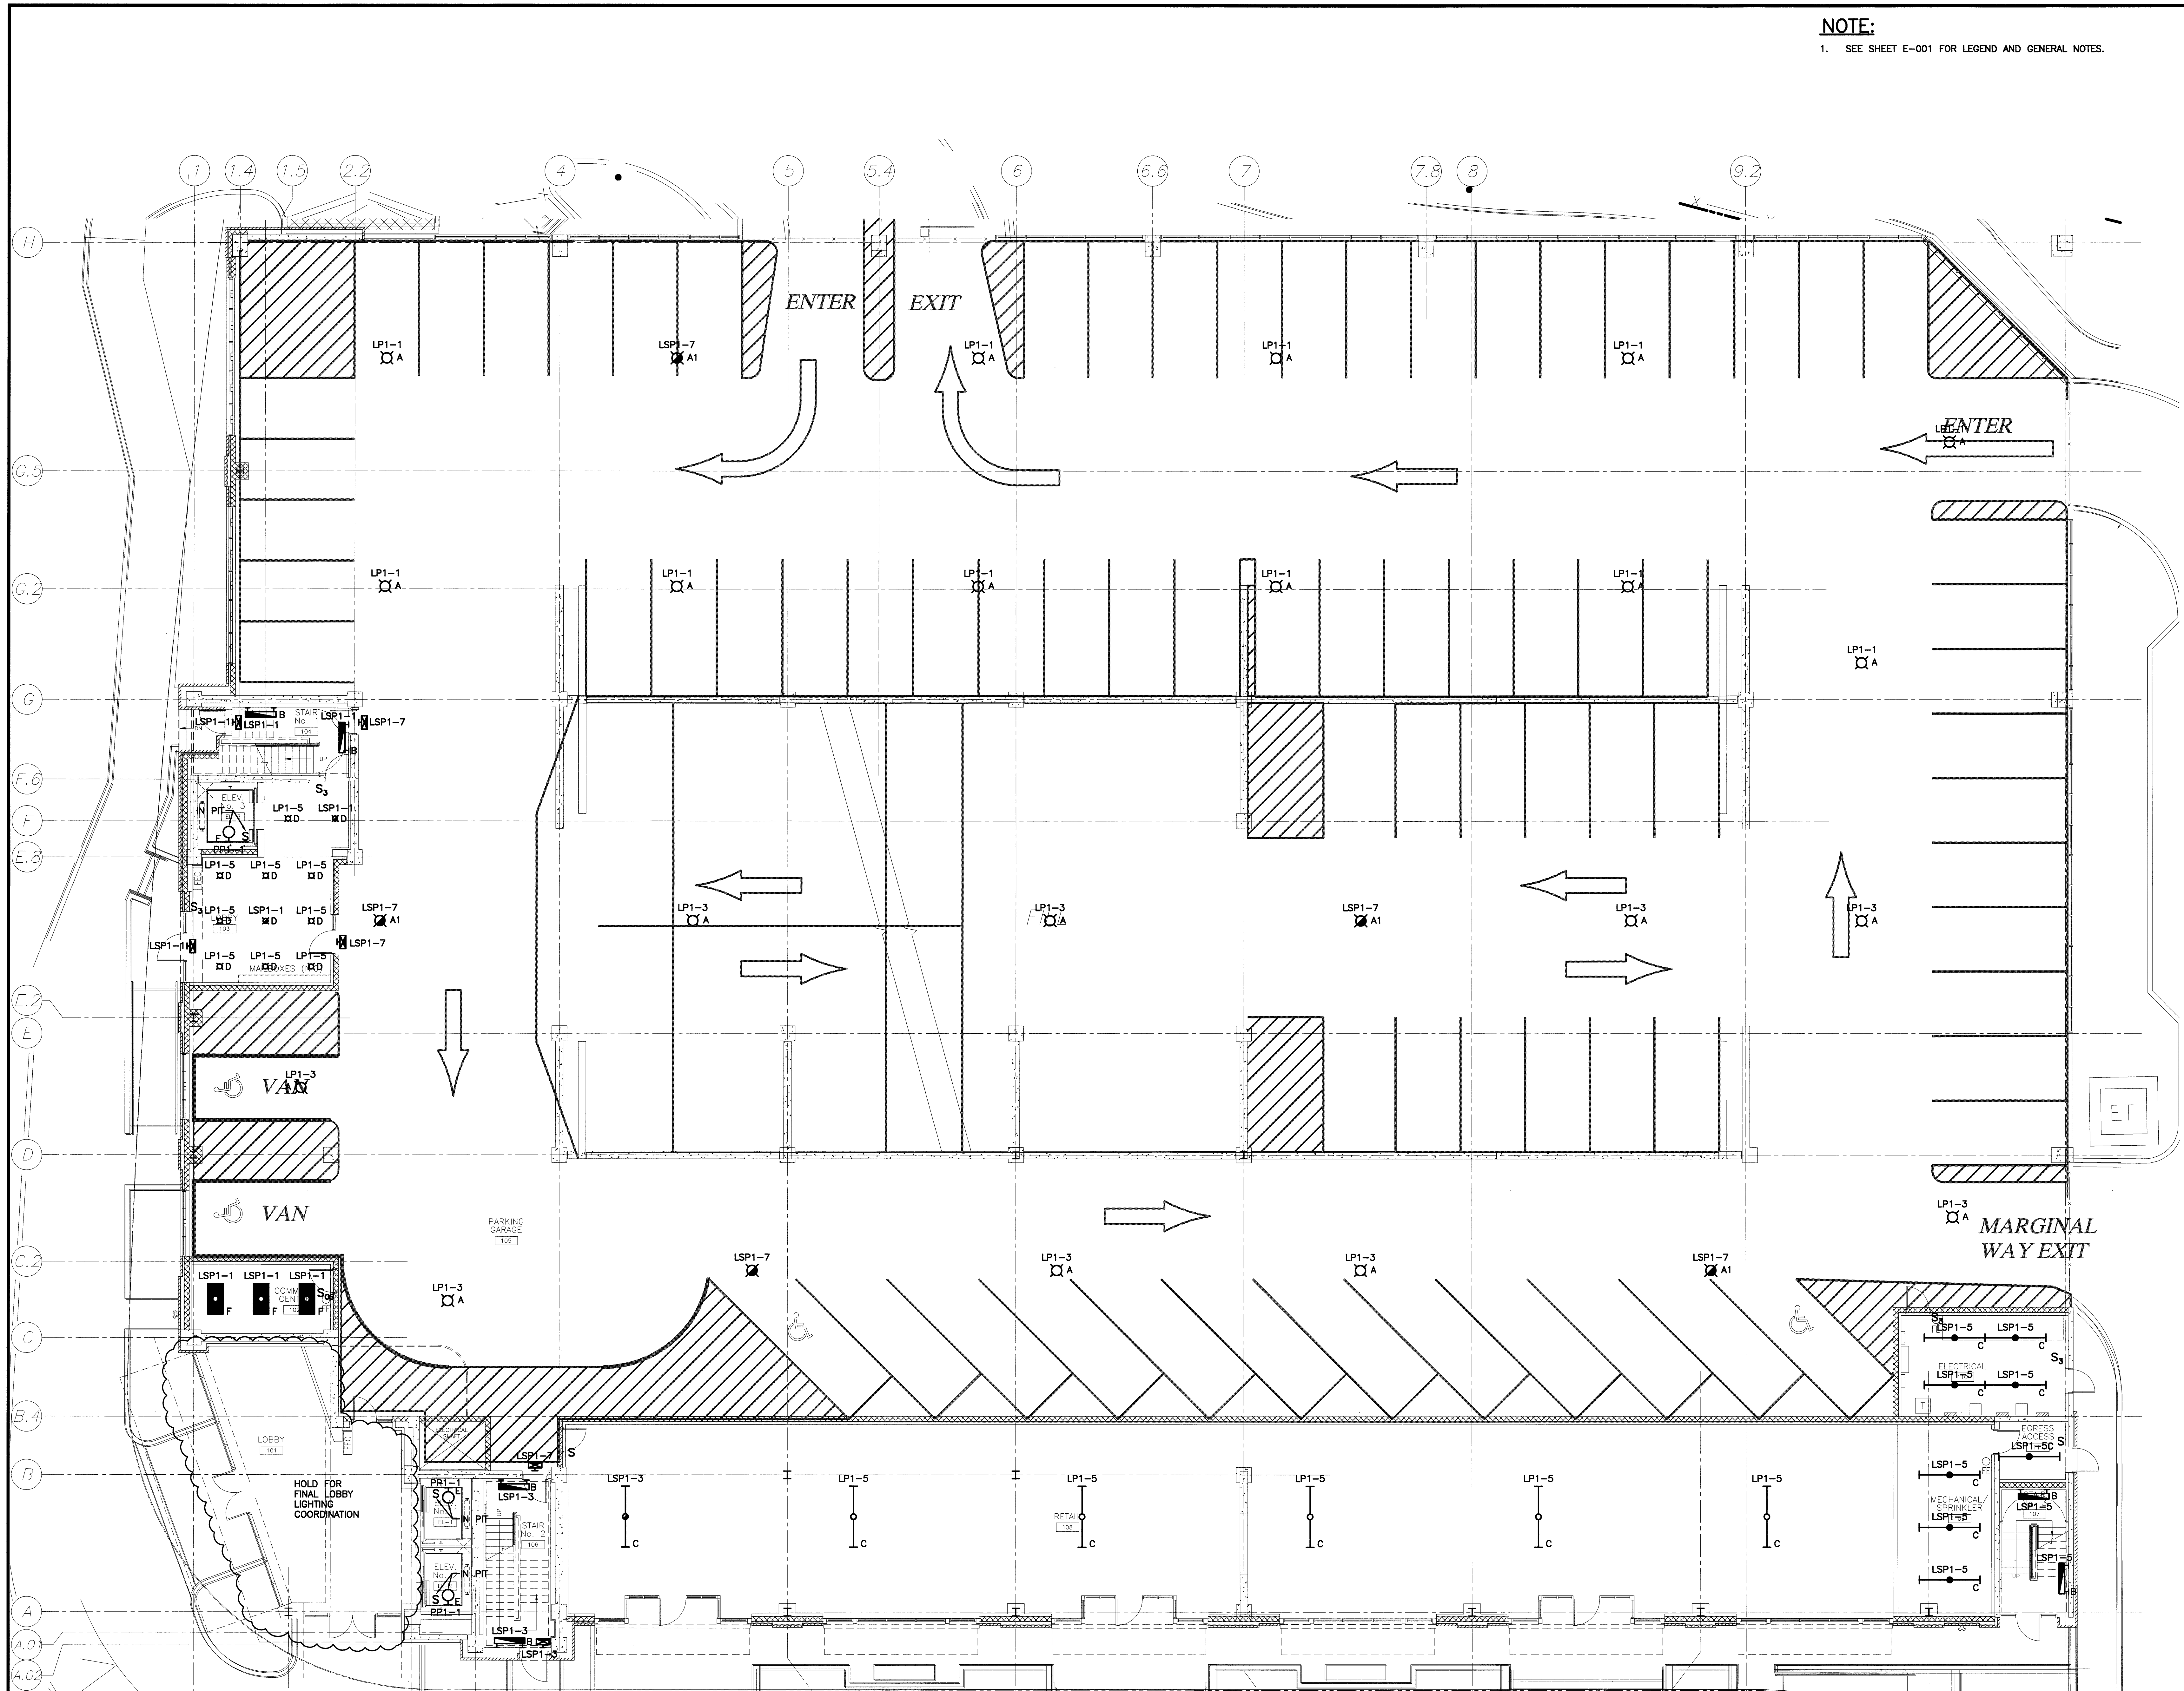

A1 FLOOR PLAN
1/8" = 1'-0"