

NOTE:

1. SEE SHEET E-001 FOR LEGEND AND GENERAL NOTES.





45 BRADLEY DRIVE
WESTBROOK, ME 04092
TEL: (207) 464-3706
FAX: (207) 464-1833

Project Title

84 MARGINAL WAY
Portland, Maine

HA Project No. 06196

Key Plan

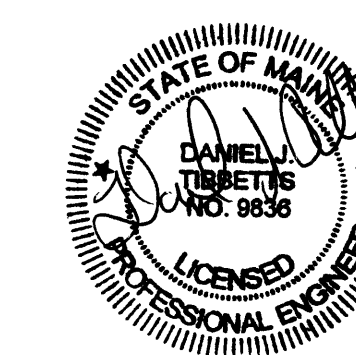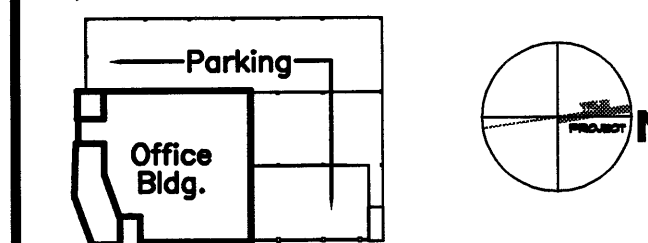

8/8/07

Mark	Date	Description
0	8-8-07	ISSUED FOR CONSTRUCTION
-	8-2-07	ISSUED FOR PERMIT
-	5-18-07	50% CONSTRUCTION DOCUMENTS
-	3-23-07	25% CONSTRUCTION DOCUMENTS

Drawing Status
ISSUED FOR CONSTRUCTION


Drawing Title
NINTH FLOOR LIGHTING PLAN

PA / PE: DJT Drawn By: CDS

Drawing Number

EL109

SMRT CAD FILE: EL109-07053

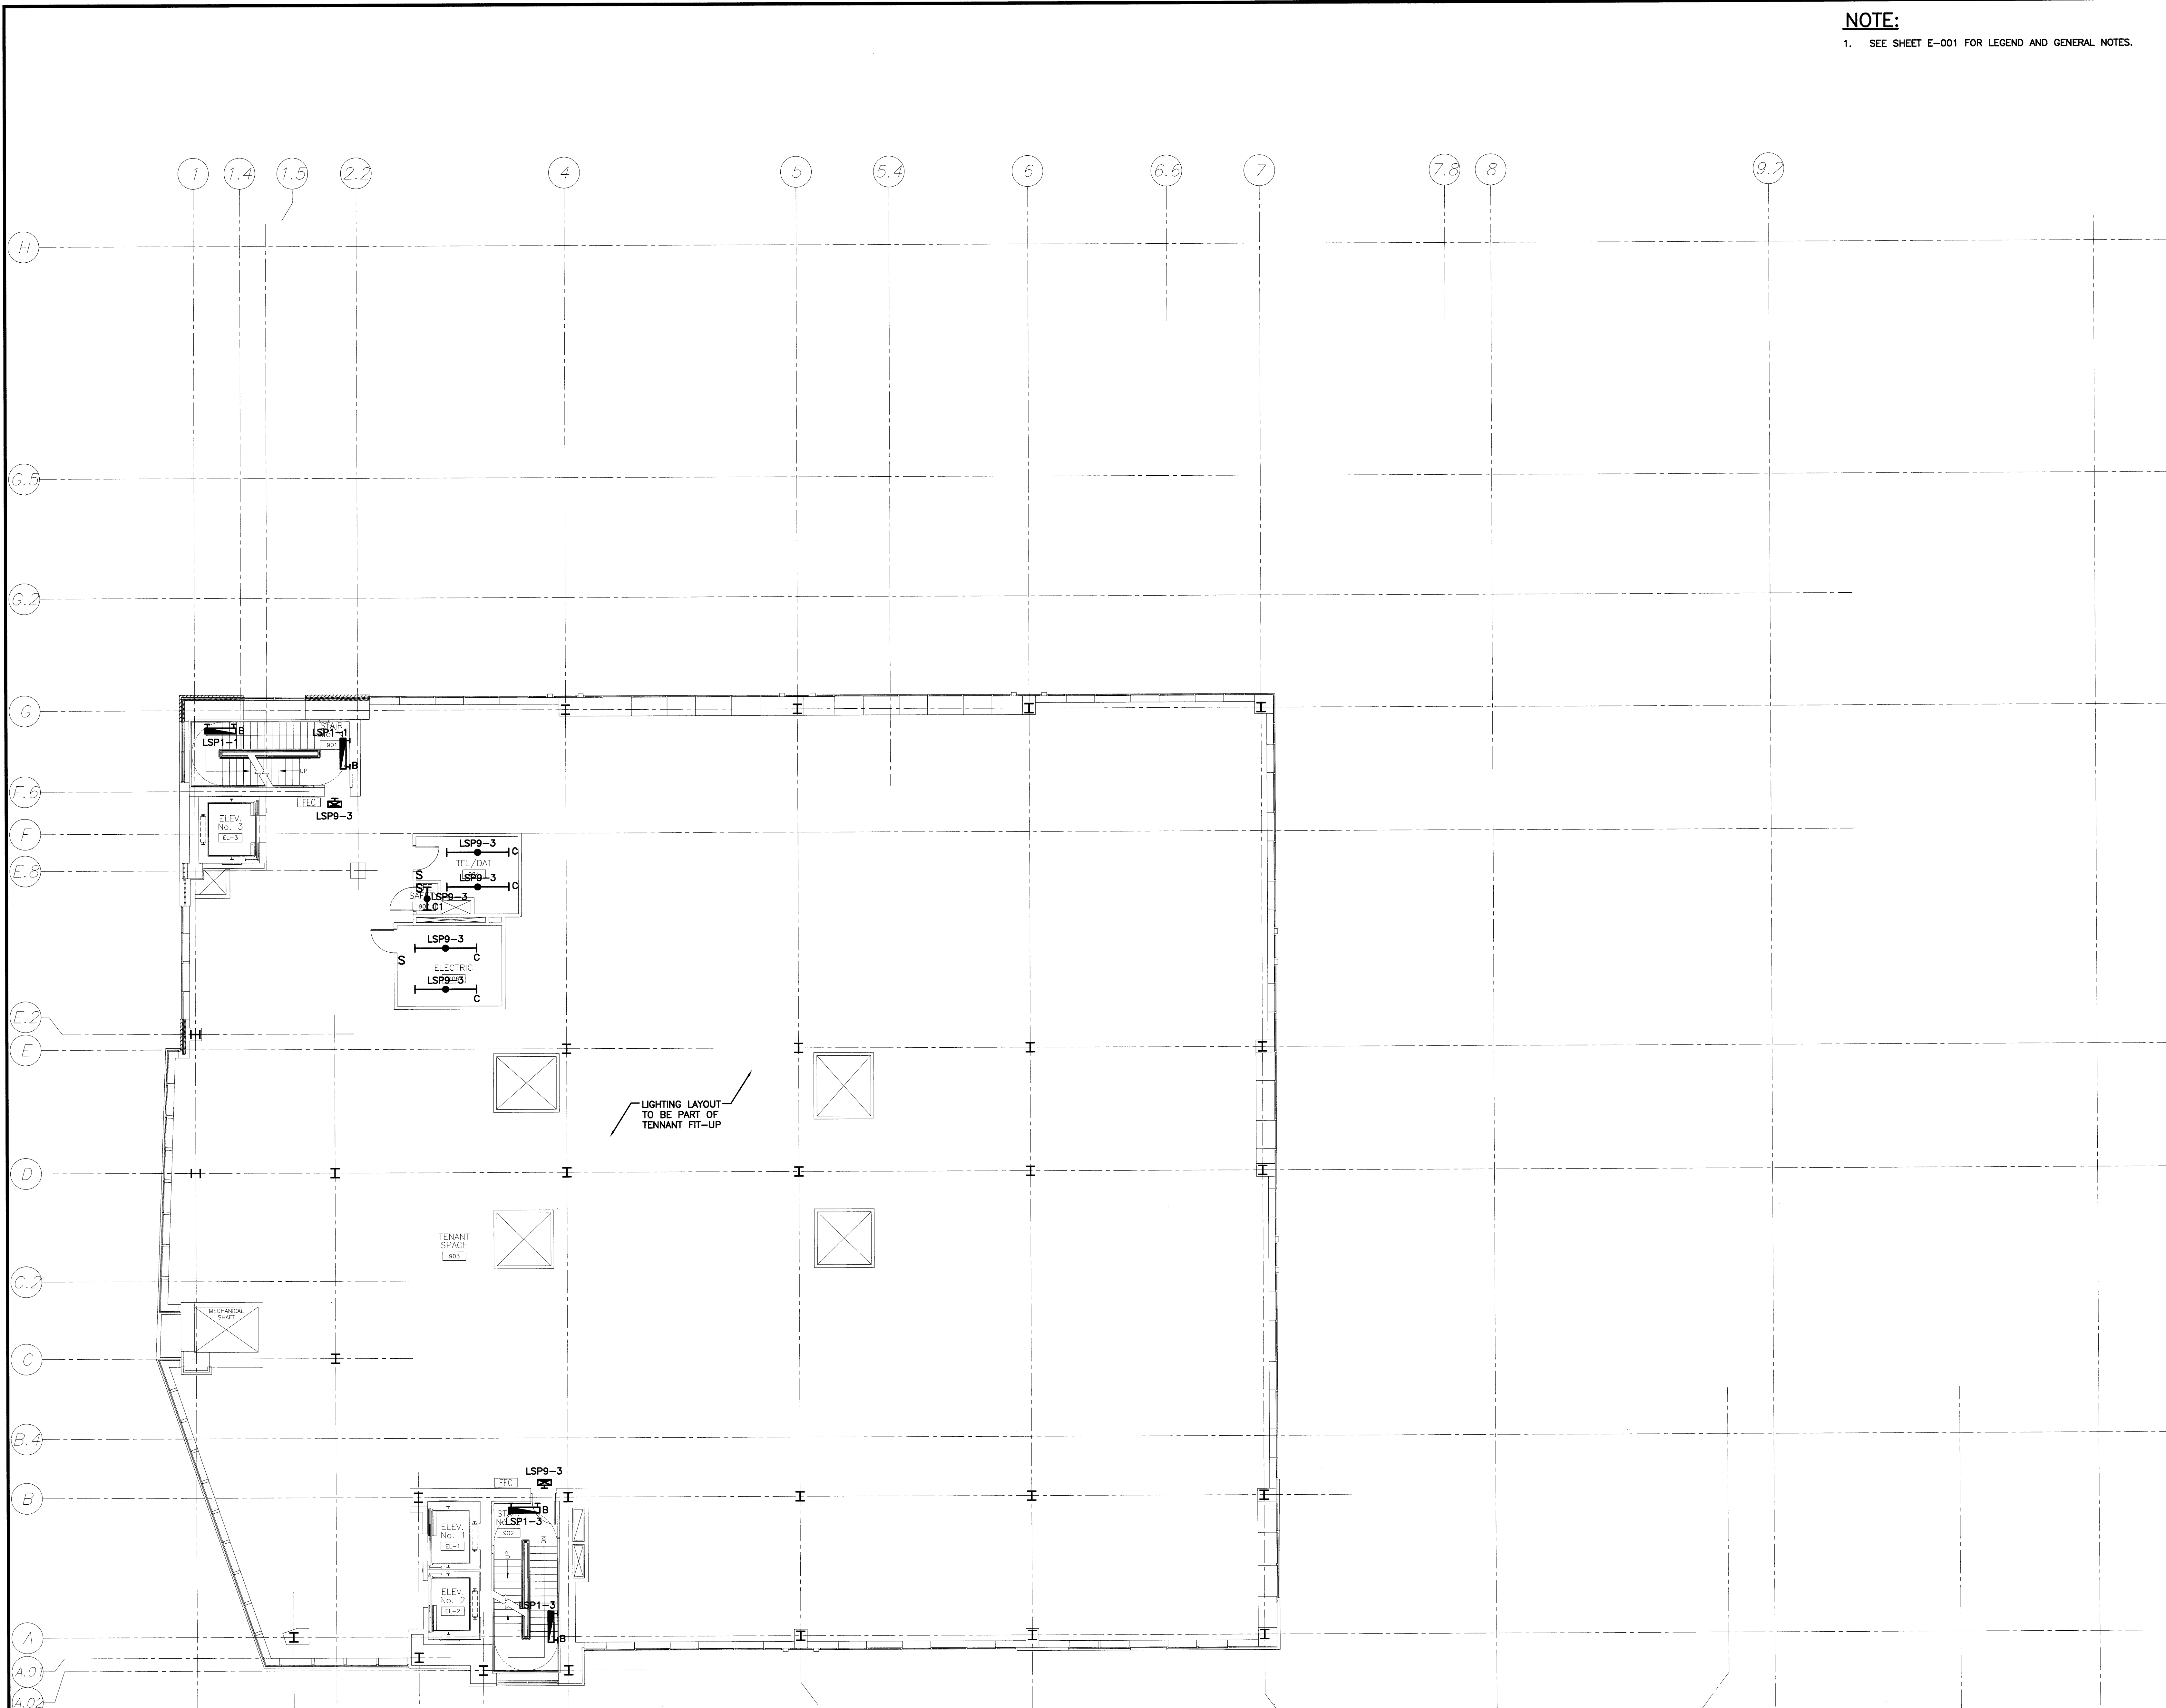

LIGHTING LAYOUT
TO BE PART OF
TENNANT FIT-UP

TENANT SPACE
#83

MECHANICAL ROOM

ELEV. No. 1
ELEV. No. 2

A1 FLOOR PLAN
1/8"=1'-0"