



**NOTE:**  
1. SEE SHEET E-001 FOR LEGEND AND GENERAL NOTES.

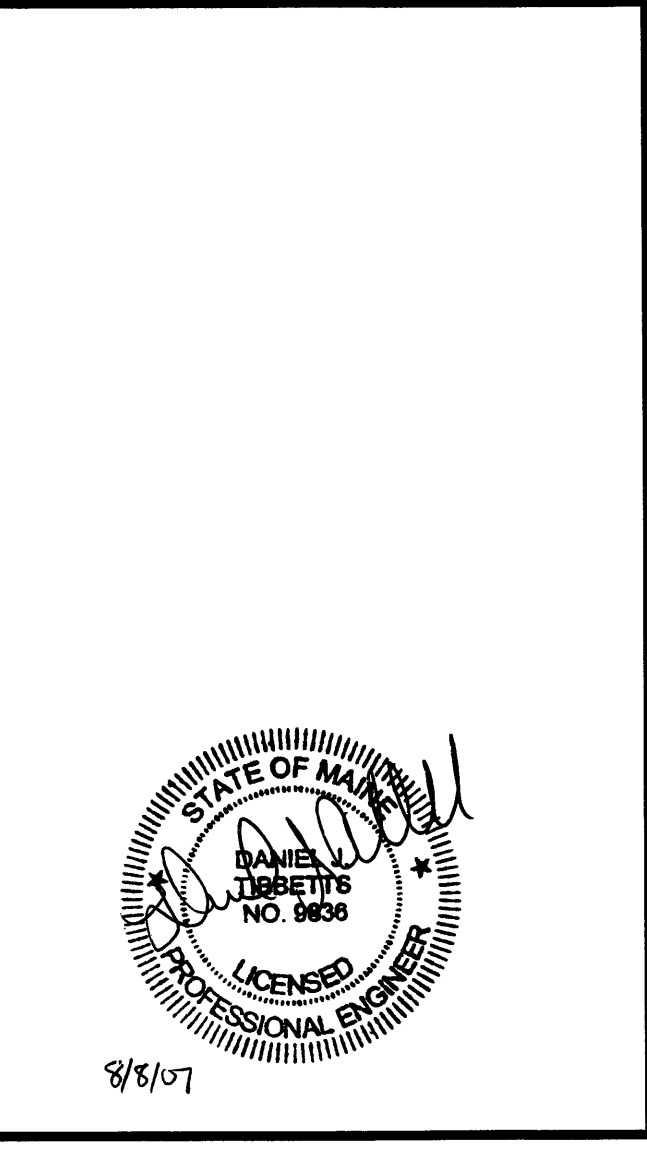

**ESB**  
E.S. BOULOS CO  
ELECTRICAL CONTRACTORS  
45 BRADLEY DRIVE  
WESTBROOK, ME 04092  
TEL: (207) 464-3706  
FAX: (207) 464-1833


Project Title  
**84 MARGINAL WAY**  
Portland, Maine  
WA Project No. **06196**  
Key Plan  
Office Bldg. Parking  
N

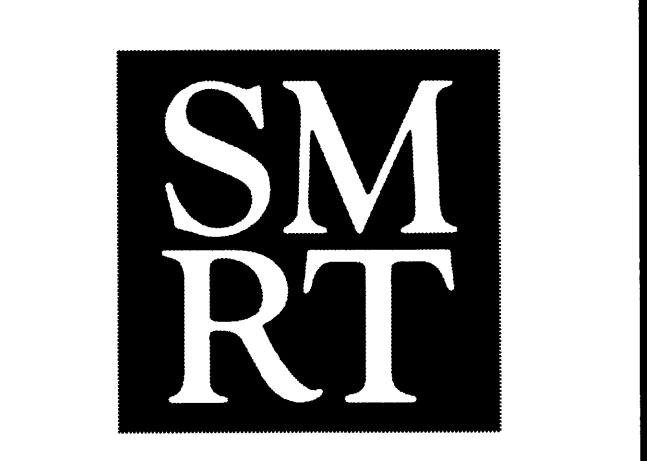

| Mark | Date    | Description                |
|------|---------|----------------------------|
| 0    | 8-8-07  | ISSUED FOR CONSTRUCTION    |
| -    | 8-2-07  | ISSUED FOR PERMIT          |
| -    | 5-18-07 | 50% CONSTRUCTION DOCUMENTS |
| -    | 3-23-07 | 25% CONSTRUCTION DOCUMENTS |

Drawing Status  
**ISSUED FOR CONSTRUCTION**

Drawing Title  
**TENTH FLOOR LIGHTING PLAN**  
PA / PE: DJT Drawn By: CDS  
Drawing Number  
**EL110**

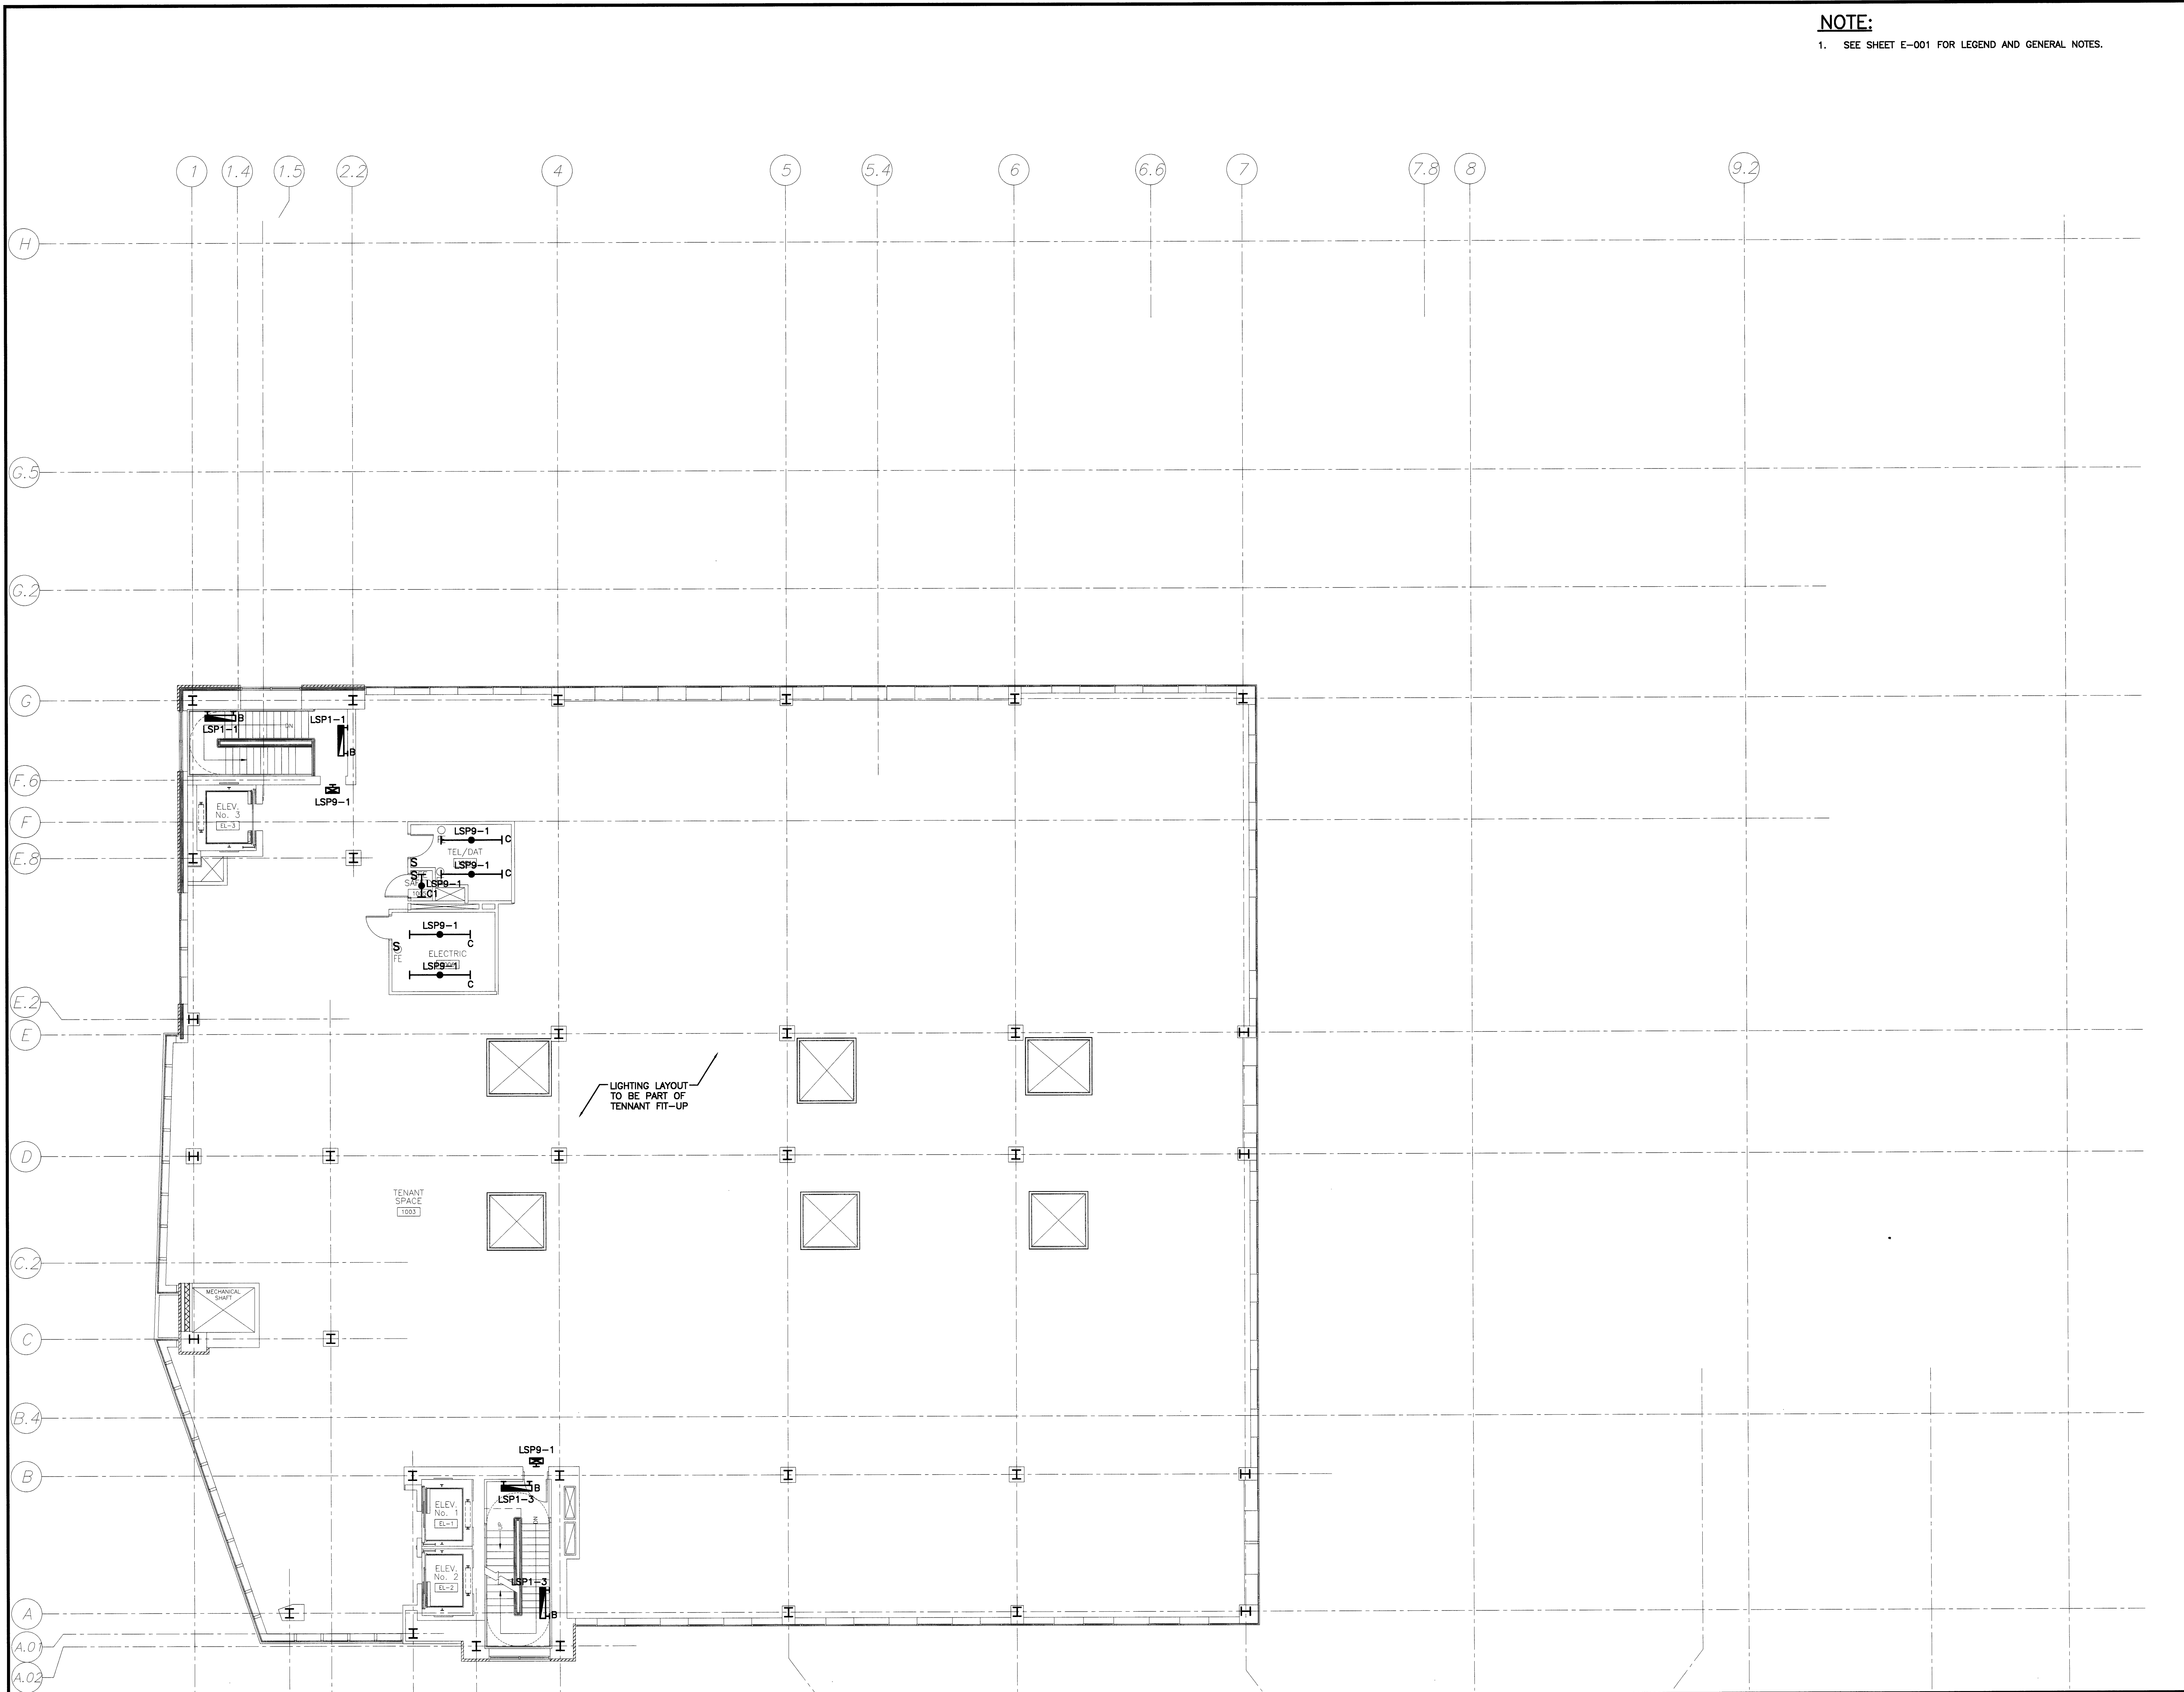

**A1 FLOOR PLAN**  
1/8"=1'-0"