



NOTE:
1. SEE SHEET E-001 FOR LEGEND AND GENERAL NOTES.

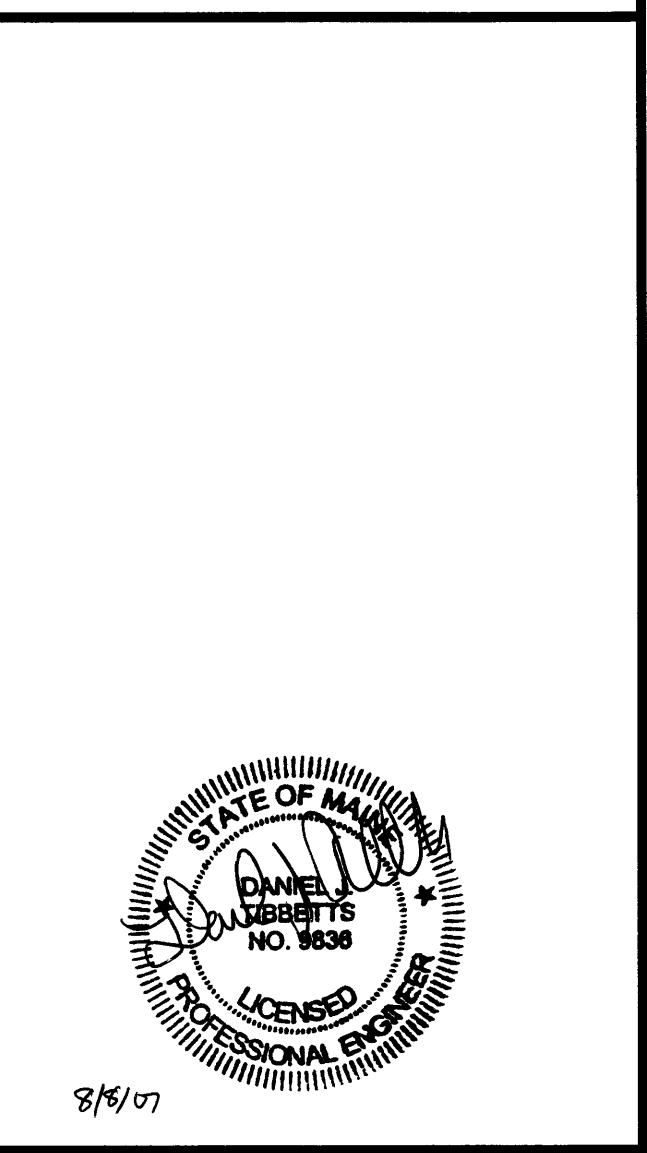

ESIB
E.S. BOULOS CO
ELECTRICAL CONTRACTORS
45 BRADLEY DRIVE
WESTBROOK, ME 04092
TEL: (207) 464-3706
FAX: (207) 464-1833

Project Title
84 MARGINAL WAY
Portland, Maine
HA Project No. **06196**
Key Plan
Office Bldg. Parking
N

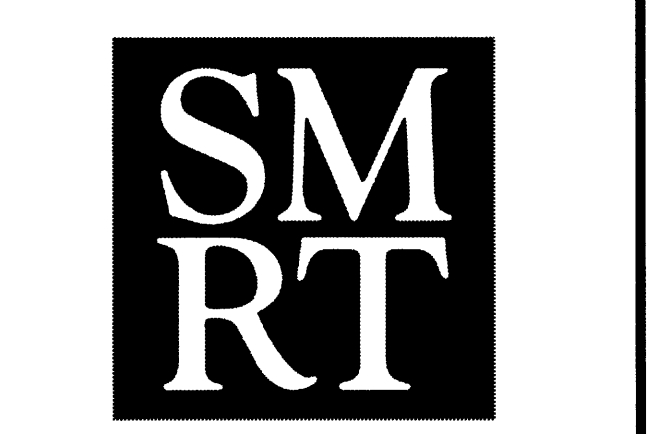


Mark	Date	Description
0	8-8-07	ISSUED FOR CONSTRUCTION
-	8-2-07	ISSUED FOR PERMIT
-	5-18-07	50% CONSTRUCTION DOCUMENTS
-	3-23-07	25% CONSTRUCTION DOCUMENTS

Drawing Status
ISSUED FOR CONSTRUCTION

Drawing Title
ELEVENTH FLOOR LIGHTING PLAN
PA / PE: DJT Drawn By: CDS
Drawing Number

EL111
SMRT CAD FILE: EL111-07053

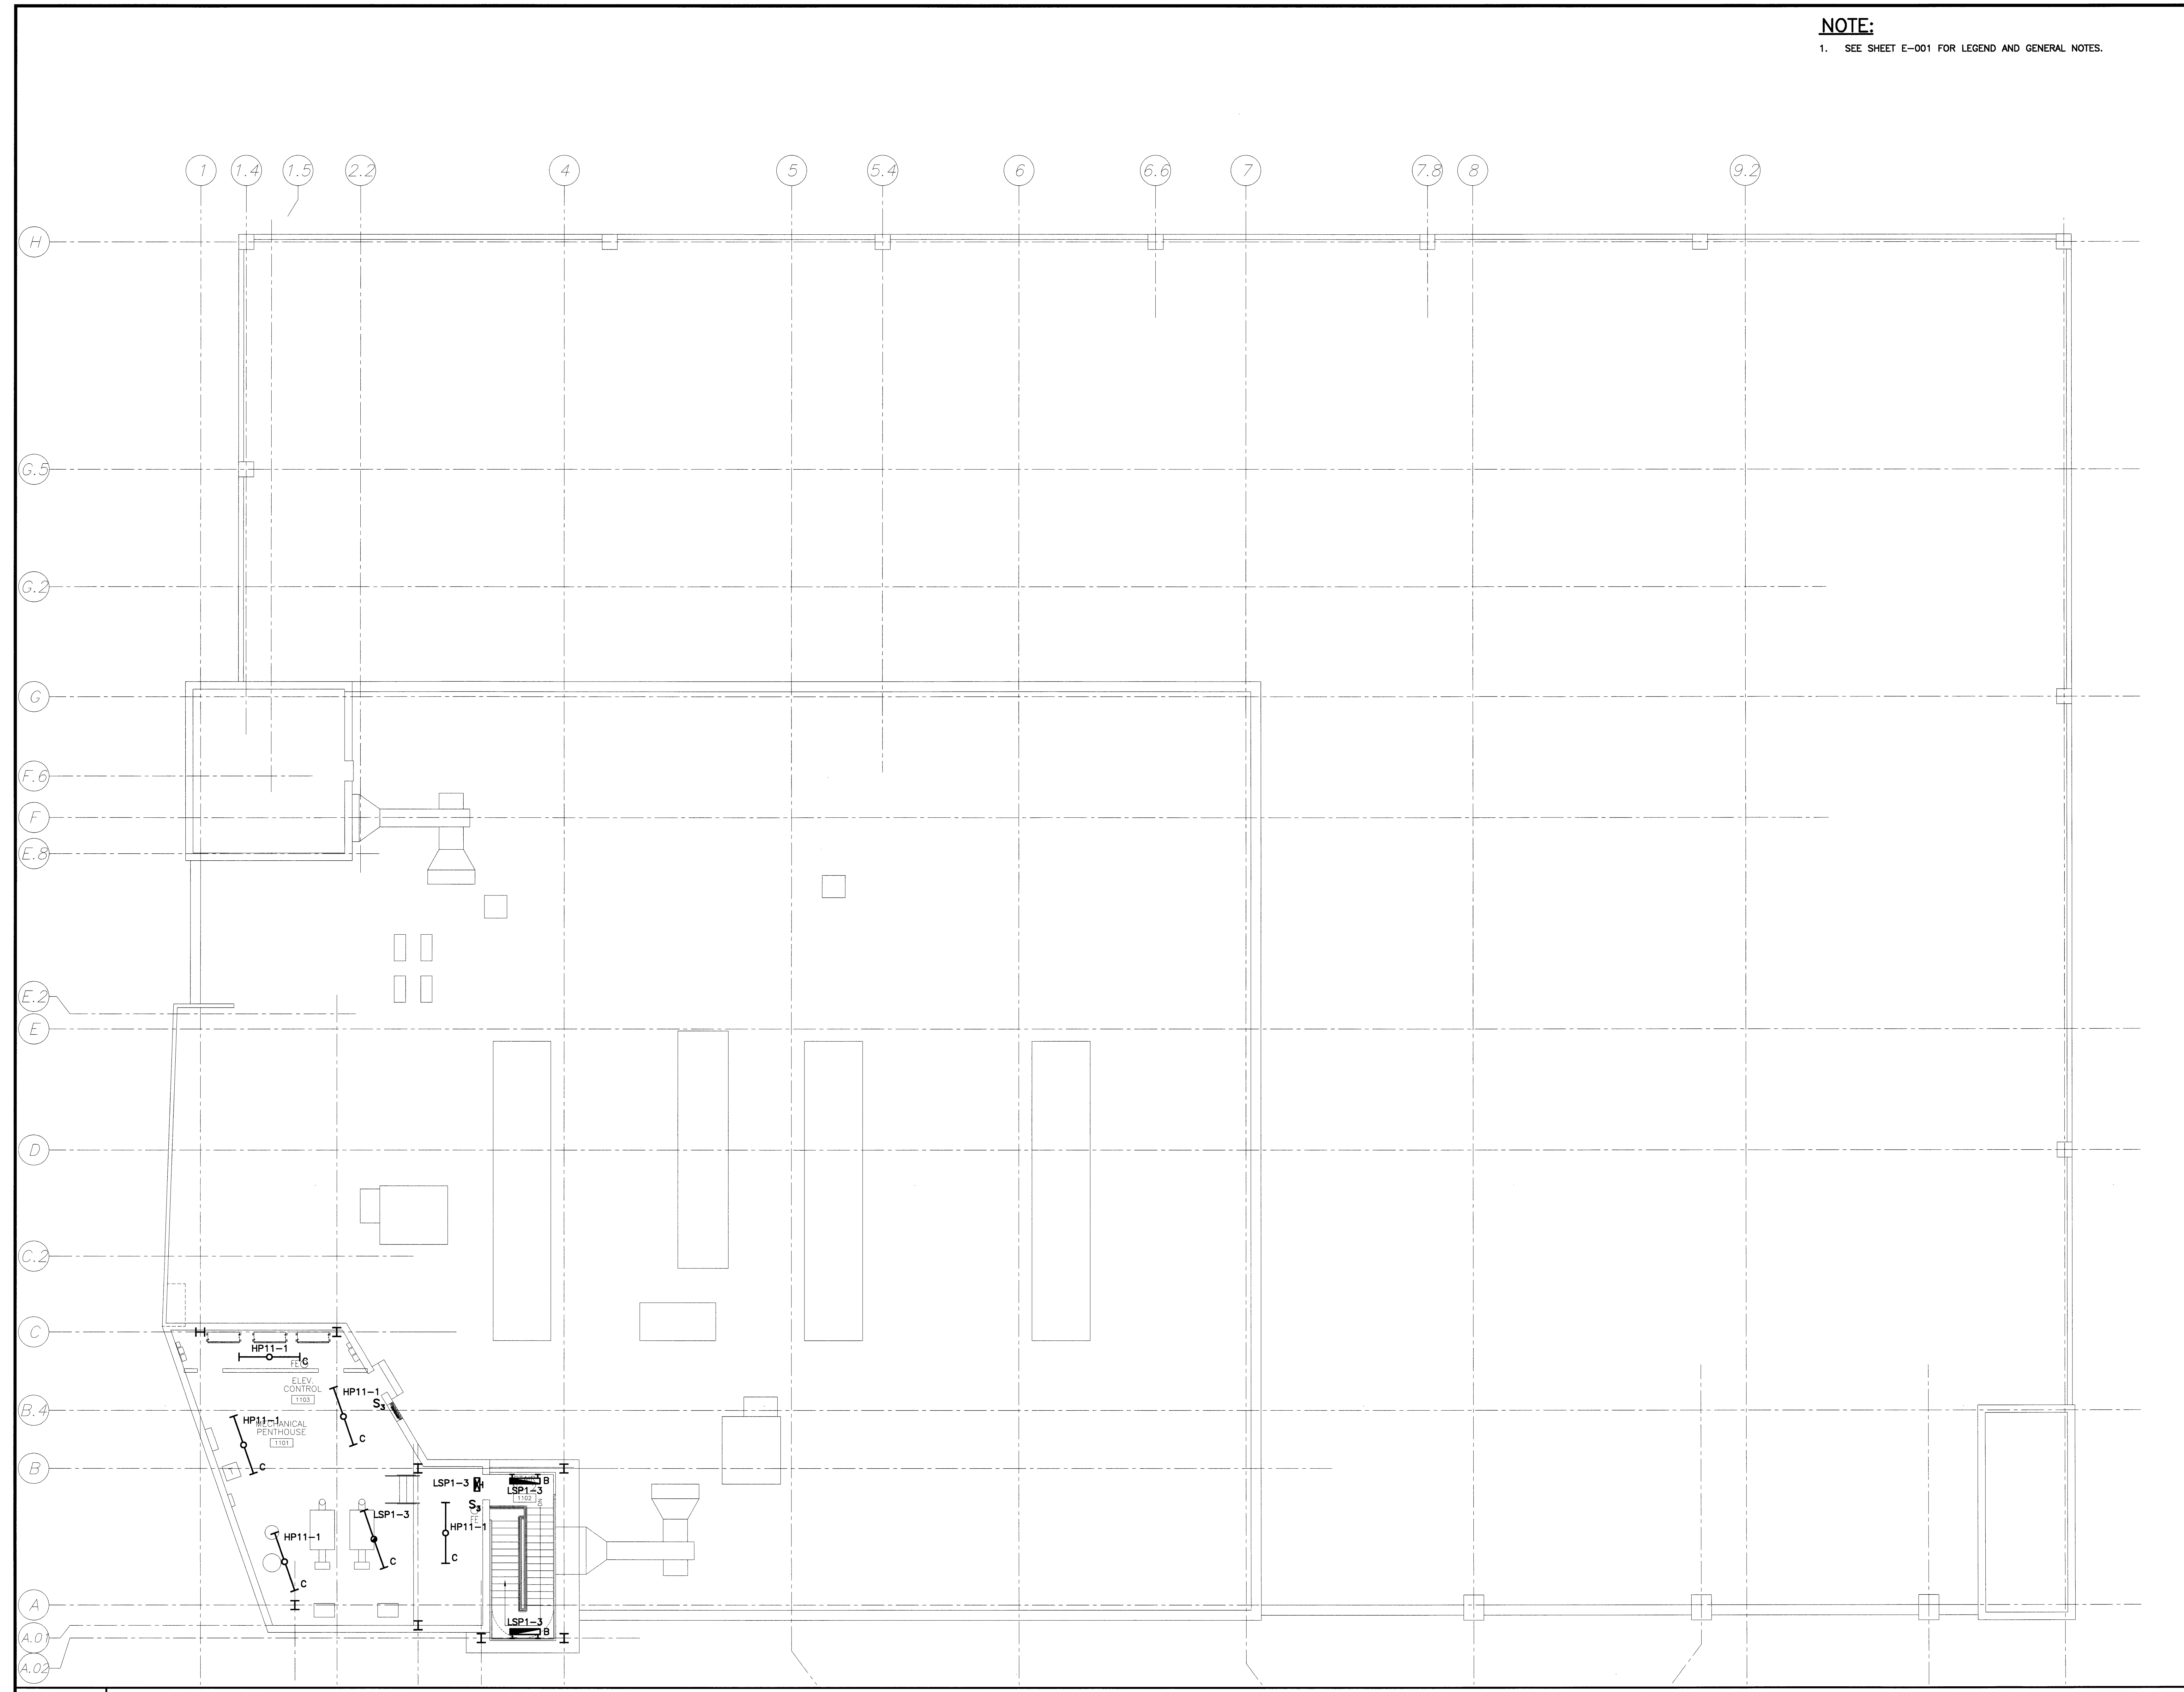

A1 FLOOR PLAN
1/8"=1'-0"