

NOTE:  
1. SEE SHEET E-001 FOR LEGEND AND GENERAL NOTES.





E.S. BOULOS CO  
ELECTRICAL CONTRACTORS

45 BRADLEY DRIVE  
WESTBROOK, ME 04092  
TEL: (207) 464-3706  
FAX: (207) 464-1833

Project Title  
84 MARGINAL WAY  
Portland, Maine

HA Project No. 06196

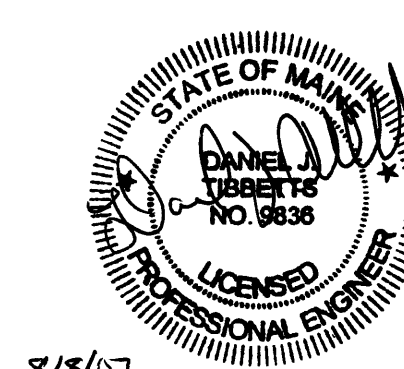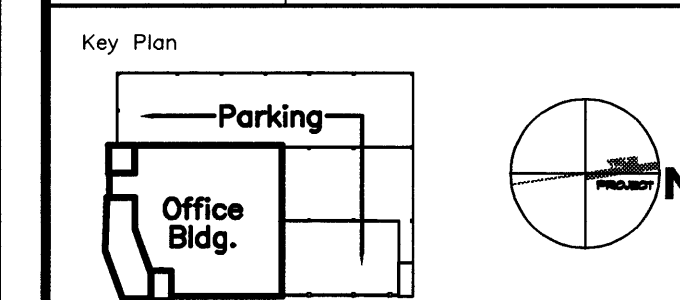

Mark	Date	Description
0	8-8-07	ISSUED FOR CONSTRUCTION
-	8-2-07	ISSUED FOR PERMIT
-	5-18-07	50% CONSTRUCTION DOCUMENTS
-	3-23-07	25% CONSTRUCTION DOCUMENTS


Drawing Status  
**ISSUED FOR CONSTRUCTION**

Drawing Title  
**FIRST FLOOR SYSTEMS PLAN**

PA / PE: DJT Drawn By: CDS  
Drawing Number

EY101

SMRT CAD FILE: EY101-07053

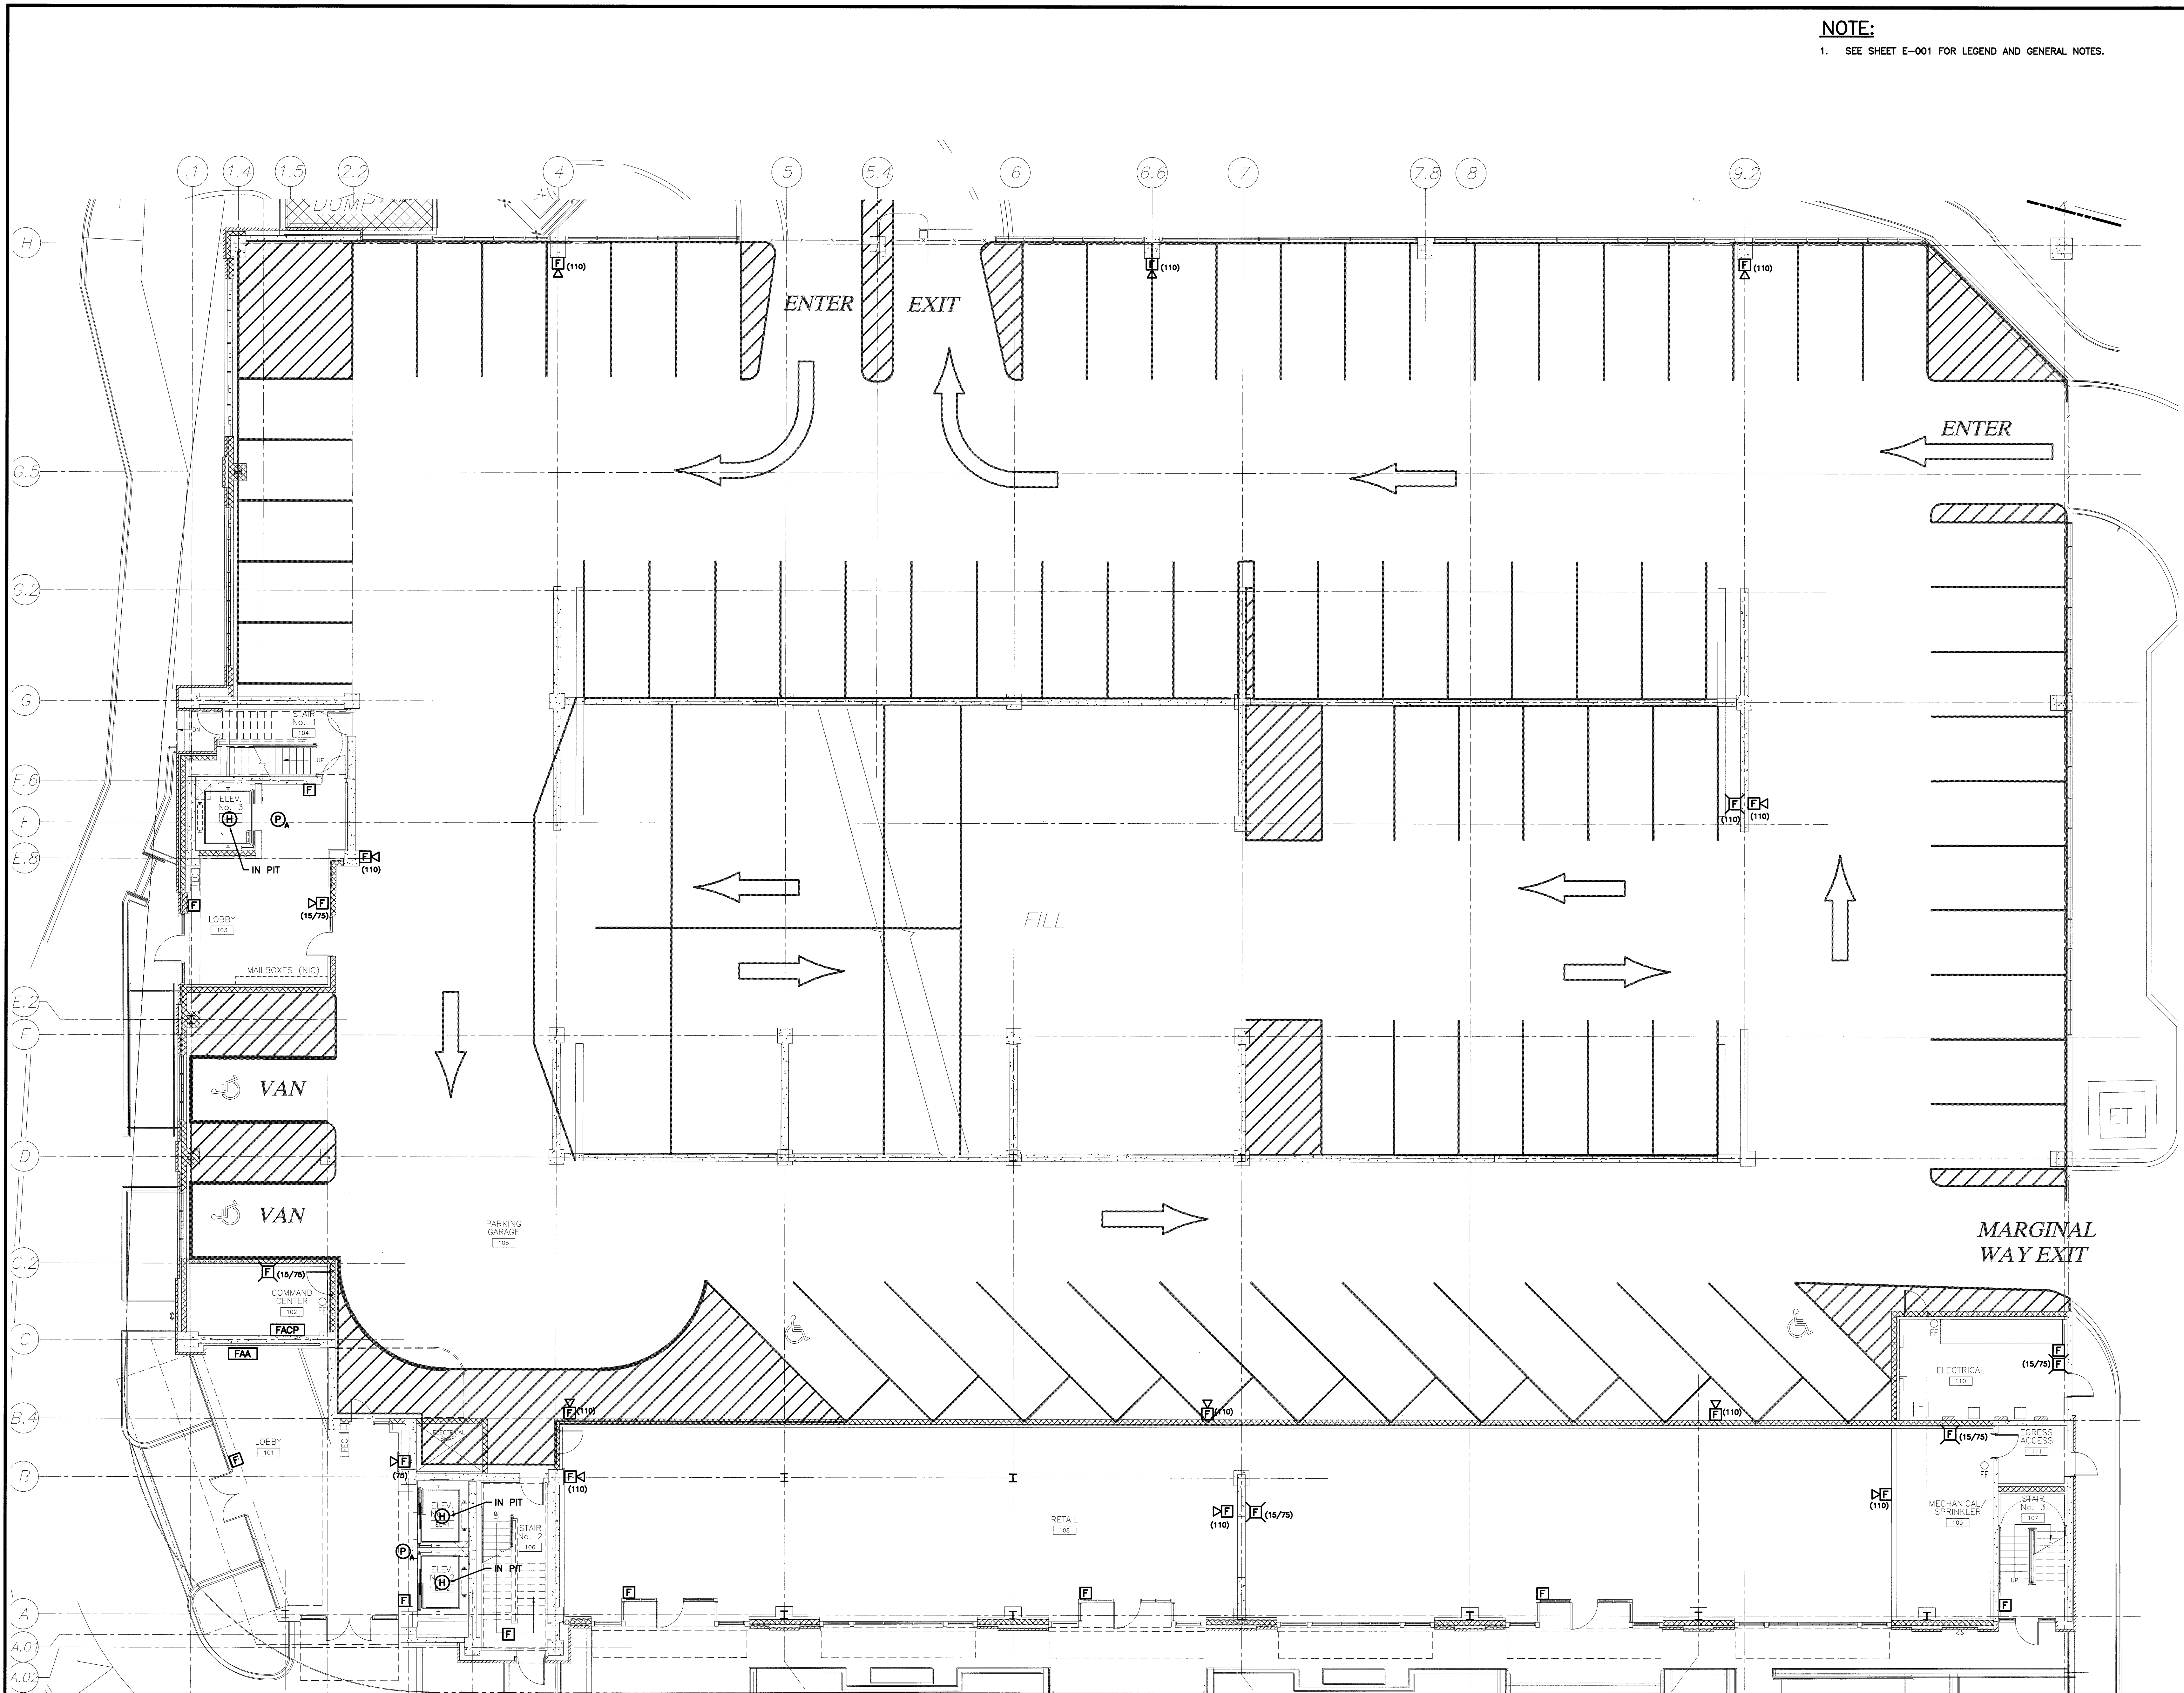

A1 FLOOR PLAN  
1/8"=1'-0"