




**NOTE:**  
1. SEE SHEET E-001 FOR LEGEND AND GENERAL NOTES.



**ESB**  
E.S. BOULOS CO  
ELECTRICAL CONTRACTORS  
45 BRADLEY DRIVE  
WESTBROOK, ME 04092  
TEL: (207) 464-3706  
FAX: (207) 464-1833

Project Title  
**84 MARGINAL WAY**  
Portland, Maine

HA Project No. **06198**

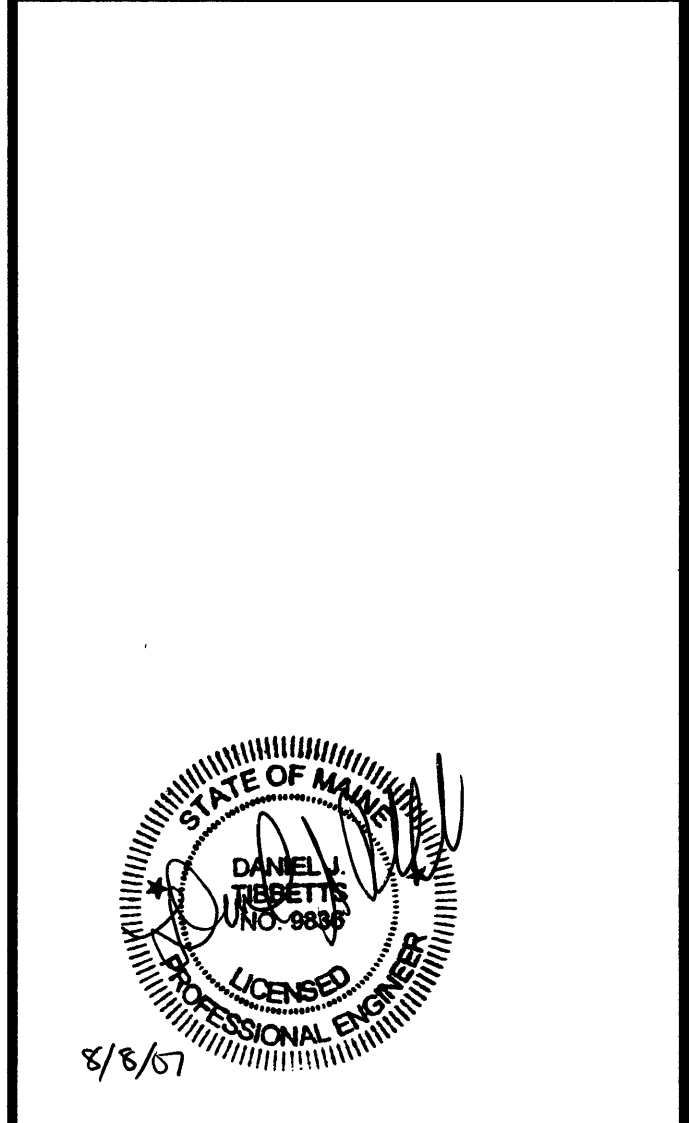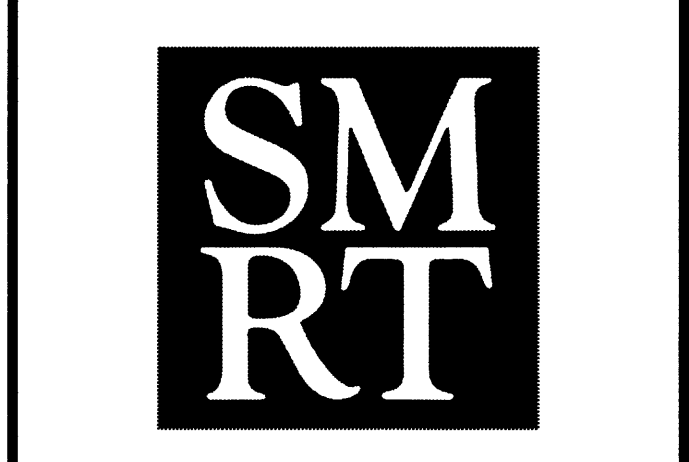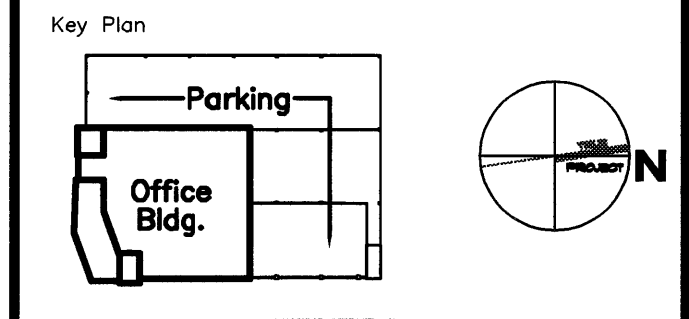

Mark	Date	Description
0	8-8-07	ISSUED FOR CONSTRUCTION
-	8-2-07	ISSUED FOR PERMIT
-	5-18-07	50% CONSTRUCTION DOCUMENTS
-	3-23-07	25% CONSTRUCTION DOCUMENTS

Drawing Status  
**ISSUED FOR CONSTRUCTION**

Drawing Title  
**THIRD FLOOR SYSTEMS PLAN**

PA / RE: DJT Drawn By: CDS  
Drawing Number

**EY103**

**A1 FLOOR PLAN**  
1/8"=1'-0"