

NOTE:

1. SEE SHEET E-001 FOR LEGEND AND GENERAL NOTES.



E.S. BOULOS CO
ELECTRICAL CONTRACTORS



45 BRADLEY DRIVE
WESTBROOK, ME 04092
TEL: (207) 464-3706
FAX: (207) 464-1833

Project Title

84 MARGINAL WAY
Portland, Maine

HA Project No. 06196

Key Plan

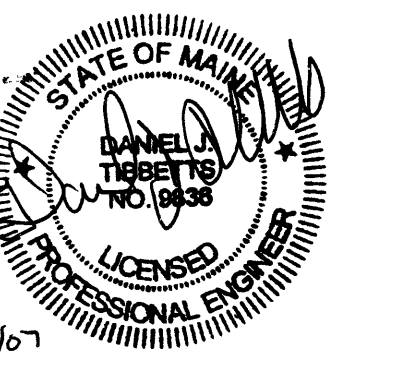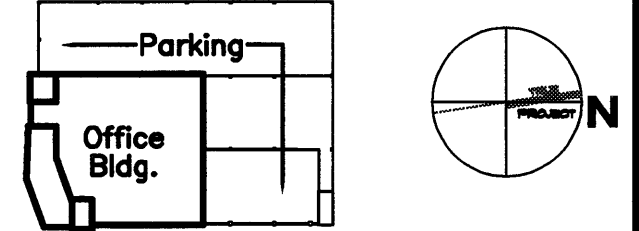


Mark	Date	Description
0	8-8-07	ISSUED FOR CONSTRUCTION
-	8-2-07	ISSUED FOR PERMIT
-	5-18-07	50% CONSTRUCTION DOCUMENTS
-	3-23-07	25% CONSTRUCTION DOCUMENTS

Drawing Status
ISSUED FOR CONSTRUCTION

Drawing Title
FIFTH FLOOR SYSTEMS PLAN

PA / PE: DJT Drawn By: CDS
Drawing Number

EY105

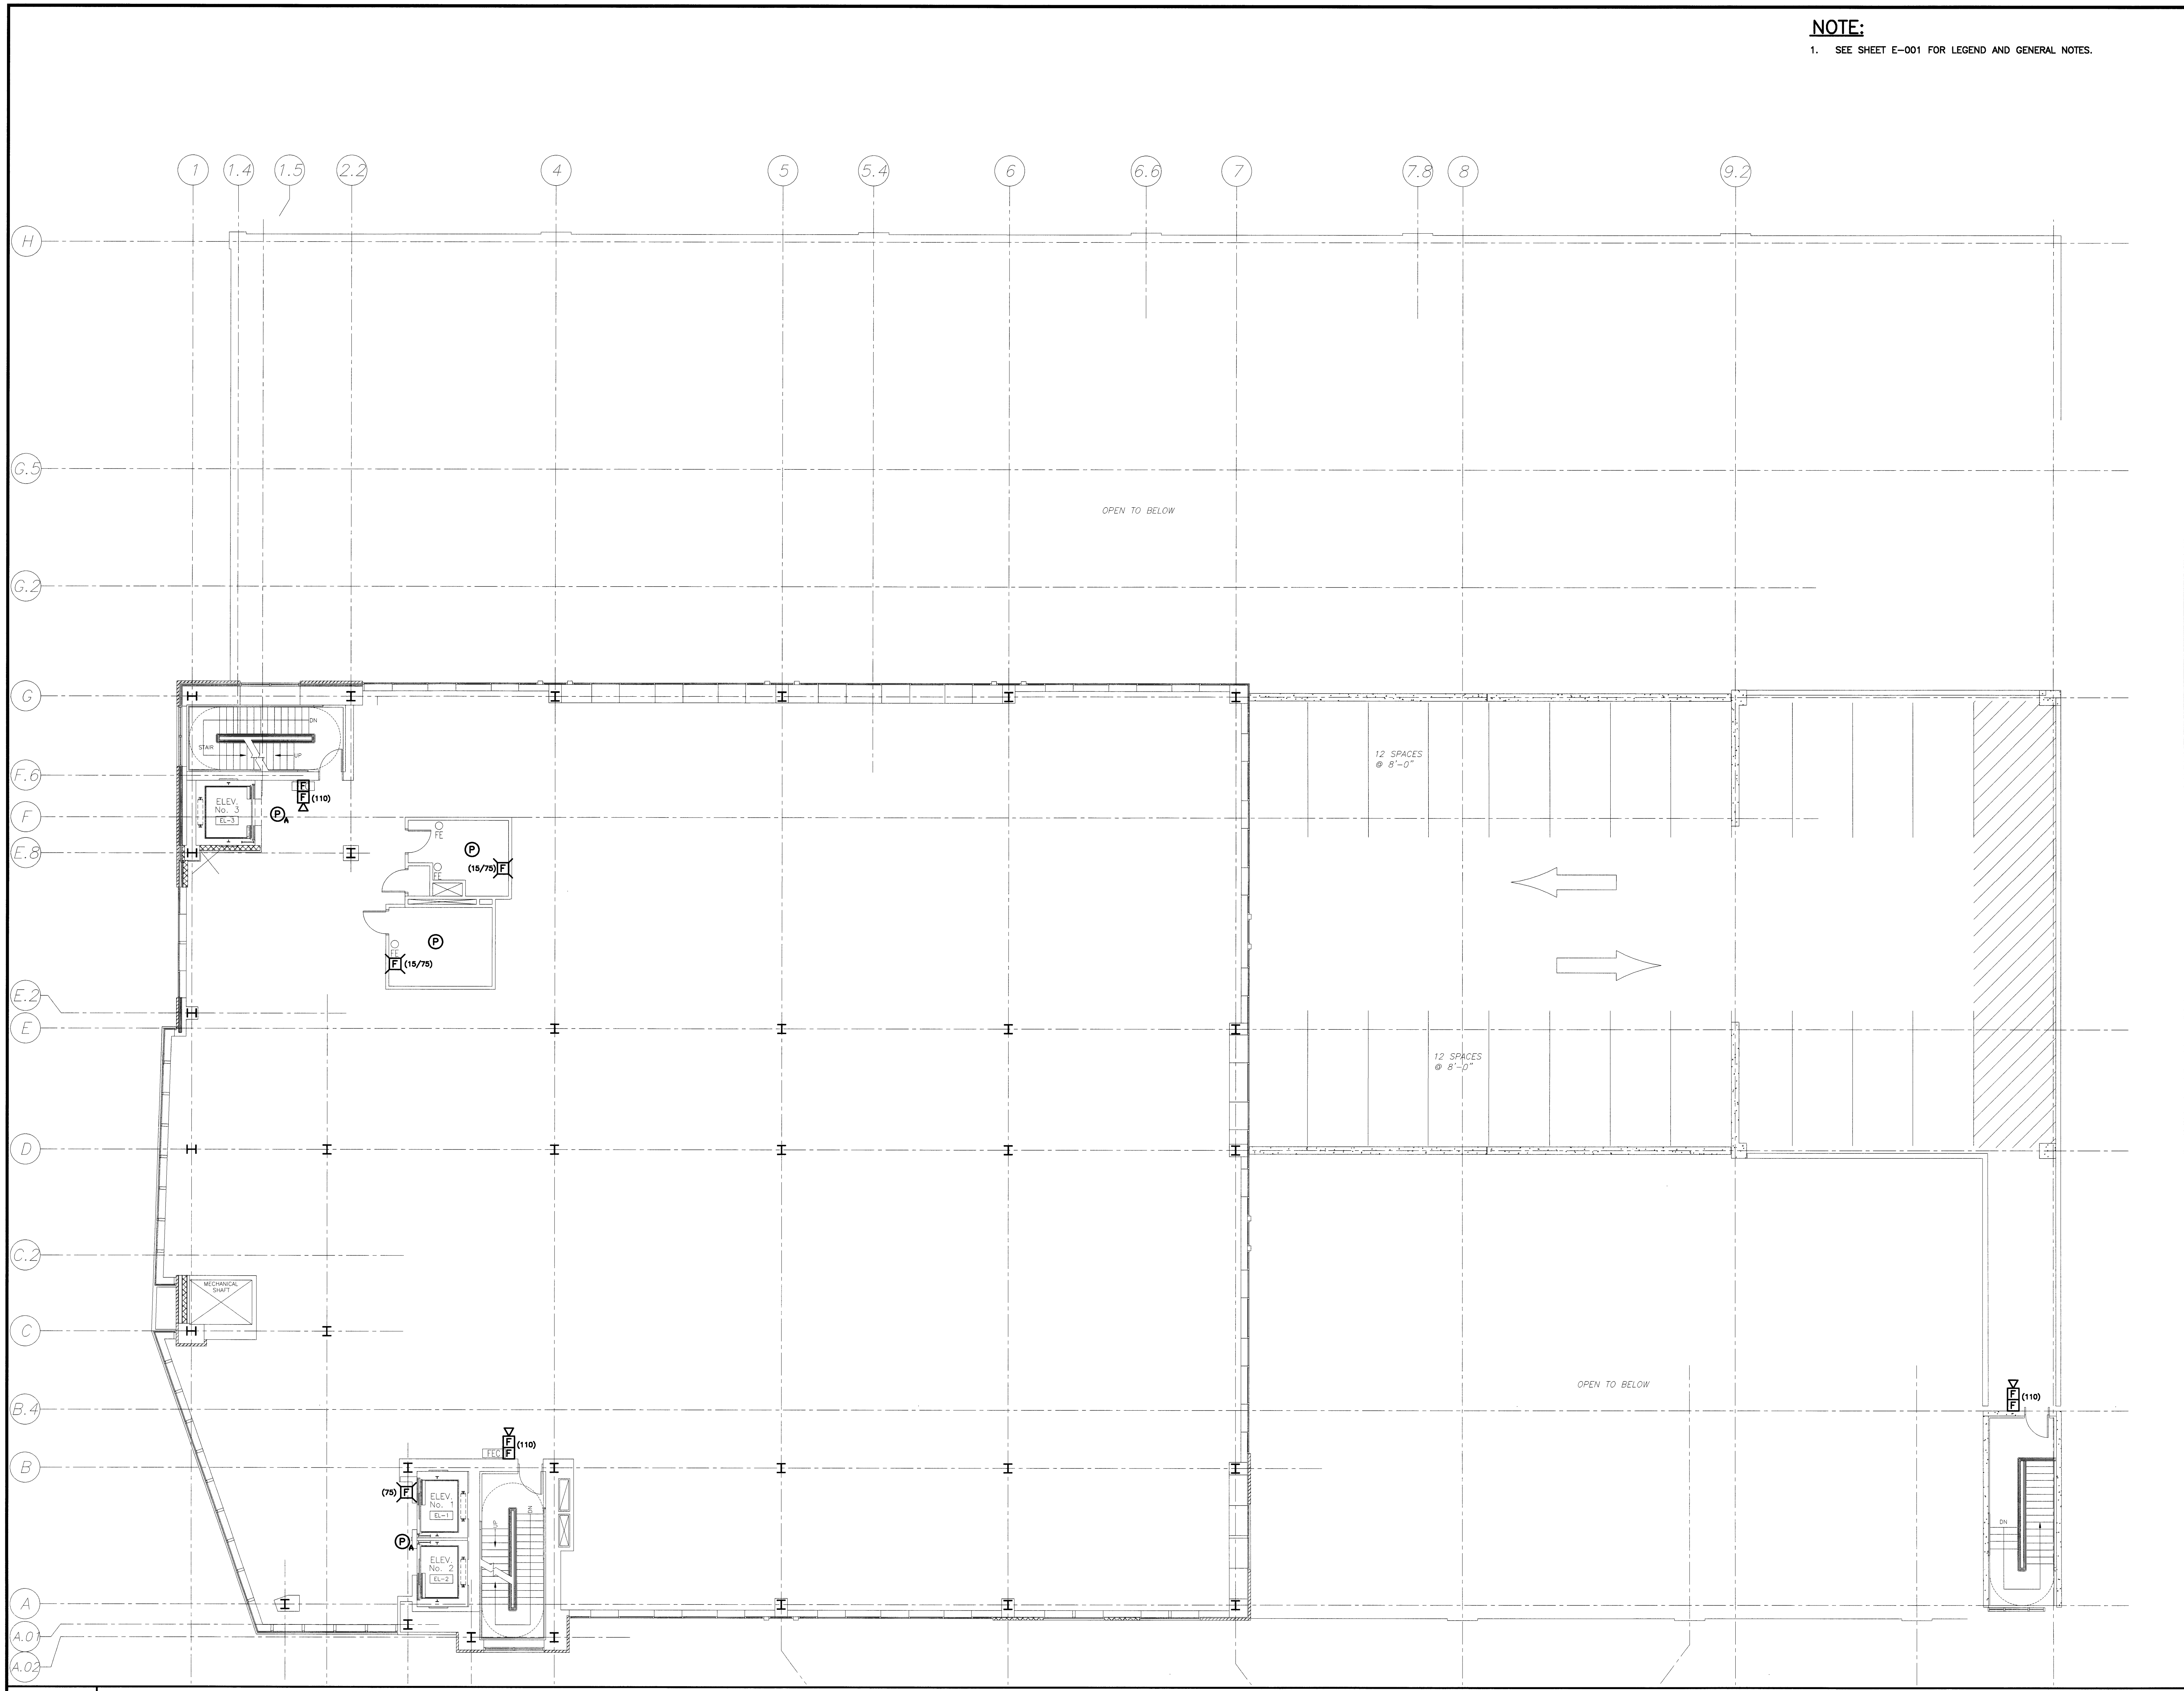

A1 FLOOR PLAN
1/8"=1'-0"