



**NOTE:**  
1. SEE SHEET E-001 FOR LEGEND AND GENERAL NOTES.

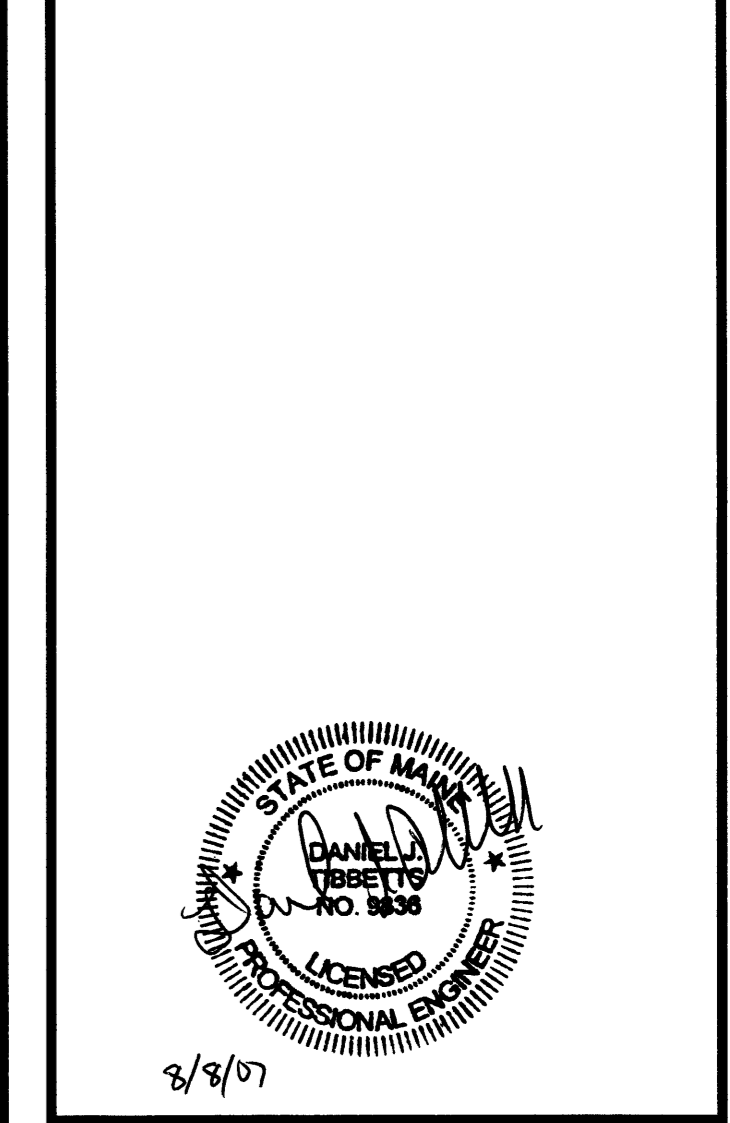

**ESIB**  
E.S. BOULOS CO  
ELECTRICAL CONTRACTORS  
45 BRADLEY DRIVE  
WESTBROOK, ME 04092  
TEL: (207) 464-3706  
FAX: (207) 464-1833

Project Title  
**84 MARGINAL WAY**  
Portland, Maine  
HA Project No. **06196**  
Key Plan  
Office Bldg. Parking  
N

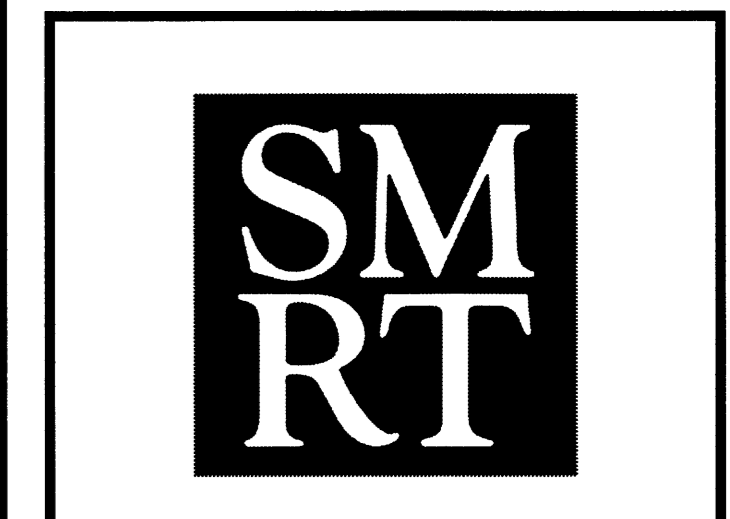


Mark	Date	Description
0	8-8-07	ISSUED FOR CONSTRUCTION
-	8-2-07	ISSUED FOR PERMIT
-	5-18-07	50% CONSTRUCTION DOCUMENTS
-	3-23-07	25% CONSTRUCTION DOCUMENTS

Drawing Status  
**ISSUED FOR CONSTRUCTION**

Drawing Title  
**EIGHTH FLOOR SYSTEMS PLAN**  
PA / PE: DJT Drawn By: CDS  
Drawing Number

**EY108**  
SMRT CAD FILE: EY108-07053

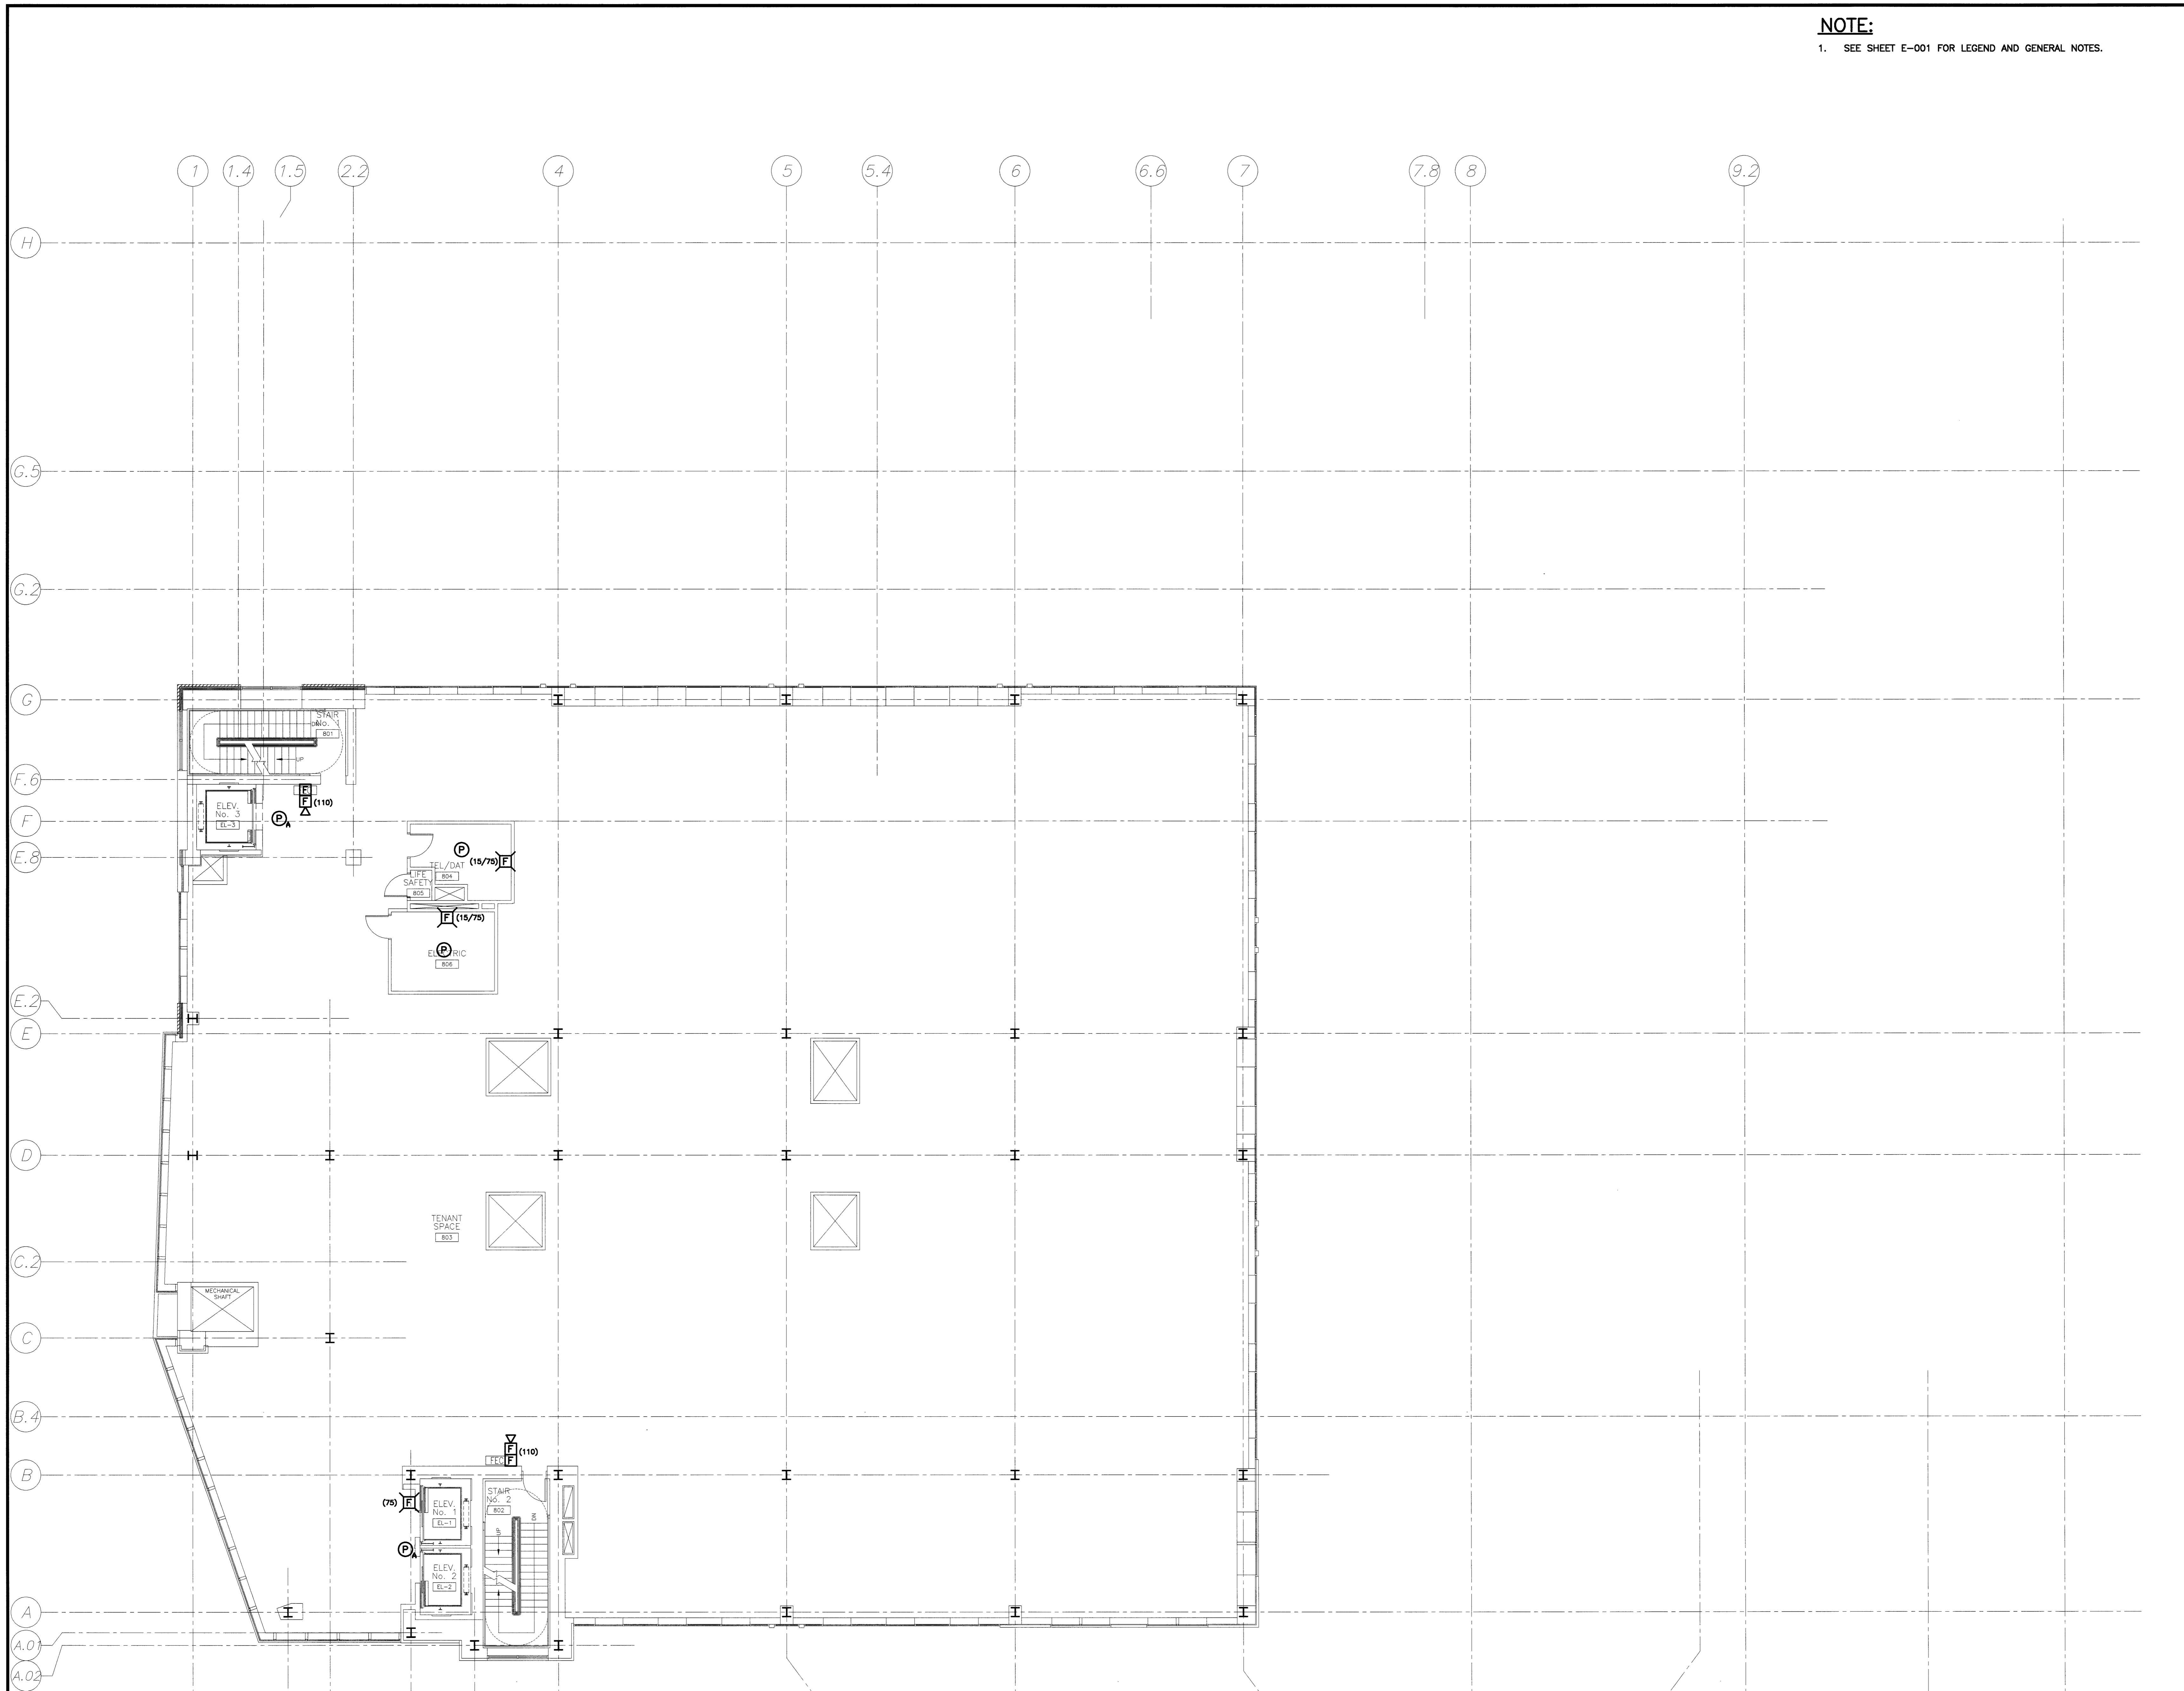

**A1 FLOOR PLAN**  
1/8"=1'-0"