

NOTE:
 1. SEE SHEET E-001 FOR LEGEND AND GENERAL NOTES.

KEYED NOTE:
 ① GANG MOUNT REMOTE TEST STATIONS FOR ALL SMOKE DETECTORS IN SINGLE LOCATION. FIELD VERIFY EXACT PLACEMENT OF REMOTE TEST STATIONS.
 ② MOUNT DUCT SMOKE DETECTORS CENTERED IN RETURN AND SUPPLY DUCTS. PROVIDE TWO DETECTORS MOUNTED AT ONE-QUARTER POINTS OF THE OPENING.





ESIB
 E.S. BOULOS CO
 ELECTRICAL CONTRACTORS
 45 BRADLEY DRIVE
 WESTBROOK, ME 04092
 TEL: (207) 464-3706
 FAX: (207) 464-1833

Project Title
 84 MARGINAL WAY
 Portland, Maine

HA Project No. 06196

Key Plan
 Office Bldg. Parking

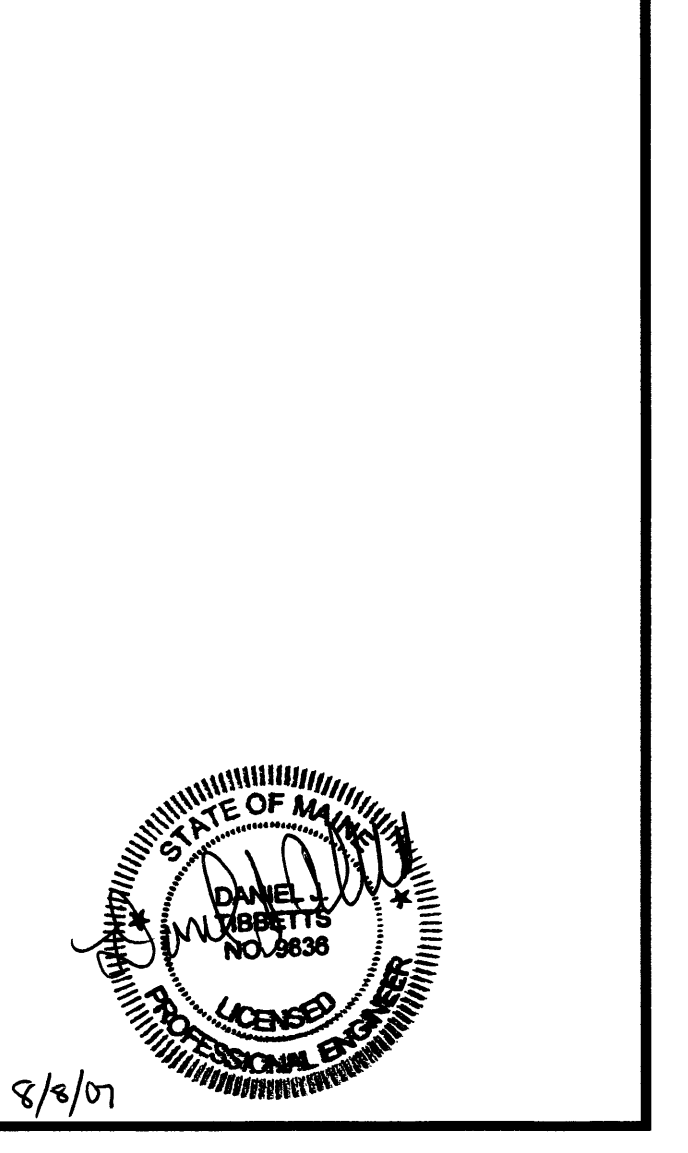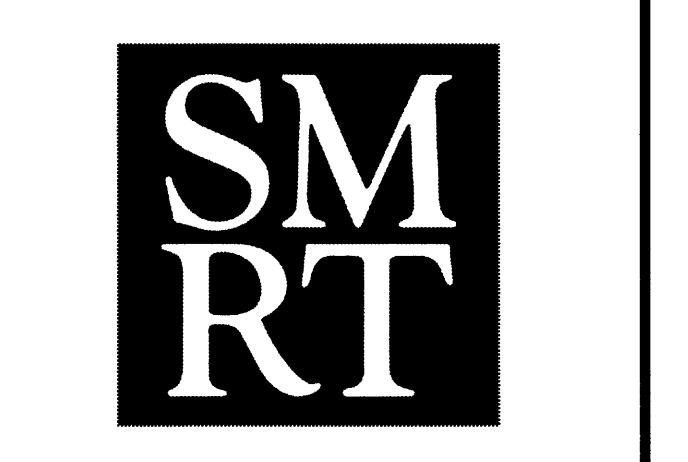

| Mark | Date | Description |
|------|---------|----------------------------|
| 0 | 8-8-07 | ISSUED FOR CONSTRUCTION |
| - | 8-2-07 | ISSUED FOR PERMIT |
| - | 5-18-07 | 50% CONSTRUCTION DOCUMENTS |
| - | 3-23-07 | 25% CONSTRUCTION DOCUMENTS |

Drawing Status
ISSUED FOR CONSTRUCTION

Drawing Title
ELEVENTH FLOOR SYSTEMS PLAN

PA / PE: DJT Drawn By: CDS
 Drawing Number

A1 FLOOR PLAN
 1/8"=1'-0"

EY111
 SMRT CAD FILE: EY111-07053