

11/18/2011 8:58:14 AM

A

B

C



D

E




- LEGEND:**
- EXISTING LIGHT POLE. PREP AND PAINT LIGHT POLES TO MATCH. INSTALL "BIRD SPIDER" BY STRIP B GONE OR APPROVED EQUAL - 2" Ø DIAMETER. ADHERED INSTALLATION.
  - INSTALL 1" "BIRD SPIDER" ON TOP OF EACH LIGHT POLE HEAD AND 1" ON TOP OF MAIN SUPPORT POLE. TYP. OF (14) LIGHT POLES.
  - EXISTING TREE TO REMAIN WITH NEW GRATE. PROVIDE 1" R-8704, 30"x30" AVENUE COLLECTION™ TREE GRATE BY NEMAN FOUNDRY OR APPROVED EQUAL.
  - EXISTING FIRE HYDRANT TO REMAIN
- LEGENDS PRESENTED BY**
1. REPLACE ALL EXISTING BOLLARD SLEEVES W/NEW. SEE SPECS. TYP. OF (28). SEE GENERAL NOTE "J" ON SHEET A201


D1 SITE PLAN  
A002 1" = 30'-0"

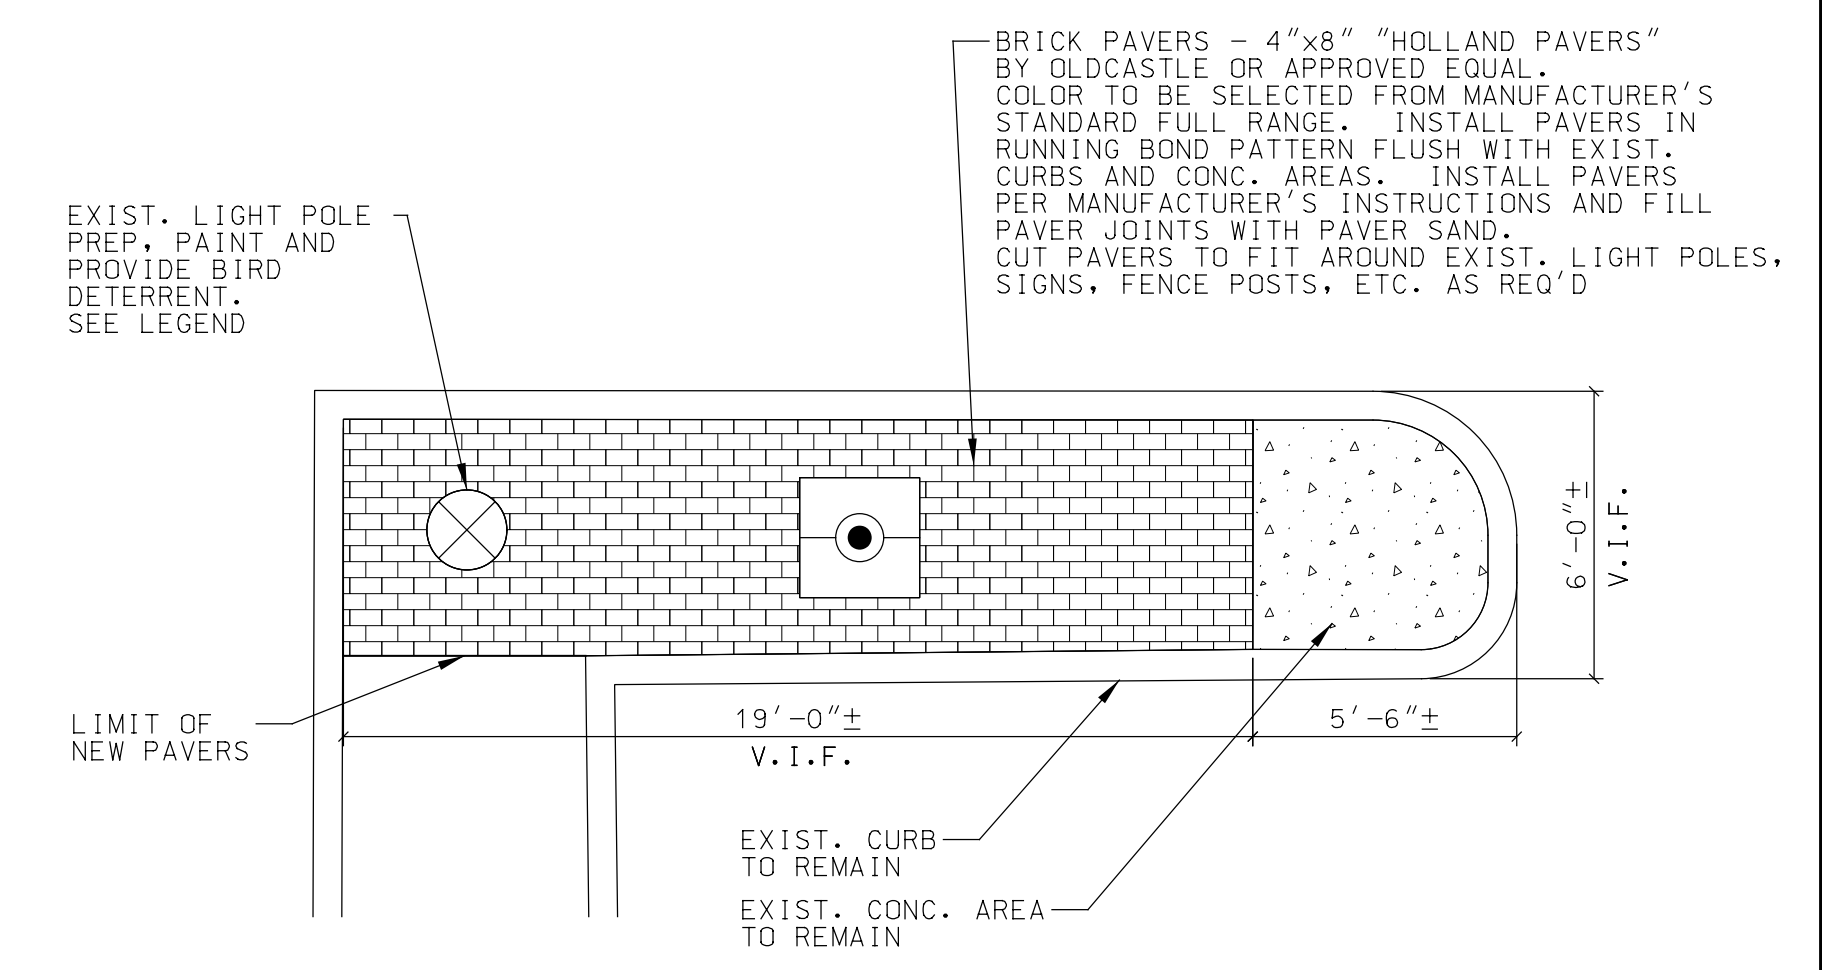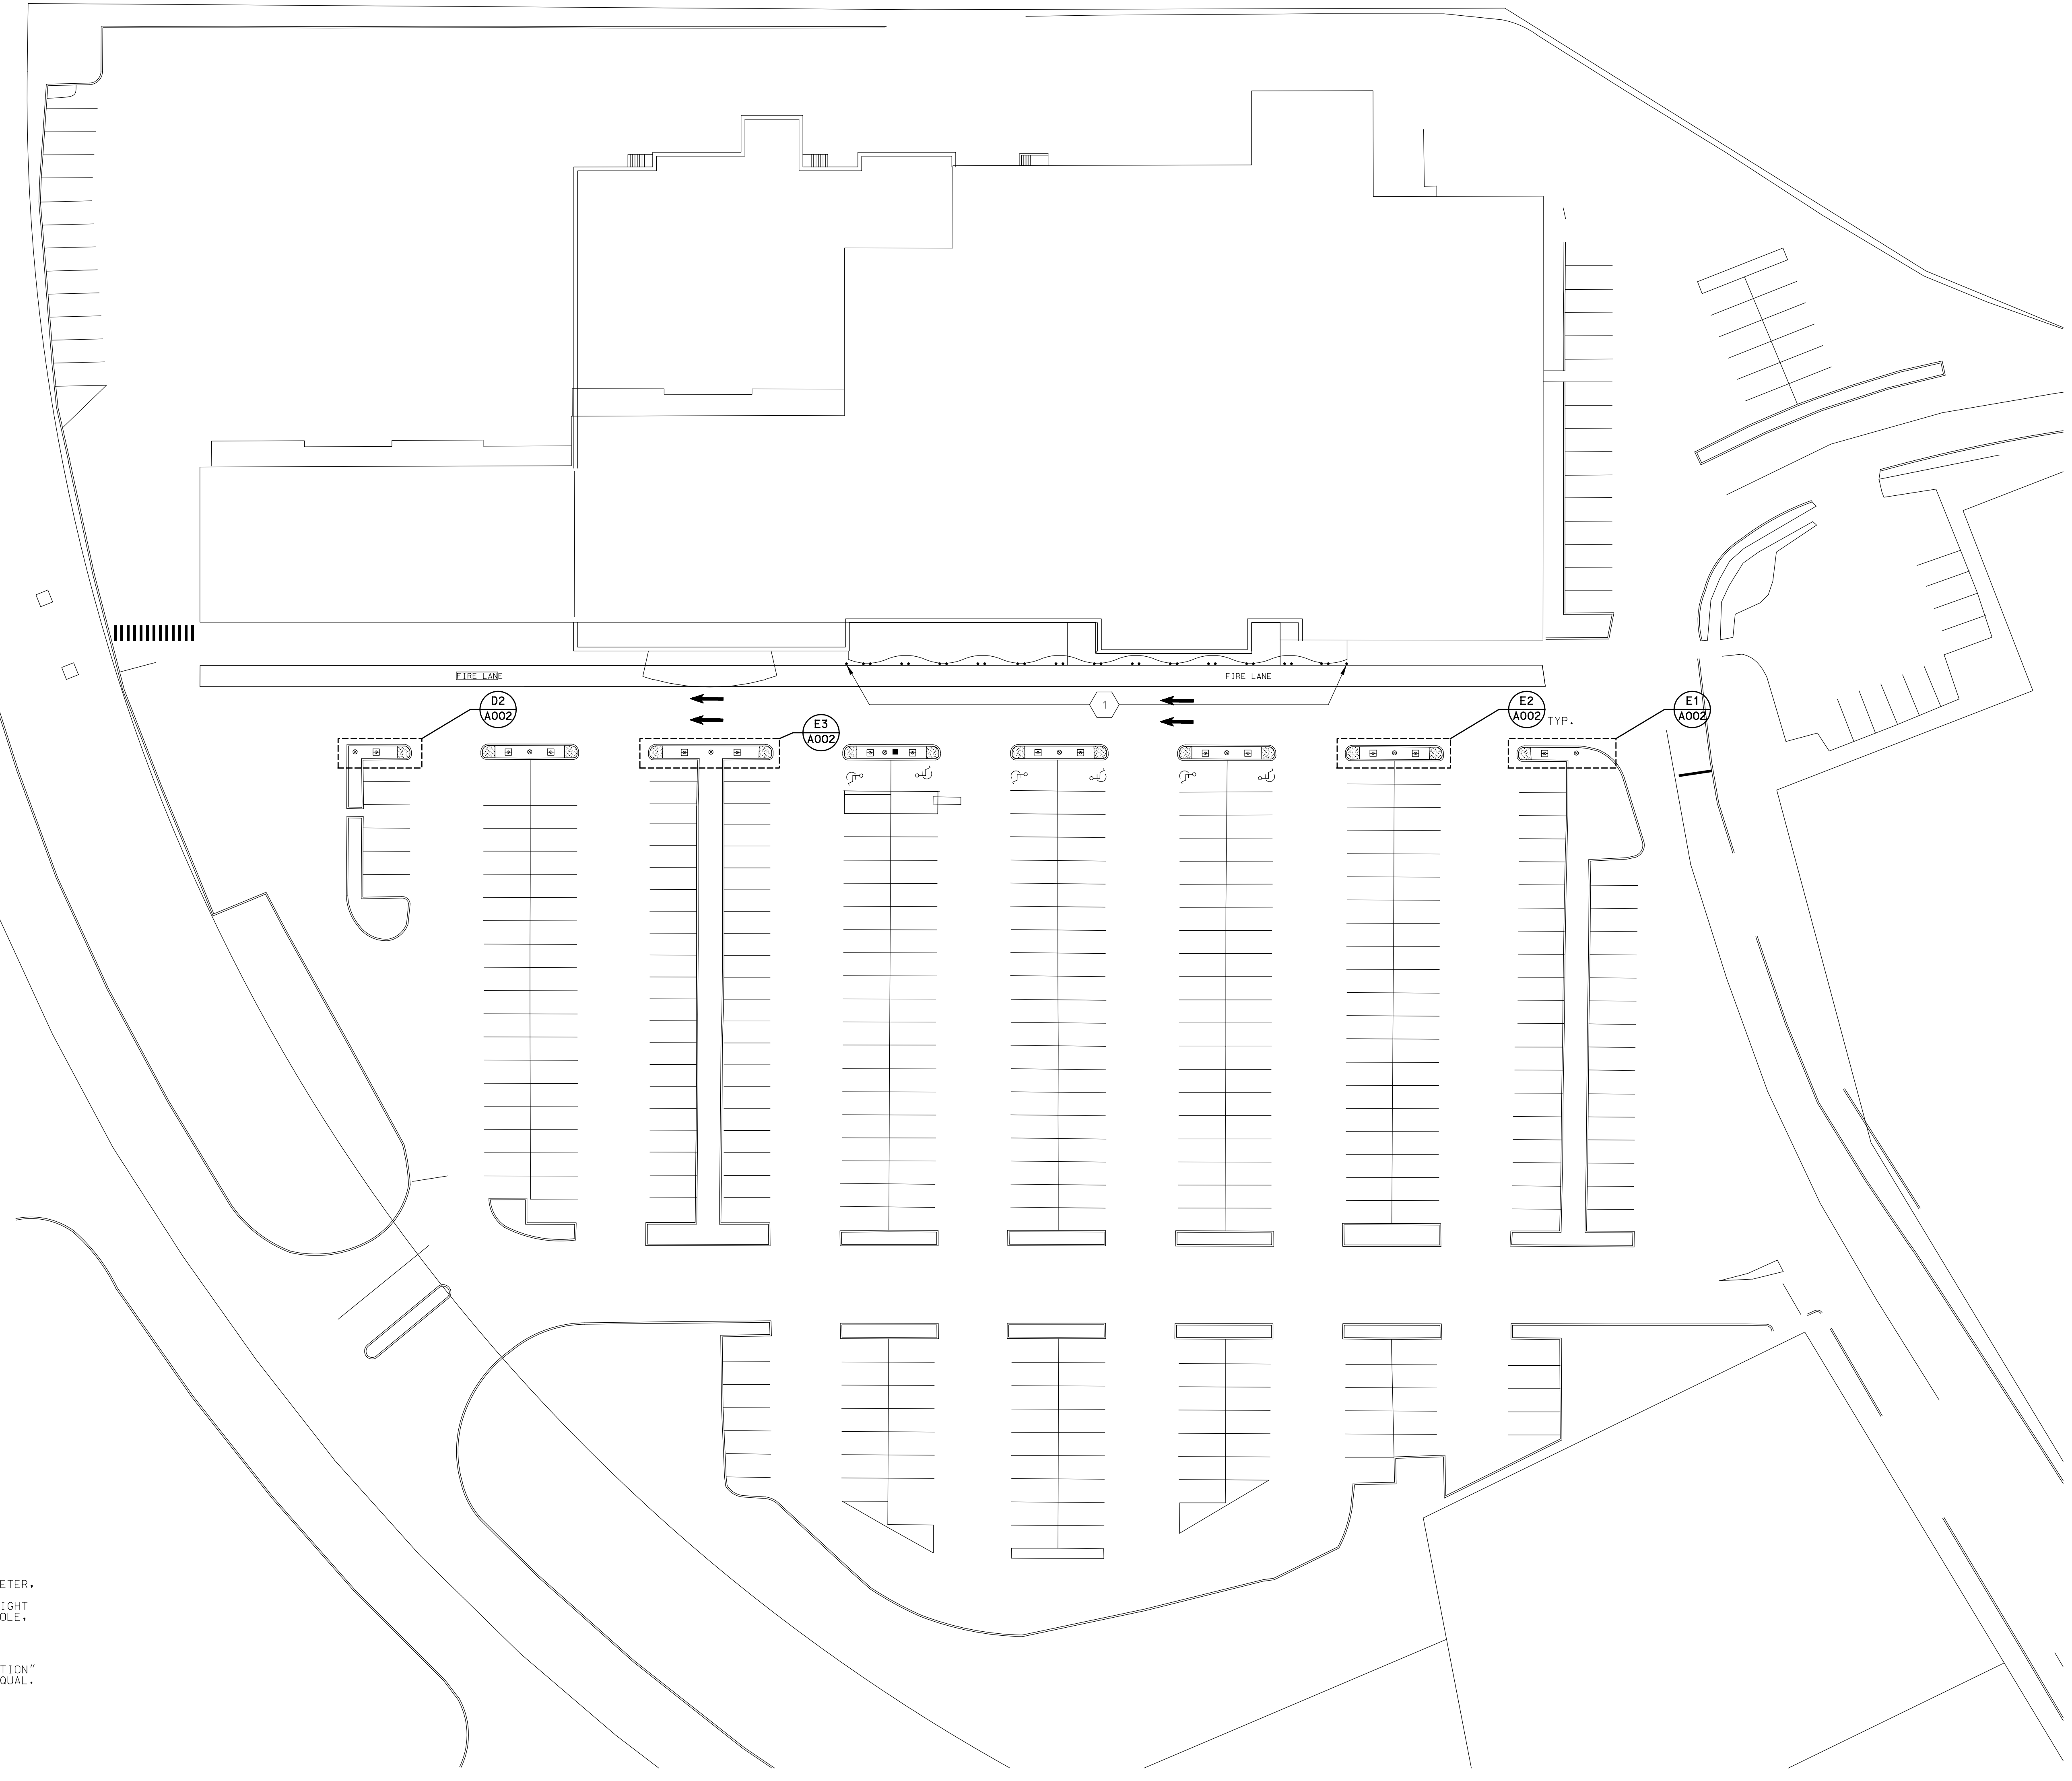


D2 ENLARGED PLAN  
A002 1/4" = 1'-0"

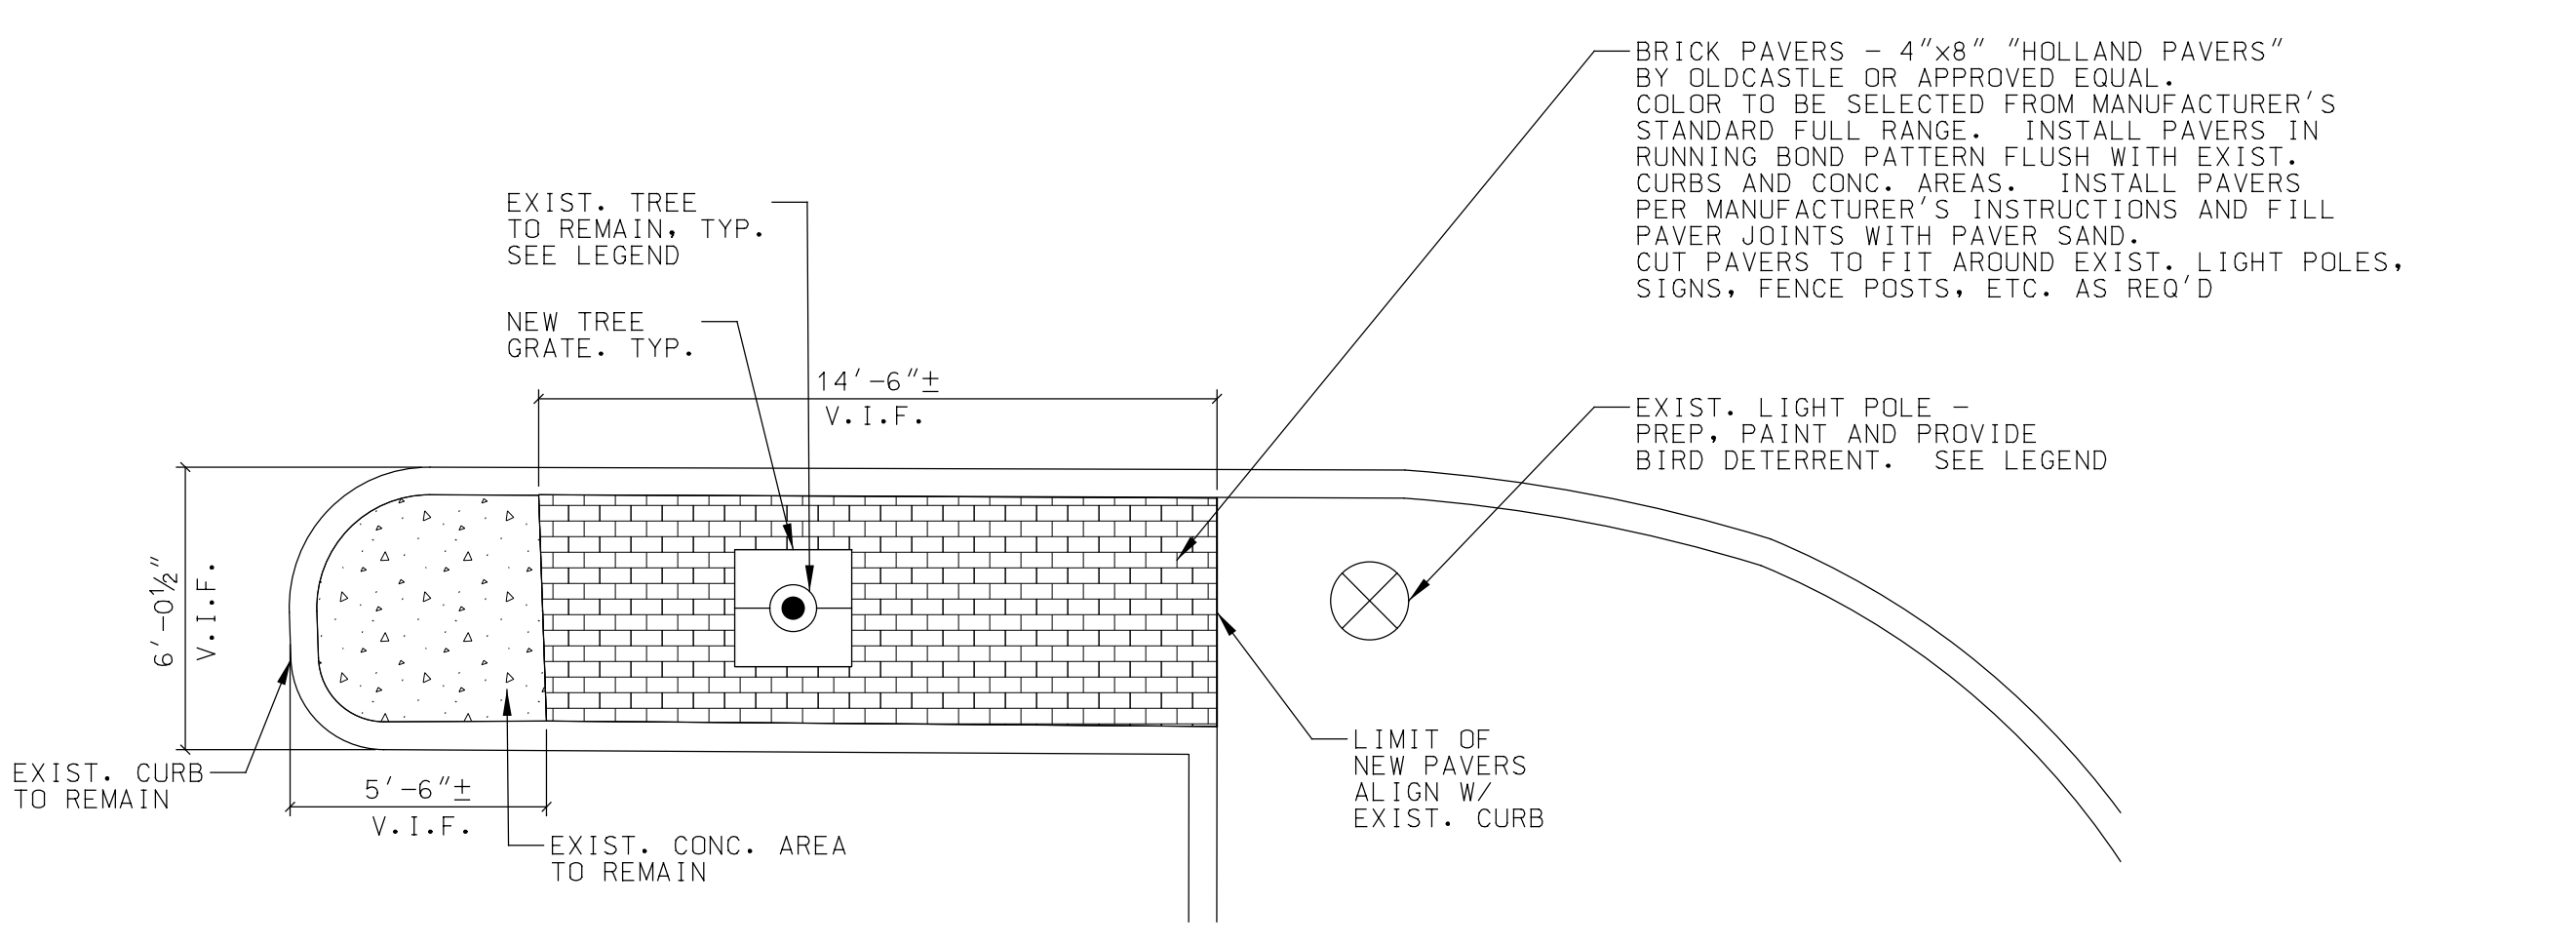

E1 ENLARGED PLAN  
A002 1/4" = 1'-0"

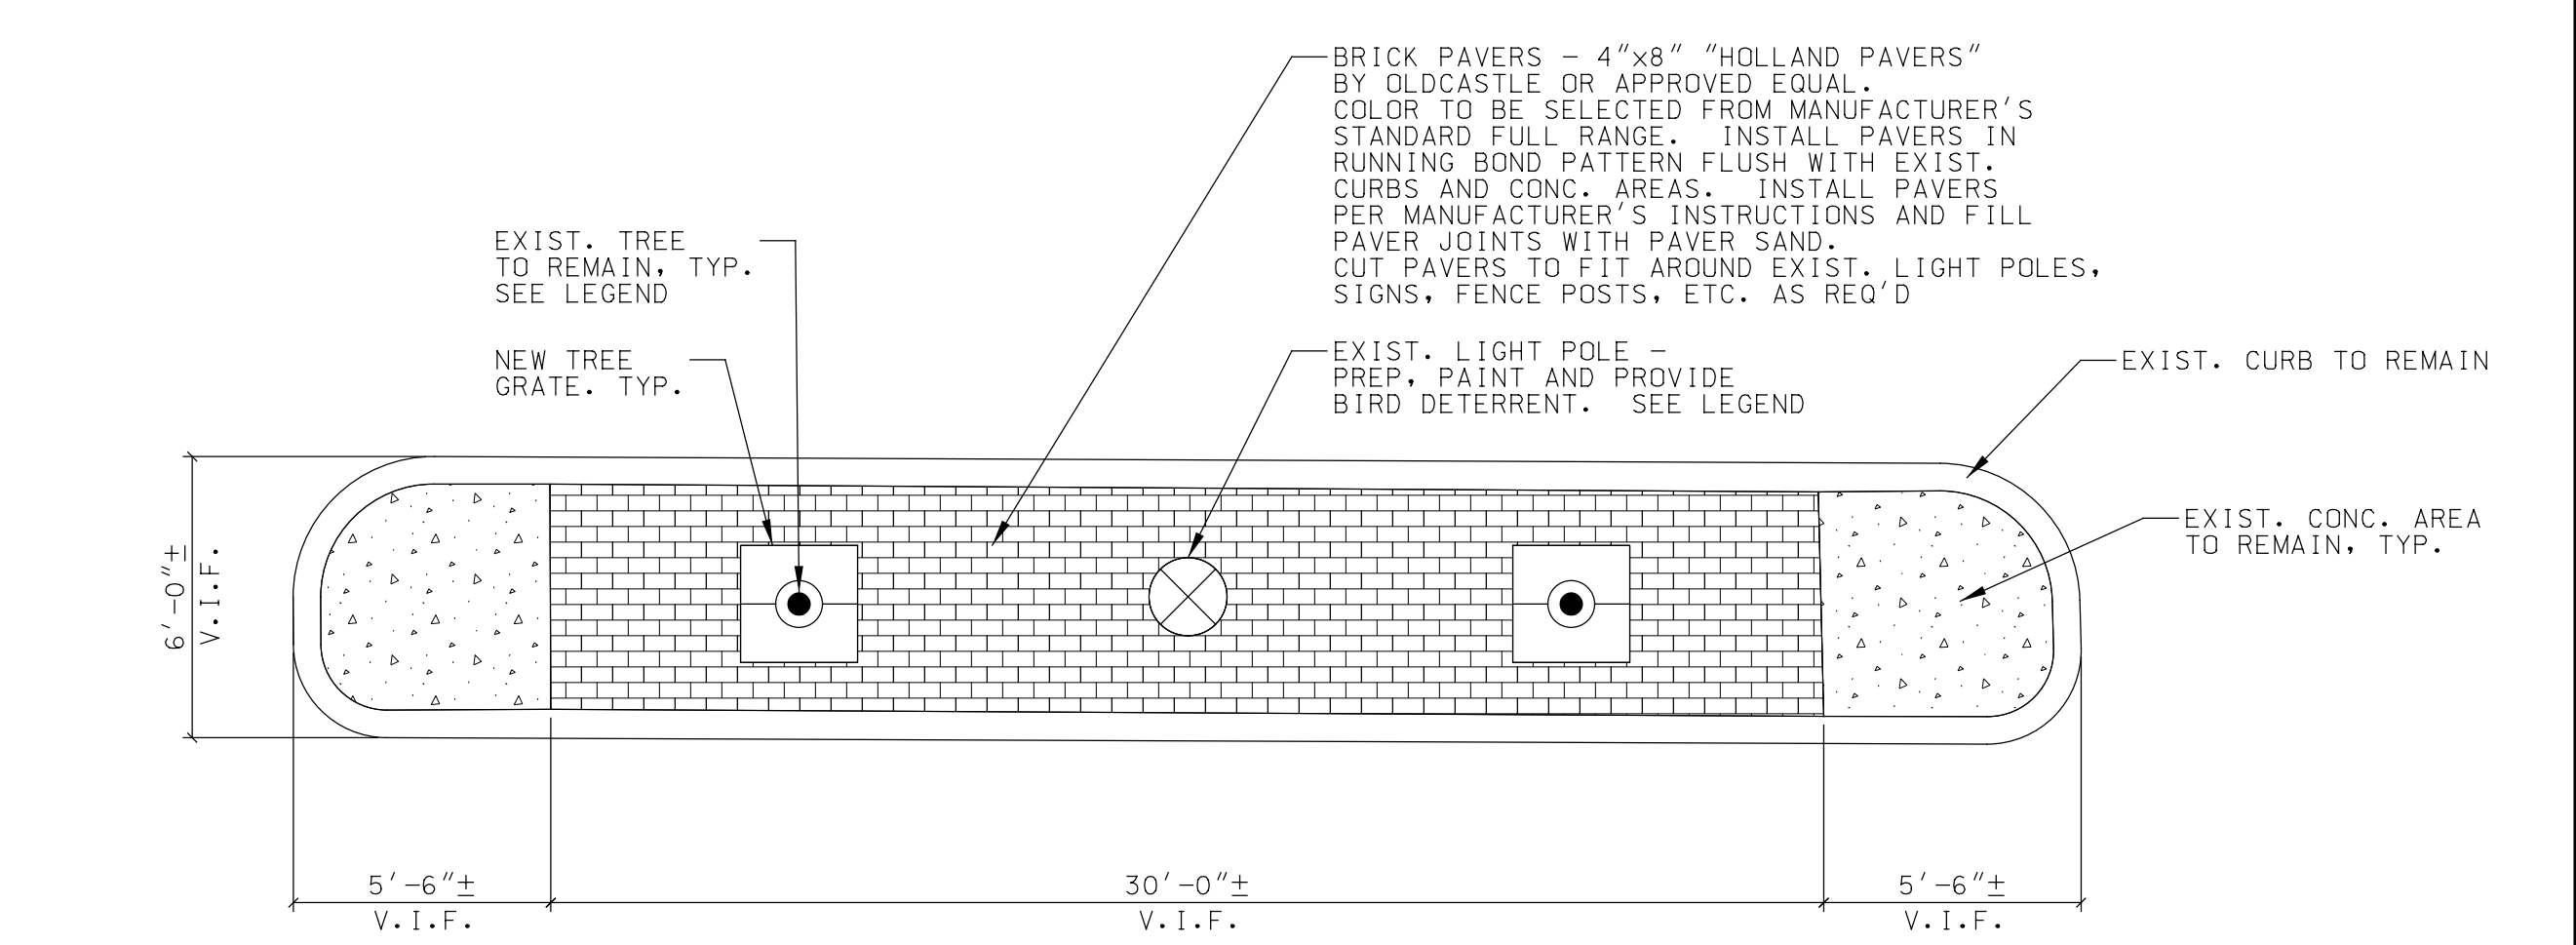

E2 ENLARGED PLAN  
A002 1/4" = 1'-0"

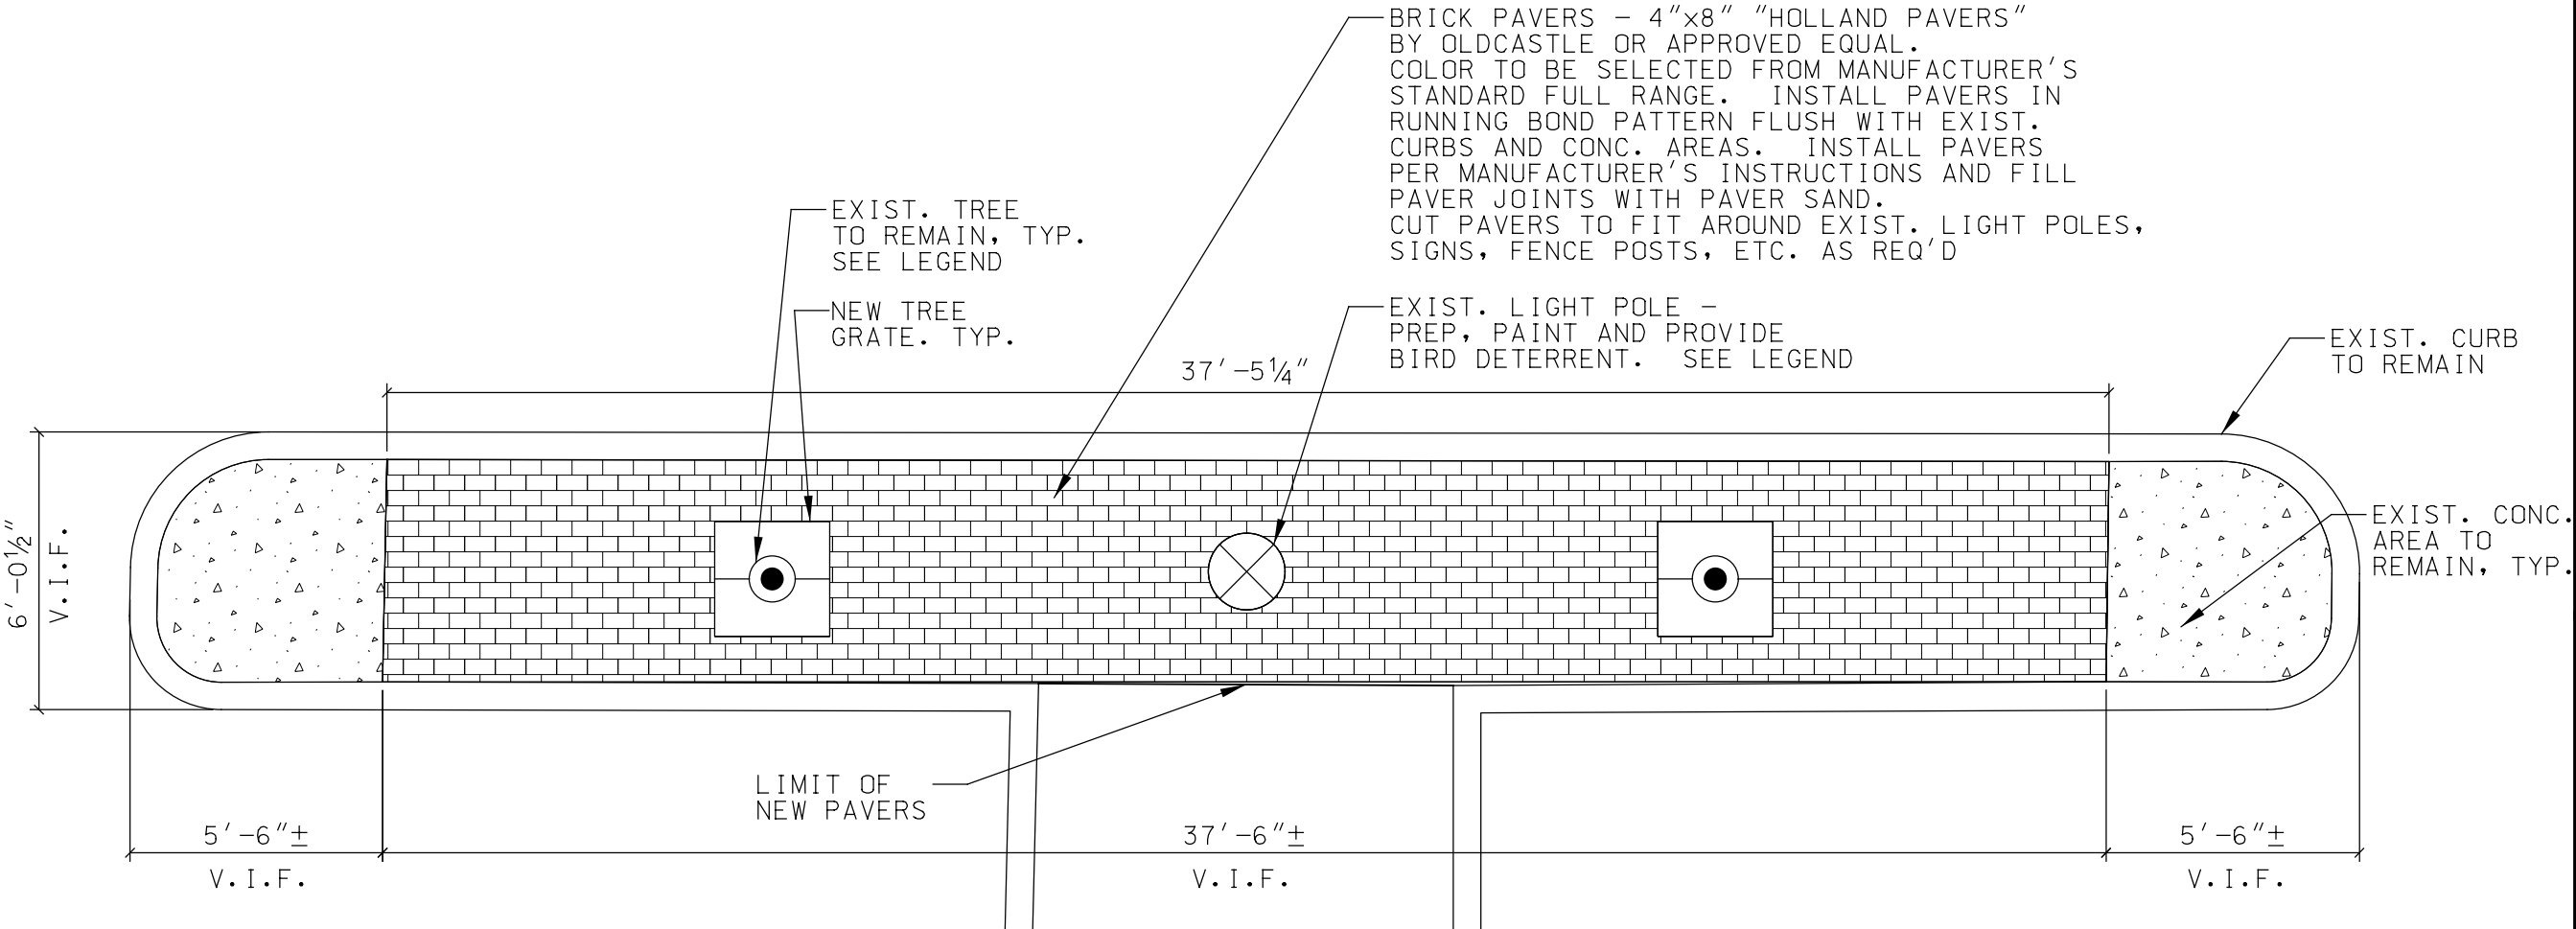

E3 ENLARGED PLAN  
A002 1/4" = 1'-0"

No.	Date	Revision
2	11/18/11	ISSUED FOR CONSTRUCTION
1	10/21/11	ISSUED FOR HANNAFORD 100% REVIEW
0	09/24/11	ISSUED FOR HANNAFORD 60% REVIEW

**REMODEL HANNAFORD  
SUPERMARKET & PHARMACY  
STORE #8351 - 295 FOREST AVENUE  
PORTLAND, MAINE 04101**

**Hannaford Bros. Co.**

**JACOBS**  
JACOBS ENGINEERING GROUP, INC.  
5700 Major Boulevard, Suite 400  
Portland, ME 04103  
Phone: 407-503-5200 Fax: 407-503-5195

Prepared By:

Swat:

ARCHITECT OF RECORD  
NAME: FLOYD W. MCCOLLUM, JR. AIA  
MAINE LICENSED ARCHITECT: 3850

**SITE PLAN AND ENLARGED PLANS**  
Scale: AS NOTED  
Date: 10/21/11

Designed by: S OUELLETTE  
Drawn by: I ESHAK  
Checked by: S OUELLETTE

Drawing No.  
**A002**  
Project No.  
PFR0300  
IBC-PORTLAND, ME