


- CEILING KEY NOTES:
1. PRE FAB CLG - PRE FABRICATED COOLER CEILING
  2. PREP AND PAINT EXISTING WOOD SOFFIT TO MATCH EXISTING
  3. EXISTING CEILING TO REMAIN
  4. NEW CEILING TO MATCH EXISTING
  5. NEW CEILING - SEE CEILING FINISH SCHEDULE FOR TYPE
  6. NEW DECORATIVE ELEMENT - SEE DECOR BOOK
  7. SEE MEZZANINE REFLECTED CEILING PLAN ON THIS SHEET FOR NEW CEILING
  8. EXISTING CEILING TO REMAIN - REPLACE ALL DAMAGED/STAINED CEILING TILES WITH NEW PAINT ALL CEILING TILES, DIFFUSERS AND GRID.
  9. EXISTING CEILING TO REMAIN - CLEAN AND PAINT WITH EPOXY PAINT.

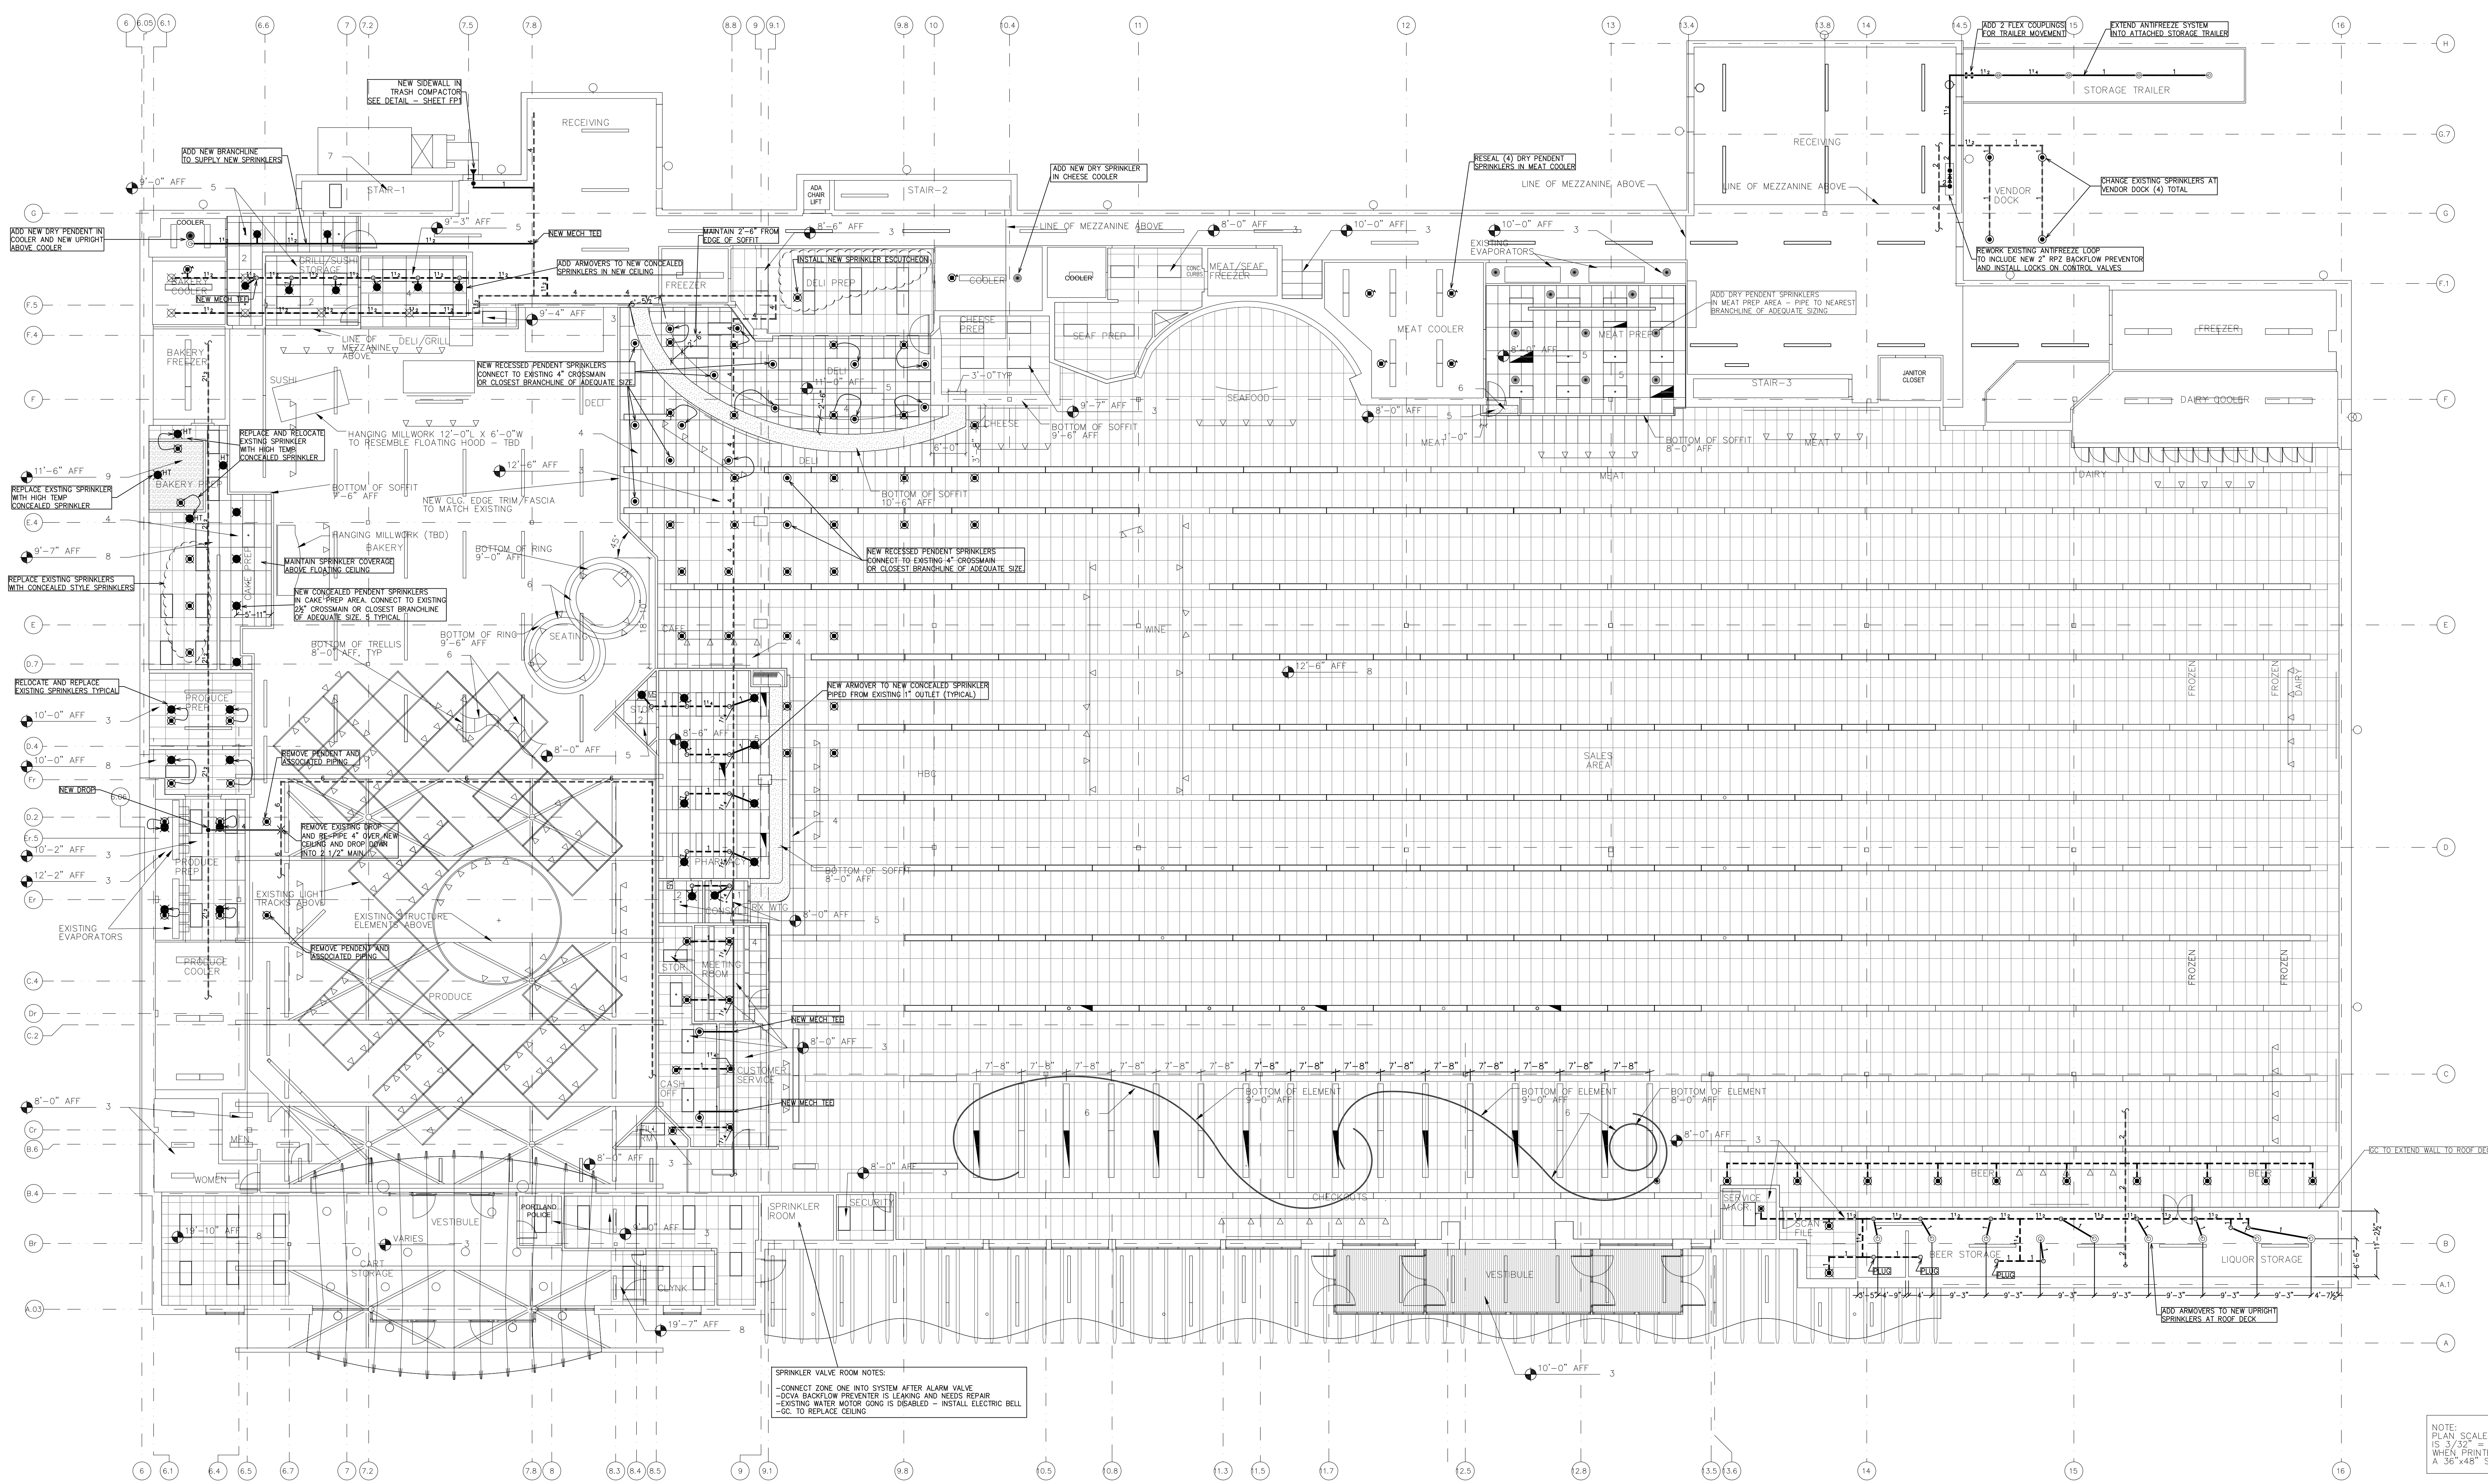

REVISIONS

NO.	DATE	DESCRIPTION
1	11/18/11	ISSUED FOR CONSTRUCTION



SPRINKLER DATA

SYMBOL	TYPE	NEW BRASS	NEW RECESSED
UPRIGRIT	PENDENT	1/2"	1/2"
N.P.T.		5.6K	5.6K
K FACTOR		155*	155*
TEMP. RATING		155*	155*
MODEL NO.			
QUANTITY		17	24

SYMBOL	TYPE	EXISTING BRASS	EXISTING
UPRIGRIT	PENDENT	1/2"	1/2"
N.P.T.		5.6K	5.6K
K FACTOR		155*	155*
TEMP. RATING		155*	155*
MODEL NO.			
QUANTITY			

SYMBOL	TYPE	EXISTING DRY	NEW DRY
UPRIGRIT	PENDENT	1"	1"
N.P.T.		5.6K	5.6K
K FACTOR		155*	155*
TEMP. RATING		155*	155*
MODEL NO.			
QUANTITY			13

SYMBOL	TYPE	NEW CONCEALED	NEW DRY
UPRIGRIT	PENDENT	1/2"	1"
N.P.T.		5.6K	5.6K
K FACTOR		155*	155*
TEMP. RATING		155*	155*
MODEL NO.			
QUANTITY		35	7


NOTE: THE TEMPERATURE RATING AND RESPONSE TYPE OF NEW SPRINKLERS ARE TO MATCH EXISTING SPRINKLER TEMPERATURE RATINGS AND RESPONSE TYPE WITHIN THE SAME COMPARTMENT.

SPRINKLER TOTAL 90 NEW

NOTE:

THE SOLE PURPOSE OF THESE DRAWINGS ARE TO DEFINE THE SCOPE OF WORK. THE DRAWINGS DEPICT WORK REQUIRED AS PART OF CURRENT STORE RENOVATIONS. THE DRAWINGS ALSO SHOW SYSTEM UPGRADES TO MEET REQUIREMENTS OF HANNAFORD AND NFPA PAMPHLET 13. THE INSTALLING CONTRACTOR SHALL VISIT THE SITE AND PRODUCE THEIR OWN DESIGN DRAWINGS FOR SUBMITTAL.

PITTS-MILLIGAN GROUP LLC  
-DESIGN DIVISION-  
NAPLES, MR - JUPITER, FL  
781-461-5613

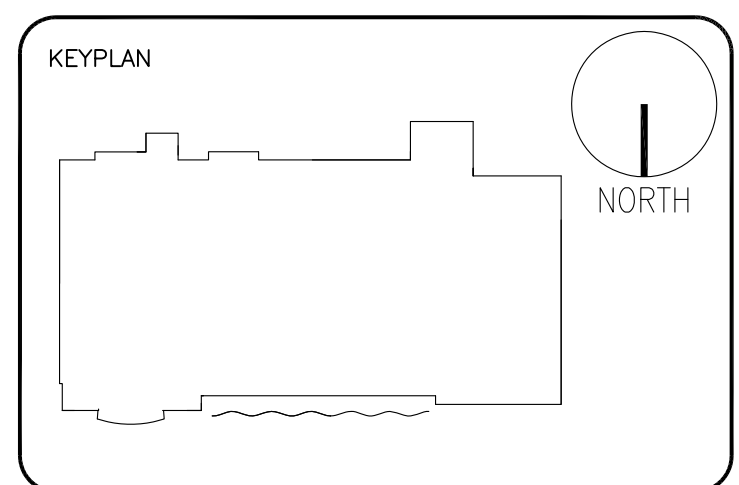

P.E.

HANNAFORD STORE #8279  
295 FORREST AVE  
PORTLAND, ME. 04101

SPRINKLER PIPING PLAN

APPROVAL	LOCAL FIRE DEPT
DRAWN BY	KPL
SCALE	AS NOTED
DATE	11-18-11
REV DATE	----

FP 2 of 2