


D9412GV3 Control **BOSCH®**

LEGEND

- *P* Denotes "POPIT" with Device
- 1257 ANNUNCIATOR PANEL - 60" A.F.F.
- 1256 FIRE ANNUNCIATION
- F PULL STATION
- P SMOKE (PHOTOELECTRIC HEAD)
- H HEAT
- A ANSUL SYSTEM CONTACT
- GV GATE VALVE
- WF WATER FLOW
- SV SUPERVISORY SWITCH
- LT ROOM LOW TEMPERATURE SENSOR
- P DUCT SMOKE (PHOTOELECTRIC HEAD)

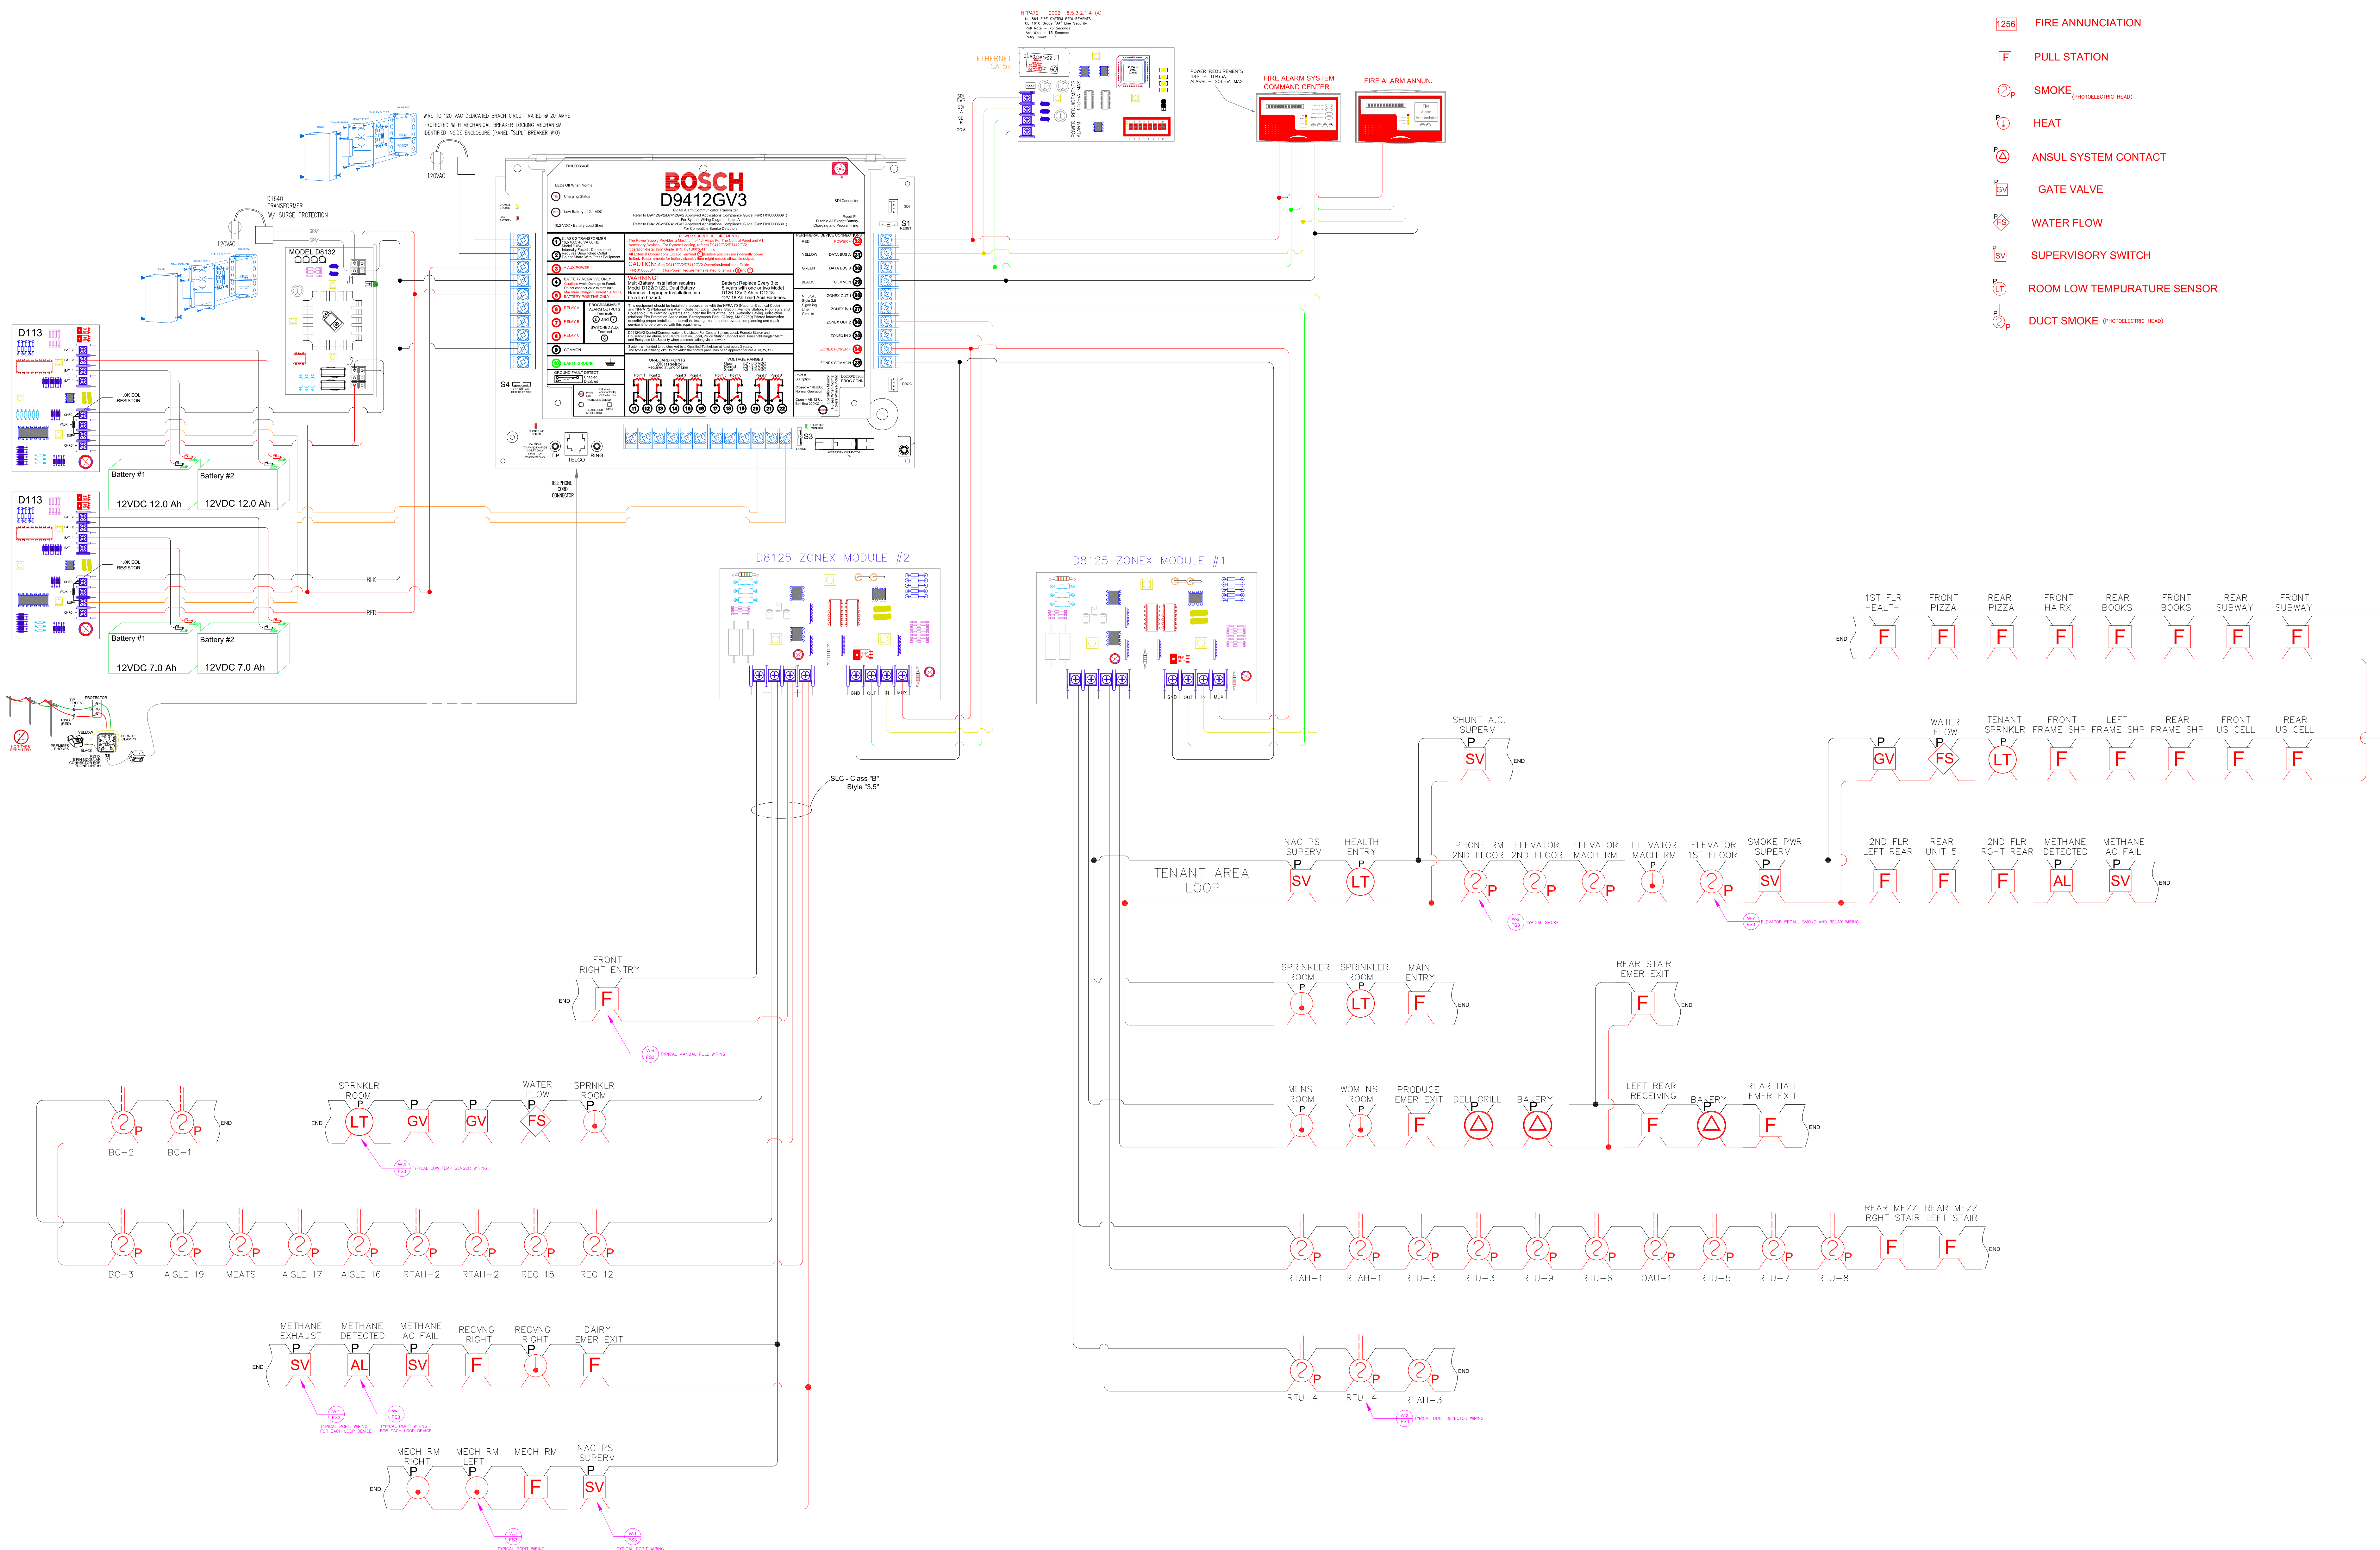

John Kimball NICEET Certified Senior Engineering Technician
Surveillance Specialist, Ltd.
 Portland, ME Office
 4 Thomas Drive
 Portland, ME 04102
 Tel: 603-883-5428
 Fax: 603-883-5426
 In State: 207-852-4022
 In State: 207-852-4444
NICEET
 NICEET is a registered trademark of the National Institute for Certification in Engineering Technologies (NICET).

REVISIONS	BY	DATE
1	JK	11/18/2011
2	JK	11/18/2011

PROJECT TITLE
HANNAFORD SUPERMARKET & PHARMACY #8351
 FOREST AVENUE
 PORTLAND, MAINE
HANNAFORD BROS. CO.
 ENGINEERING DEPT.
 STORE PLANNING

SCALE NTS
 REDRAWN JK-SURV
 DATE 11/18/2011
 © 2009 HANNAFORD BROS. CO.

SHEET TITLE
FIRE ALARM RISER INITIATION
 SHEET NUMBER
FS-4

