


- LEGEND**
- AF-F ABOVE FRESH FLOOR
 - BC-F BLOWER COIL AIR HANDLER (UNIT TAG)
 - B.O.D. BOTTOM OF DUCT (ELEVATION ABOVE FINISH FLOOR)
 - B.O.G. BOTTOM OF GRILLE (ELEVATION ABOVE FINISH FLOOR)
 - C.D.M. CEILING DIFFUSER (UNIT TAG)
 - C.F.M. CUBIC FEET PER MINUTE
 - CU-F CONDENSING UNIT (UNIT TAG)
 - DA-C DUCTLESS AIR CONDITIONER
 - DN DOWN
 - DN EXTERIOR
 - EF EXHAUST GRILLE (UNIT TAG)
 - EF-F EXHAUST FAN (UNIT TAG)
 - FC FLEXIBLE CONNECTOR
 - HOOD HOOD (UNIT TAG)
 - NEW NEW
 - OPEN EXIST DUCT
 - RETUR RETURN GRILLE (UNIT TAG)
 - ROOF TOP AIR HANDLER (UNIT TAG)
 - FRONT-F MANUAL VOLUME DAMPER W/ LOCKING QUADRANT
 - VO WITH
 - W.M.S. WIRE MESH SCREEN
- MITERED ELBOW W/ SINGLE TURN TURNS
 - RECTANGULAR (OR SQUARE) TO ROUND TRANSITION
 - MANUAL VOLUME DAMPER W/ LOCKING QUADRANT
 - DUCT SMOKE DETECTOR W/ SAMPLE AND EXHAUST TUBES
 - TEMPERATURE SENSOR BY AUTOMATIC TEMPERATURE CONTROLS CONTRACTOR
 - HUMIDITY SENSOR BY AUTOMATIC TEMPERATURE CONTROLS CONTRACTOR

NOTES

1. NEW REAS 1 AND 2 TO REUSE EXISTING TEMPERATURE/HUMIDITY CONTROLS.

No.	Date	Revision
2	11/19/11	ISSUED FOR CONSTRUCTION
1	10/21/11	ISSUED FOR HANNAFORD 100% REVIEW
0	09/26/11	ISSUED FOR HANNAFORD 100% REVIEW

REMODEL HANNAFORD SUPERMARKET & PHARMACY
 STORE #8351 - 295 FOREST AVENUE
 PORTLAND, MAINE 04101

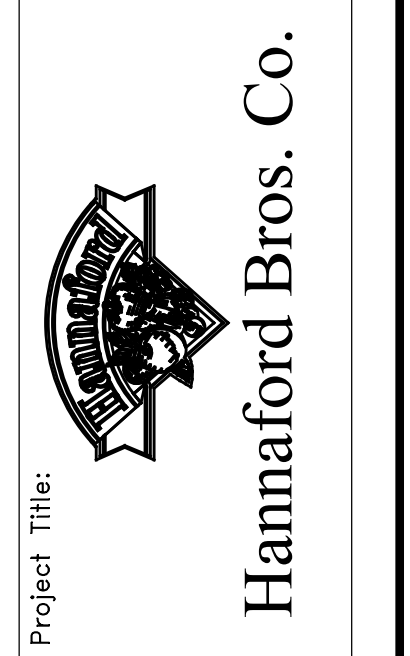

JACOBS
 JACOBS ENGINEERING GROUP, INC. 04-091808
 5700 Major Boulevard, Suite 400
 Columbia, Maryland, 21046
 Phone: 410-303-2000 Fax: 410-303-2195

Prepared By: _____
 Swat: _____
 MECHANICAL ENGINEER OF RECORD
 NAME: KEVIN EUGA, P.E.
 MAINE REGISTERED P.E. 12608

MECHANICAL PLAN
 Scale: 3/32" = 1'-0"
 Date: 10/21/11
 Designed by: K EUGA
 Drawn by: K EUGA
 Checked by: K EUGA

Drawing No. **M101**
 Project No. **FRYR0300**
 IBC-PORTLAND, ME

