




PLUMBING FIXTURE SCHEDULE										
TAG	TYPE	LOCATION	SAN WASTE	EW FEED	HW FEED	TW FEED	VENT	MFR	MODEL NO.	REMARKS
SK-D	HANDSINK	CAFE	1 1/2"	1/2"	1/2"	-	1 1/2"	AERO	HSB	110° HOT WATER WITH TV-2
SK-DE	HANDSINK W/ EW BRACKET	DELI	1 1/2"	1/2"	1/2"	-	1 1/2"	AERO	HSB W/ EW BRACKET	110° HOT WATER WITH TV-2
SK-F	SINK	PHARMACY	2"	1/2"	1/2"	-	1 1/2"	ELKAY	LRAD-1716	110° HOT WATER WITH TV-2
LAV-A	LAV SINK	MEZZANINE RESTROOM	1 1/2"	-	1/2"	-	1 1/2"	SEE ARCH'S SPECIFICATION	SEE ARCH'S SPECIFICATION	PROVIDE DRAIN WITH OVERFLOW, OFFSET TAILPIECE AND TRAP; PROVIDE SPECIFIED FAUCET FITTING
WC-1	WATER CLOSET	MEZZANINE RESTROOM	3"	1/4"	-	-	2"	AMERICAN STANDARD	MADERA 3451.128	
WC-2	WATER CLOSET	MEZZANINE RESTROOM	3"	1/4"	-	-	2"	AMERICAN STANDARD	MADERA 3461.128	ADA COMPLIANT
UR-1	URINAL	MEZZANINE RESTROOM	2"	1"	-	-	1 1/2"	SLOAN	WEUS 1002.1301-0.025	
EW-1	EYE WASH	ALL SK-DE'S, PHARMACY SINK	-	1/2"	-	3/8"	-	GUARDIAN EQUIPMENT	G5022BP	INTEGRAL BACK FLOW PREVENTER
TV-1	TEMP. VALVE	EYEWASH STATIONS	-	1/2"	1/2"	1/2"	-	LEONARD	MODEL TA-300	OUTLET 85° TEMPERED WATER
TV-2	TEMP. VALVE	HAND SINKS, LAVS	-	3/4"	3/4"	3/4"	-	LEONARD	TM-28-E-RF	OUTLET 110° WATER
HWHB-1	HOT WATER HOSE BIBB	REFRIGERATED CASE WASH-DOWN	-	-	3/4"	-	-	WOODFORDS	74	140° HOT WATER CONNECTION

NOTES:  
 1. REFER TO SPEC SECTION 224000 FOR LIST OF ACCEPTABLE ALTERNATIVES.  
 2. FIXTURE SUPPLY AND VENT CONNECTIONS ARE AS SHOWN IN SCHEDULE UNLESS OTHERWISE NOTED.  
 3. VENT SIZE IS SPECIFIED FOR SINK FIXTURE ONLY.  
 4. CONTRACTOR TO VERIFY NUMBER OF FIXTURES AND TYPE WITH FIXTURE PLAN (44-1)

DOMESTIC WATER HEATER SCHEDULE										
TAG	MFR	MODEL	STORAGE (GALLONS)	WATER TEMPERATURE (°F)	RECOVERY RATE (GPM)	FUEL	ELECTRICAL	WEIGHT (LBS)	NOTES	
	A.O.						JW	V/PH		
DWH-2	A.O. SMITH	BTH 300	130	100°	349	NATURAL GAS	N/A	N/A	1,895	

FLOOR DRAIN SCHEDULE	
TAG	MFR. & MODEL
FD-F	ZURN Z-1750-YS-3

NOTE: TOP OF ALL DRAINS AT 100'-0" (FIN. FLR) UNLESS ELEVATION NOTED ON STUBUP TAG

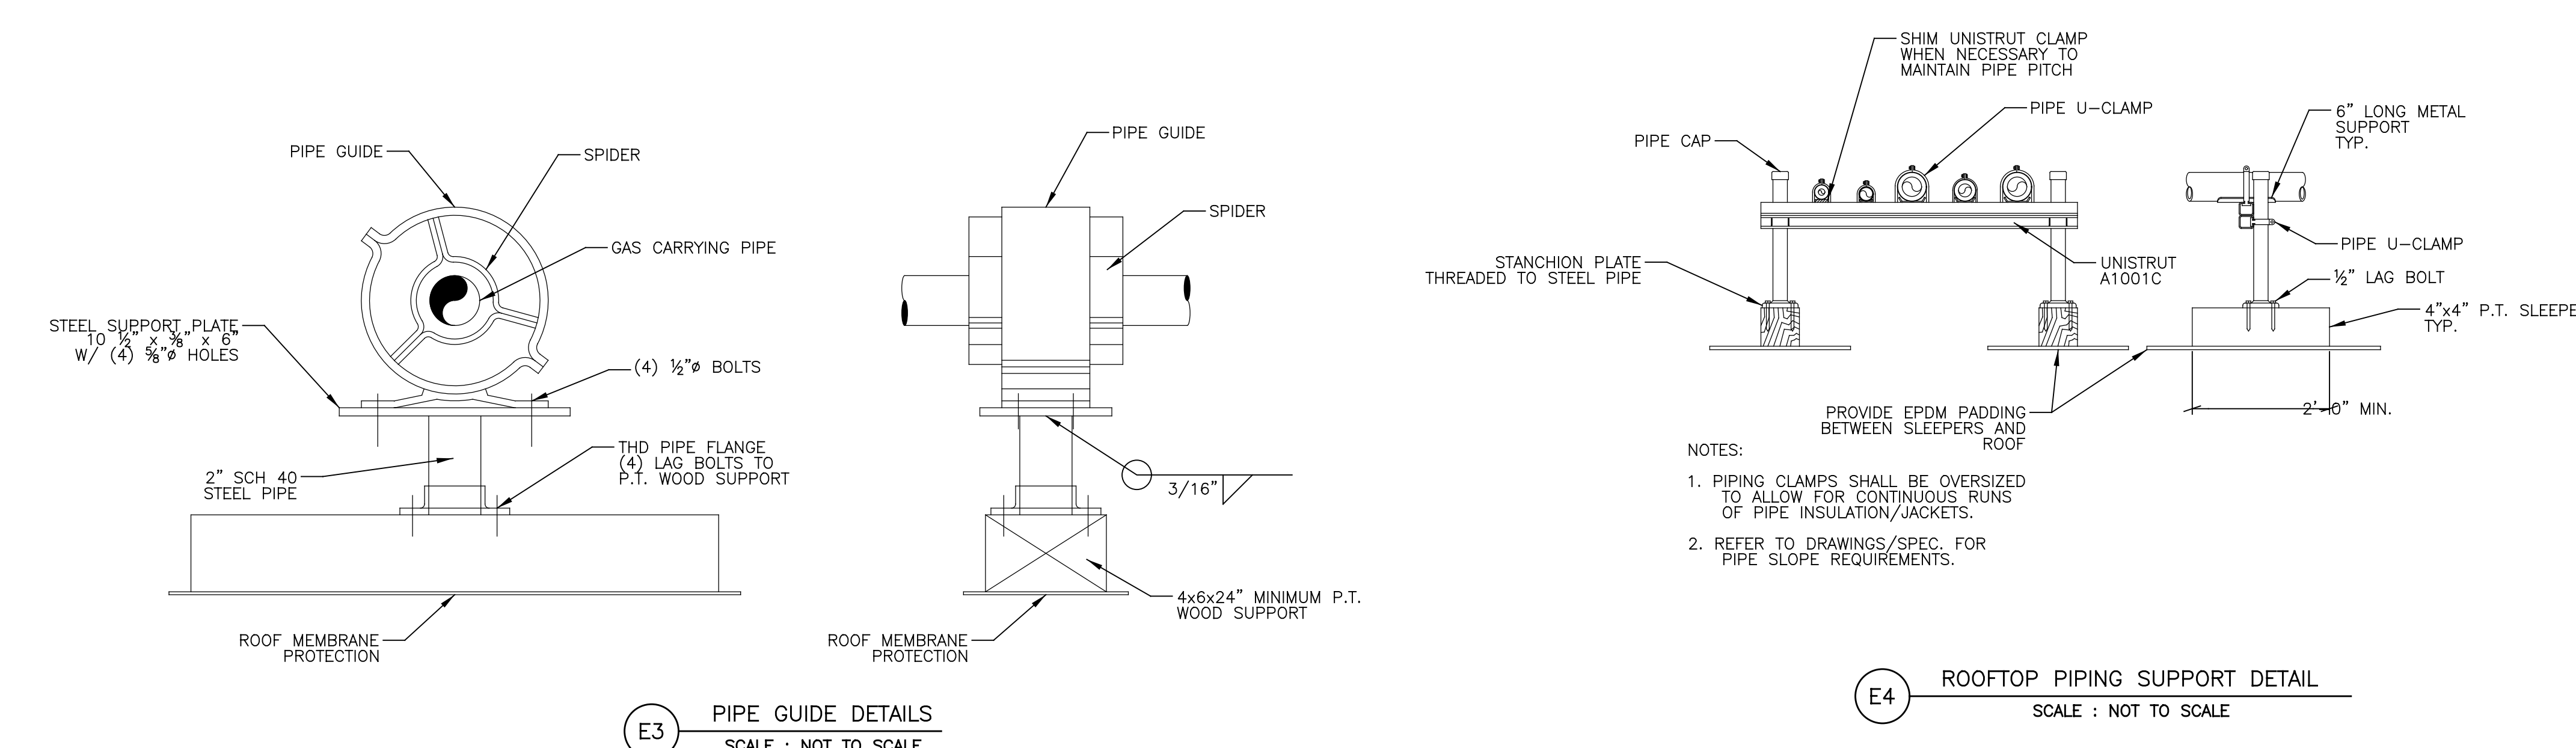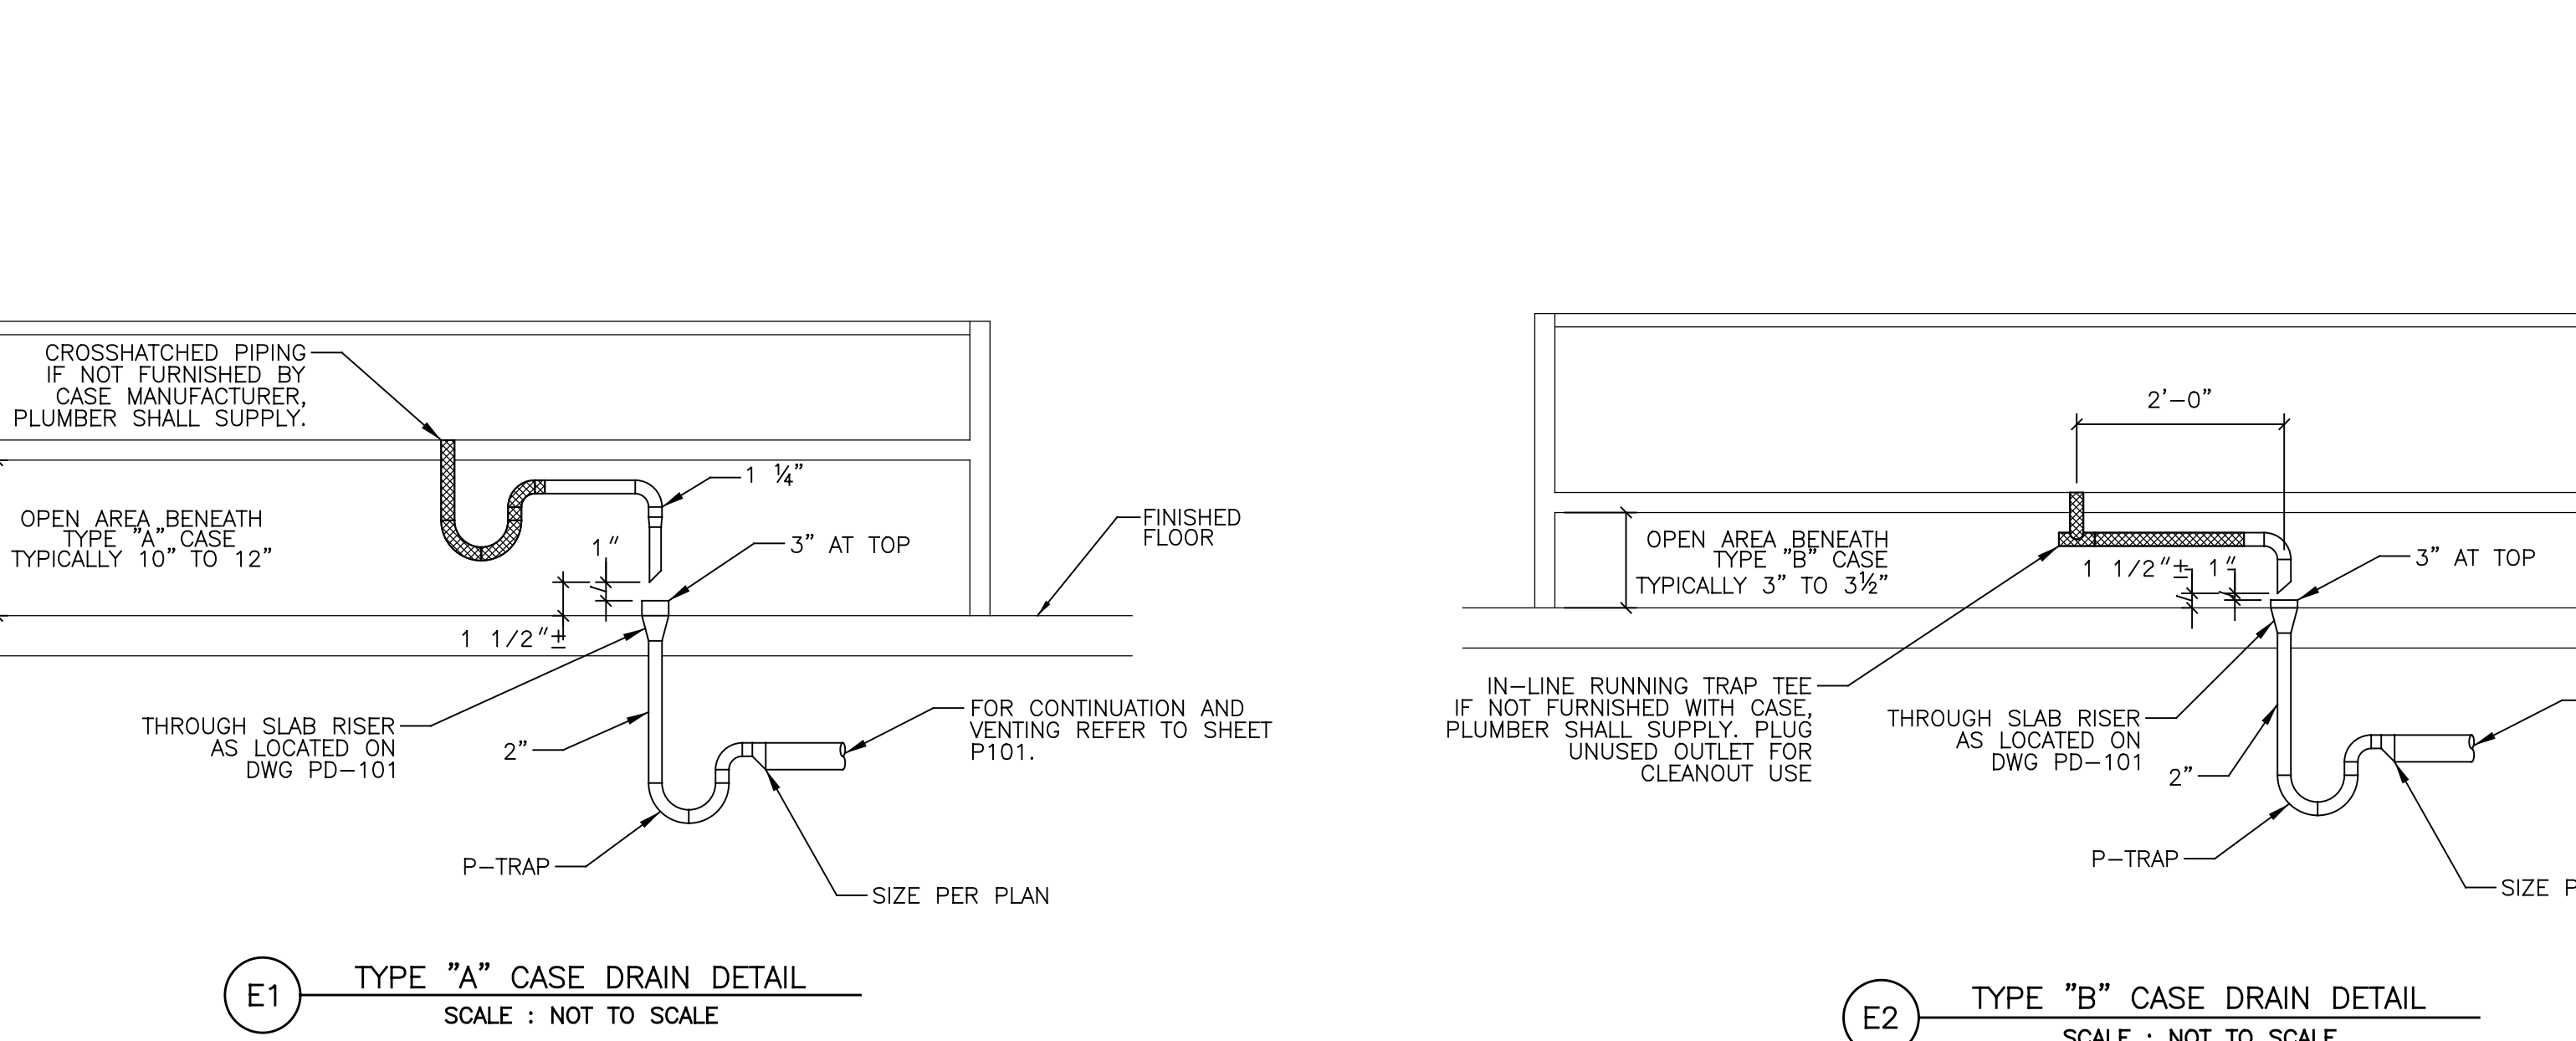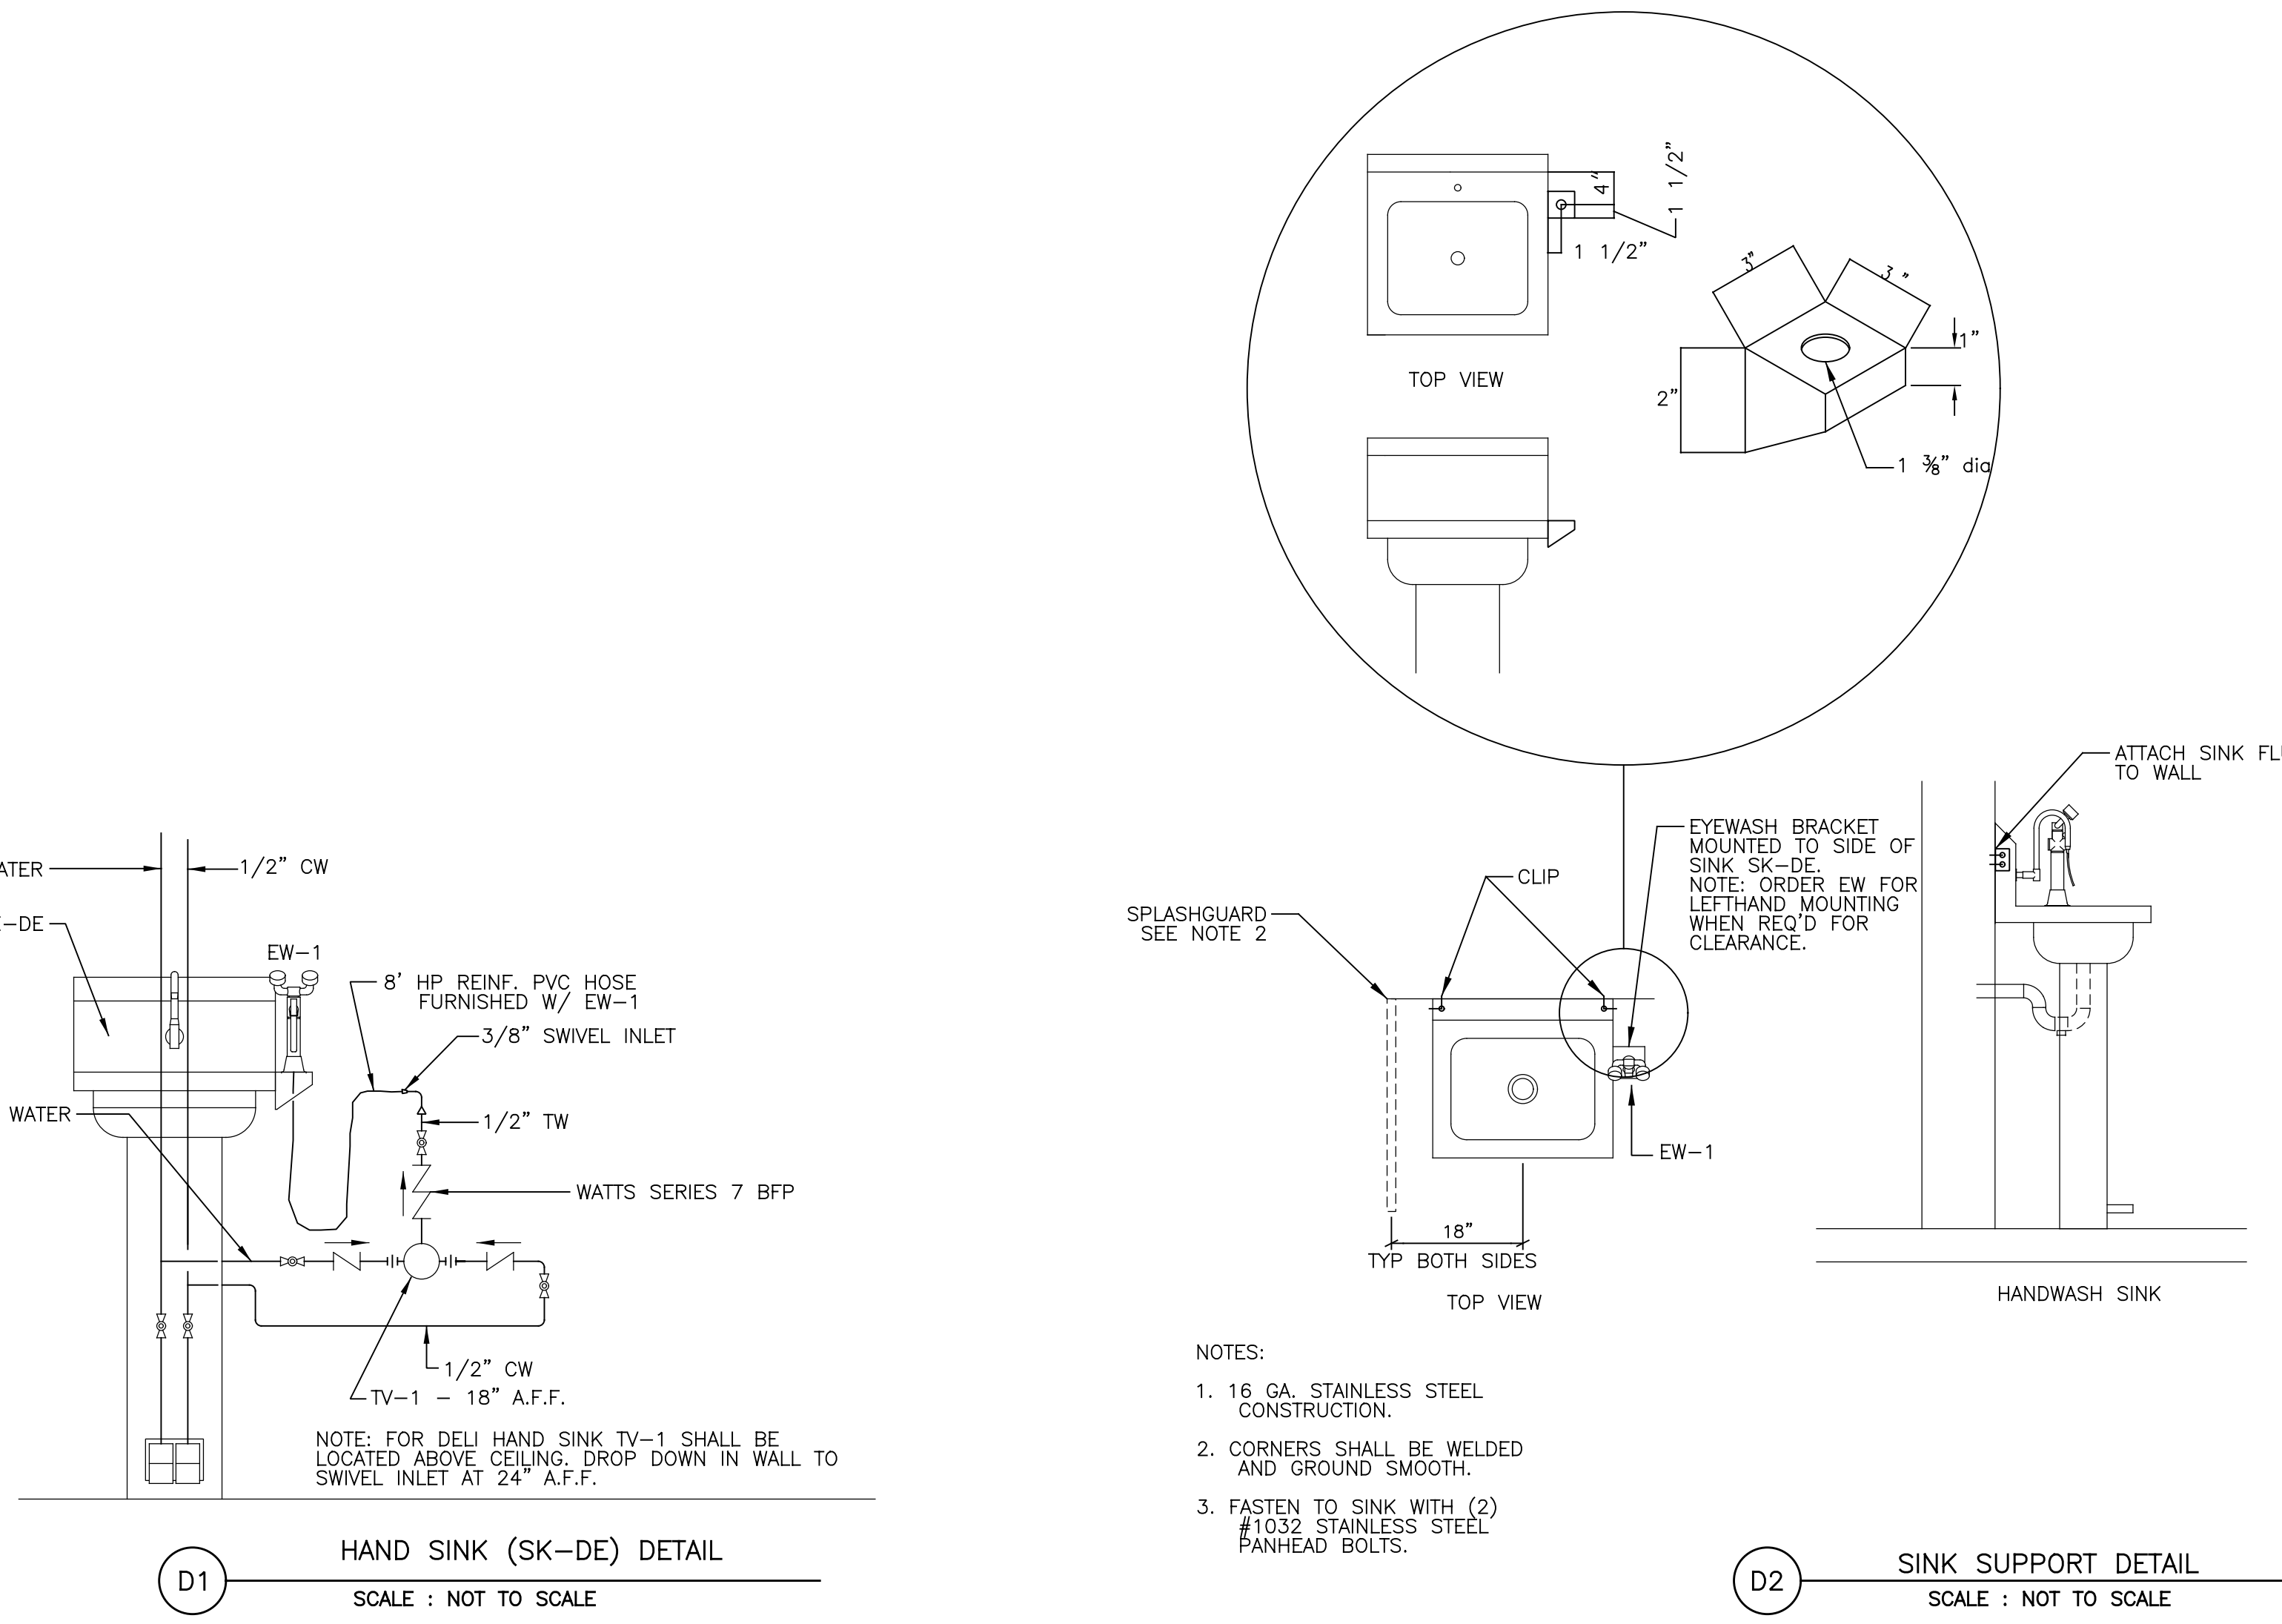

PLUMBING LEGEND			
AFF/A.F.F.	ABOVE FINISHED FLOOR	G	GAS
AD	ACCESS DOOR	HWHB	HOT WATER HOSE BIBB
AP	ACCESS PANEL	INV	PIPE INVERT ELEVATION
BFP	BACKFLOW PREVENTER	LAV	LAVATORY
BWV	BACKWATER VALVE	LP	LIQUID PETROLEUM
CD	CLEANOUT	NTS/N.T.S.	NOT TO SCALE
COND	CONDENSATE	OD	OUTSIDE DIAMETER
CJ	COPPER	PRV	PRESSURE REDUCING VALVE
CW	COLD WATER	PVC	POLYVINYL CHLORIDE PIPE
CWV	COMBINATION WASTE VENT	RD	ROOF DRAIN
DIW	DOWN IN WALL	S	SANITARY
DN	DOWN	SV	SANITARY VENT
DWH	DOMESTIC WATER HEATER	SK	SINK
DET	DOMESTIC EXPANSION TANK	T/G	TOP OF FLOOR DRAIN GRATE, ELEVATION
EQUIP	EQUIPMENT	T&P	TEMPERATURE & PRESSURE
EW	EYE WASH	TV	TEMPERING VALVE
EWC	ELECTRIC WATER COOLER	TW	TEMPERED WATER
FCO	FLOOR CLEANOUT	TEMP	TEMPERATURE
FDC	FIRE DEPARTMENT CONNECTION	TYP	TYPICAL
FD	FLOOR DRAIN	UR	URINAL
FLR	FLOOR	V	VENT
FT	FOOT	VTR	VENT TO ROOF
GW	GREASE WASTE	W	WASTE
GWV	GREASE WASTE VENT	WC	WATER CLOSET
HW	HOT WATER	WCO	WALL CLEANOUT
HWR	HOT WATER RETURN		

Project Title: REMODEL HANNAFORD SUPERMARKET & PHARMACY STORE #8351 - 295 FOREST AVENUE PORTLAND, MAINE 04101

Prepared By: JACOBS ENGINEERING GROUP, INC. 3400 MAINE AVENUE PORTLAND, ME 04106-1100  
 Phone: 407-505-5000 Fax: 407-505-5199

Scale: NTS Date: 10/21/11

Designed by: J. STAMPER  
 Drawn by: J. STAMPER  
 Checked by: K. EUGA

Drawing No. P601  
 Project No. PFR0300