

PIPE SLOPE, ARROW INDICATES DIRECTION, TEXT INDICATES SLOPE RATE




REFERENCE COLUMN DESIGNATION & COORDINATE ORIENTATION

OFFSET DIMENSION TAG, REFERENCED TO COLUMN & DIRECTION

DISTANCE, IN FEET AND INCHES
DIRECTION (NORTH (N), EAST (E), SOUTH (S), WEST (W))
REFERENCED COLUMN I.D.

- LEGEND**
- S SANITARY PIPING BELOW GRADE
 - IW INDIRECT WASTE PIPING BELOW GRADE
 - GW GREASE WASTE PIPING BELOW GRADE
 - CWV COMBINATION WASTE AND VENT PIPING BELOW GRADE
 - RW RAIN WATER LEADER PIPING BELOW GRADE
 - TP TRAP PRIMER PIPING BELOW GRADE
 - CDOP TWO WAY FLOOR CLEANOUT
 - CU COPPER TUBE
 - DN DOWN
 - DF-L DRINKING FOUNTAIN TYPE, SEE FIXTURE SCHEDULE
 - EST EXISTING STORM WATER
 - ECO END CLEANOUT

- EW-L EYEWASH TYPE, SEE FIXTURE SCHEDULE
- EVAP EVAPORATOR
- FCO FLOOR CLEANOUT
- FD-L FLOOR DRAIN TYPE, SEE FIXTURE SCHEDULE
- INV. PIPE INVERT ELEVATION
- LAV-L LAVATORY TYPE, SEE FLOOR DRAIN SCHEDULE
- MB-L MOP BASIN TYPE, SEE FIXTURE SCHEDULE
- PVC POLYVINYL CHLORIDE PIPE
- SK-L SINK TYPE, SEE FIXTURE SCHEDULE
- T/G TOP OF FLOOR DRAIN GRATE, ELEVATION
- UR-L URINAL TYPE, SEE FIXTURE SCHEDULE
- WC-L WATER CLOSET TYPE, SEE FIXTURE SCHEDULE
- WCO WALL CLEANOUT
- (E) EXISTING FIXTURE
- (R) RELOCATED FIXTURE
- CTE CONNECT TO EXISTING
- NEW TIED INTO EXISTING

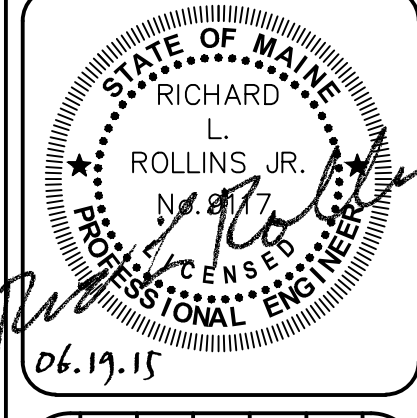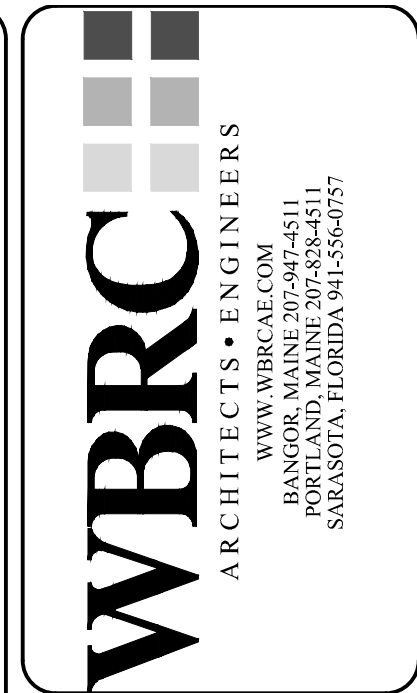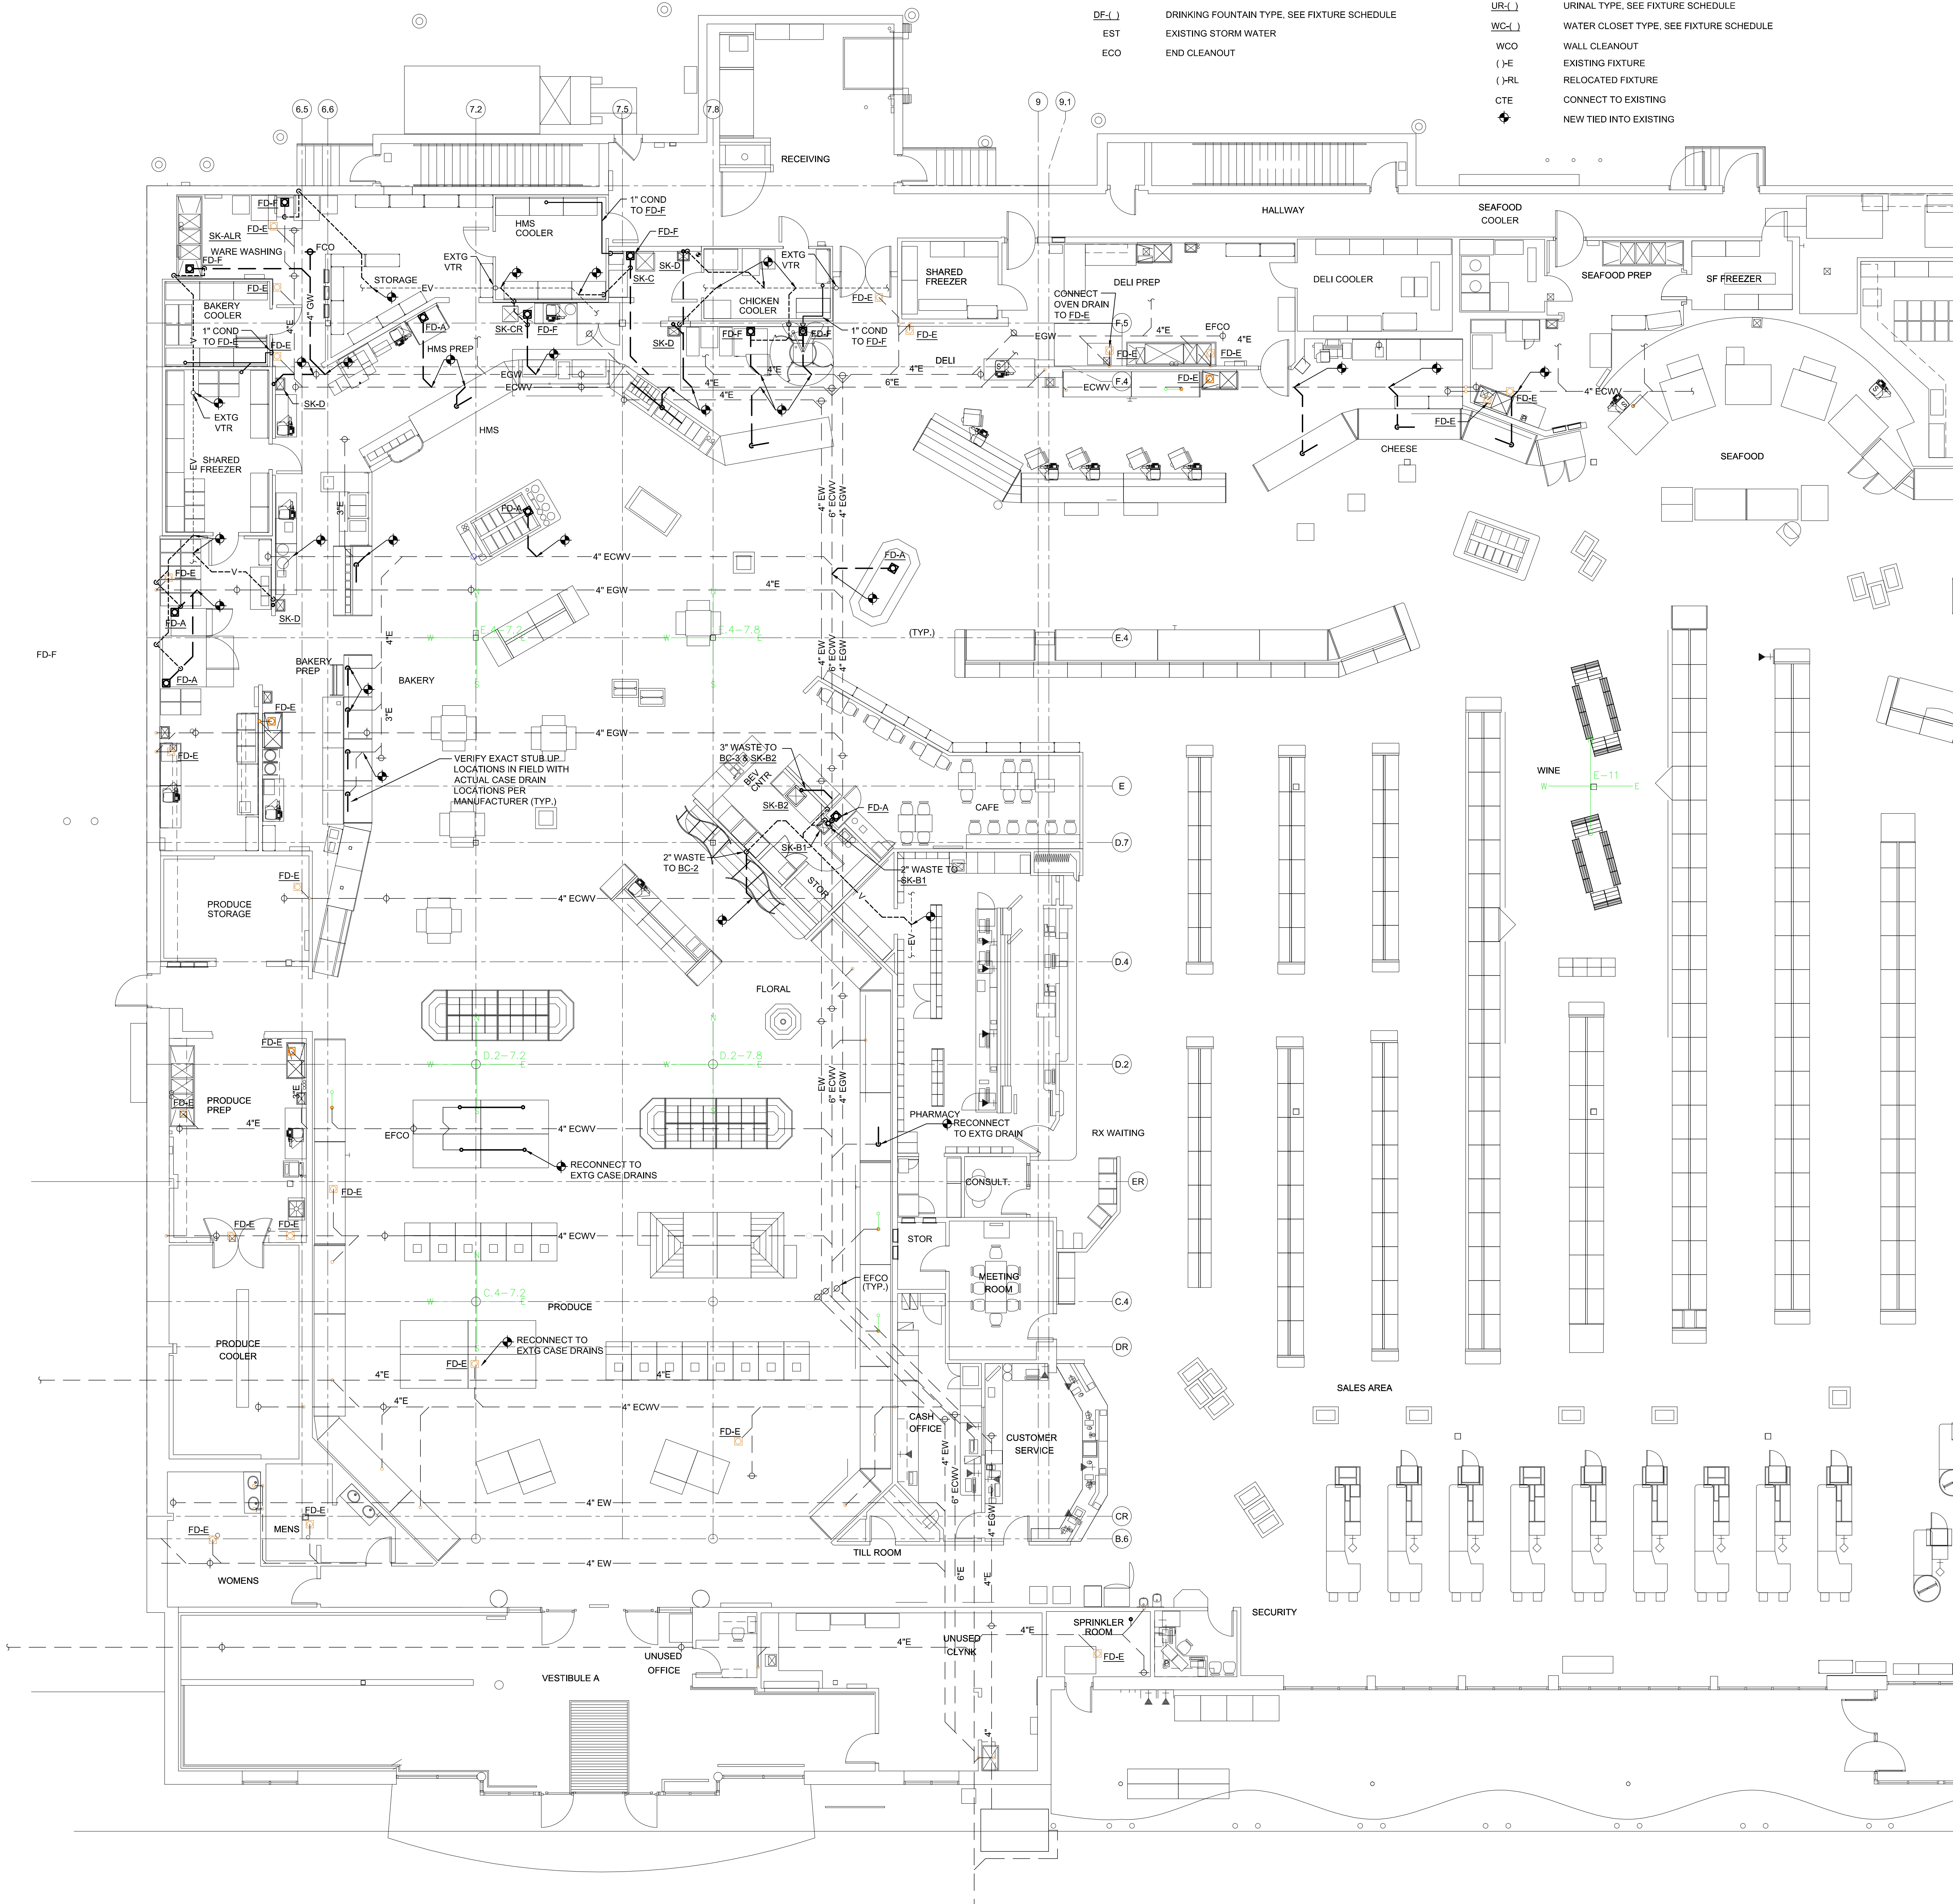

NO.	REVISIONS	DATE	BY	CHK

NO.	REVISIONS	DATE	BY	CHK

Sheet Title	WASTE & VENT PIPING PLAN	RLR
Scale	1/8" = 1'-0"	CGB
Date	06.19.15	Design
		Drawn
		© 2015 Delhaze America Shared Services LLC

HANNAFORD STORE #8351 295 FOREST AVE.
PORTLAND, ME
LIMITED USE NOTE

Jun 14 2015 - 2:07pm
 T:\02 Projects - Maine\3000\3000\30154 Hannaford - Forest Ave Portland\Design\Bldg\HANNAFORD 510RE #8351 295 FOREST AVE\Bldg\T04-WASTE & VENT PIPING PLAN\dwg\p101.dwg