

NO.	REVISIONS	DATE	BY

NO.	REVISIONS	DATE	BY

NO.	REVISIONS	DATE	BY

Sheet Title
DOMESTIC WATER SUPPLY PIPING PLAN

Scale
1/8" = 1'-0"

Date
06.19.15

Design
Param

Drawn
CGB

Checked
RLR


© 2015 Delhaize America Shared Services LLC

TECHNICAL NOTES:

1. TIE INTO EXISTING HW & CW PIPING IN VICINITY W/ NEW 1/2" HW & CW LINES. PROVIDE SHUT-OFF VALVES @ NEW BRANCH LINES.
2. TIE INTO EXISTING HW & CW PIPING IN VICINITY W/ NEW 3/4" HW & CW LINES. PROVIDE SHUT-OFF VALVES @ NEW BRANCH LINES.
3. TIE INTO EXISTING CW PIPING IN VICINITY W/ NEW 3/4" CW LINES. PROVIDE SHUT-OFF VALVE @ NEW BRANCH LINE.
4. PROVIDE TRAP PRIMER AND 1/2" CW BRANCH OFF MAIN TO SERVE FLOOR DRAIN.

PIPING LEGEND:

— CW —	— CW —	— COLD WATER LINE
— FW —	— FW —	— FILTERED WATER LINE
— HW —	— HW —	— HOT WATER LINE
— HWR —	— HWR —	— HOT WATER RETURN LINE (TEMP AS NOTED)
—	—	— SHOCK ARRESTOR OF SIZE INDICATED
—	—	— SHUT-OFF VALVE
—	—	— TRAP PRIMER VALVE
— ECW —	— ECW —	— EXISTING COLD WATER LINE
— EFW —	— EFW —	— EXISTING FILTERED WATER LINE
— EHW —	— EHW —	— EXISTING HOT WATER LINE

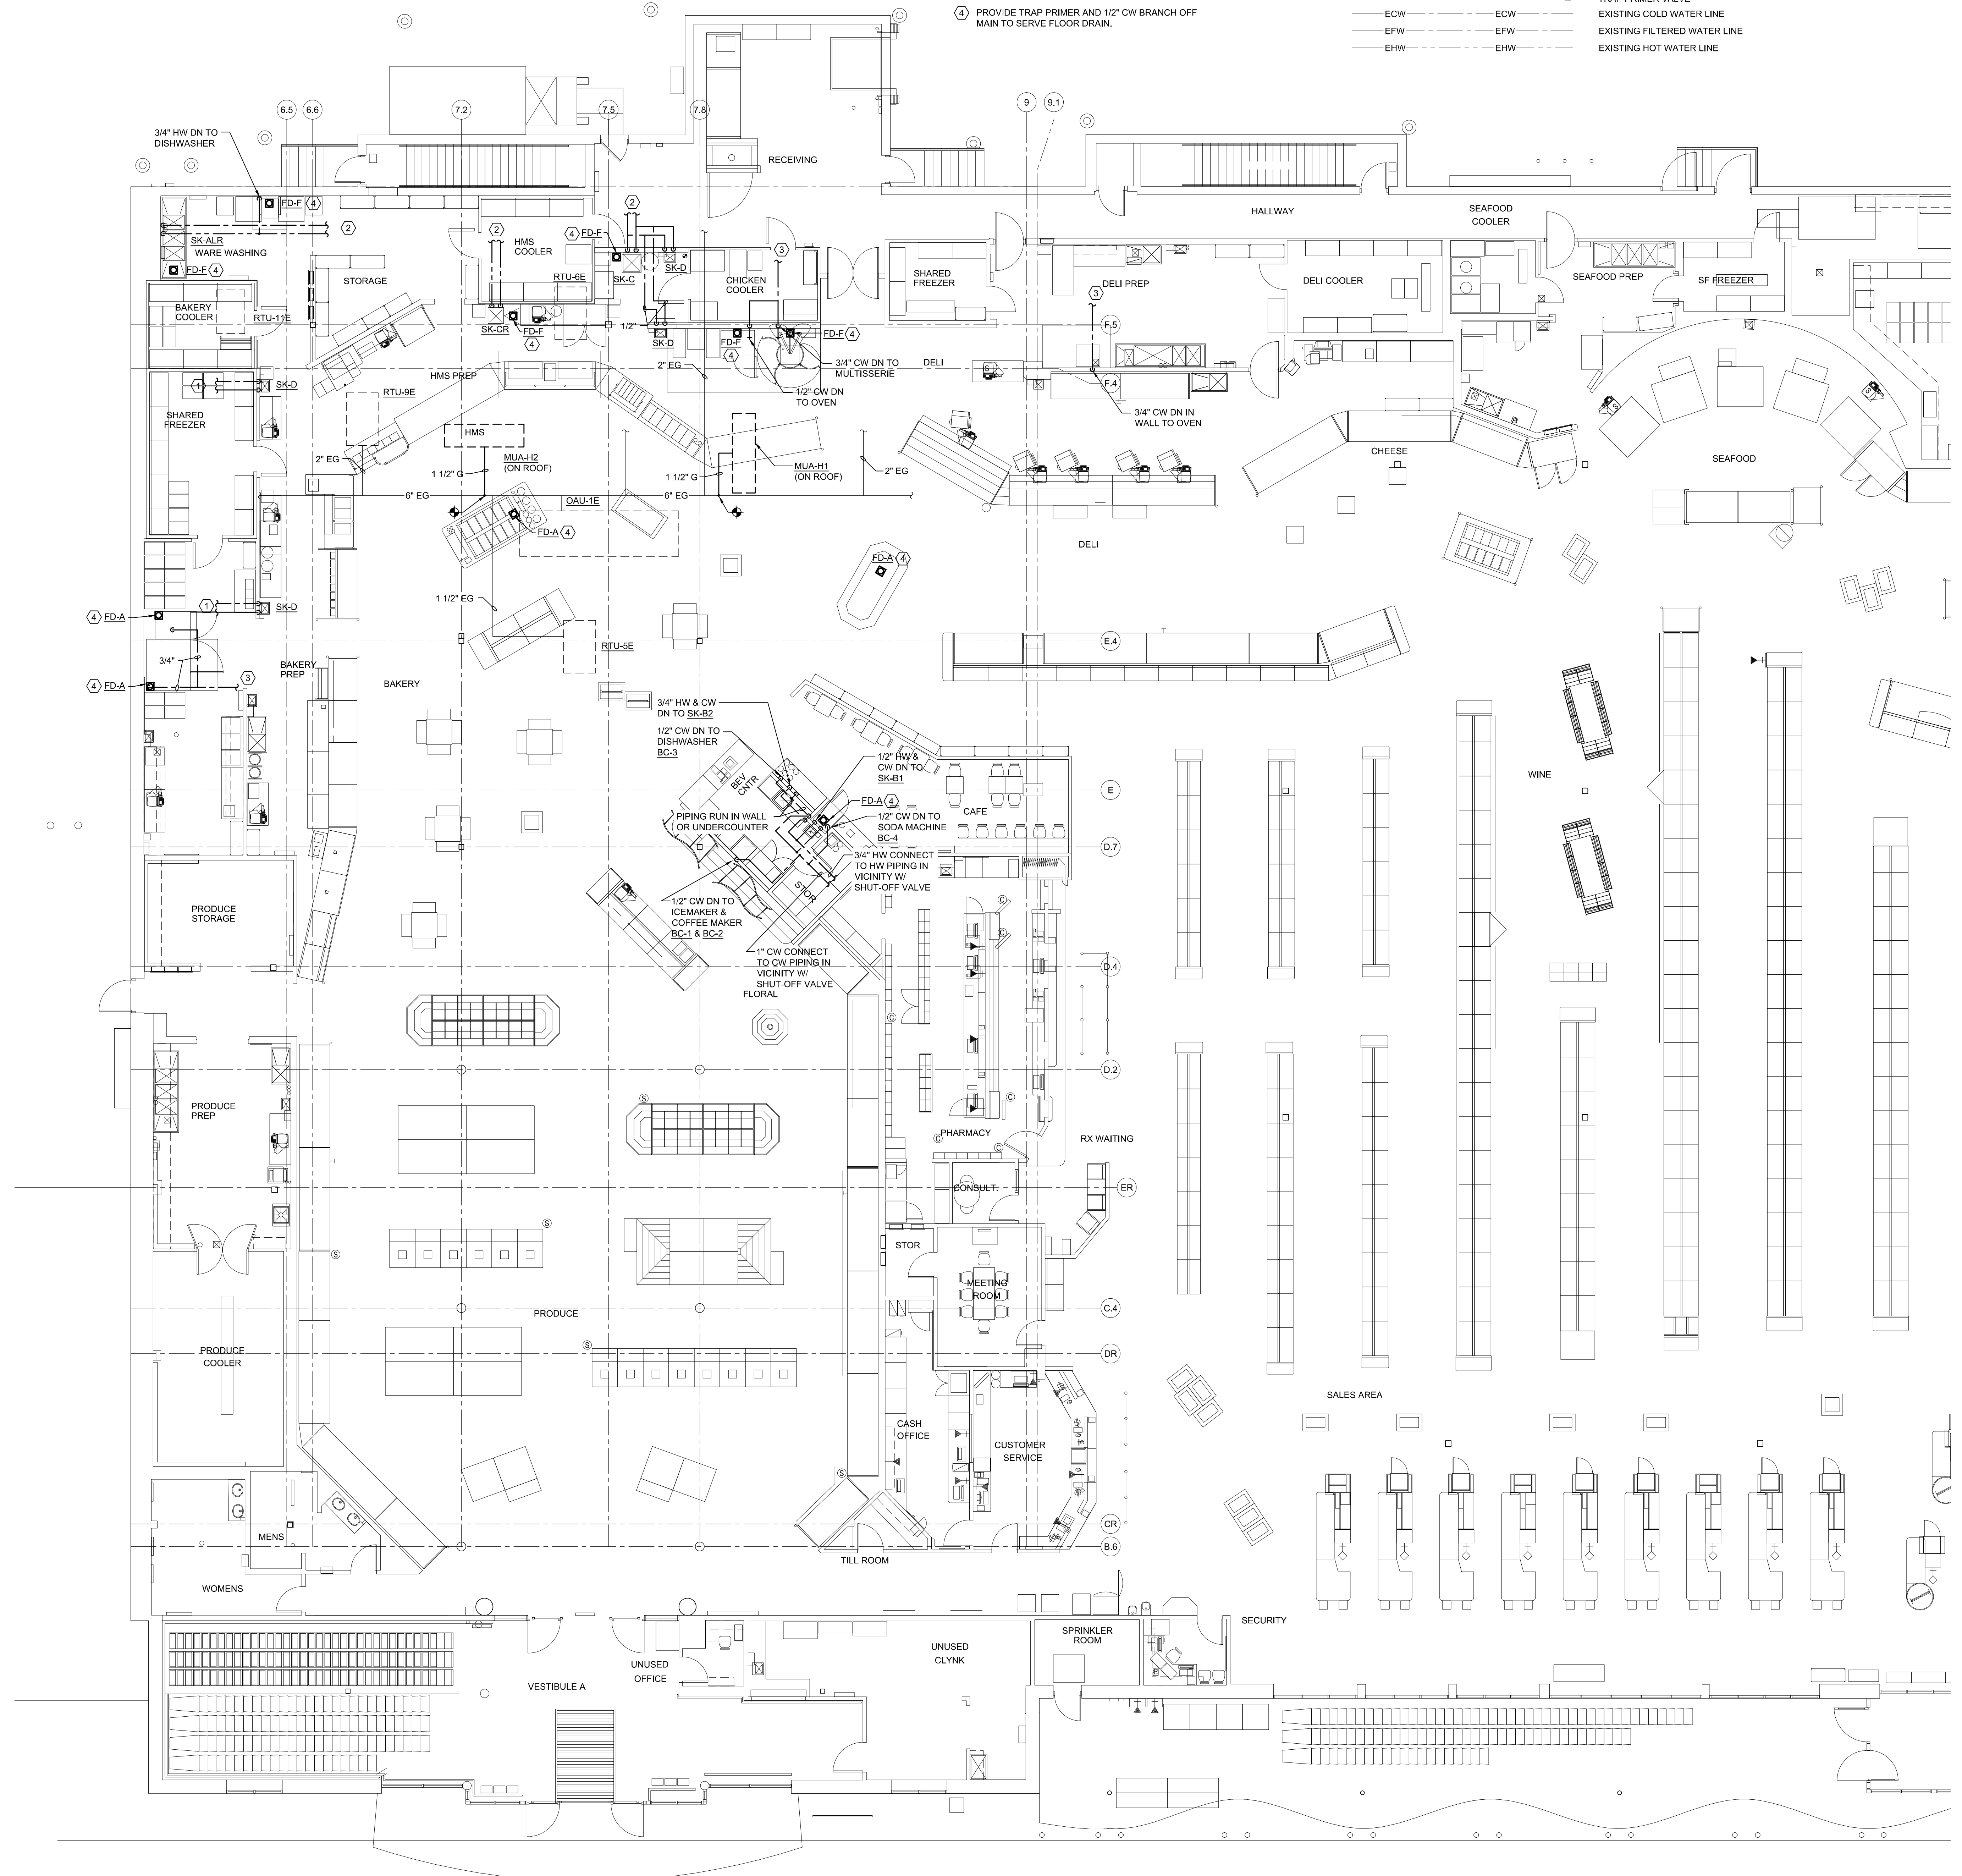

Jun 19, 2015 - 2:06pm
 T:\02 Projects - Maine\001-3100\301759 Hannaford - Forest Ave Portland\Design\Wgs\Bldg\HANNAFORD STORE #8351 - 295 FOREST AVE\301759-P103 DOMESTIC WATER SUPPLY PIPING PLAN.dwg\p103.rvt