


This document contains confidential information, is an instrument of a professional service, and the property of TriMark. It shall not be used on other projects or for the extension of this project without TriMark's written approval.


Owner and all Contractors to check and verify existing dimensions and conditions in the field before starting construction and to notify TriMark of any material or detail changes.

REVISIONS

DATE	BY	NO.	DESCRIPTION
3/21/16	RDP	A	REVISION
4/13/16	RDP	B	REVISION
4/15/16	RDP		ADDED ALT PLAN
4/18/16	RDP	C	REVISION
4/25/16	RDP	D	REVISION
4/26/16	RDP	E	REVISION
4/28/16	RDP	F	REVISION
5/6/16	RDP		UTILITY DRAWINGS

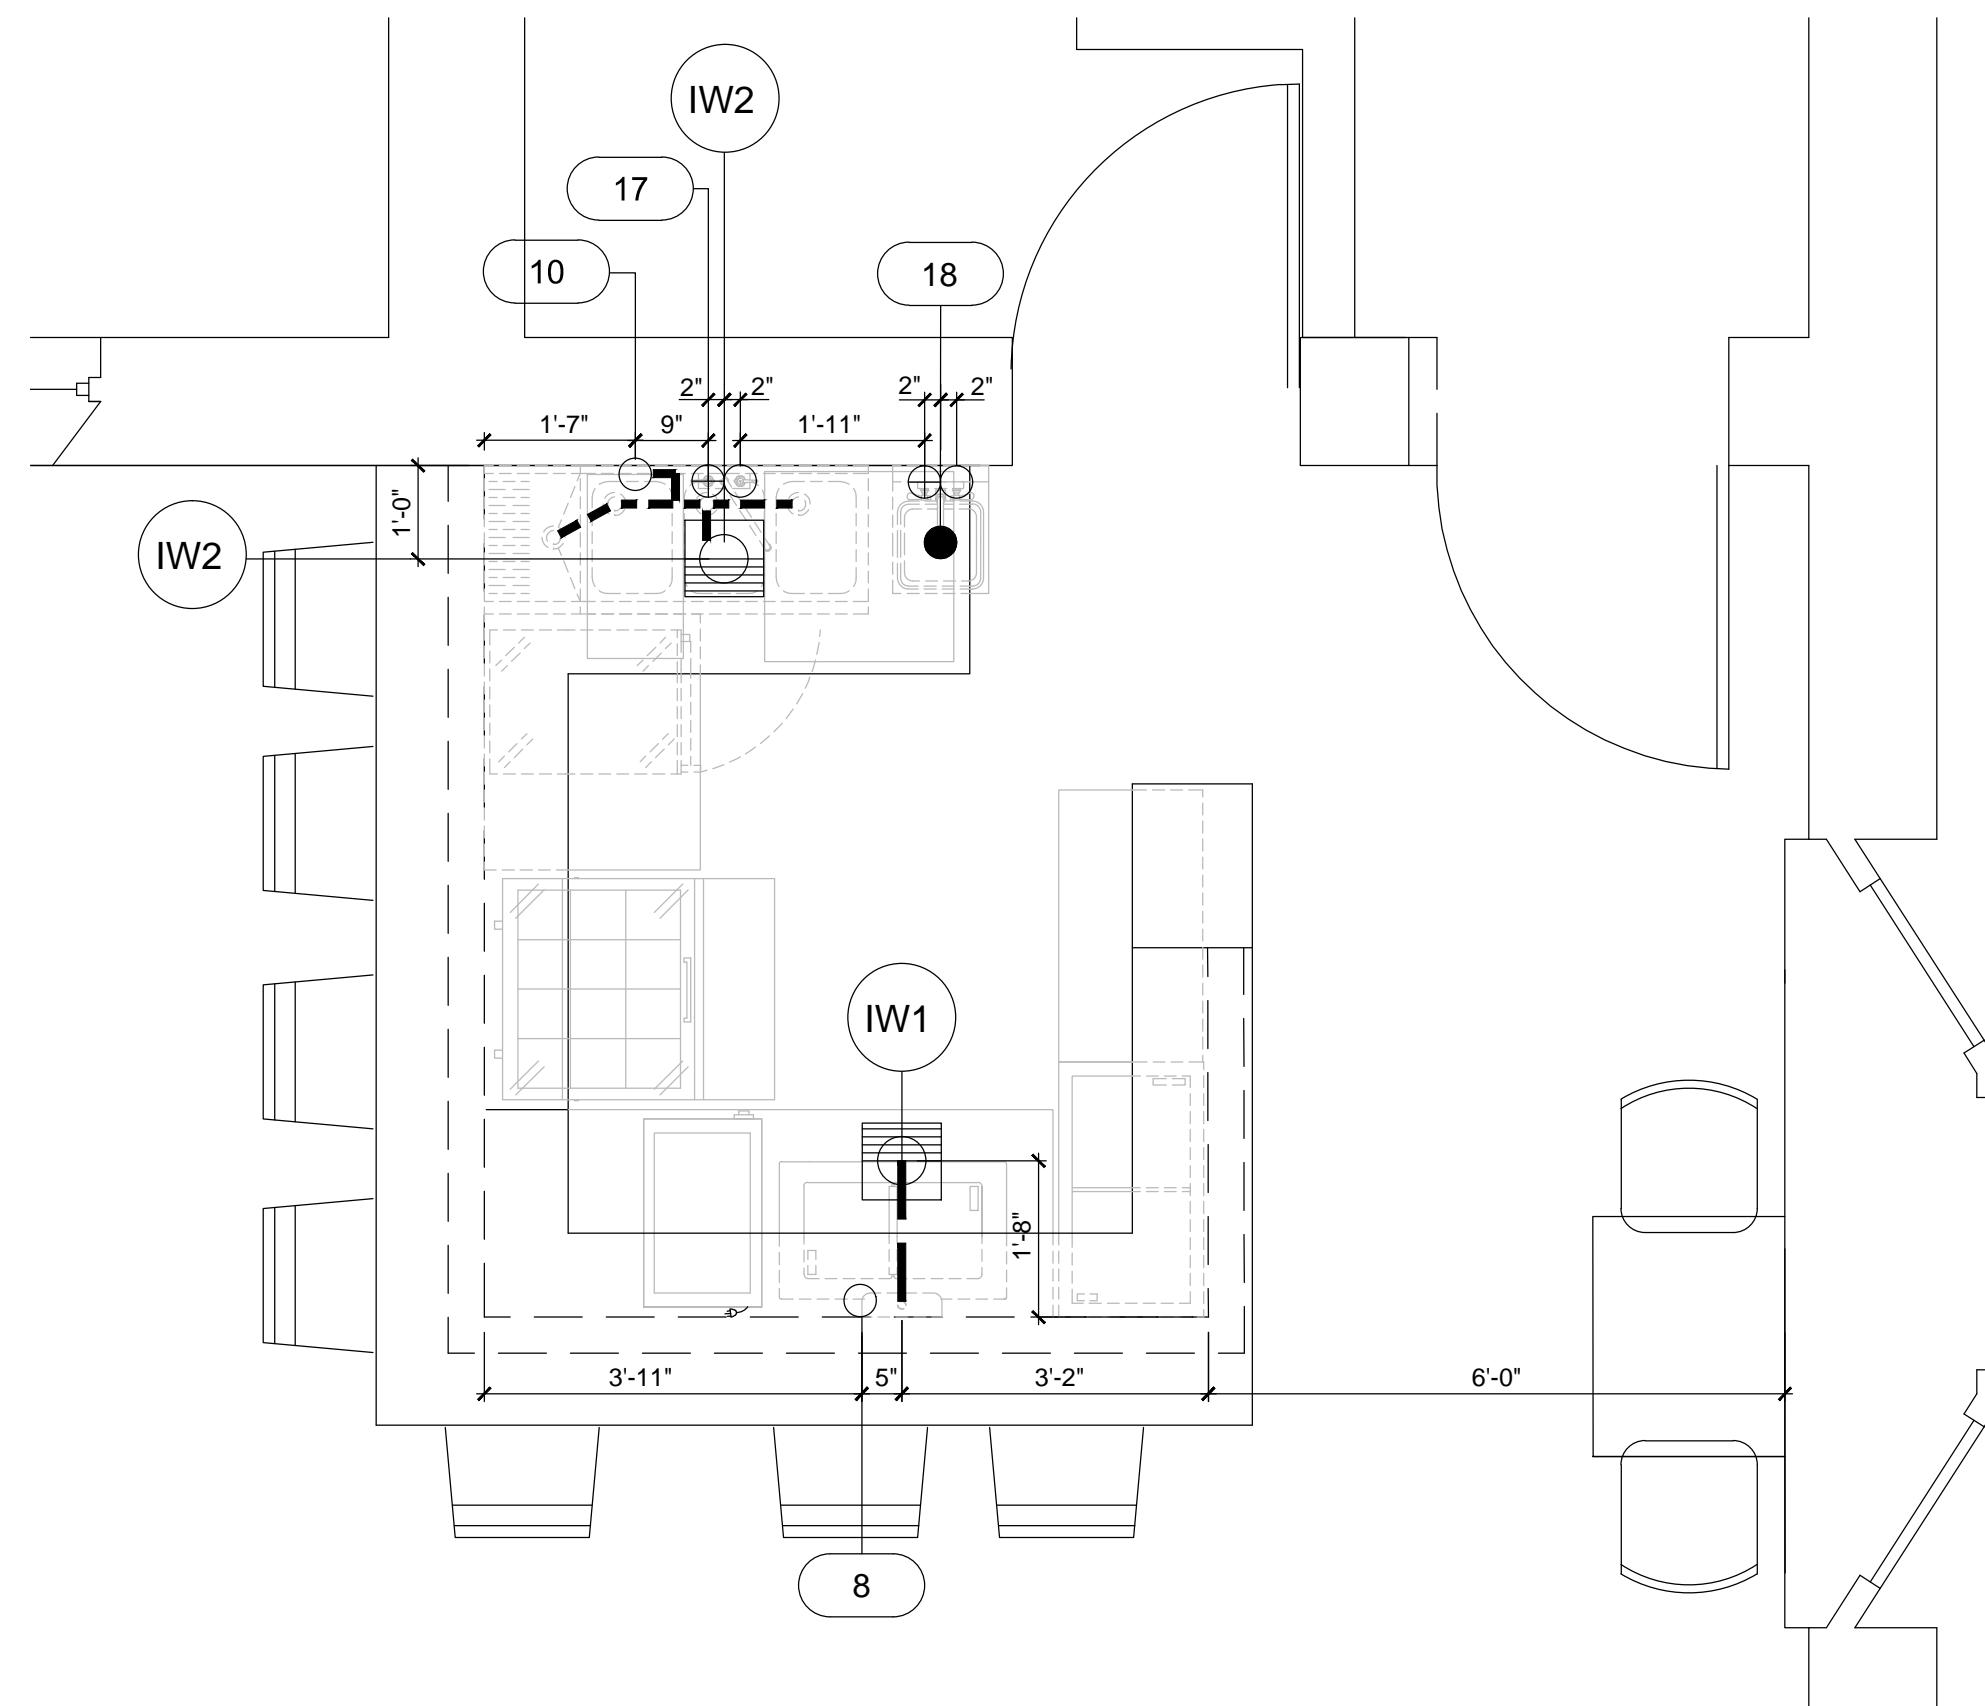

PLUMBING ROUGH-IN PLAN
SCALE: 1/2" = 1'-0"

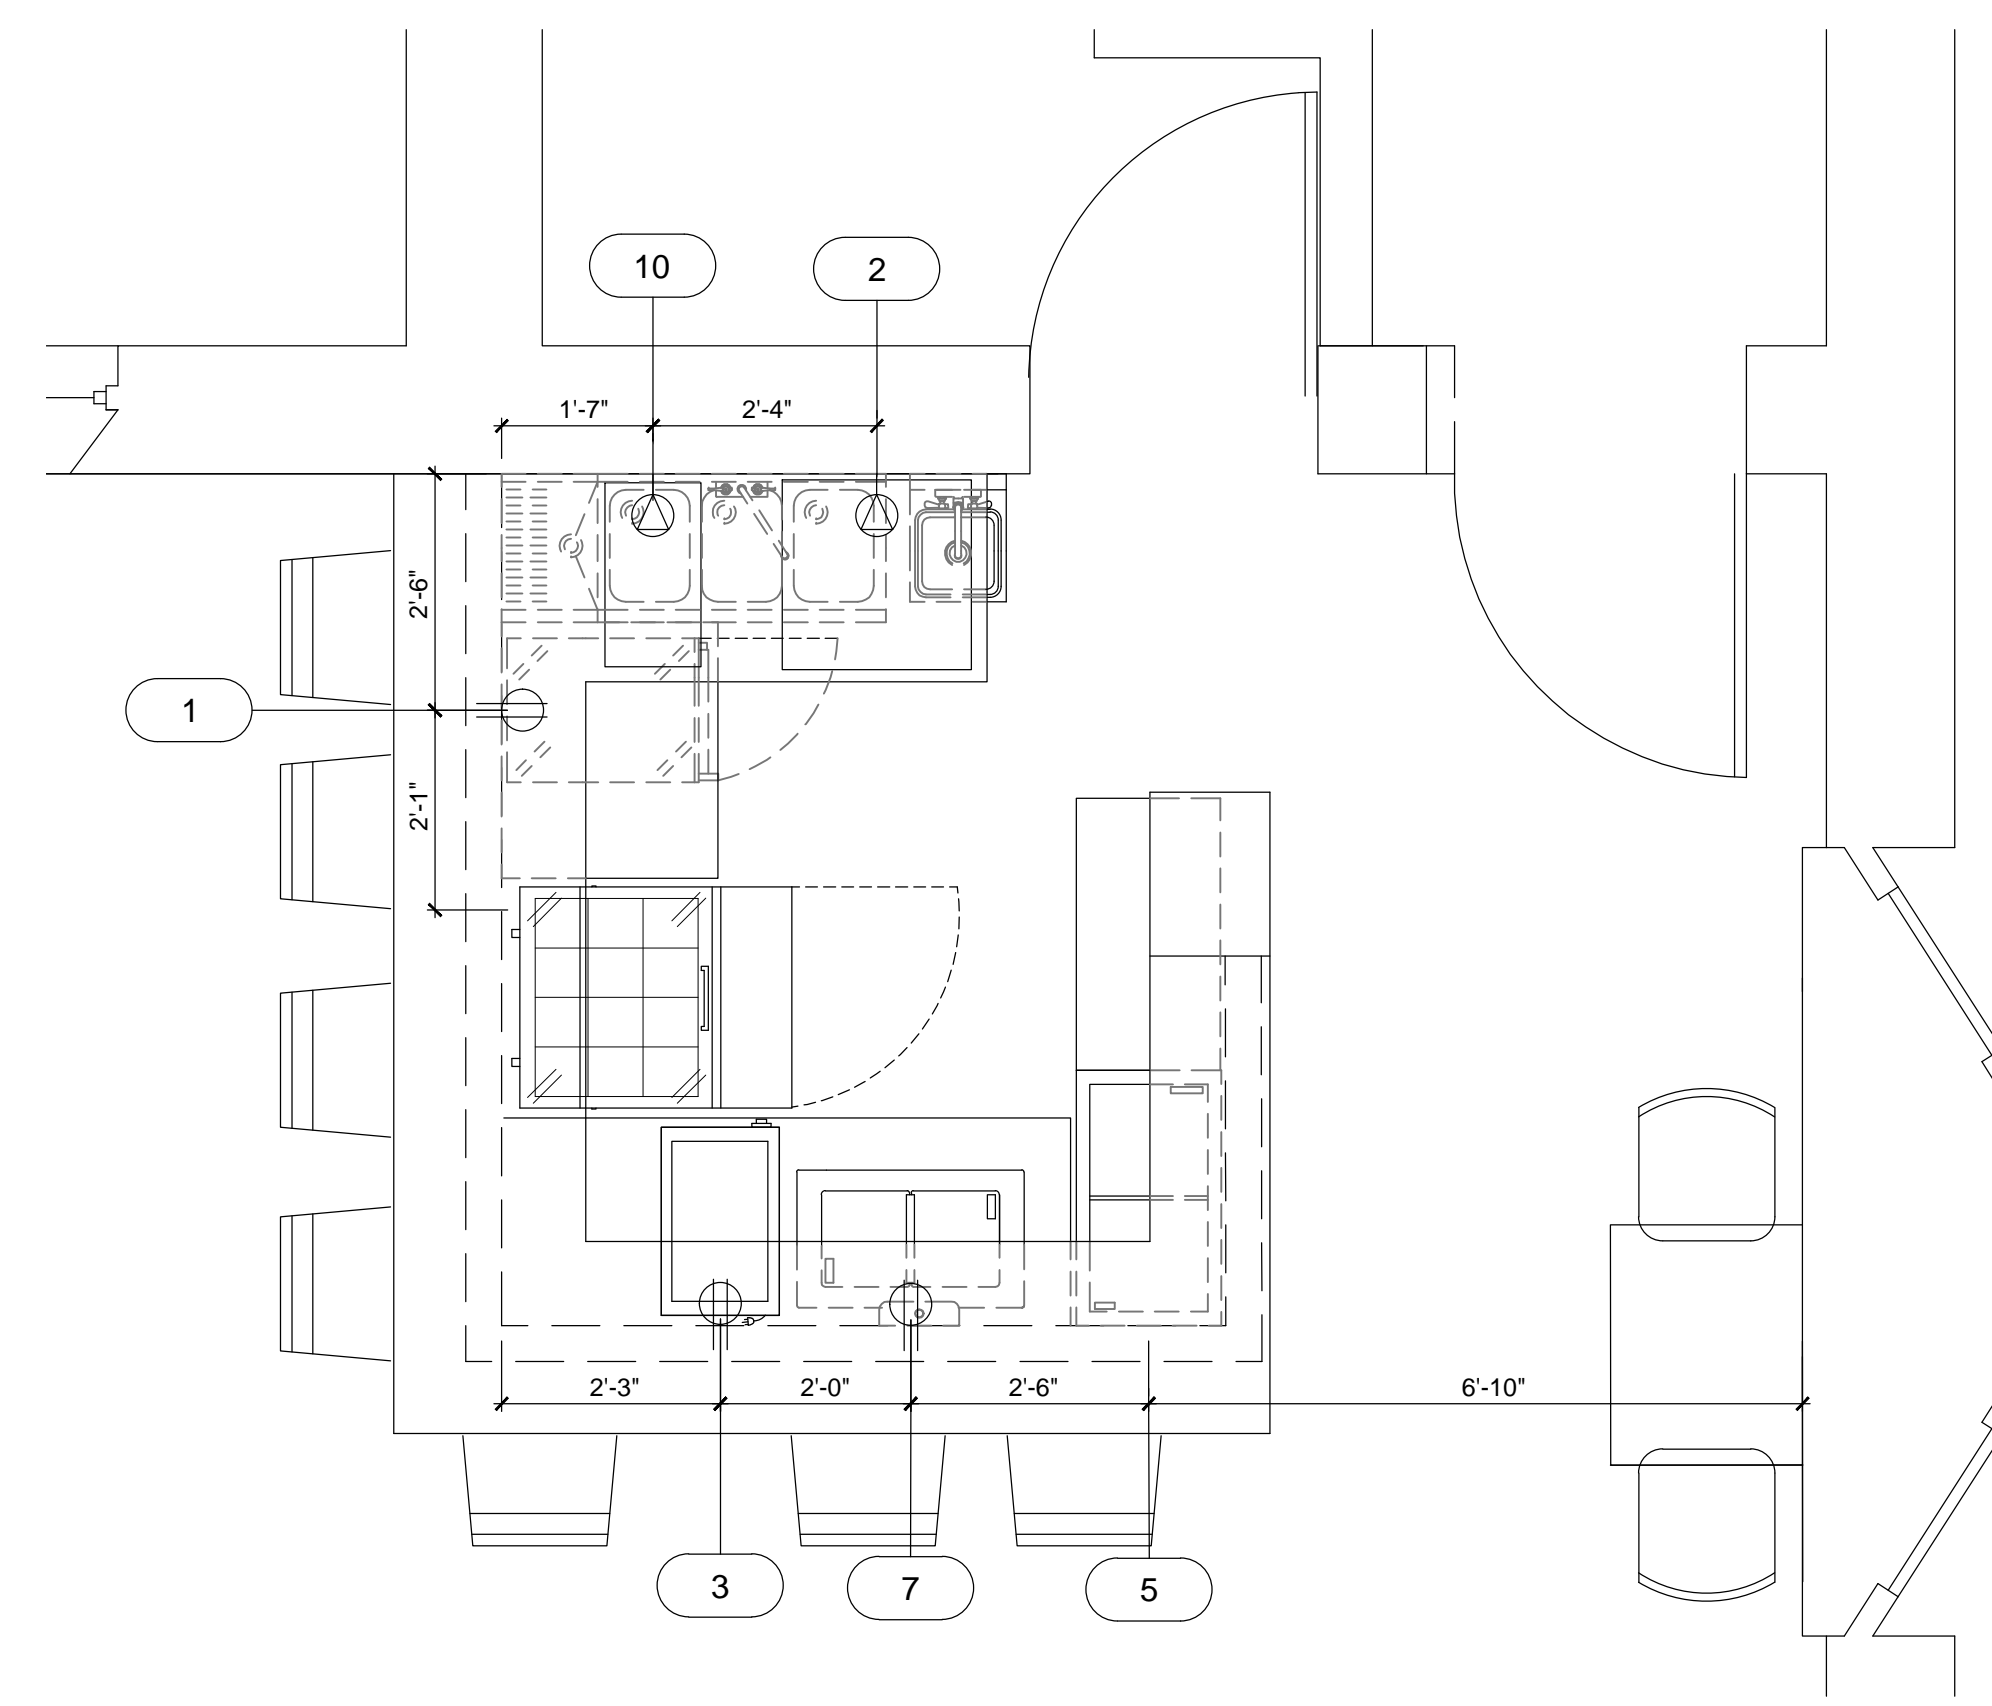

ELECTRICAL ROUGH-IN PLAN
SCALE: 1/2" = 1'-0"

PLUMBING SCHEDULE

REV	ITEM NO.	QTY	ITEM DESCRIPTION	CW (IN)	CW CONN. HGT	HW (IN)	HW CONN. HGT	IW (IN)	DW (IN)	DW CONN. HGT	GAS SIZE	MBTUH	GAS CONN. HGT	PLUMBING REMARKS	ITEM NO.
B	8	1	DIPWELL 10" W/ INSTALL KIT 3" WIDE W/ FAUCET	1/2"	12"			1", IW1							8
A	10	1	ESPRESSO CAPPUCCINO MACHINE	3/8"	24"			2", IW1						STUB OUT AND BRANCH TO CONNECTION	10
C	17	1	UNDERBAR SINK UNITS	1/2"	12"	1/2"	12"	(4) 1-1/2", IW2						P.C. TO RUN FOUR (4) INDIRECT WASTES TO FLOOR SINK AS REQUIRED	17
E	18	1	HAND SINK	1/2"	24"	1/2"	24"		1-1/2"	22"					18

ELECTRICAL SCHEDULE

REV	ITEM NO.	QTY	ITEM DESCRIPTION	VOLTS	PH	KW	HP	AMPS	CONN.	NEMA	CONN HGT	ELEC REMARKS	ITEM NO.
	1	1	HEATED LOW TEMP HOLDING CABINET	120	1	1.0		8.4	DR	5-15P	16"		1
C	2	1	CONVECTION OVEN	208-240	1	2.7		11.25	SP	6-15P	60"		2
F	3	1	HOT FOOD WELL	120	1	1.65		13.75	DR	5-15P	38"		3
	4	1	MEGA TOP SANDWICH / SALAD PREPARATION REFRIGERATOR	115	1		1/5	4.9	DR	5-15P	16"		4
E	5	1	REFRIGERATED MERCHANDISER	X	X	X	X	X	X	X		E. TO VERIFY WITH OWNER FINAL UTILITIES PRIOR TO ROUGH-INS	5
A	7	1	DROP-IN FREEZER	115	1		1/3	6.3	DR	5-15P	16"		7
A	10	1	ESPRESSO CAPPUCCINO MACHINE	220-240	1	6.6		30.0	SP	L6-30 R	60"		10

Tiqa Cafe
PORTLAND, ME

Bar Layout

PROJECT NUMBER:
16-030

DATE:
02-09-2016

SCALE:
1/4" = 1'-0"

DRAWN BY:
RDP

APPROVED BY:
MJT

SHEET TITLE:
FOODSERVICE PLUMBING AND ELECTRICAL ROUGH-IN PLANS

SHEET NUMBER:
QF200