



- ▲
- ▲
- ▲
- ▲
- ▲

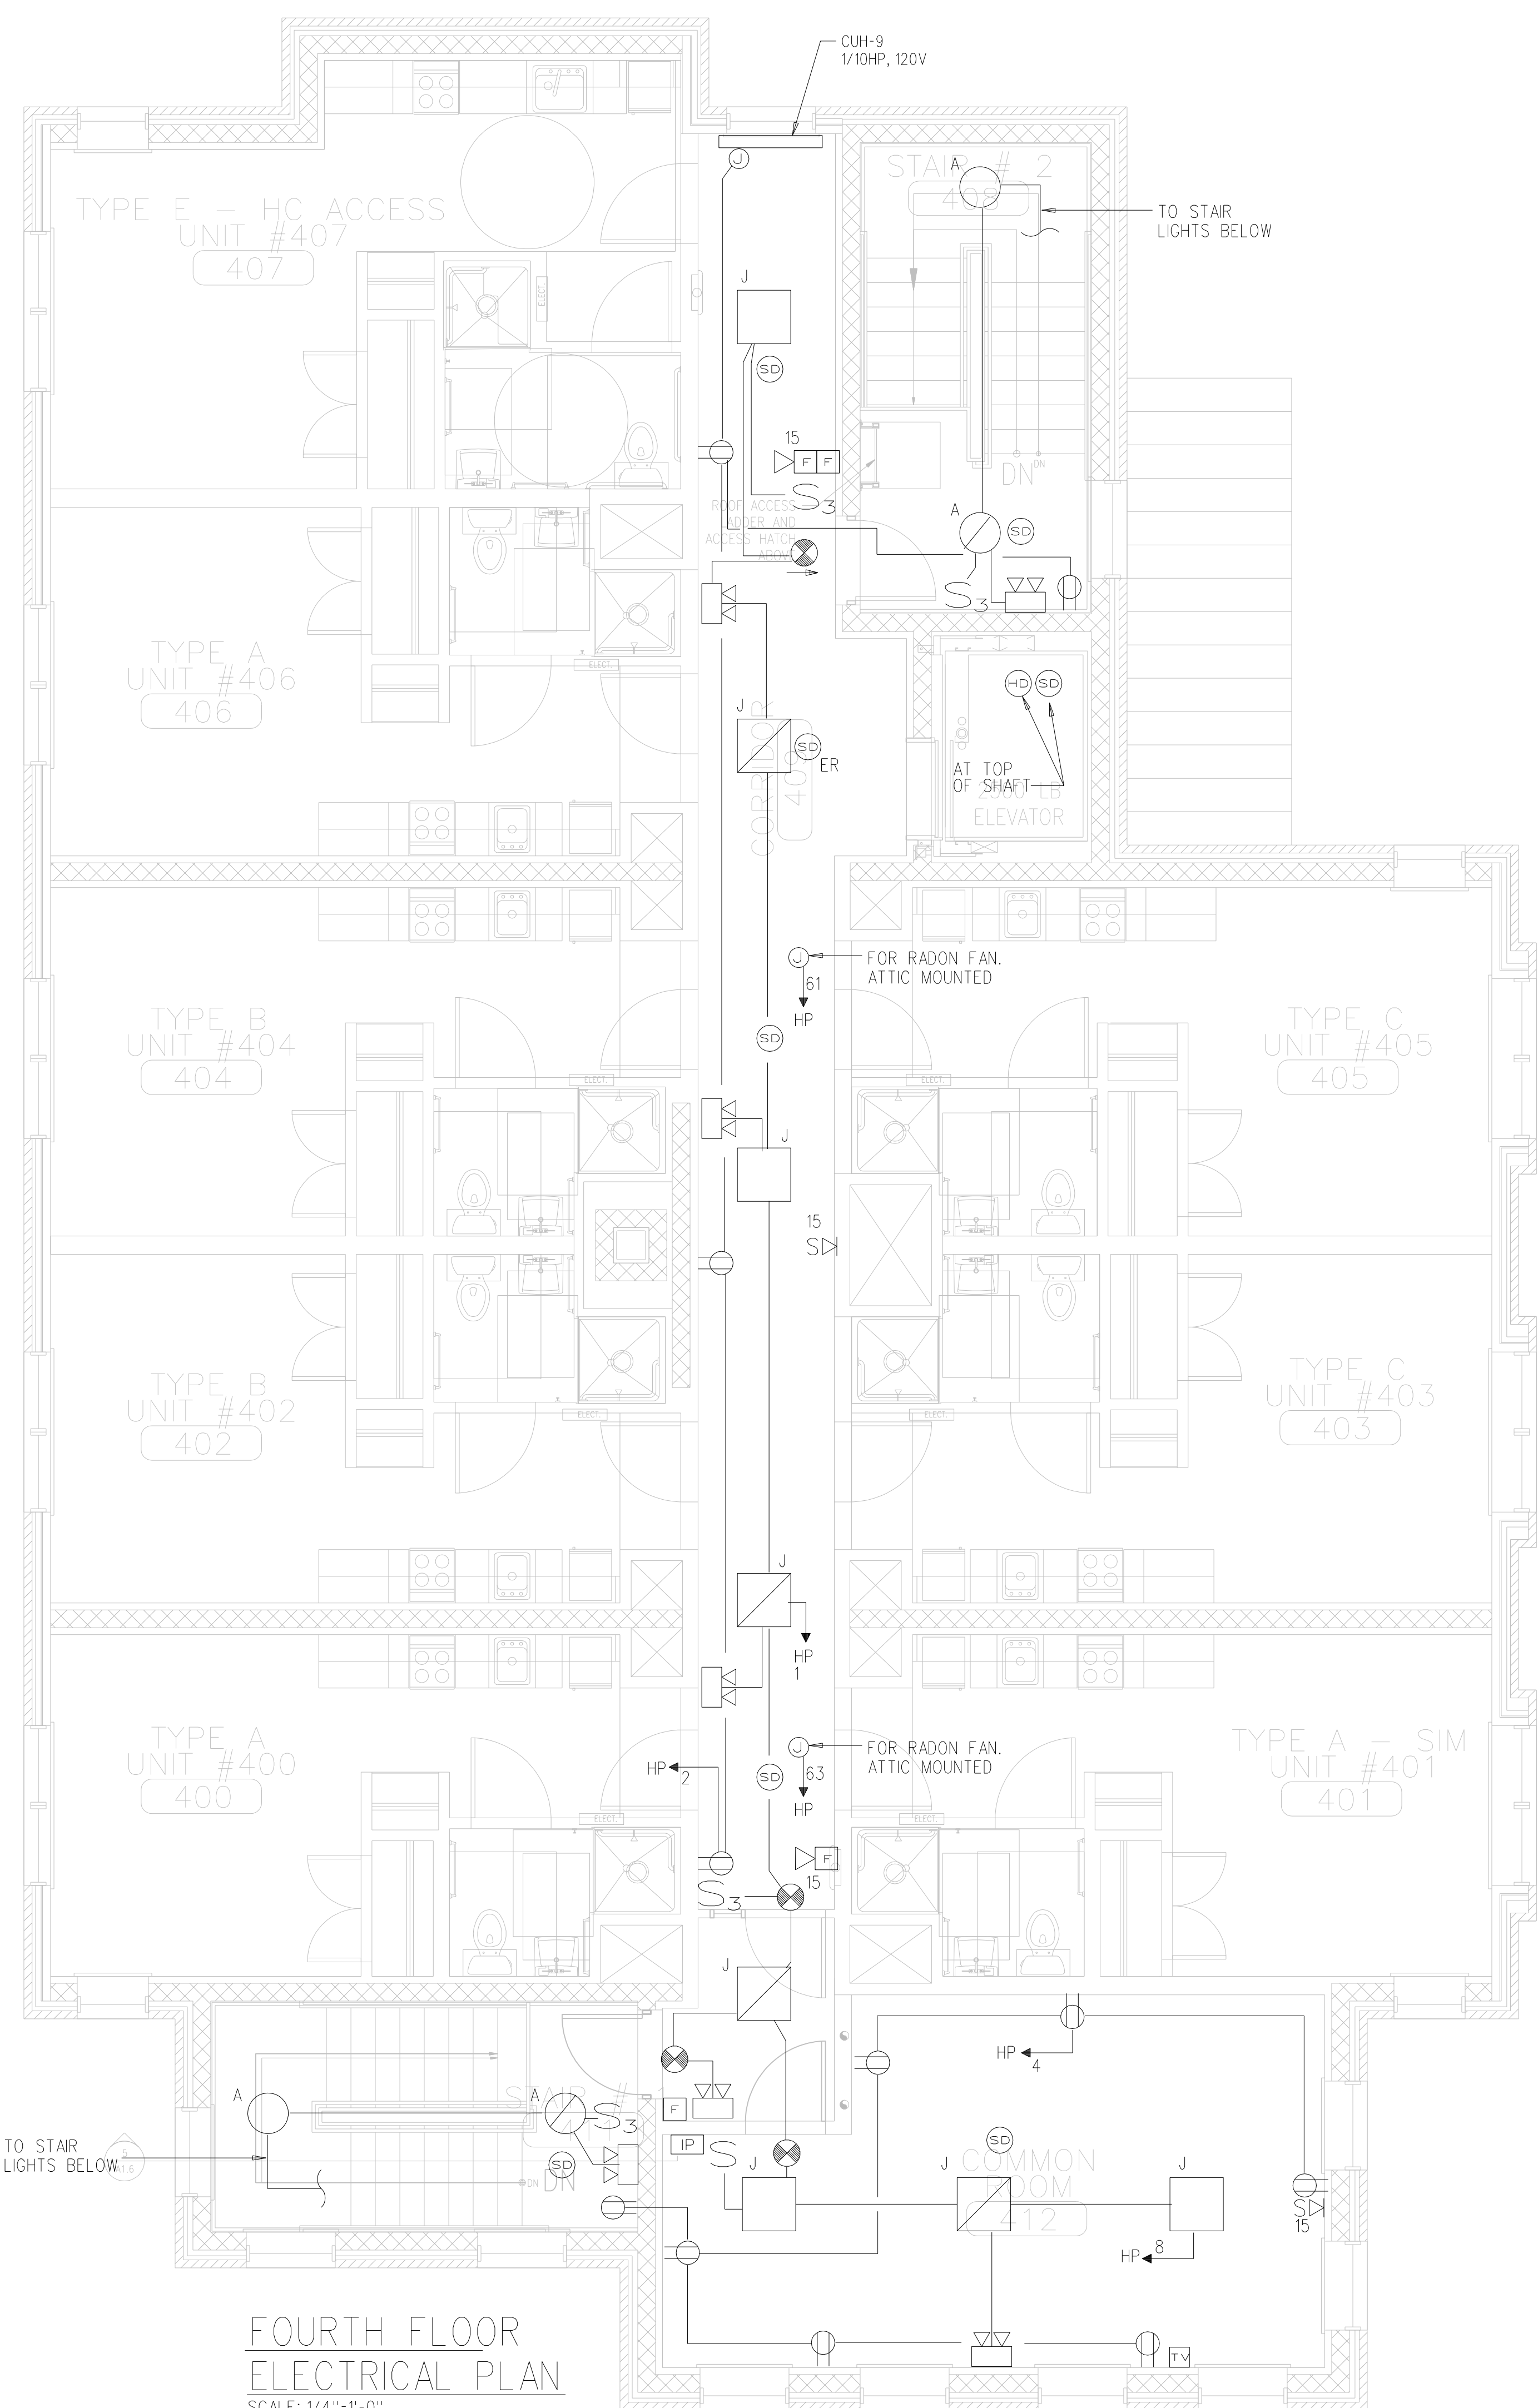

**FOURTH FLOOR
 ELECTRICAL PLAN**
 SCALE: 1/4"=1'-0"

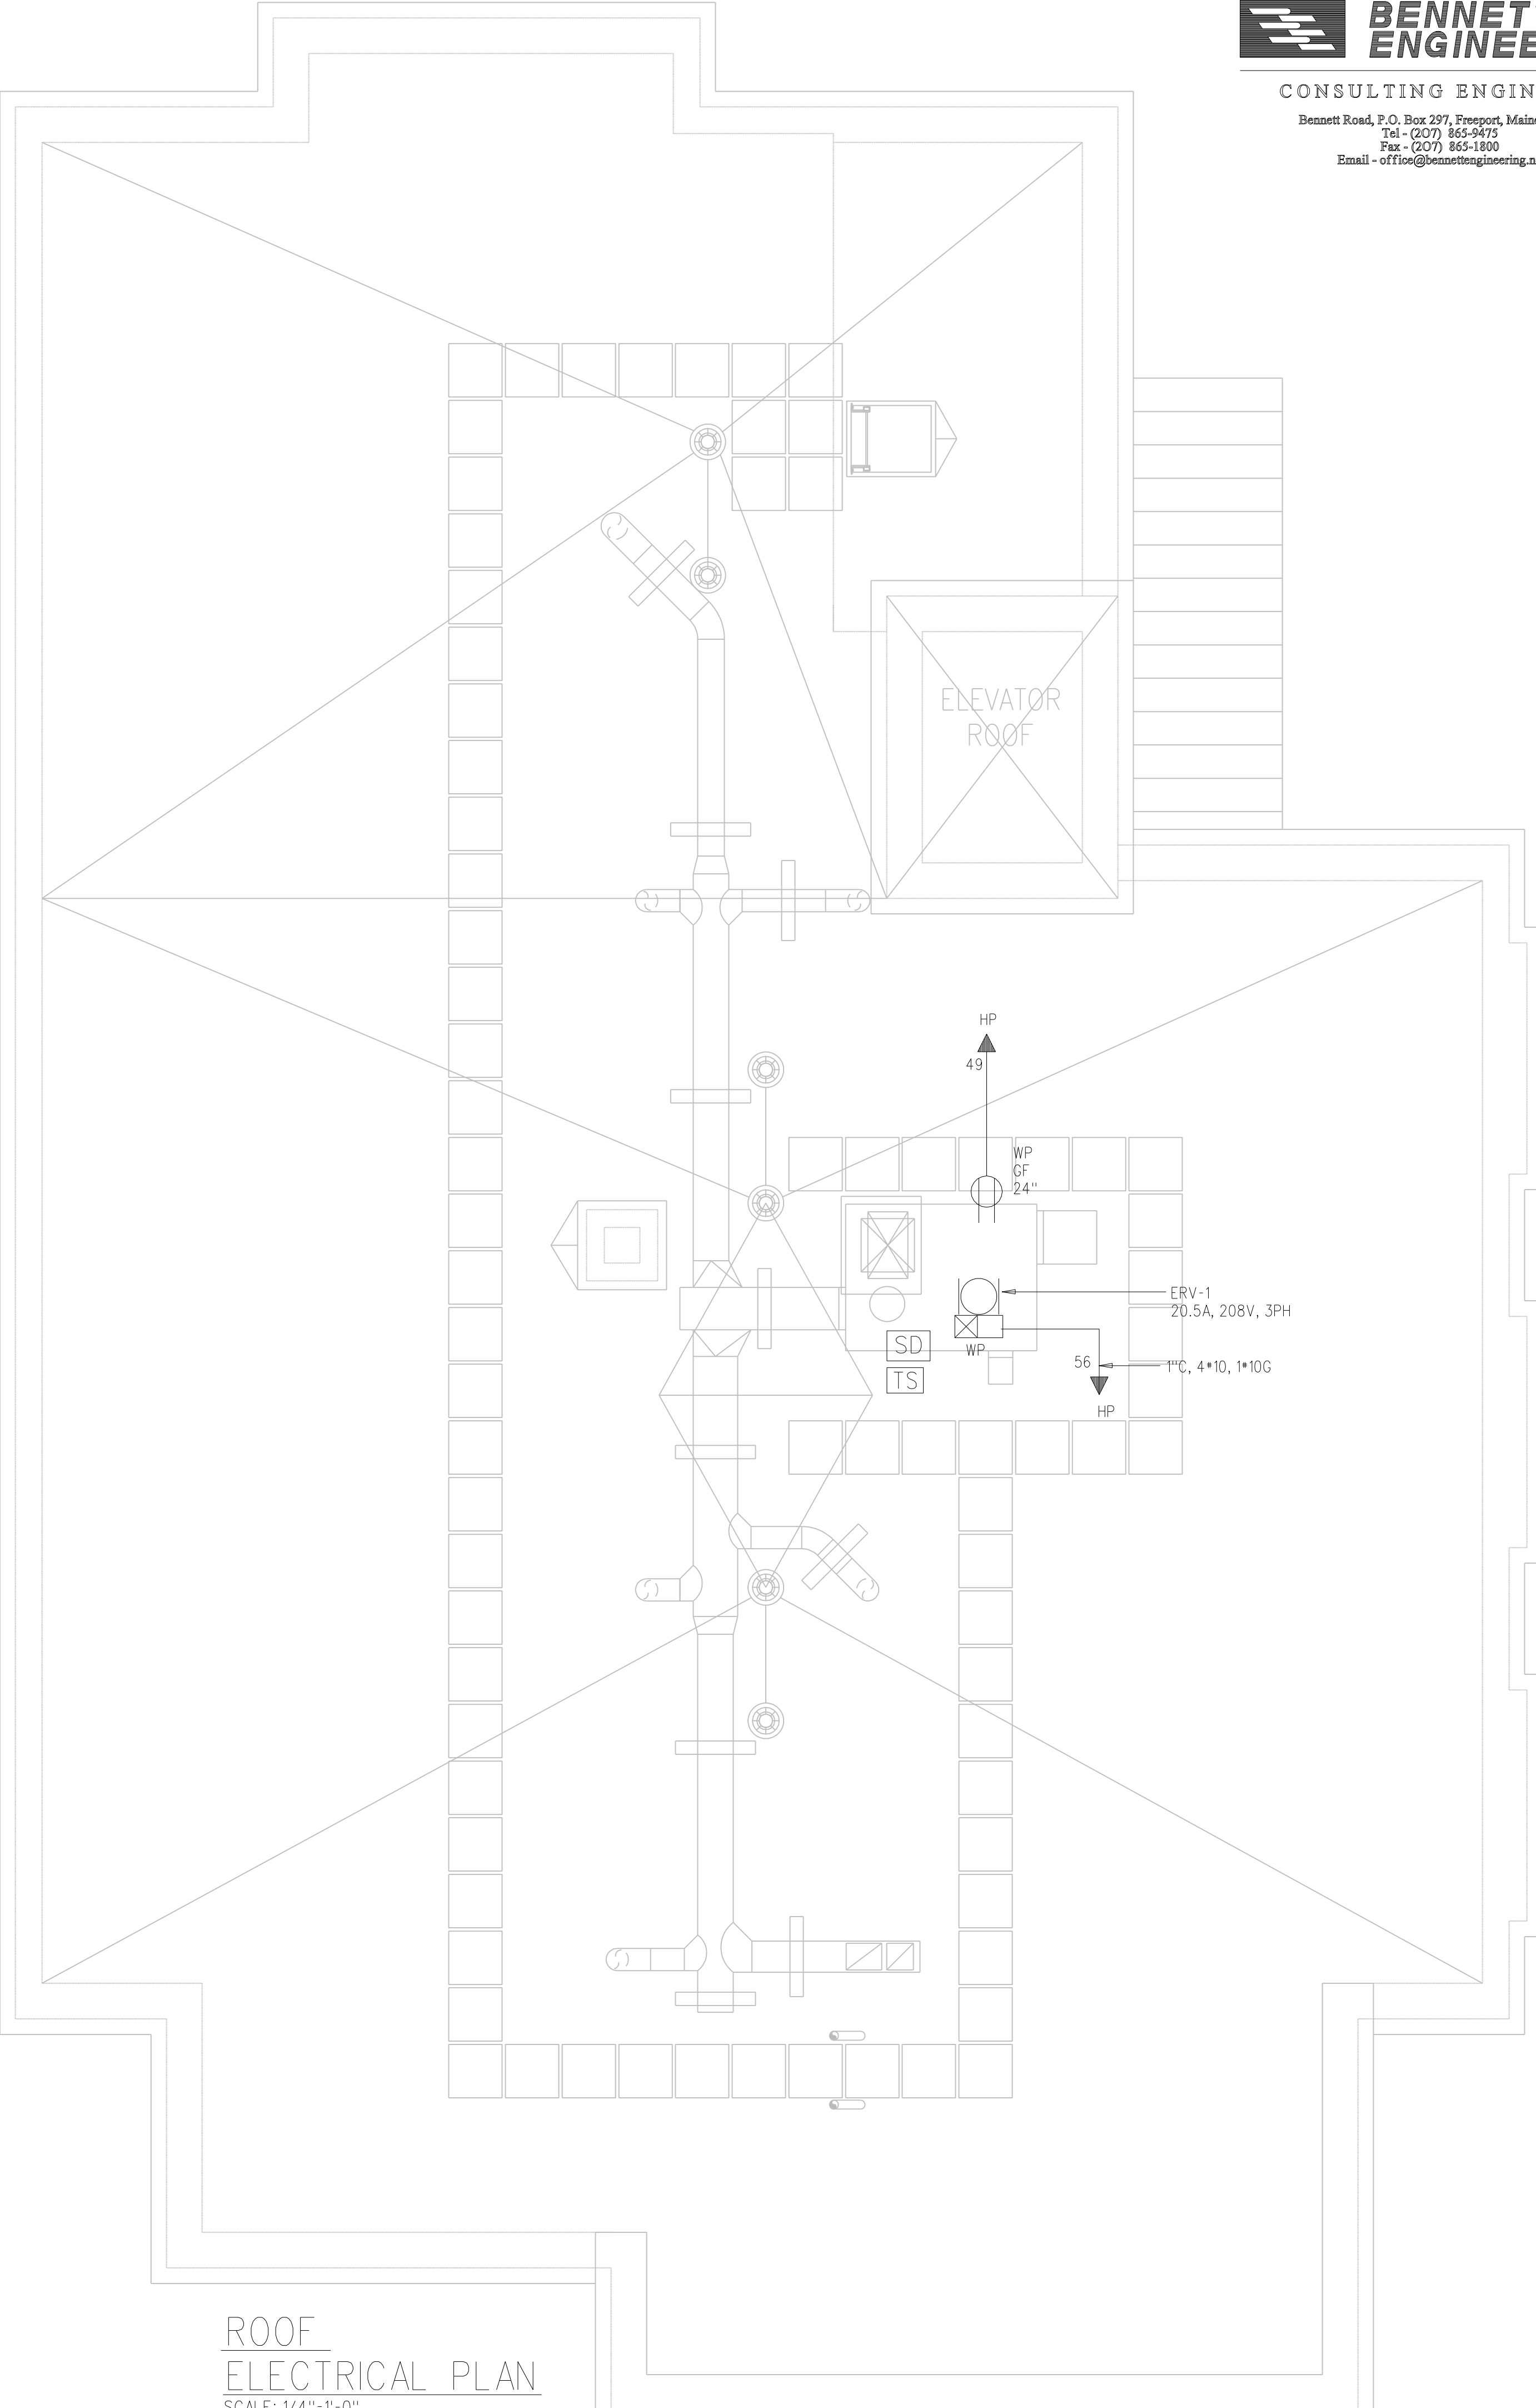

**ROOF
 ELECTRICAL PLAN**
 SCALE: 1/4"=1'-0"