


MEZZANINE SANITARY PLAN
SCALE - 1/8"=1'-0"

PLUMBING NOTES


1. REFER TO PLUMBING FIXTURES SCHEDULE FOR INDIVIDUAL FIXTURE PIPE SIZES.
2. ALL PIPING SHALL BE ROUTED IN FLOOR TRUSS SPACE WHEREVER POSSIBLE.
3. UNLESS INDICATED OTHERWISE, CONNECT 3/4" H.P. CONDENSATE TO NEAREST LAVATORY THRU TAILPIECE, SEE DETAIL.

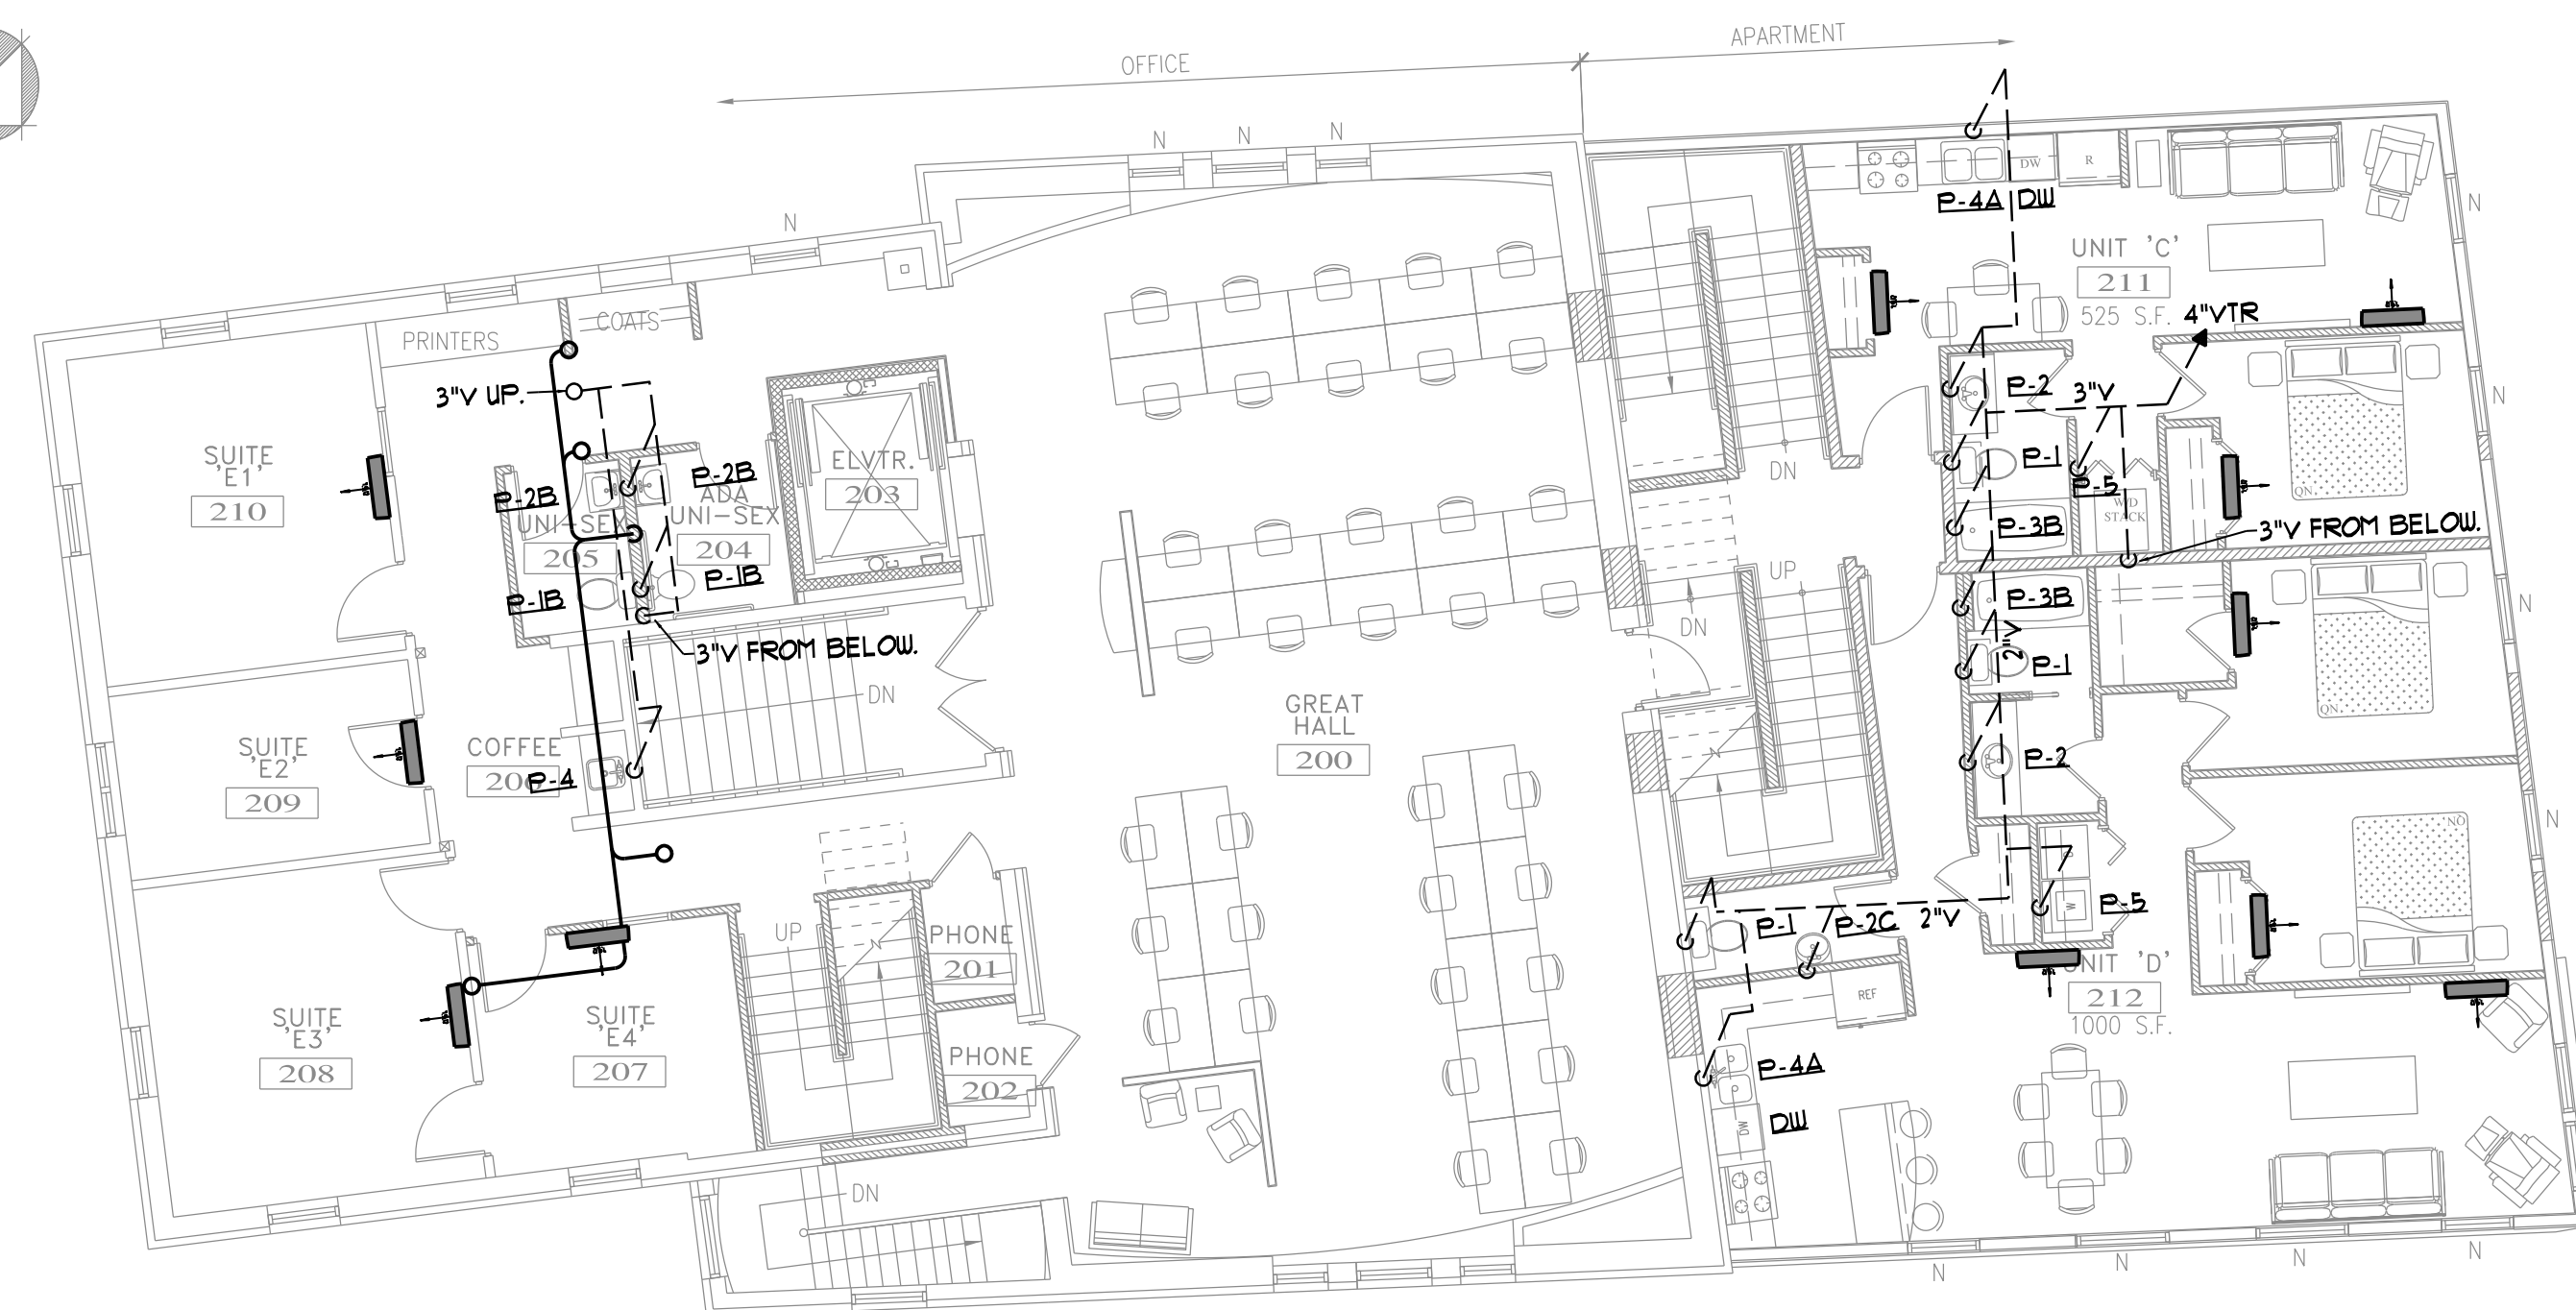



SECOND FLOOR SANITARY PLAN
SCALE - 1/8"=1'-0"

PLUMBING NOTES

1. REFER TO PLUMBING FIXTURES SCHEDULE FOR INDIVIDUAL FIXTURE PIPE SIZES.
2. ALL PIPING SHALL BE ROUTED IN FLOOR TRUSS SPACE WHEREVER POSSIBLE.
3. UNLESS INDICATED OTHERWISE, CONNECT 3/4" H.P. CONDENSATE TO NEAREST LAVATORY THRU TAILPIECE, SEE DETAIL.

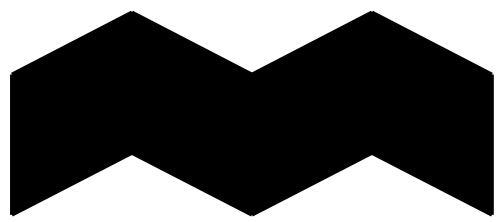

 ALPHAarchitects
17 CHESTNUT STREET
PORTLAND, ME 04101
PHONE: 207.761.9500
FAX: 207.761.9595
design@alphaarchitects.com

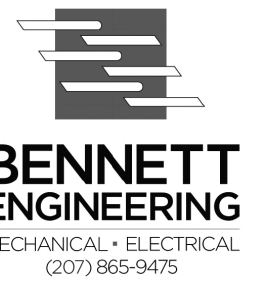

Station 415
415 Cumberland Avenue
Portland, ME. 04101

JOB: 16110

ISSUE DATE	
PRELIM	01-17-16
SFMO	-
CD's	-
REV. 1	-
REV. 2	-
PRINT	09-30-16

SECOND FLOOR &
MEZZANINE SANITARY
PLANS

M2.1

FOR PERMIT 09-30-16