


MEZZANINE DOMESTIC PLAN
SCALE - 1/8"=1'-0"

PLUMBING NOTES


1. REFER TO PLUMBING FIXTURES SCHEDULE FOR INDIVIDUAL FIXTURE PIPE SIZES.
2. ALL PIPING SHALL BE ROUTED IN FLOOR TRUSS SPACE WHEREVER POSSIBLE.
3. PROVIDE 3/4" CW, 1/2" HW & 1/2" RHU FOR EACH APT W/ APT SHUTOFFS AND SIZE 'A' WATER HAMMER ARRESTORS AT WATER HEATER.
4. NATURAL GAS PIPING SYSTEM BASED ON A 4INUC SERVICE PRESSURE.
5. UNO. CW/HW PIPING SHALL BE 1/2".
6. PENTHOUSE CW/HW PIPING FROM BELOW.

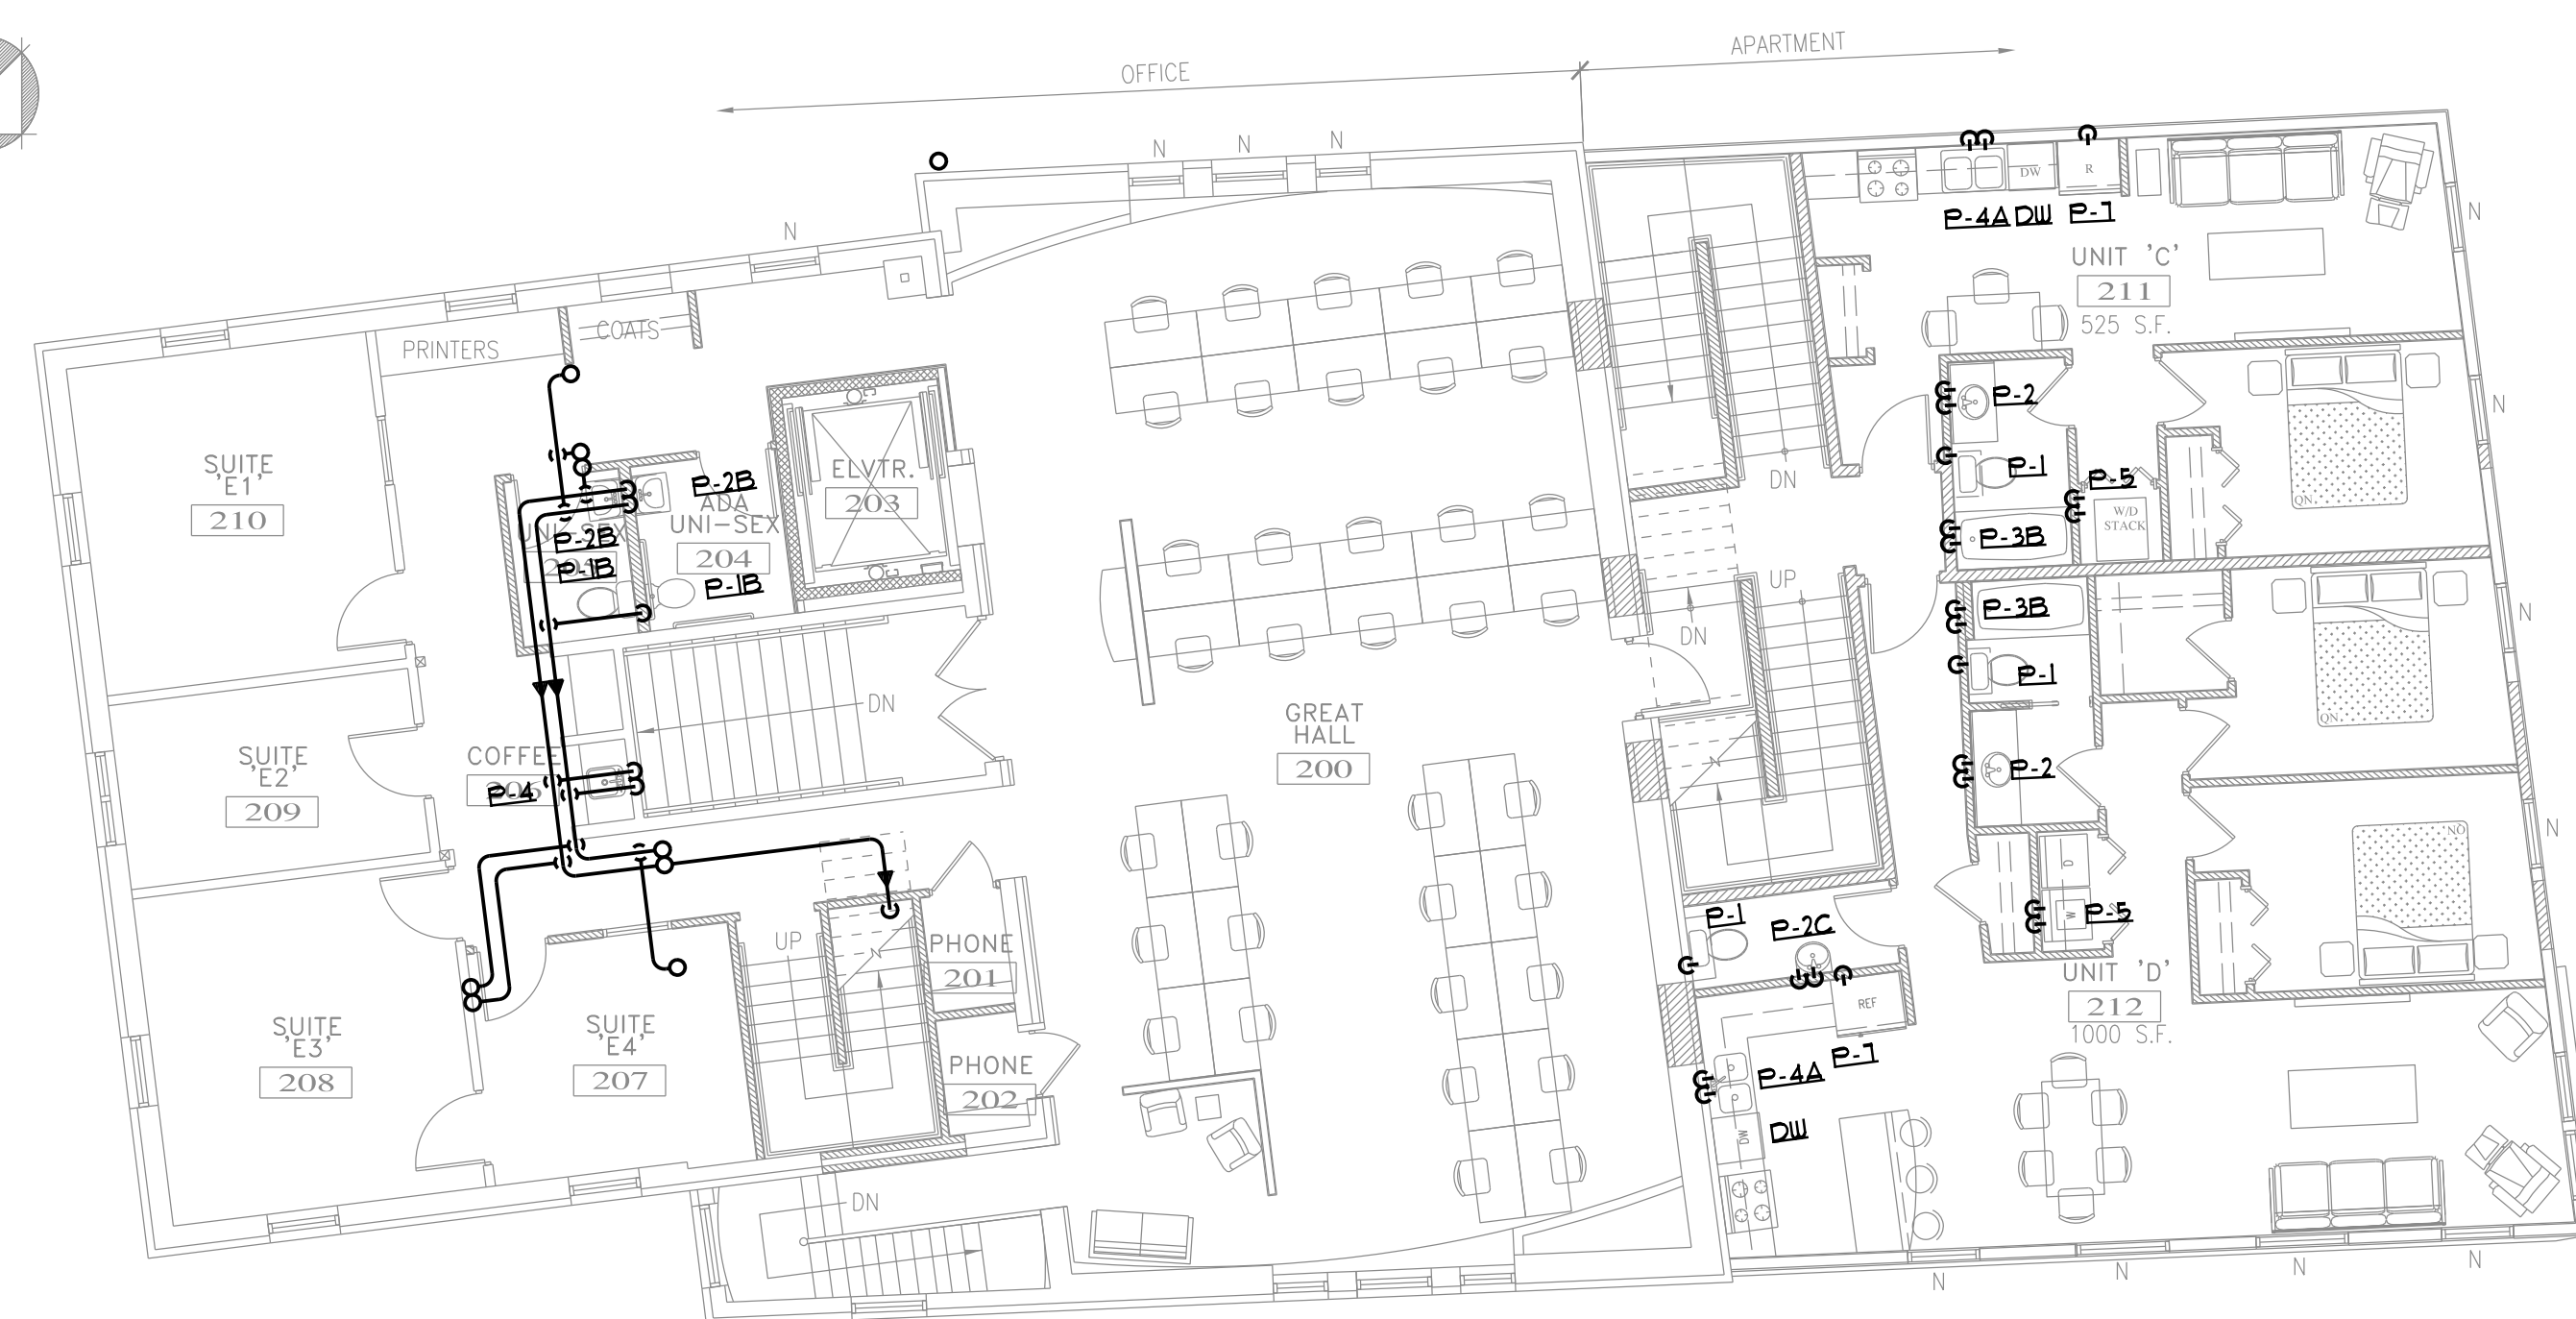


SECOND FLOOR DOMESTIC PLAN
SCALE - 1/8"=1'-0"

PLUMBING NOTES

1. REFER TO PLUMBING FIXTURES SCHEDULE FOR INDIVIDUAL FIXTURE PIPE SIZES.
2. ALL PIPING SHALL BE ROUTED IN FLOOR TRUSS SPACE WHEREVER POSSIBLE.
3. PROVIDE 3/4" CW, 1/2" HW & 1/2" RHU FOR EACH APT W/ APT SHUTOFFS AND SIZE 'A' WATER HAMMER ARRESTORS AT WATER HEATER.
4. NATURAL GAS PIPING SYSTEM BASED ON A 4INUC SERVICE PRESSURE.
5. UNO. CW/HW PIPING SHALL BE 1/2".
6. APT 'C' & APT 'D' CW/HW PIPING FROM BELOW, REFER TO M3.0.

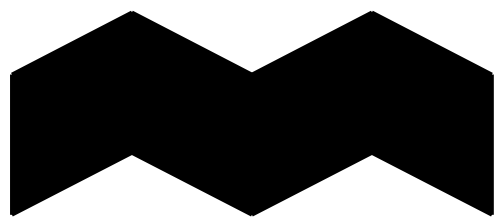

ALPHAarchitects
17 CHESTNUT STREET
PORTLAND, ME 04101
PHONE: 207.761.9500
FAX: 207.761.9595
design@alphaarchitects.com

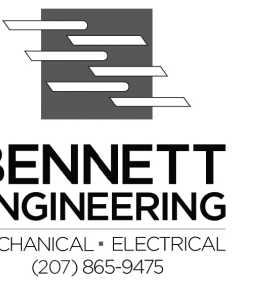

**BENNETT
ENGINEERING**
MECHANICAL • ELECTRICAL
(207) 866-9475

Station 415
415 Cumberland Avenue
Portland, ME. 04101

JOB: 16110

ISSUE DATE	
PRELIM	01-17-16
SFMO	-
CD's	-
REV. 1	-
REV. 2	-
PRINT	09-30-16

SECOND FLOOR &
MEZZANINE DOMESTIC
PLANS

M3.1

FOR PERMIT 09-30-16