


FIRST FLOOR SANITARY PLAN  
SCALE - 1/8"=1'-0"

PLUMBING NOTES

1. REFER TO PLUMBING FIXTURES SCHEDULE FOR INDIVIDUAL FIXTURE PIPE SIZES.
2. ALL PIPING SHALL BE ROUTED IN FLOOR TRUSS SPACE WHEREVER POSSIBLE.
3. UNLESS INDICATED OTHERWISE, CONNECT 3/4" HP. CONDENSATE TO NEAREST LAVATORY THRU TAILPIECE, SEE DETAIL.

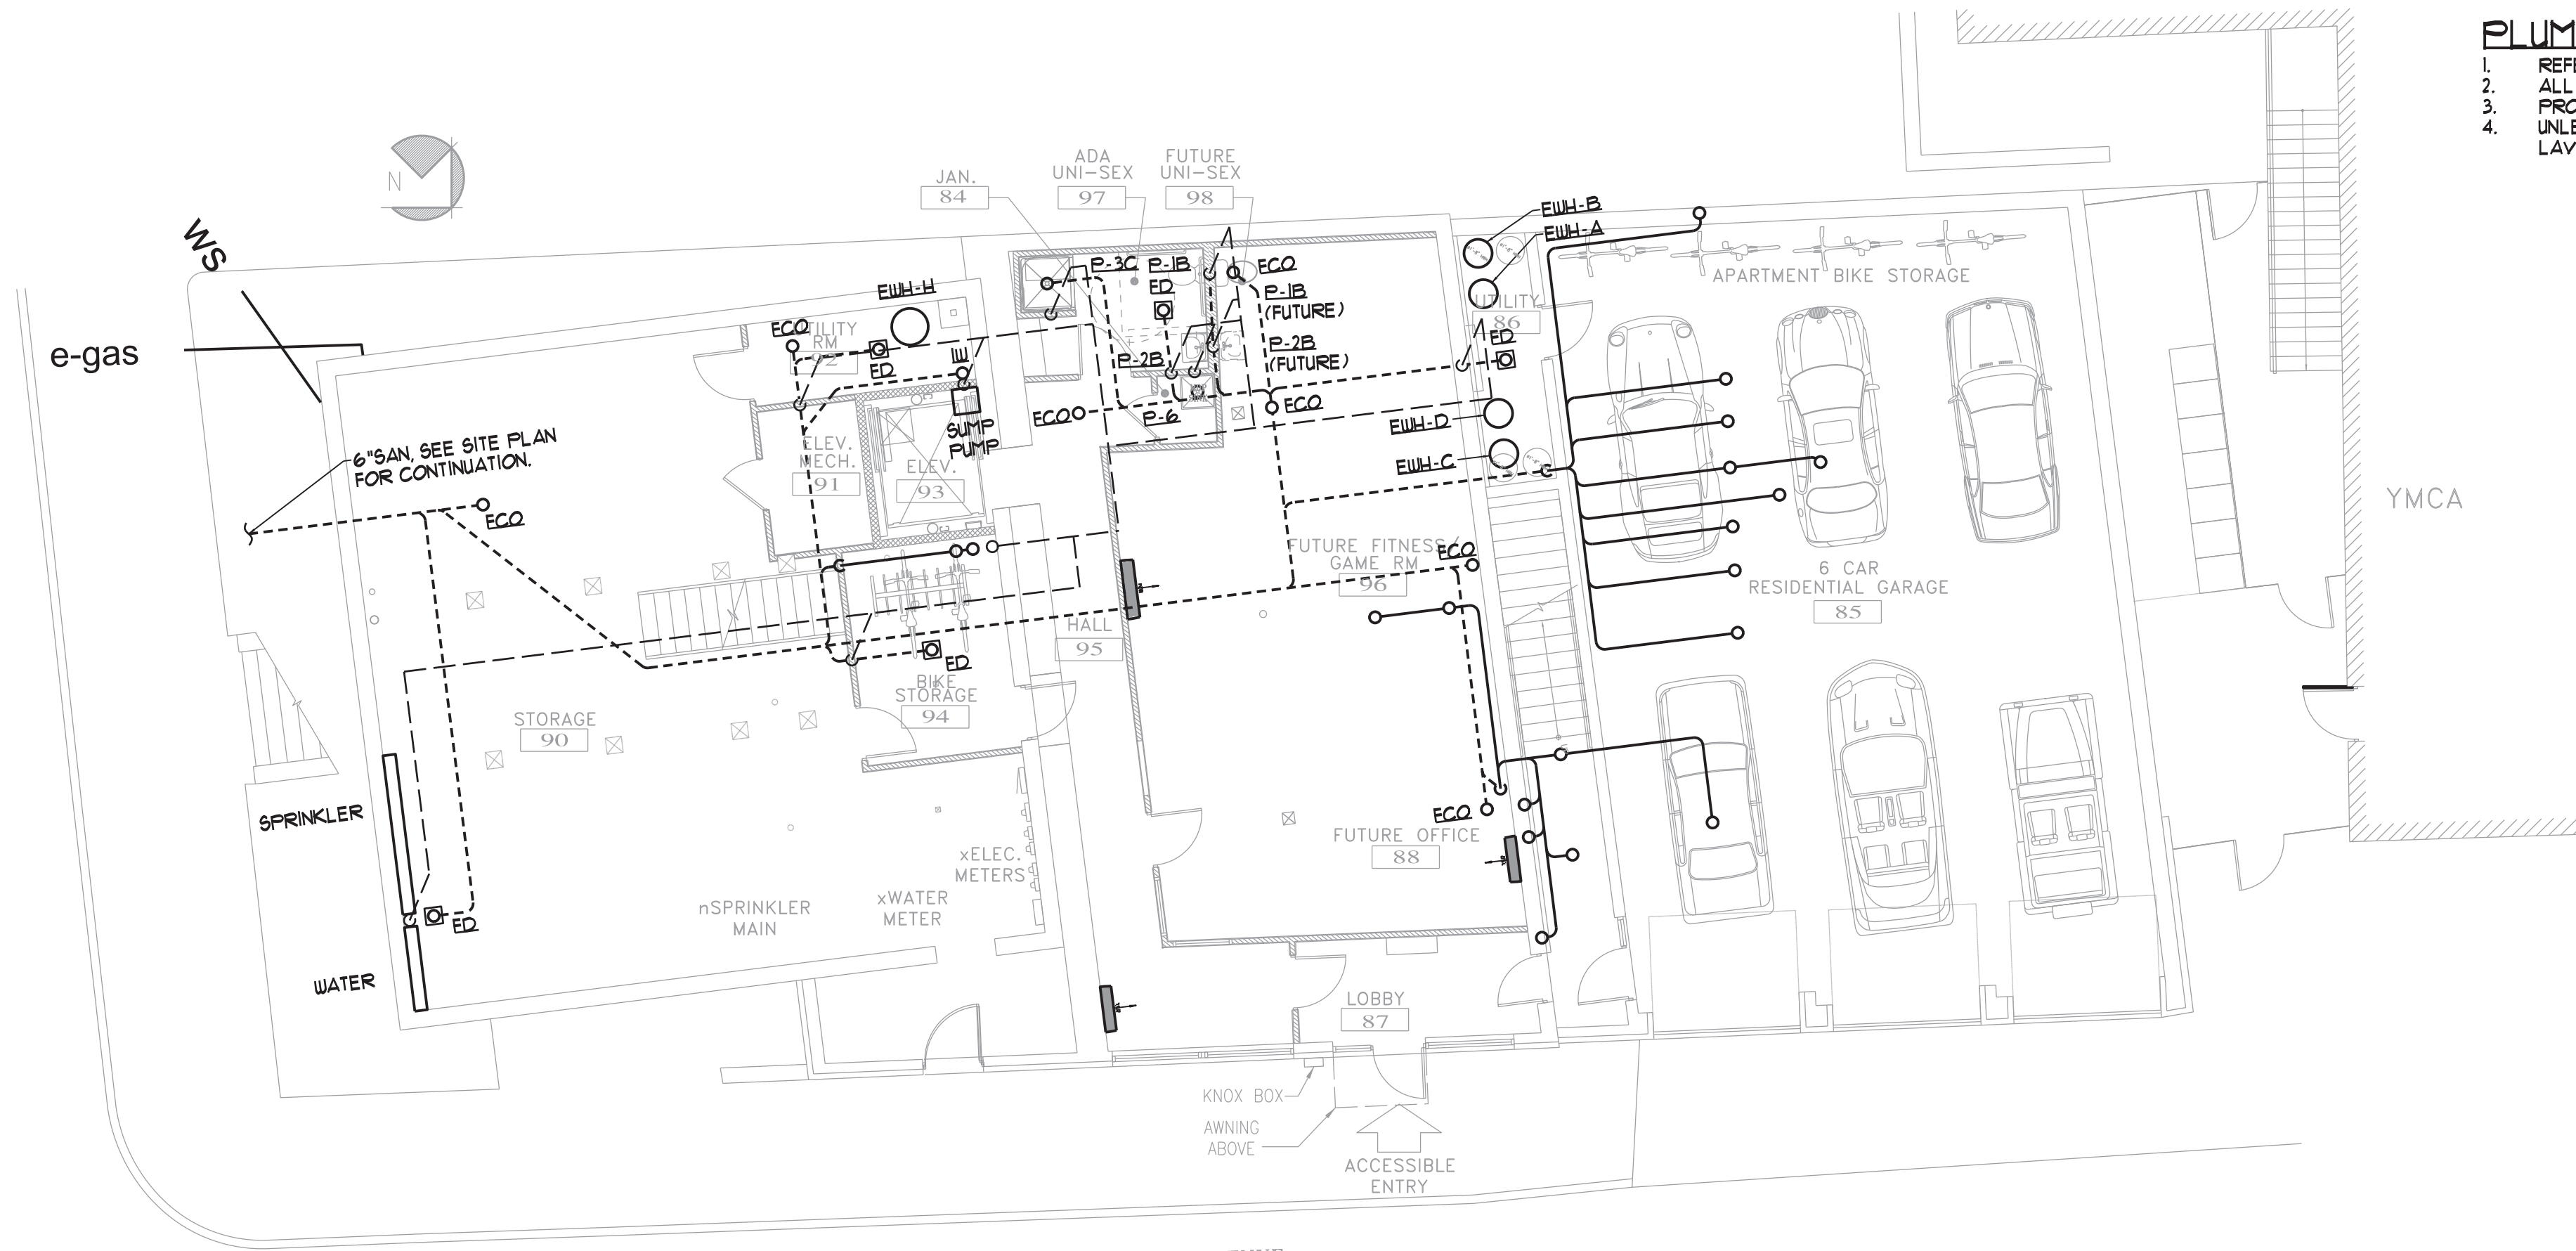

LOWER LEVEL SANITARY PLAN  
SCALE - 1/8"=1'-0"

PLUMBING NOTES

1. REFER TO PLUMBING FIXTURES SCHEDULE FOR INDIVIDUAL FIXTURE PIPE SIZES.
2. ALL PIPING SHALL BE ROUTED IN FLOOR TRUSS SPACE WHEREVER POSSIBLE.
3. PROVIDE A CLEANOUT AT THE BASE OF ALL SANITARY RISERS PER CODE.
4. UNLESS INDICATED OTHERWISE, CONNECT 3/4" HP. CONDENSATE TO NEAREST LAVATORY THRU TAILPIECE, SEE DETAIL.



ALPHAarchitects  
17 CHESTNUT STREET  
PORTLAND, ME 04101  
PHONE: 207.761.9500  
FAX: 207.761.9595  
design@alphaarchitects.com



**Station 415**  
415 Cumberland Avenue  
Portland, ME. 04101

JOB: 16110

ISSUE DATE	
PRELIM	01-17-16
SFMO	-
CD's	-
REV. 1	-
REV. 2	-
PRINT	09-30-16

LOWER LEVEL & FIRST FLOOR SANITARY PLANS

**M2.0**

FOR PERMIT 09-30-16