


GROUND FLOOR, OFFICE SPACE
SEPARATE BLDG. FIRE ALARM PLAN
SCALE: 1/4"=1'-0"

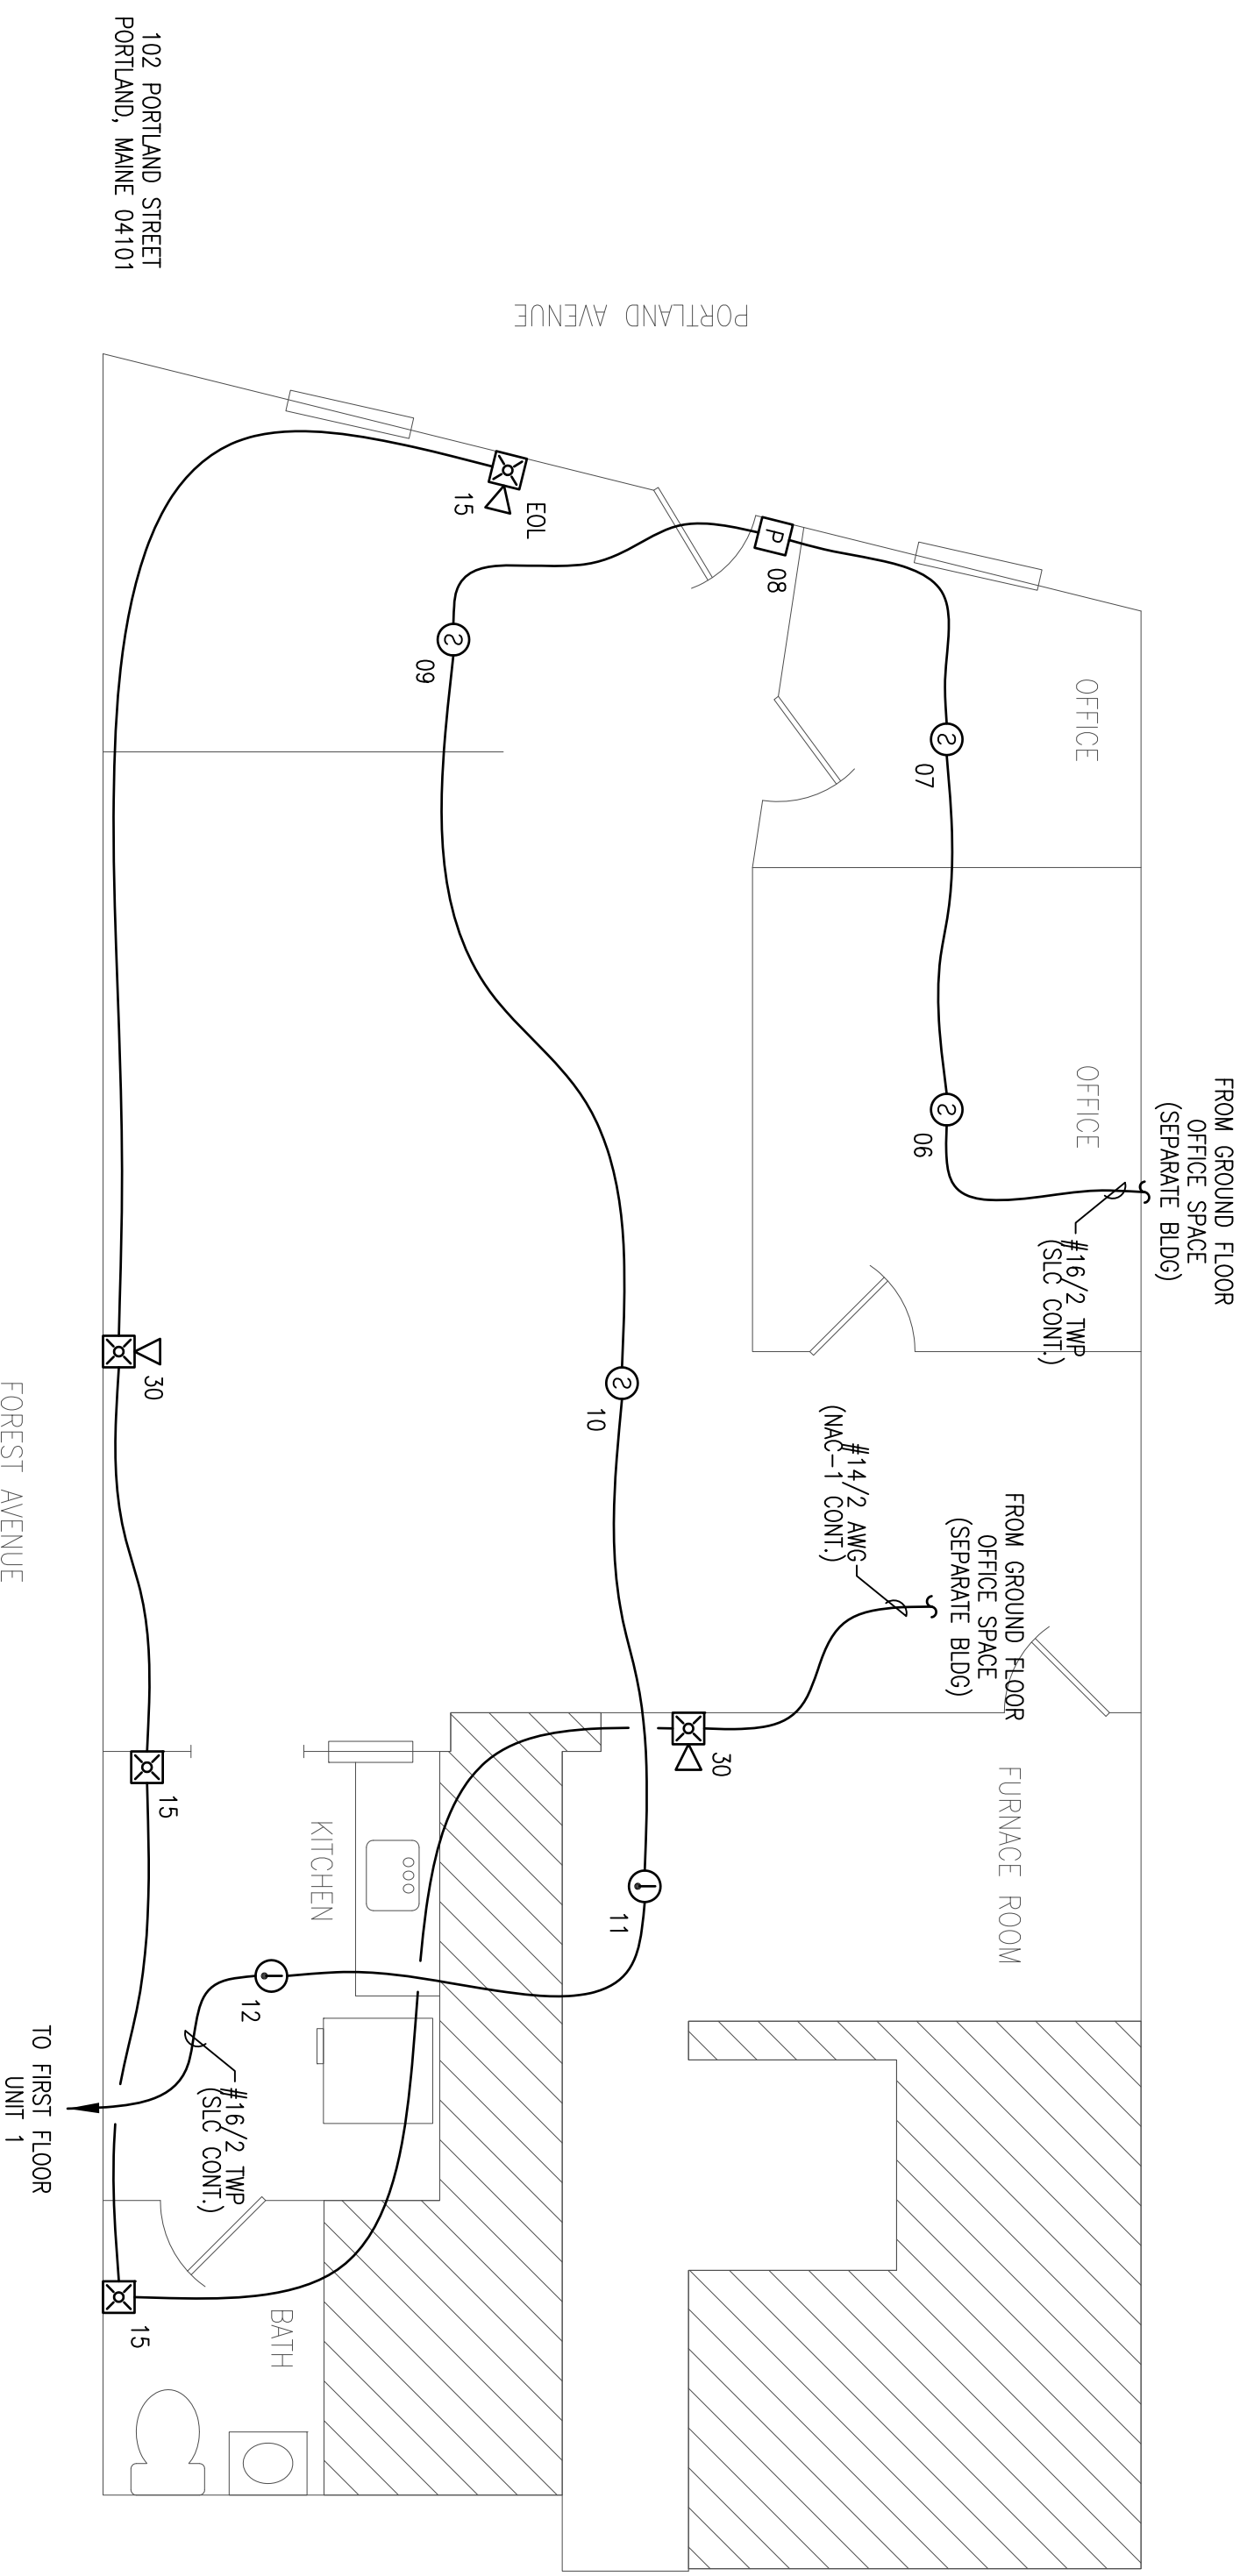

GROUND FLOOR, OFFICE SPACE
FIRE ALARM PLAN
SCALE: 1/4"=1'-0"

RESERVED FOR CITY STAMP

REVISION	DESCRIPTION	DATE
0	ISSUED FOR REVIEW & APPROVAL	11/17/2014

CUNNINGHAM
Security Systems
10 Princes Point Road, Yarmouth, Maine 04096
Office: 207.846.3350 • Fax: 207.846.6080

**120 PORTLAND STREET
PORTLAND, MAINE 04101**

GROUND FLOOR FIRE ALARM PLAN

DRAWN	JPB UNICAD JOB #14726
CHECKED	WAYNE B. HAWK NCEIT IV 90496
DATE	11/17/2014
REVISION	0
SCALE	1/4"=1'-0"

UNICAD Inc.
575 W. 40th St.
Portland, ME 04102
Office: 207.846.6110
www.unicad.me

UNICAD
Fire Alarm Design & Drafting Services

FA-3