



FIRST FLOOR, UNIT 6
FIRE ALARM PLAN
SCALE: 1/4"=1'-0"

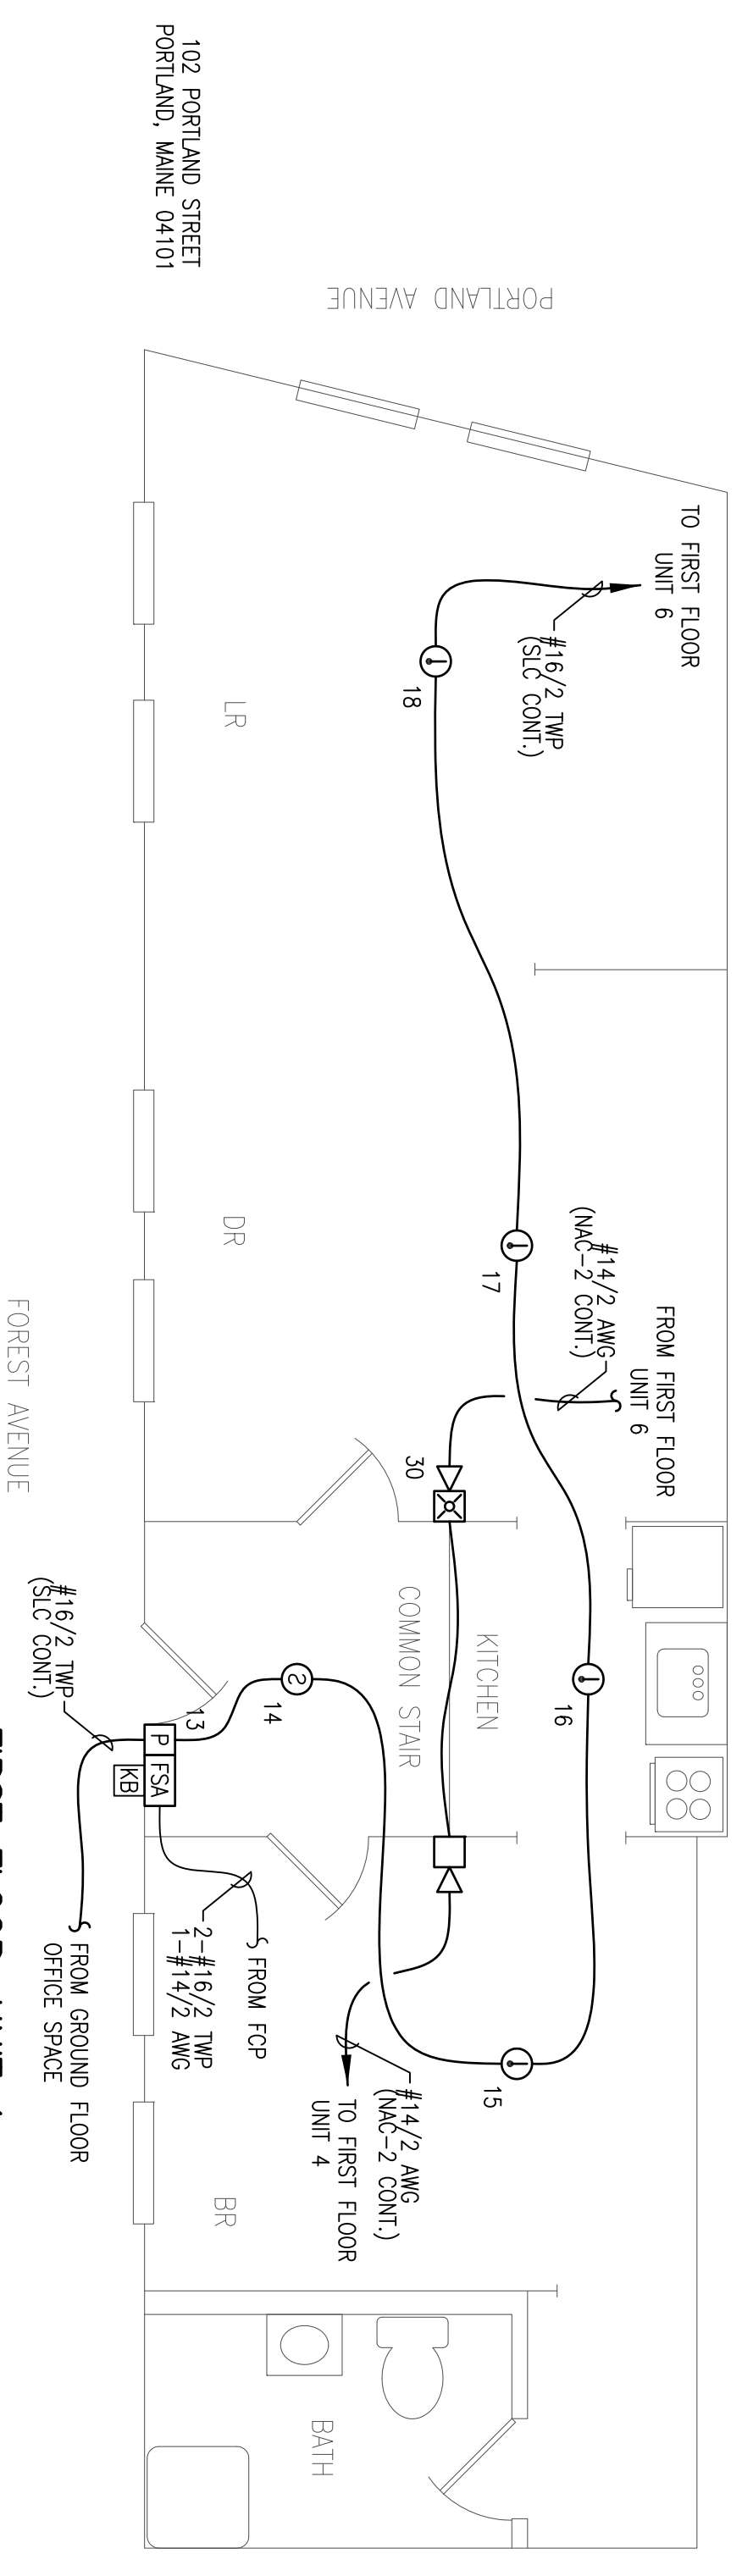

FIRST FLOOR, UNIT 1
FIRE ALARM PLAN
SCALE: 1/4"=1'-0"

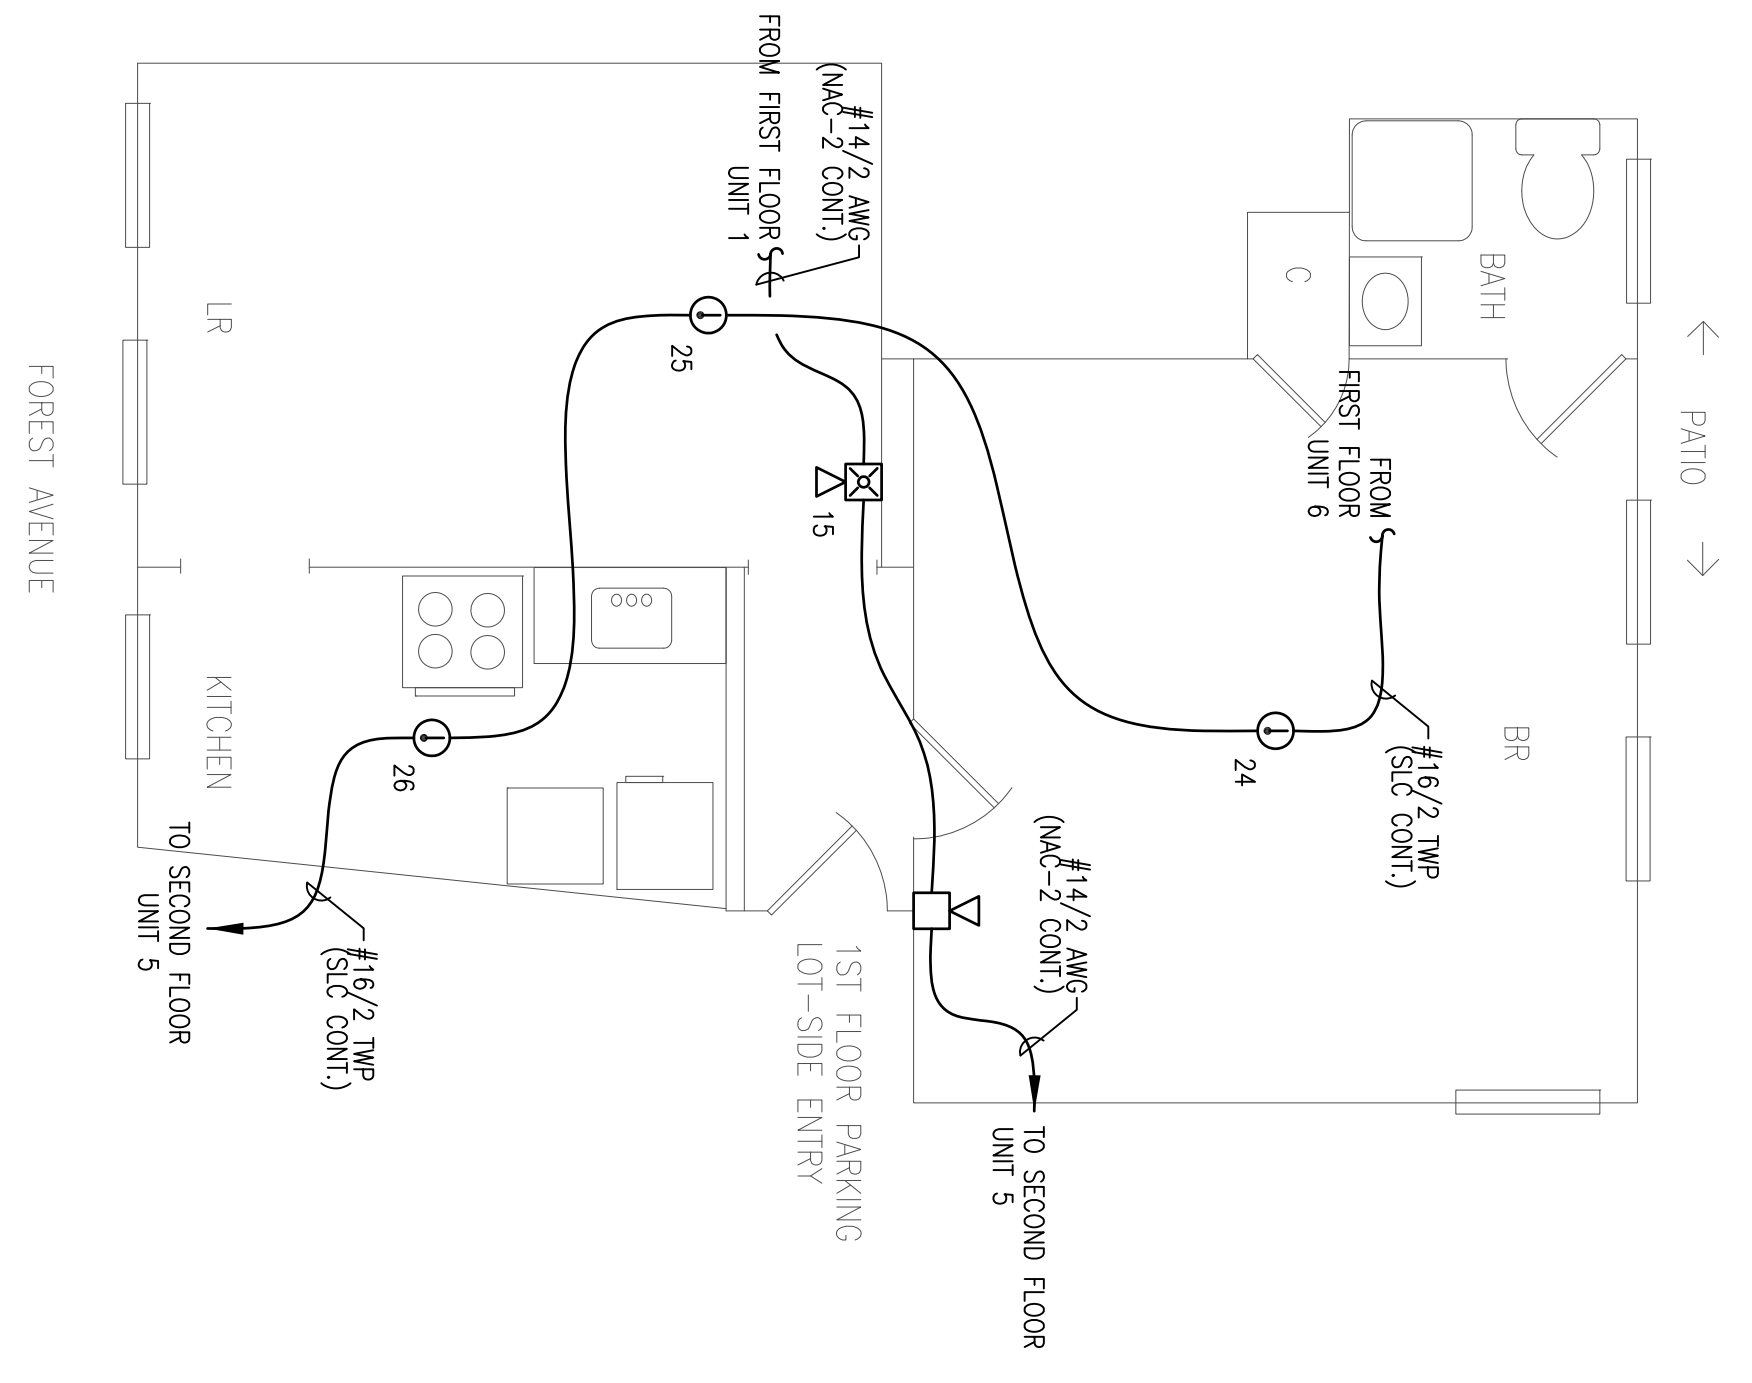

FIRST FLOOR, UNIT 4
FIRE ALARM PLAN
SCALE: 1/4"=1'-0"

RESERVED FOR CITY STAMP

REVISION	DESCRIPTION	DATE
0	ISSUED FOR REVIEW & APPROVAL	11/17/2014

CUNNINGHAM
Security Systems
10 Princes Point Road, Yarmouth, Maine 04096
Office: 207.846.3350 • Fax: 207.846.6080

120 PORTLAND STREET
PORTLAND, MAINE 04101

FIRST FLOOR FIRE ALARM PLAN

DRAWN	JPB
CHECKED	WAXIE B. HAWES
DATE	11/17/2014
REVISION	0
SCALE	1/4"=1'-0"

UNIGAD Inc.
Fire Alarm Design & Drafting Services
5754 W. 40th St.
Portland, ME 04103
Office: 800.585.6110
www.unigad.me

FA-4