

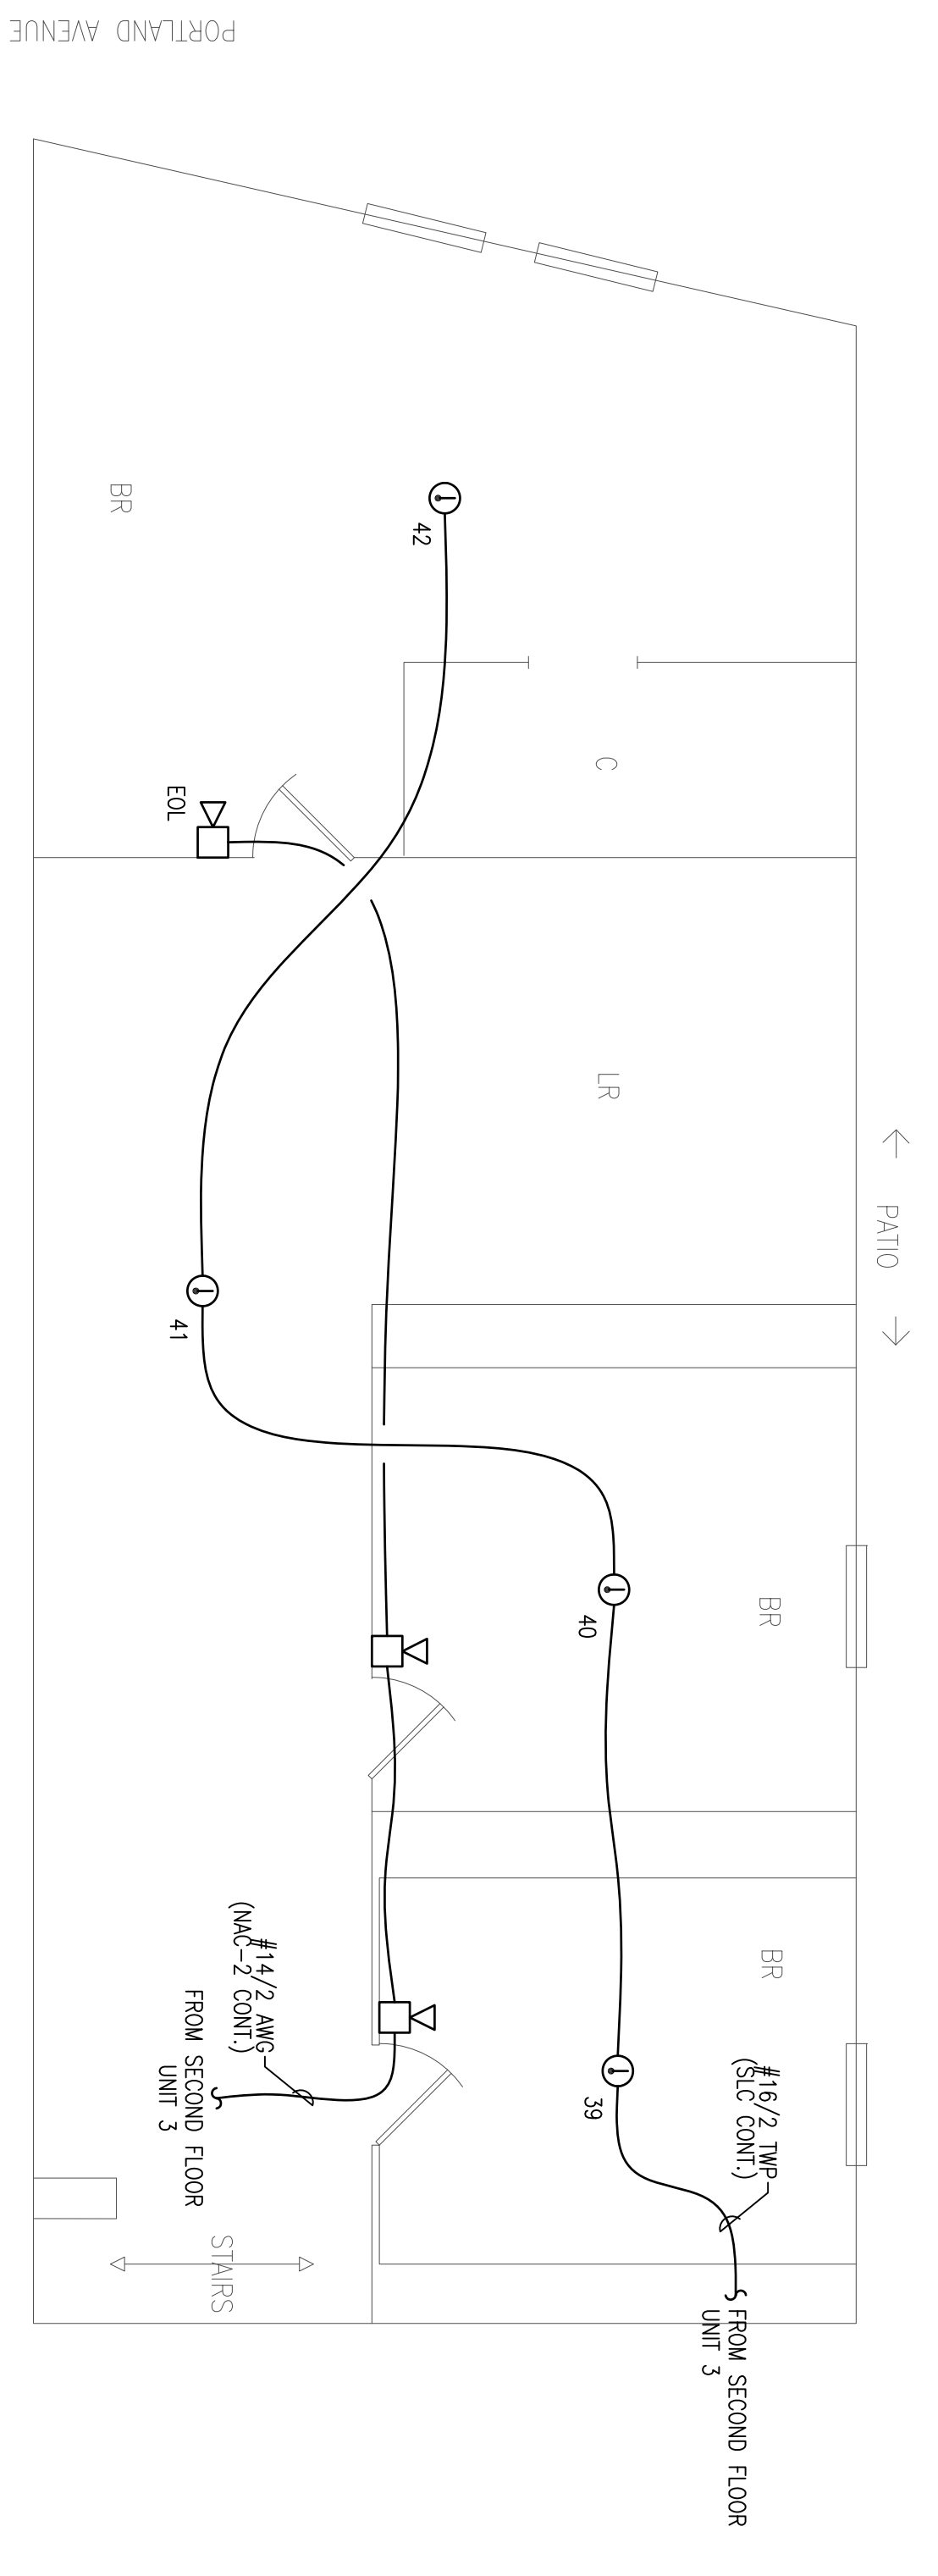




102 PORTLAND STREET
 PORTLAND, MAINE 04101

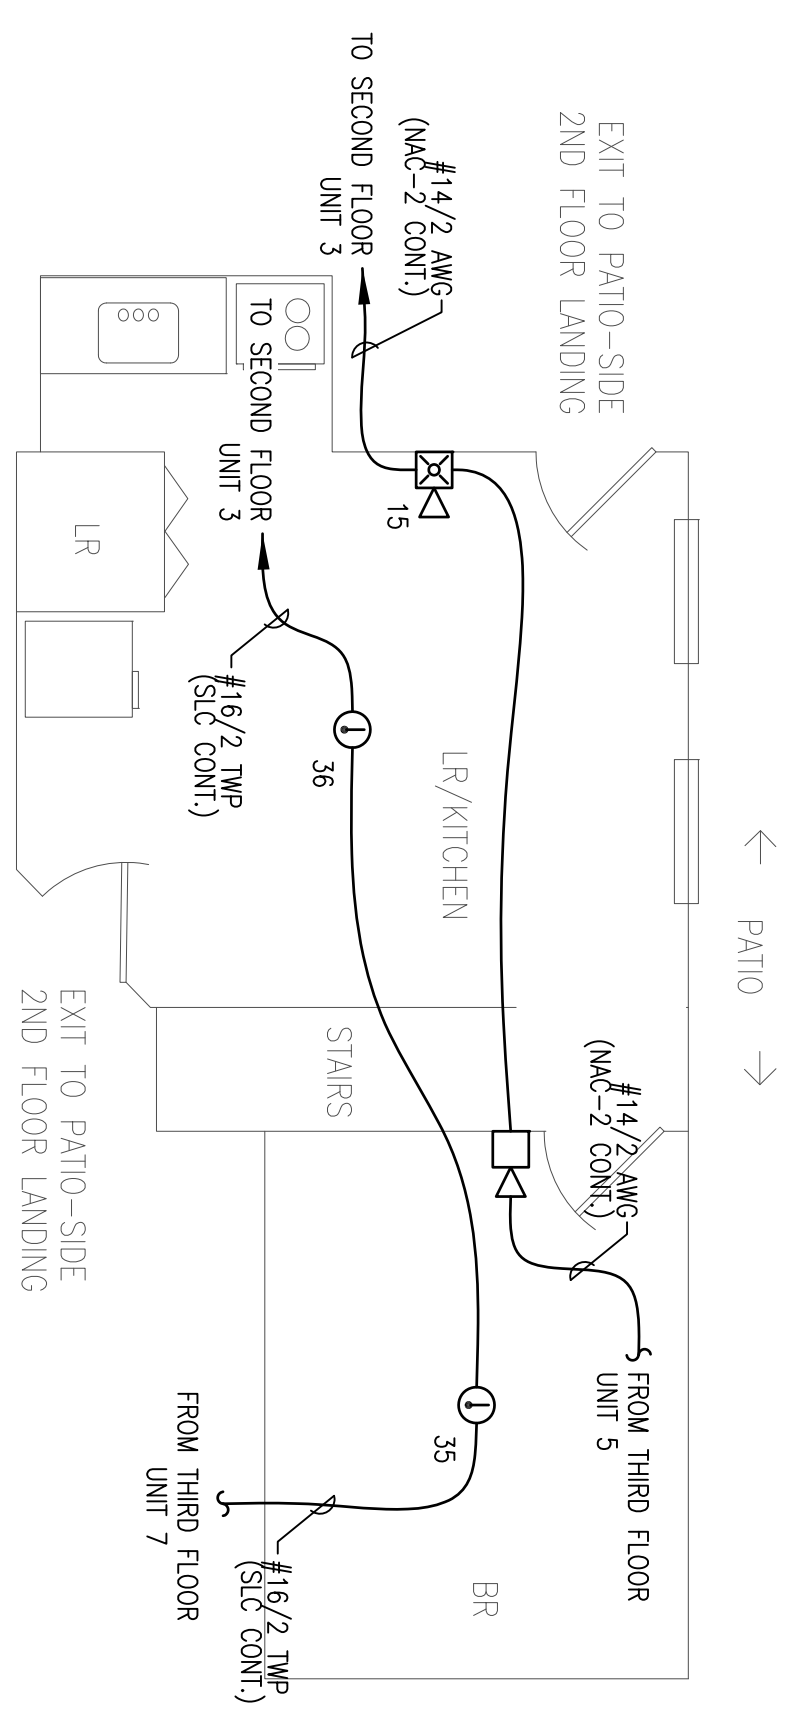

SECOND & THIRD FLOOR, UNIT 3
 FIRE ALARM PLAN
 SCALE: 1/4"=1'-0"

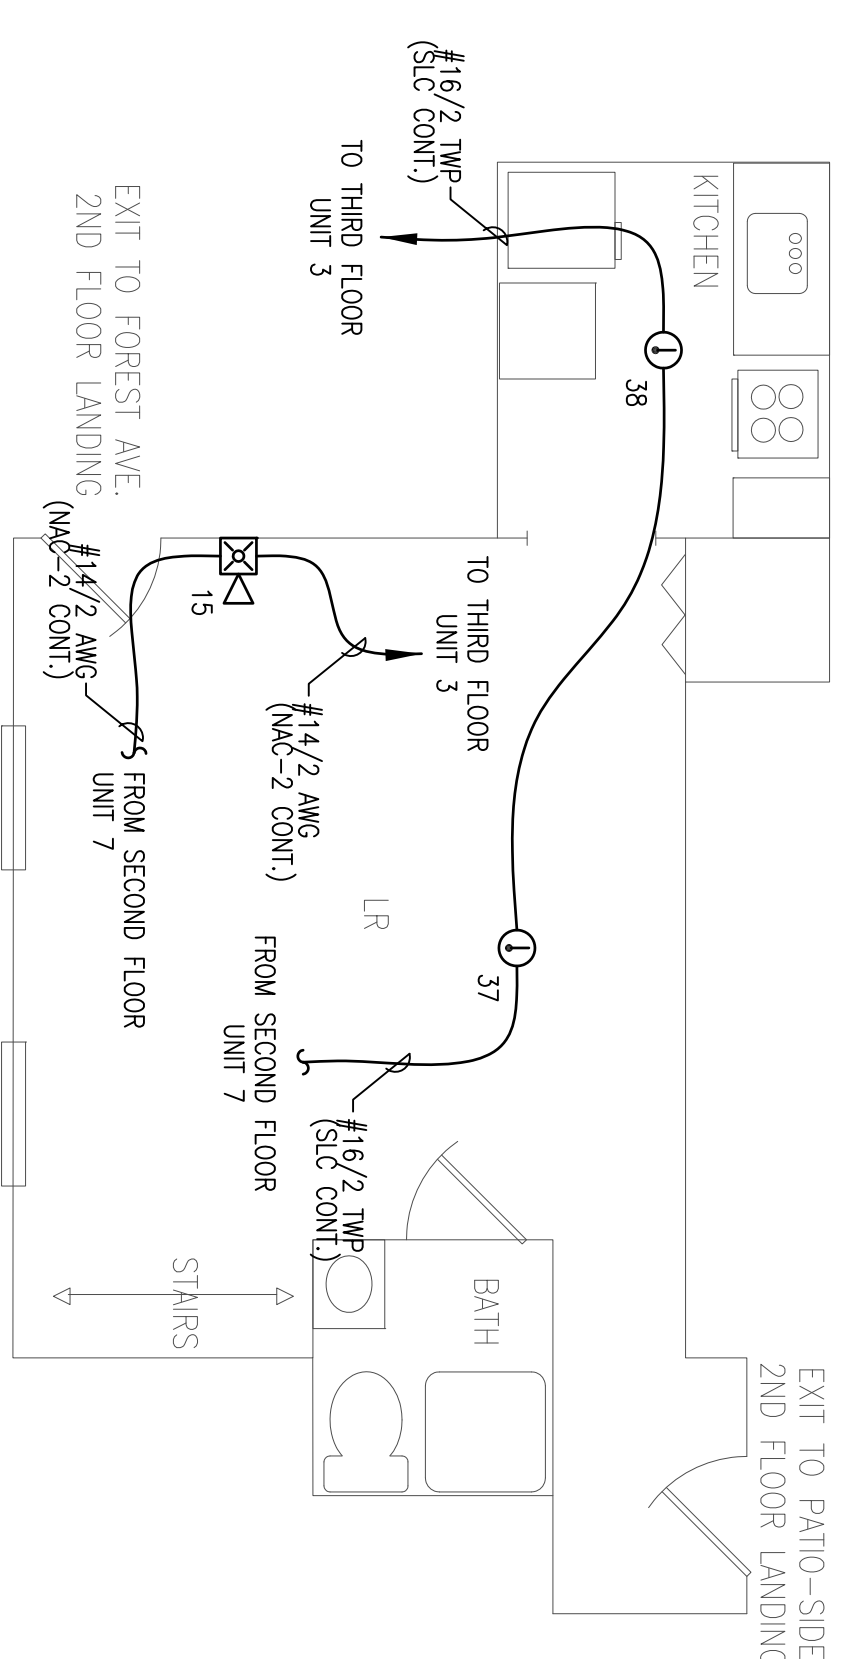

SECOND & THIRD FLOOR, UNIT 7
 FIRE ALARM PLAN
 SCALE: 1/4"=1'-0"

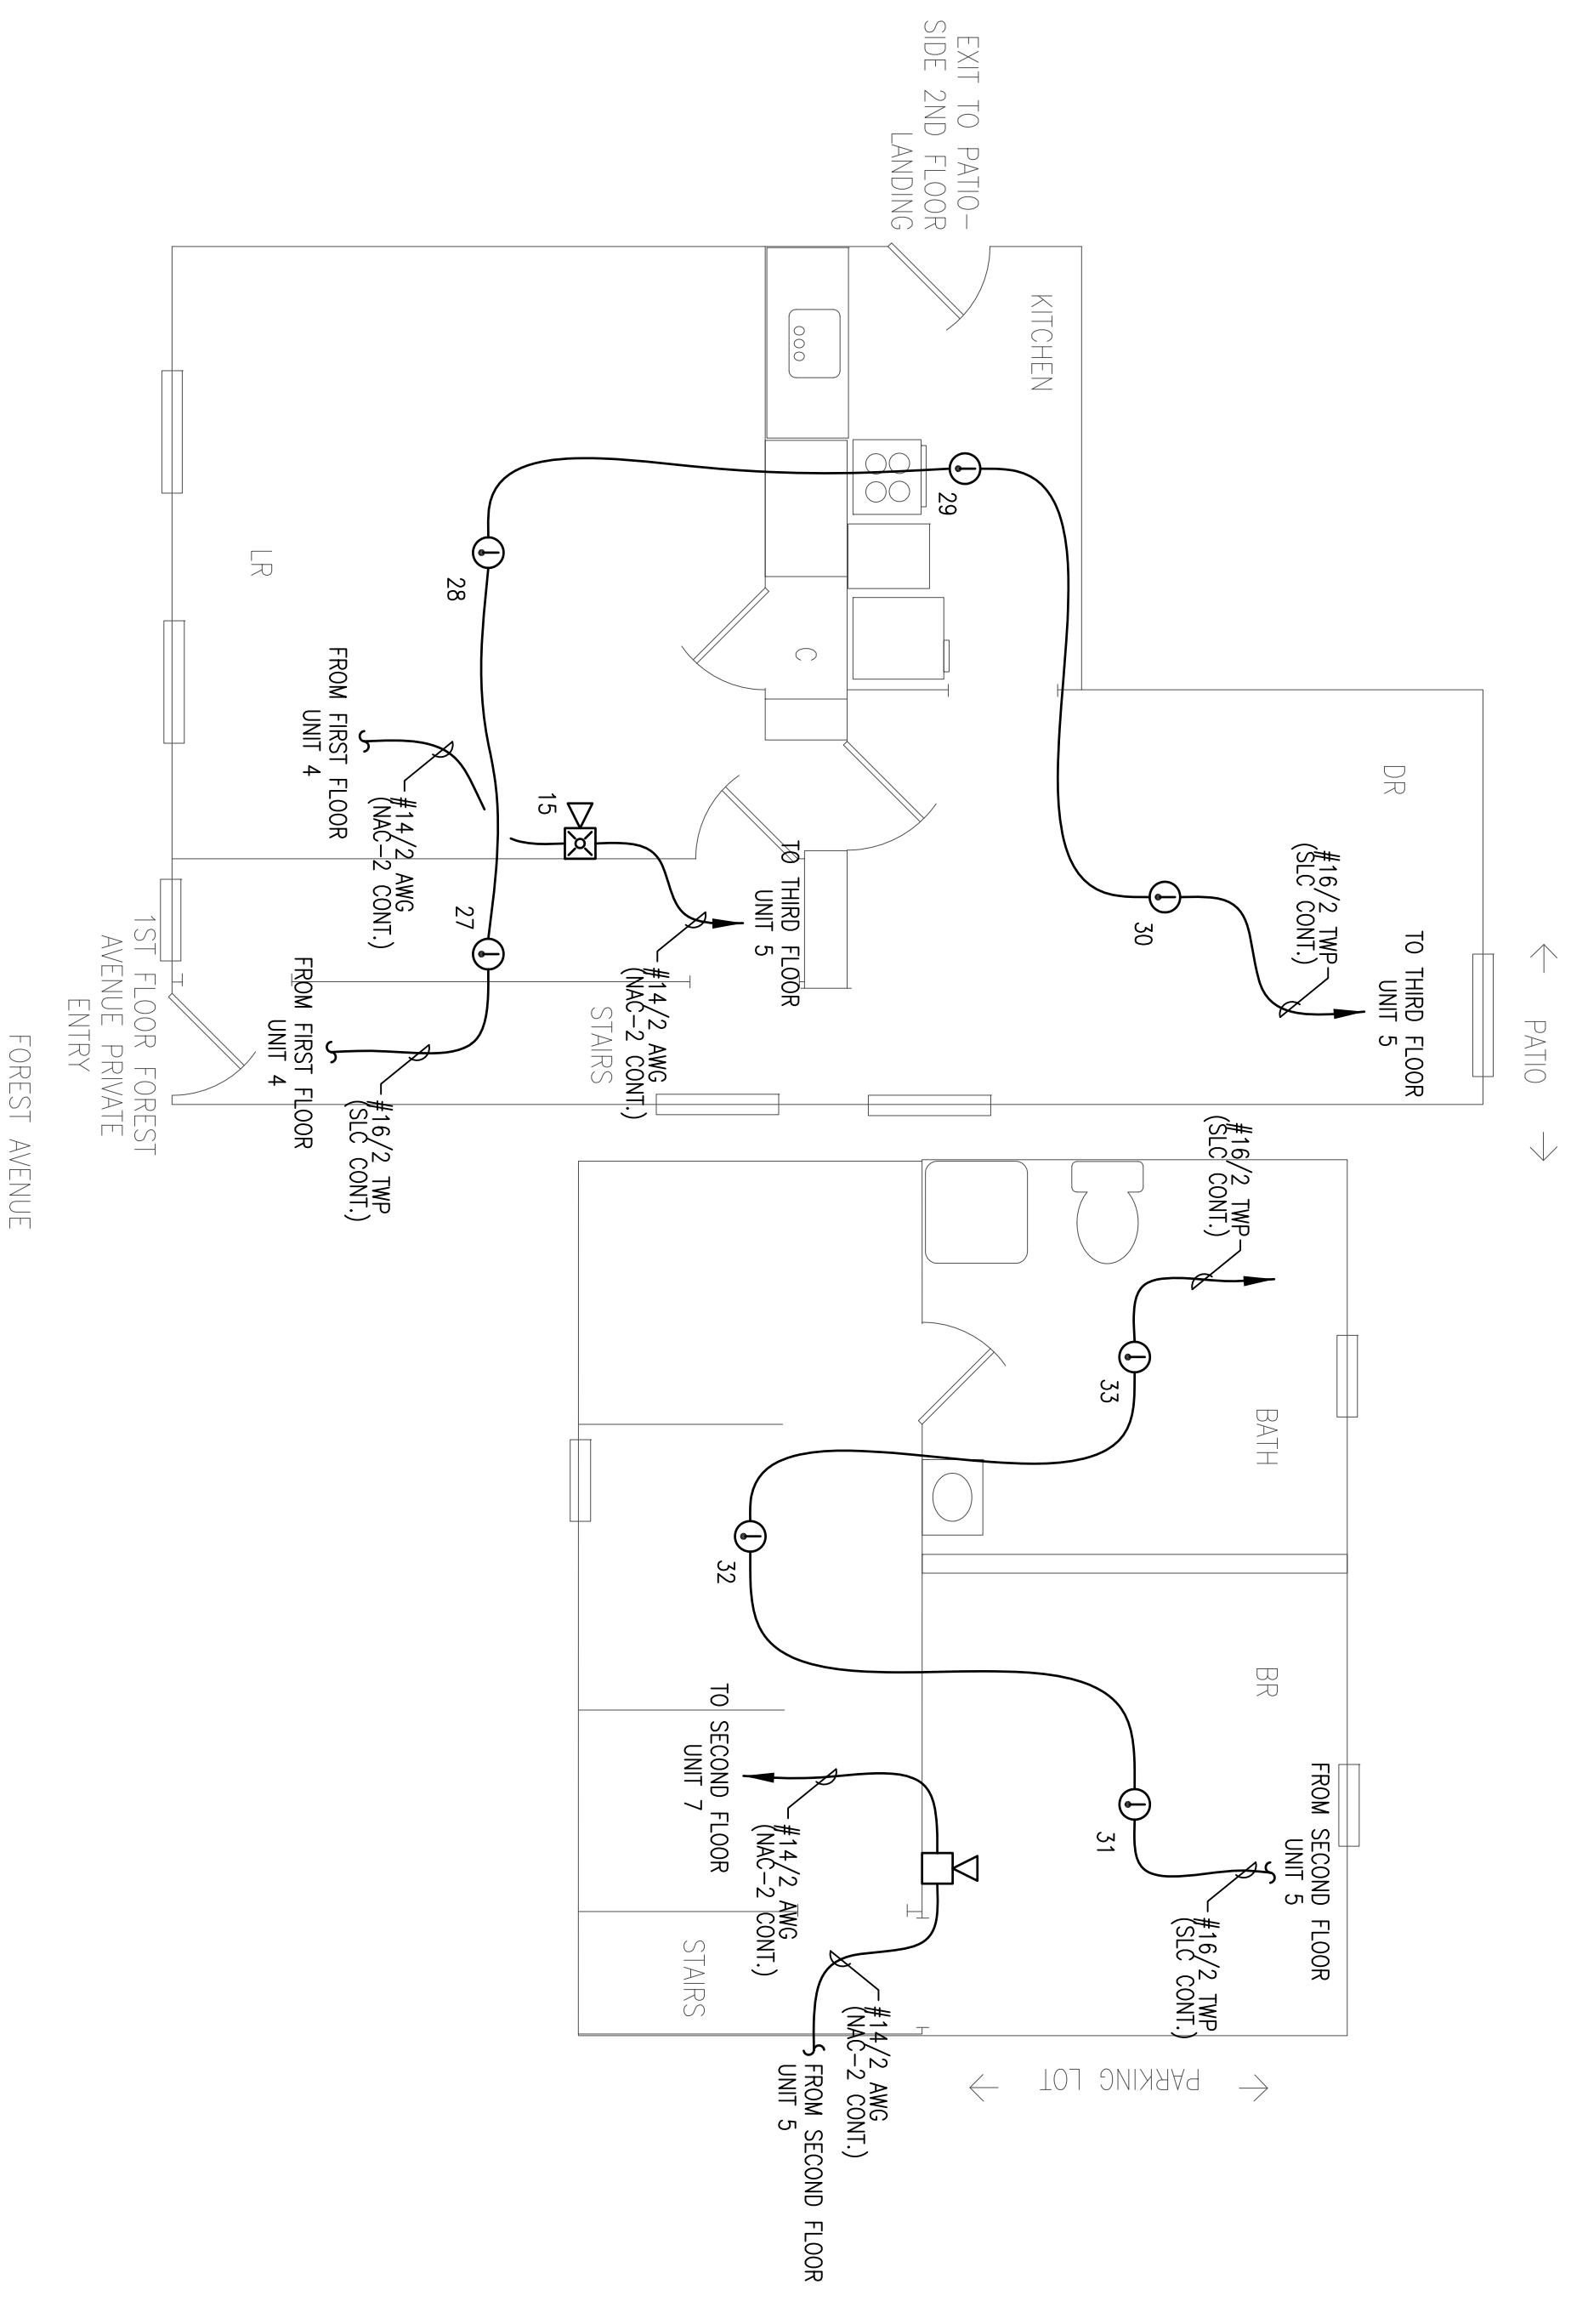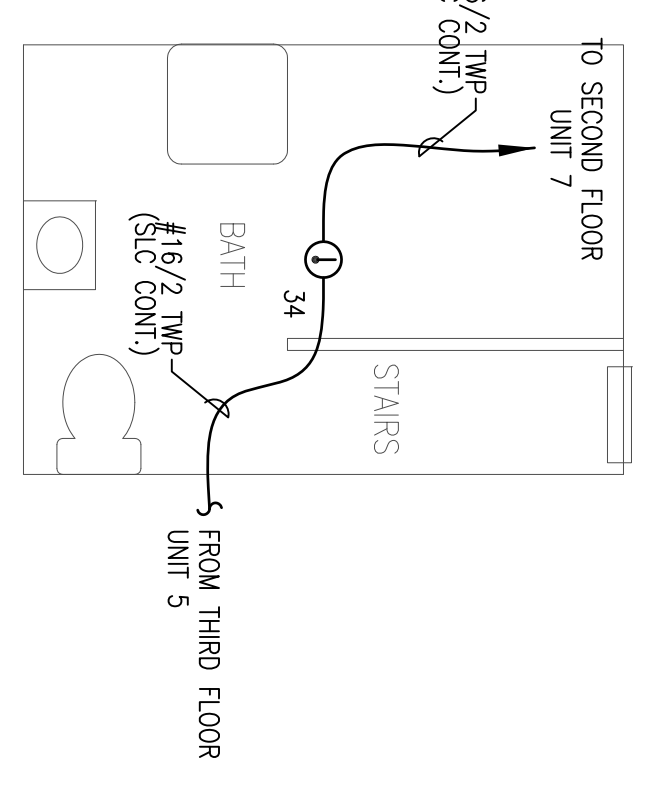

SECOND & THIRD FLOOR, UNIT 5
 FIRE ALARM PLAN
 SCALE: 1/4"=1'-0"

RESERVED FOR CITY STAMP

REVISION	DESCRIPTION	DATE
0	ISSUED FOR REVIEW & APPROVAL	11/17/2014

CUNNINGHAM
 Security Systems
 10 Princes Point Road, Yarmouth, Maine 04096
 Office: 207.846.3350 • Fax: 207.846.6080

120 PORTLAND STREET
 PORTLAND, MAINE 04101
SECOND & THIRD FLOOR FIRE ALARM PLAN

UNIGAD Inc.
 Fire Alarm Design & Drafting Services
 574 W. 40th St.
 Portland, ME 04102
 Office: 603.863.6110
 www.unigad.com

DRWN	JPB	UNIGAD JOB #14726
CHECKED	WYNNE B. JAMES	NCEIT IV 90496
DATE	11/17/2014	
REVISION	0	
SCALE	1/4"=1'-0"	

FA-5