




**BASEMENT**

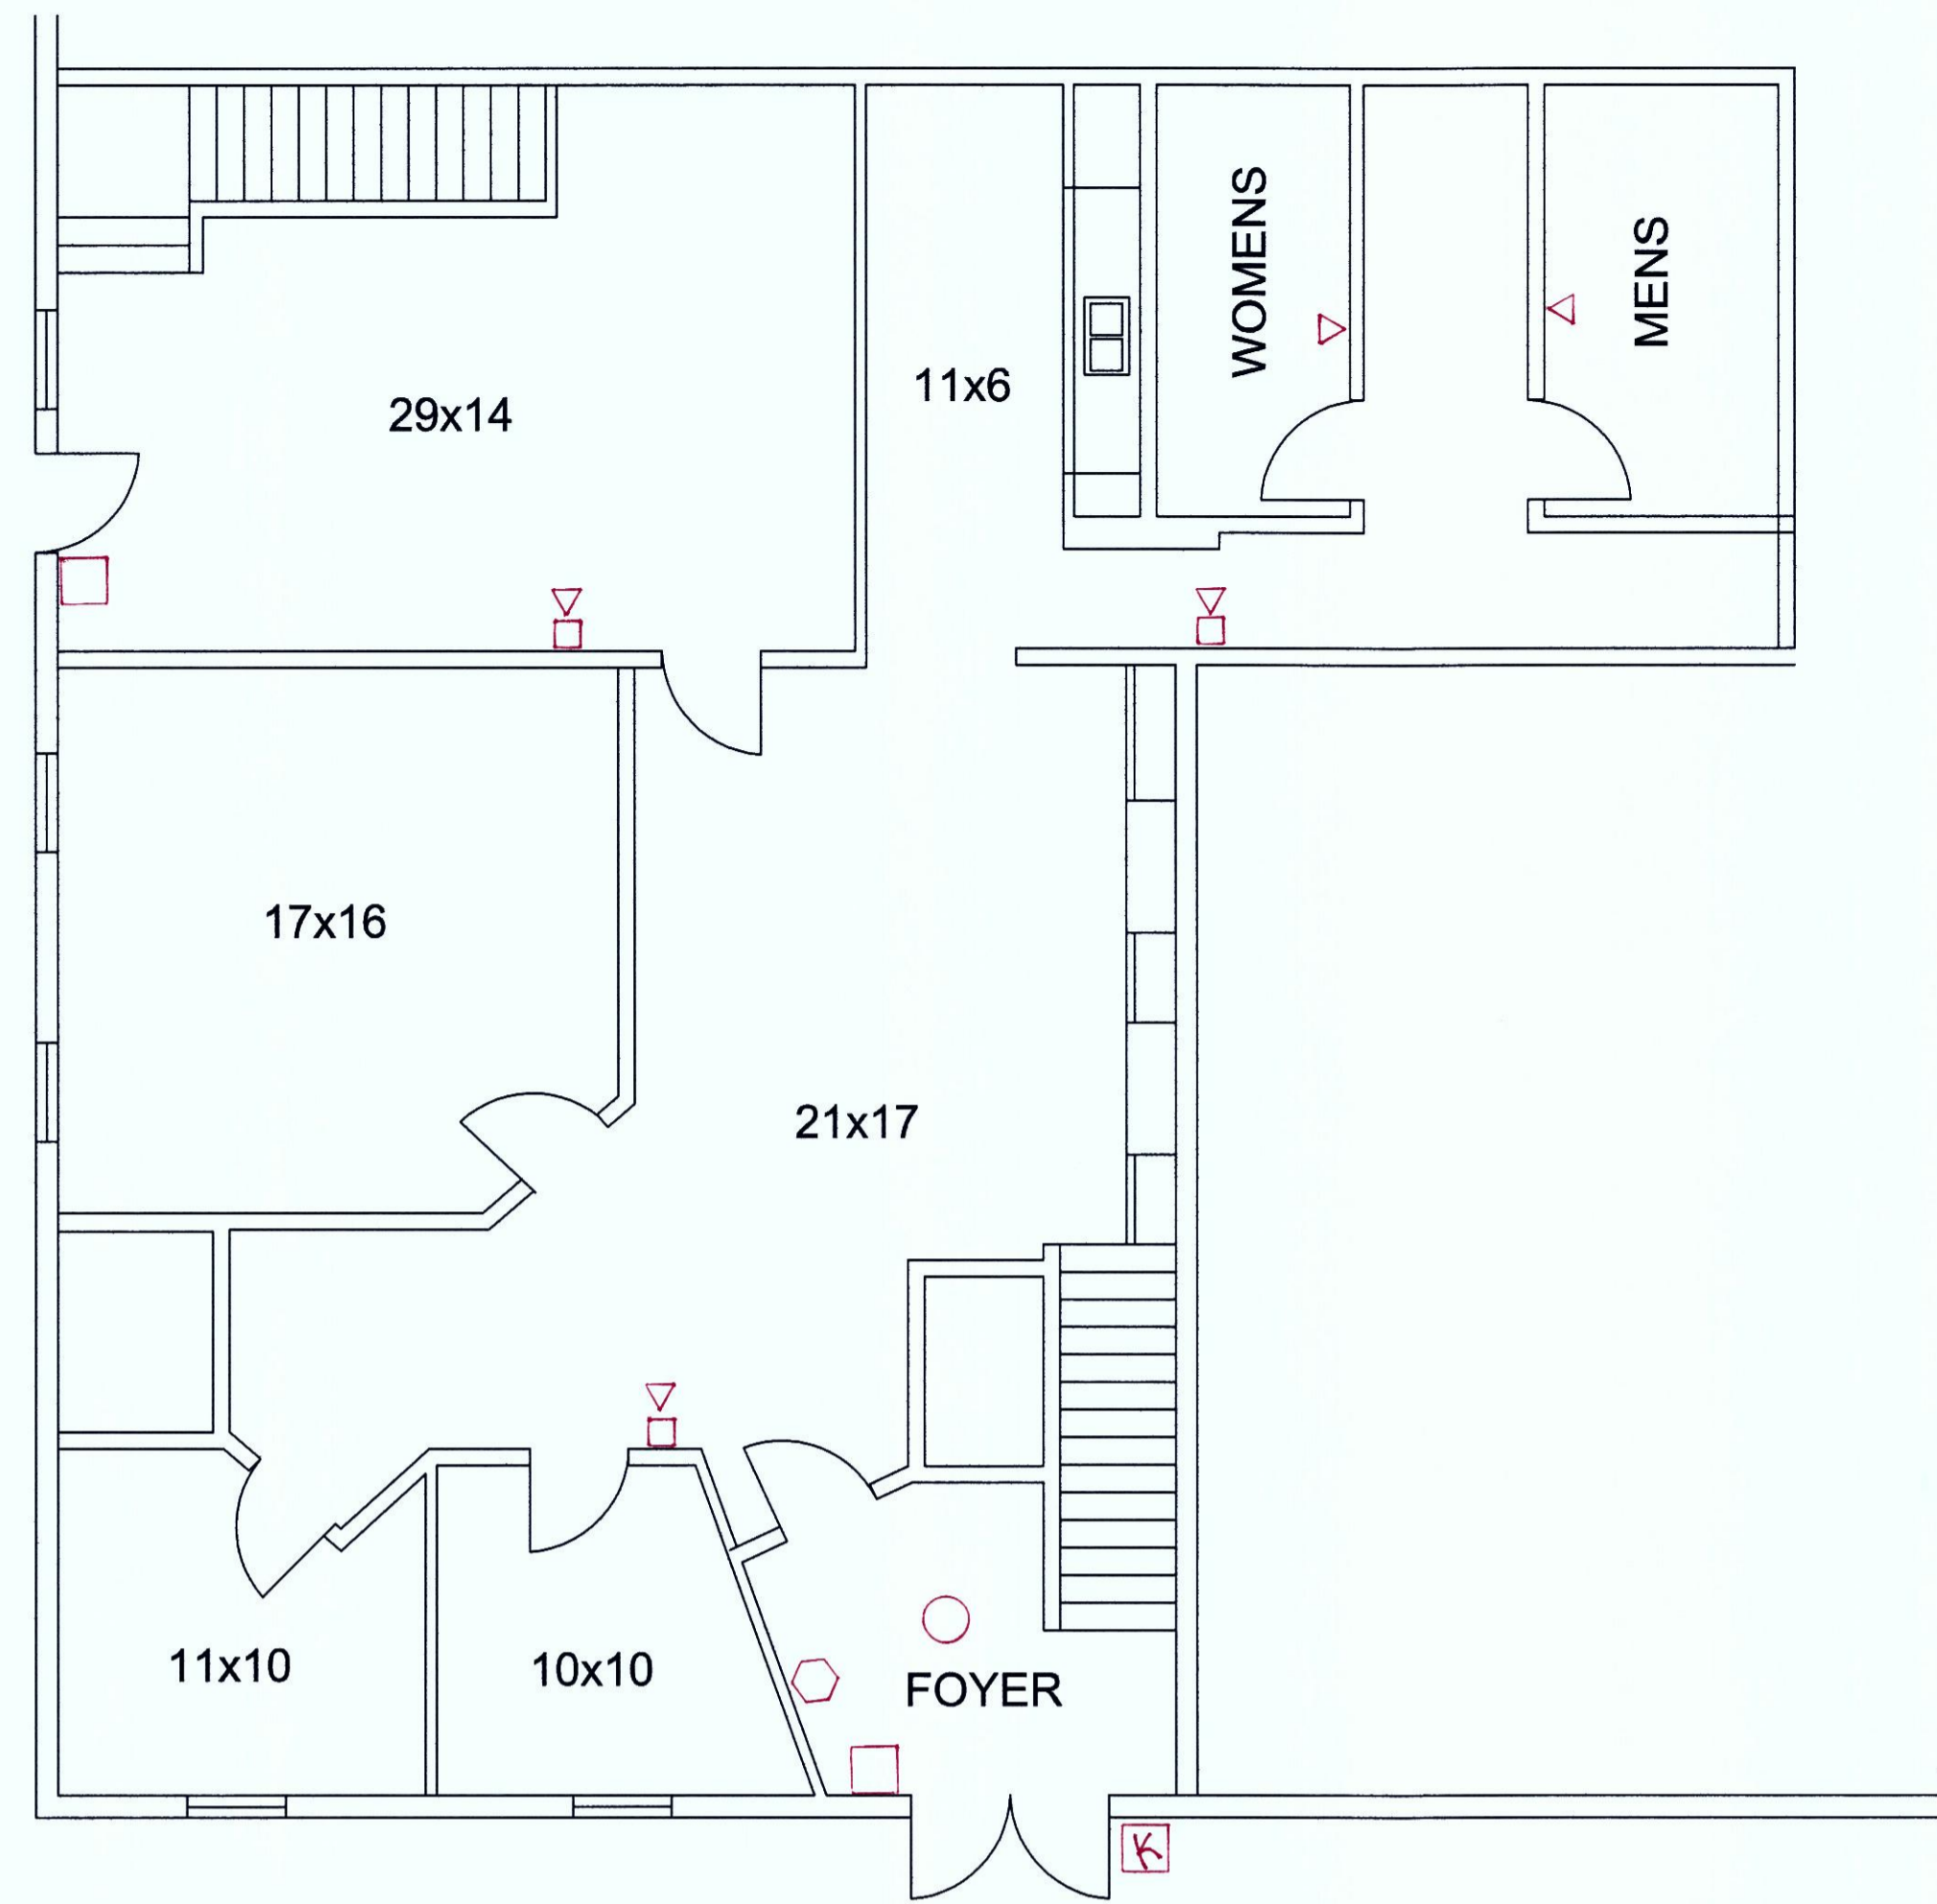

**FIRST FLOOR P LAN**

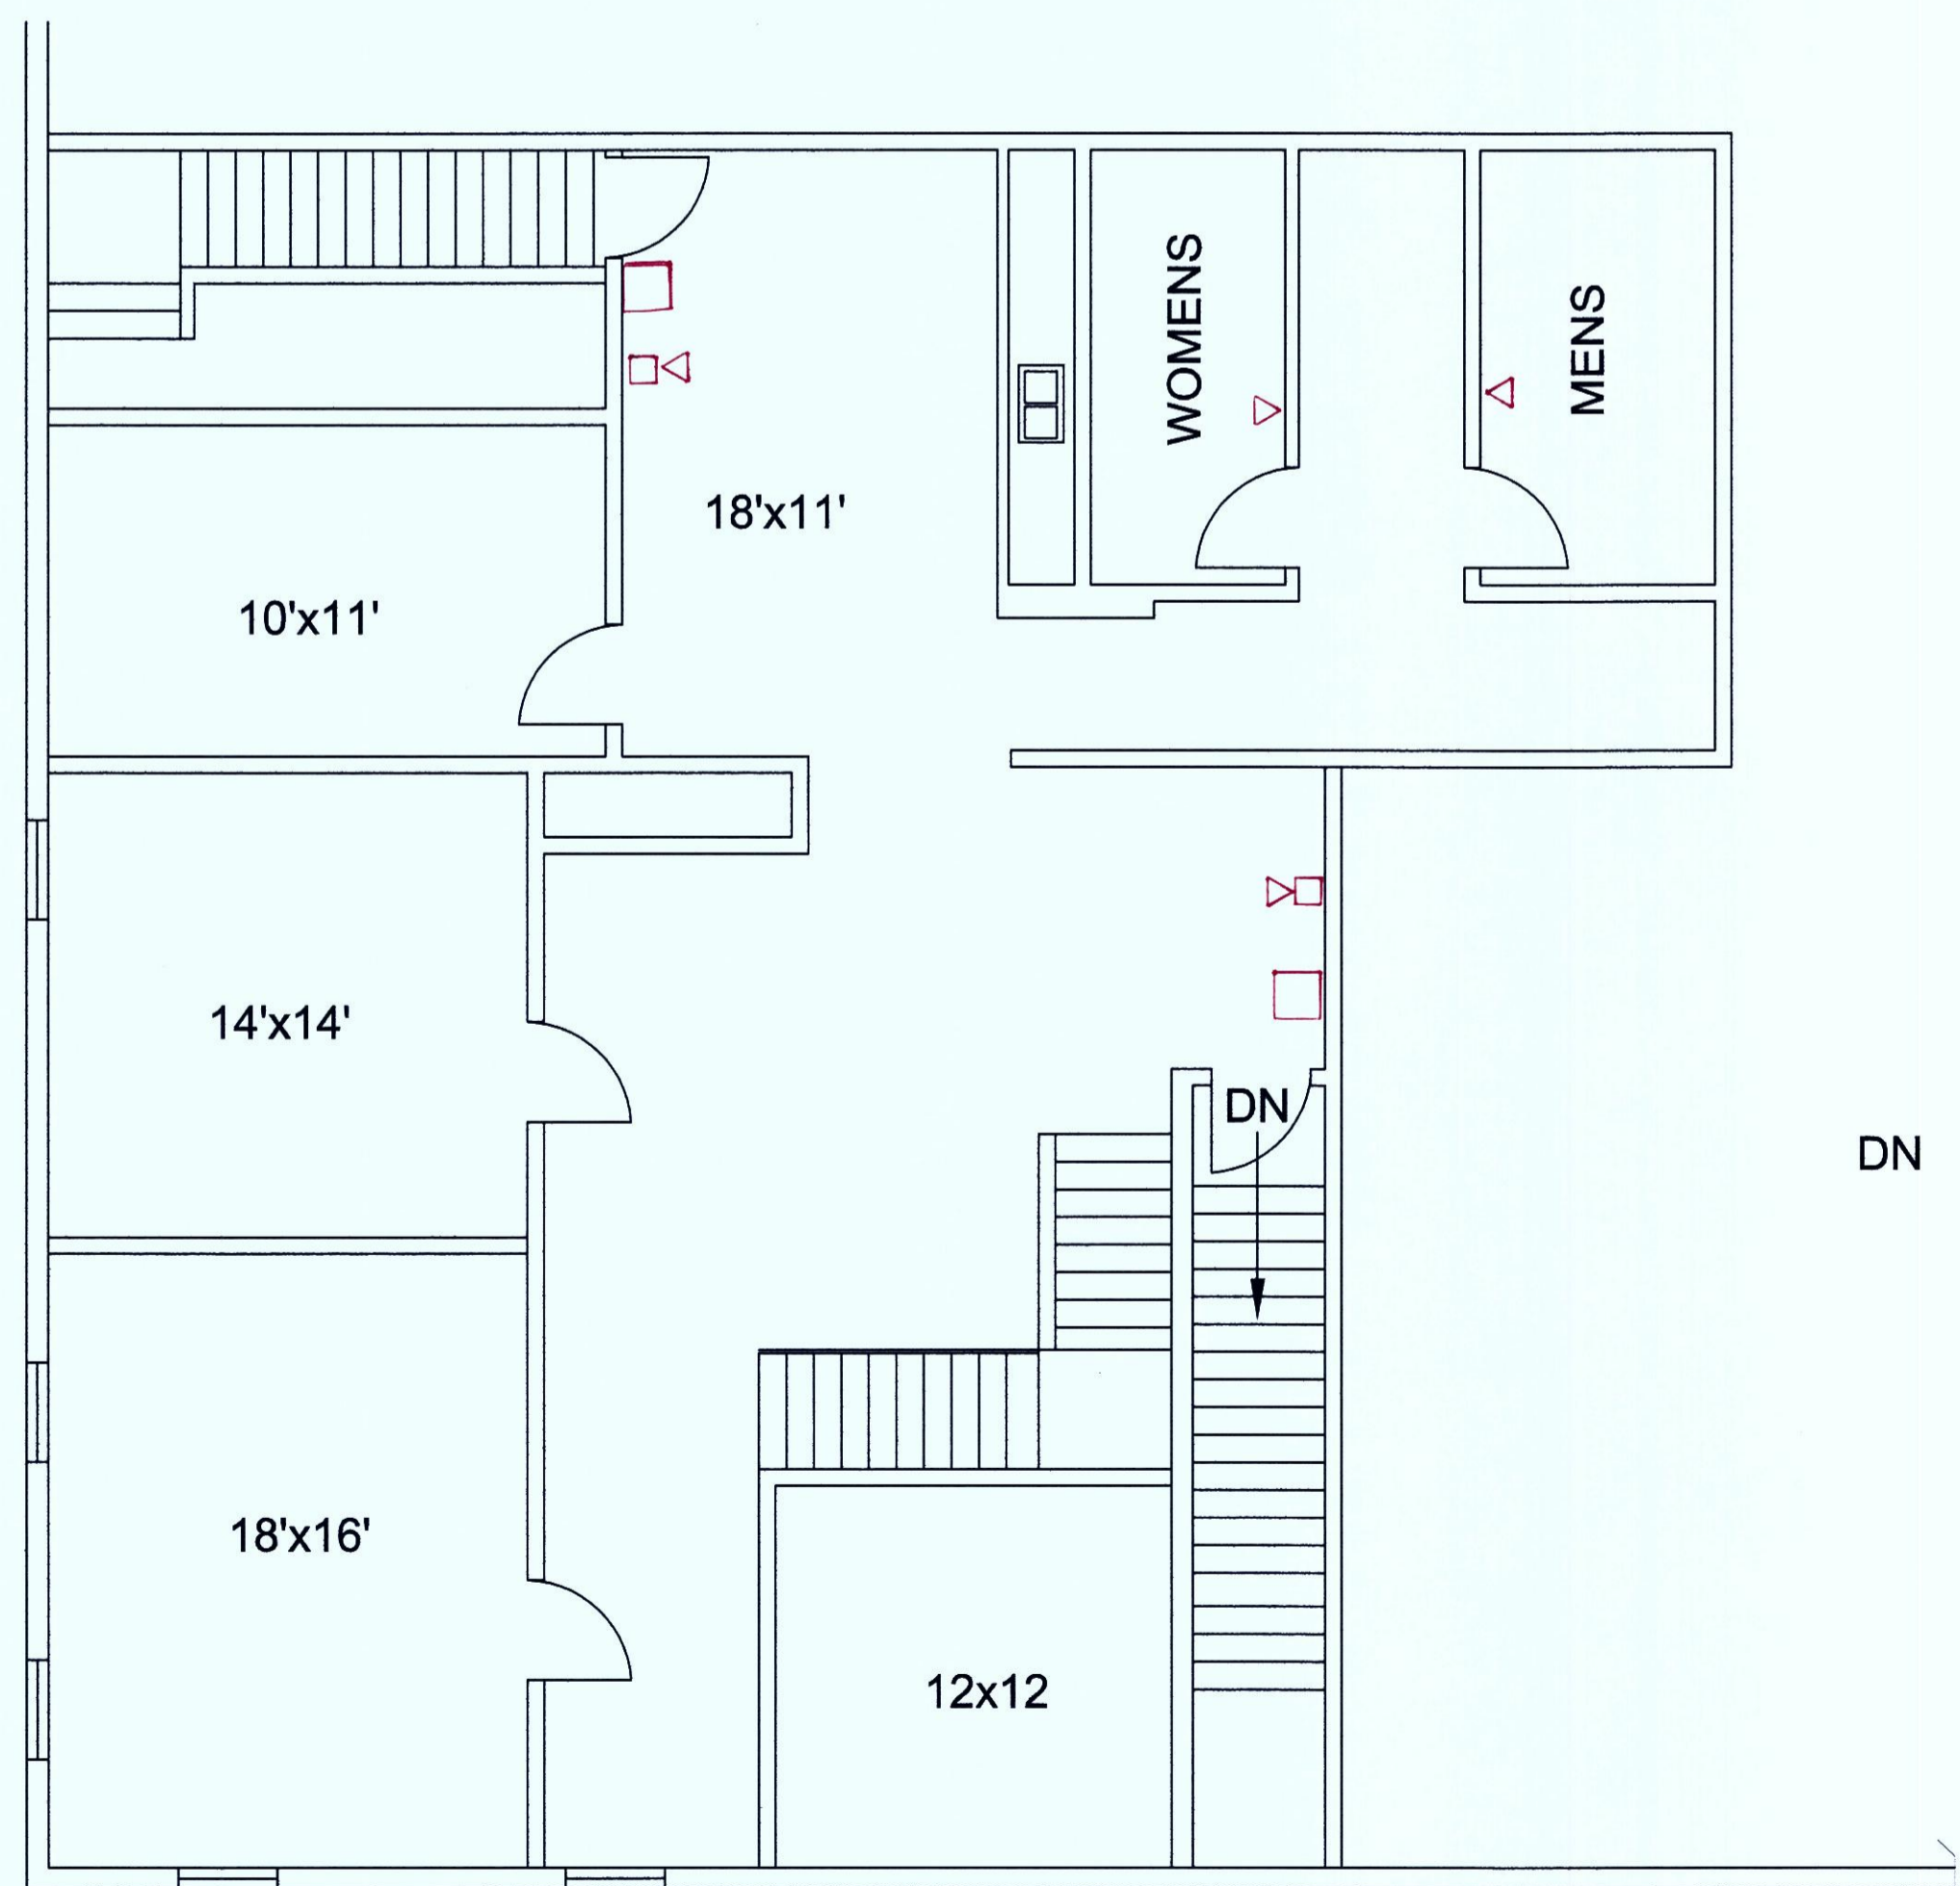

**2ND FLOOR**

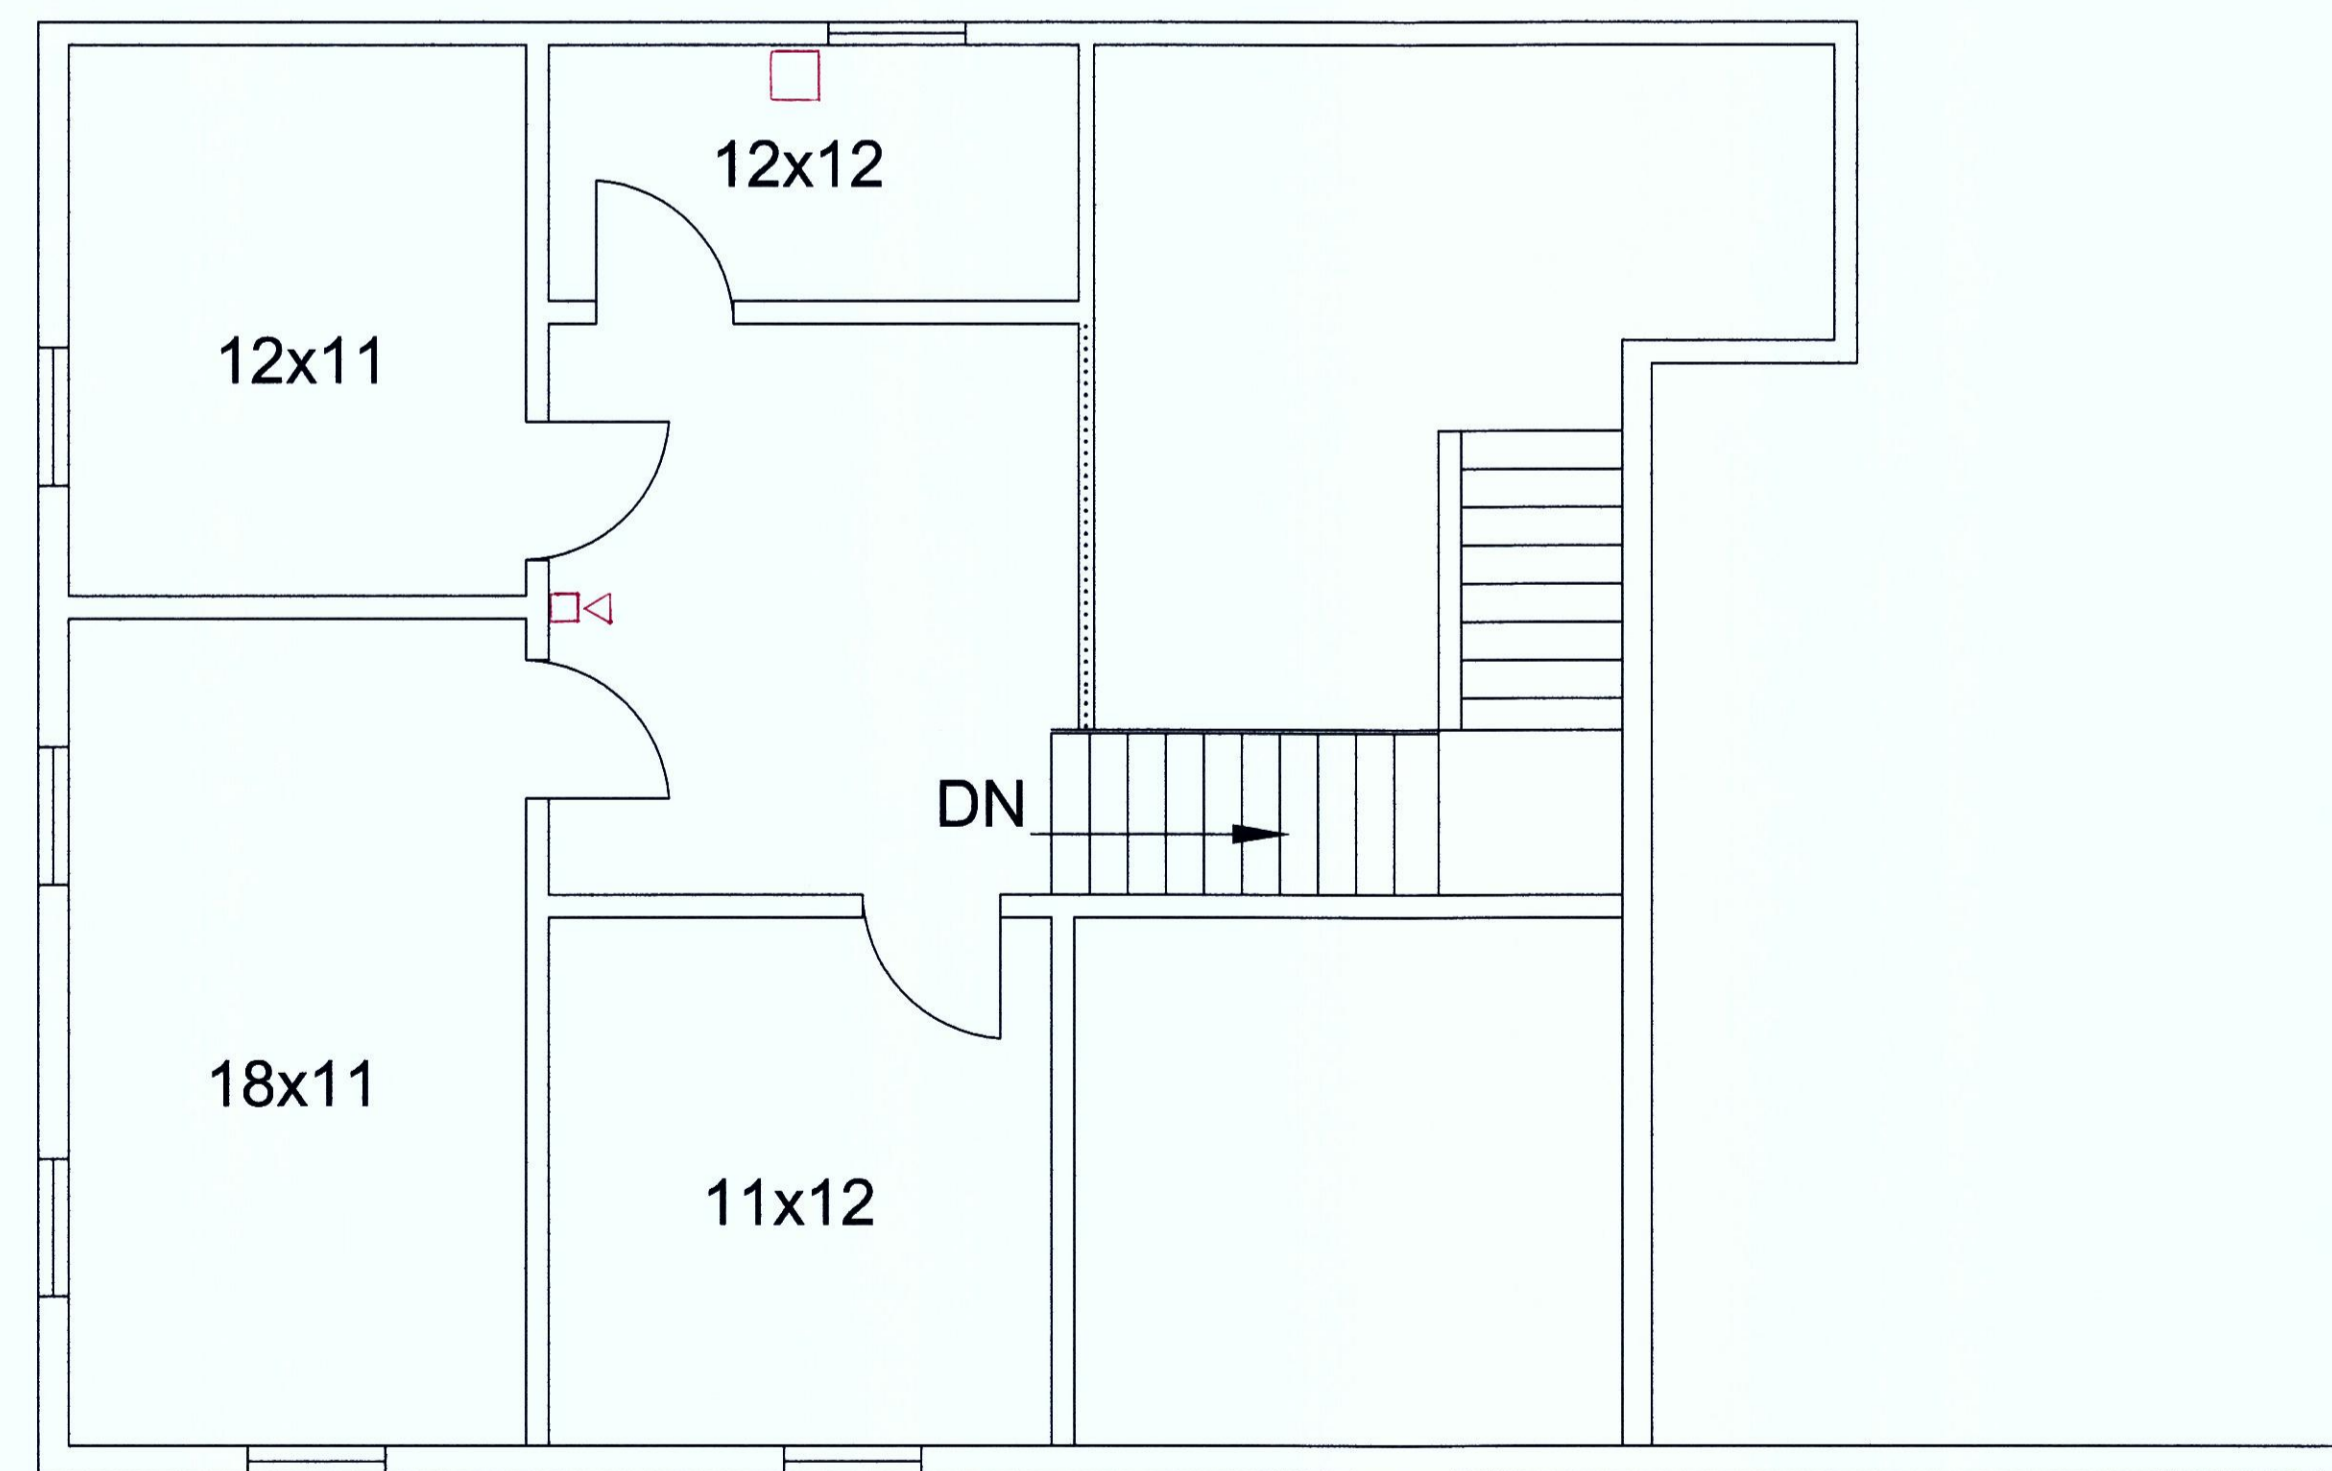

**3RD FLOOR**

- < horn strobe
- < strobe
- Pull Station
- Smoke detector
- ⬡ Fire Panel
- Ⓚ Knob box

2.
1.
REVS:
CODE:
TOWN: Portland
DATE: 06-21-14
SCALE: AS NOTED
DESIGNED: SSA
DRAWN: SSA
TITLE: BUILDING FLOOR PLANS
FILE:
SHEET: A-1