


SYSTEM OUTPUTS


CONTROL UNIT ACTIVATION

NOTIFICATION

SYSTEM INPUTS

		A	B	C	D	E	F	G	H	I	J	K	L	M	
1	MANUAL FIRE ALARM PULL STATION	●	●					●	●	●		●			1
2	AREA SMOKE DETECTOR	●	●					●	●	●		●			2
3	AREA HEAT DETECTOR	●	●					●	●	●		●			3
4	FIRE ALARM AC POWER FAILURE					●	●	●	●					●	4
5	FIRE ALARM SYSTEM LOW BATTERY					●	●	●	●					●	5
6	OPEN CIRCUIT					●	●	●	●					●	6
7	GROUND FAULT					●	●	●	●					●	7
8	NOTIFICATION APPLIANCE CIRCUIT SHORT					●	●	●	●					●	8
		A	B	C	D	E	F	G	H	I	J	K	L	M	

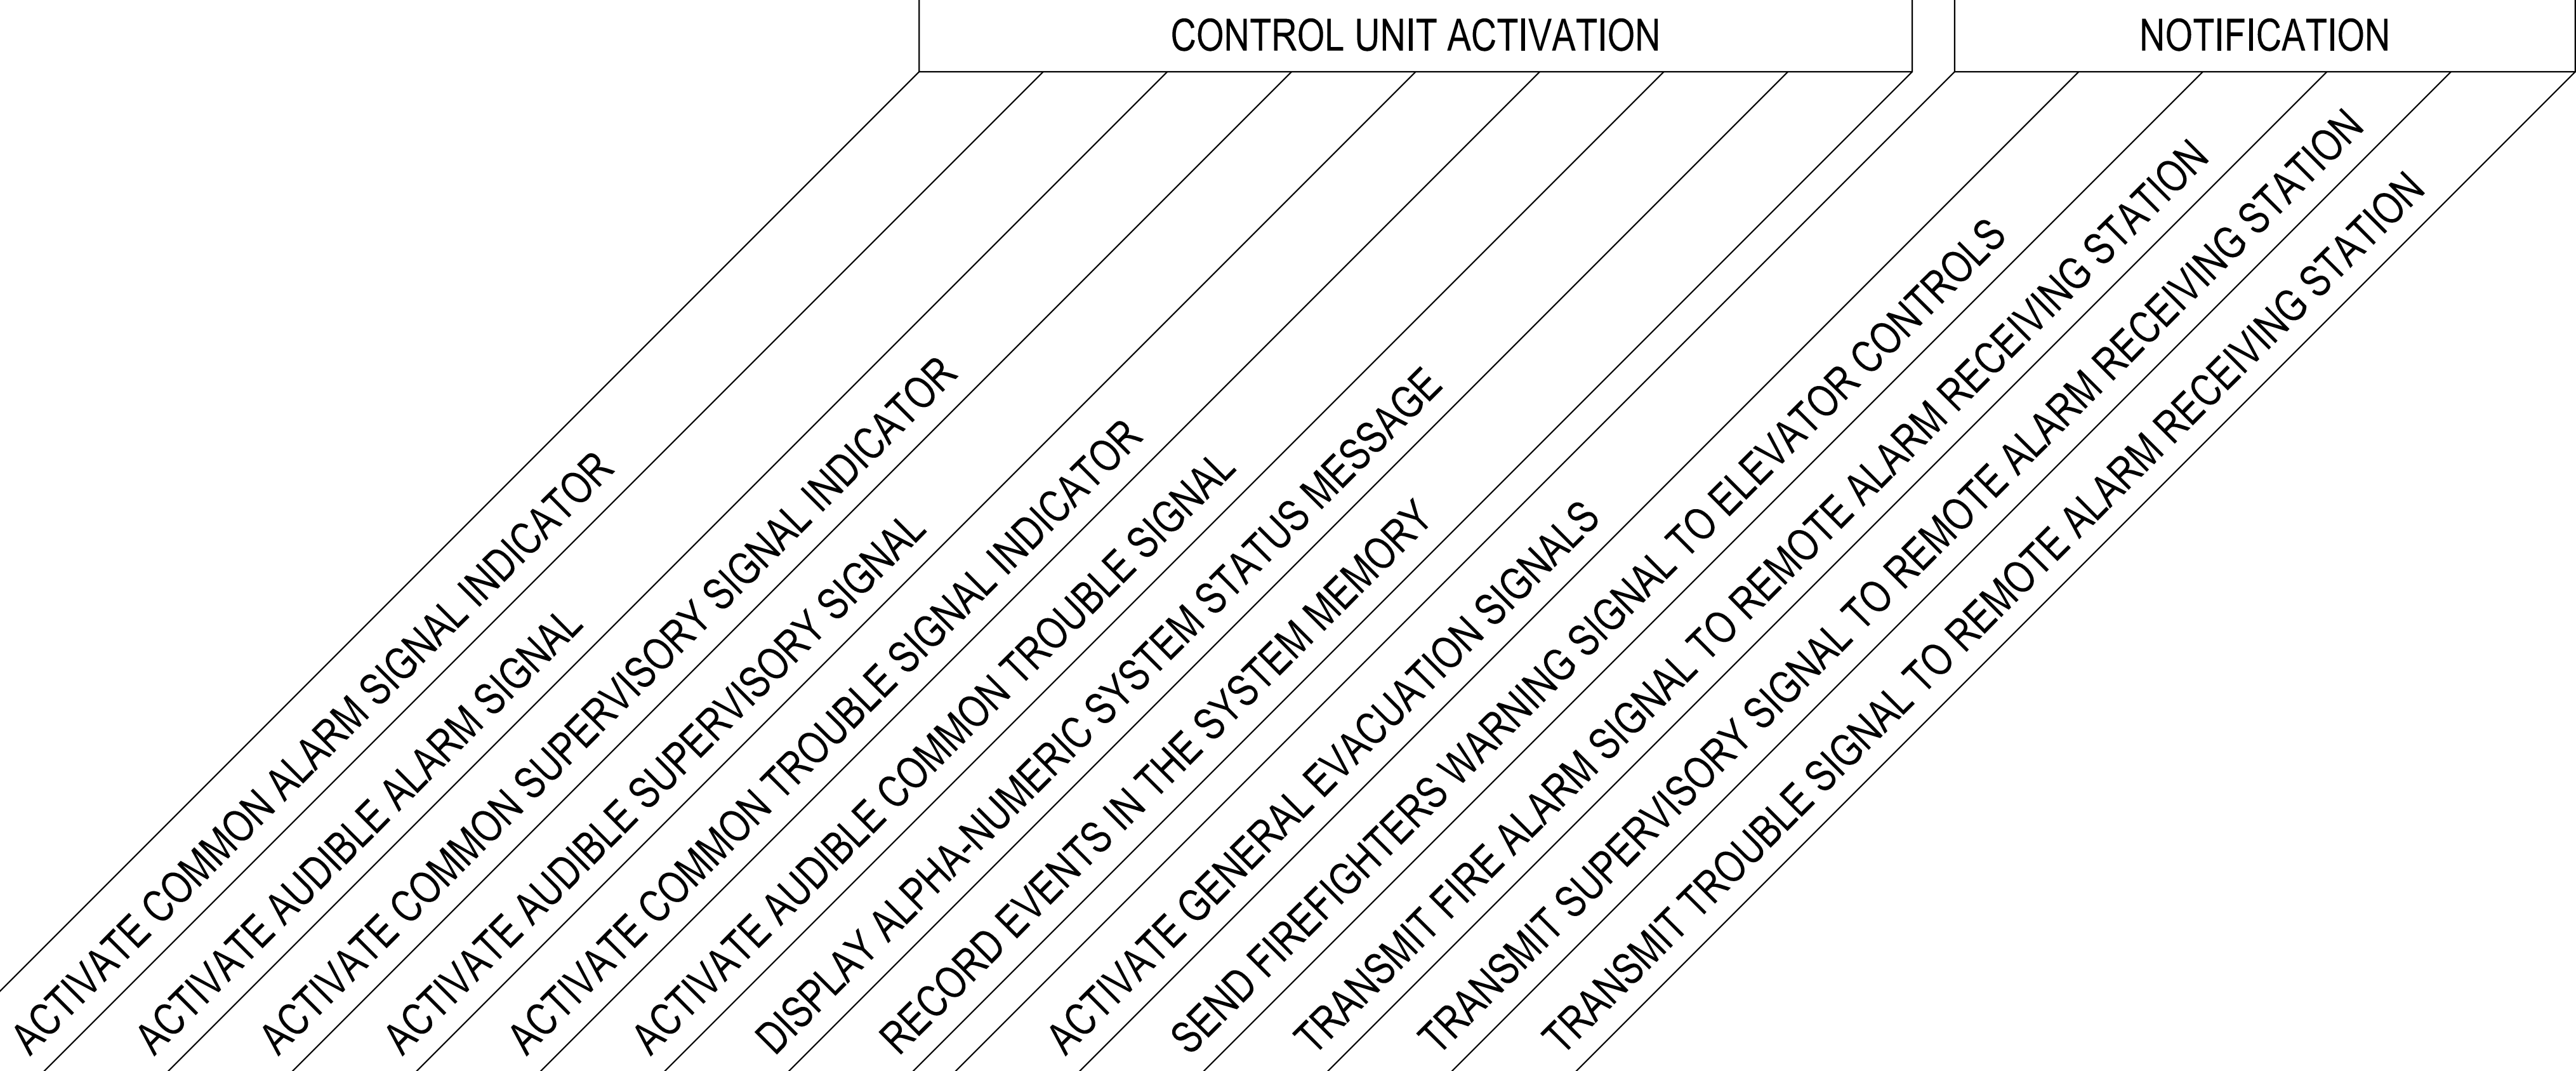

REVISION 0: SUBMITTAL		09/07/2016
FIRE ALARM MATRIX		
PROJECT NUMBER: 323986R1	SCALE: NONE	
PROJECT:	DRAWN BY: JRS	
MECA FIT-UP 380 CUMBERLAND AVE PORTLAND, MAINE 04101	CHECKED BY: DG	
SHEET:		TEK-01
		
2257 BROADWAY	SOUTH PORTLAND, MAINE	